



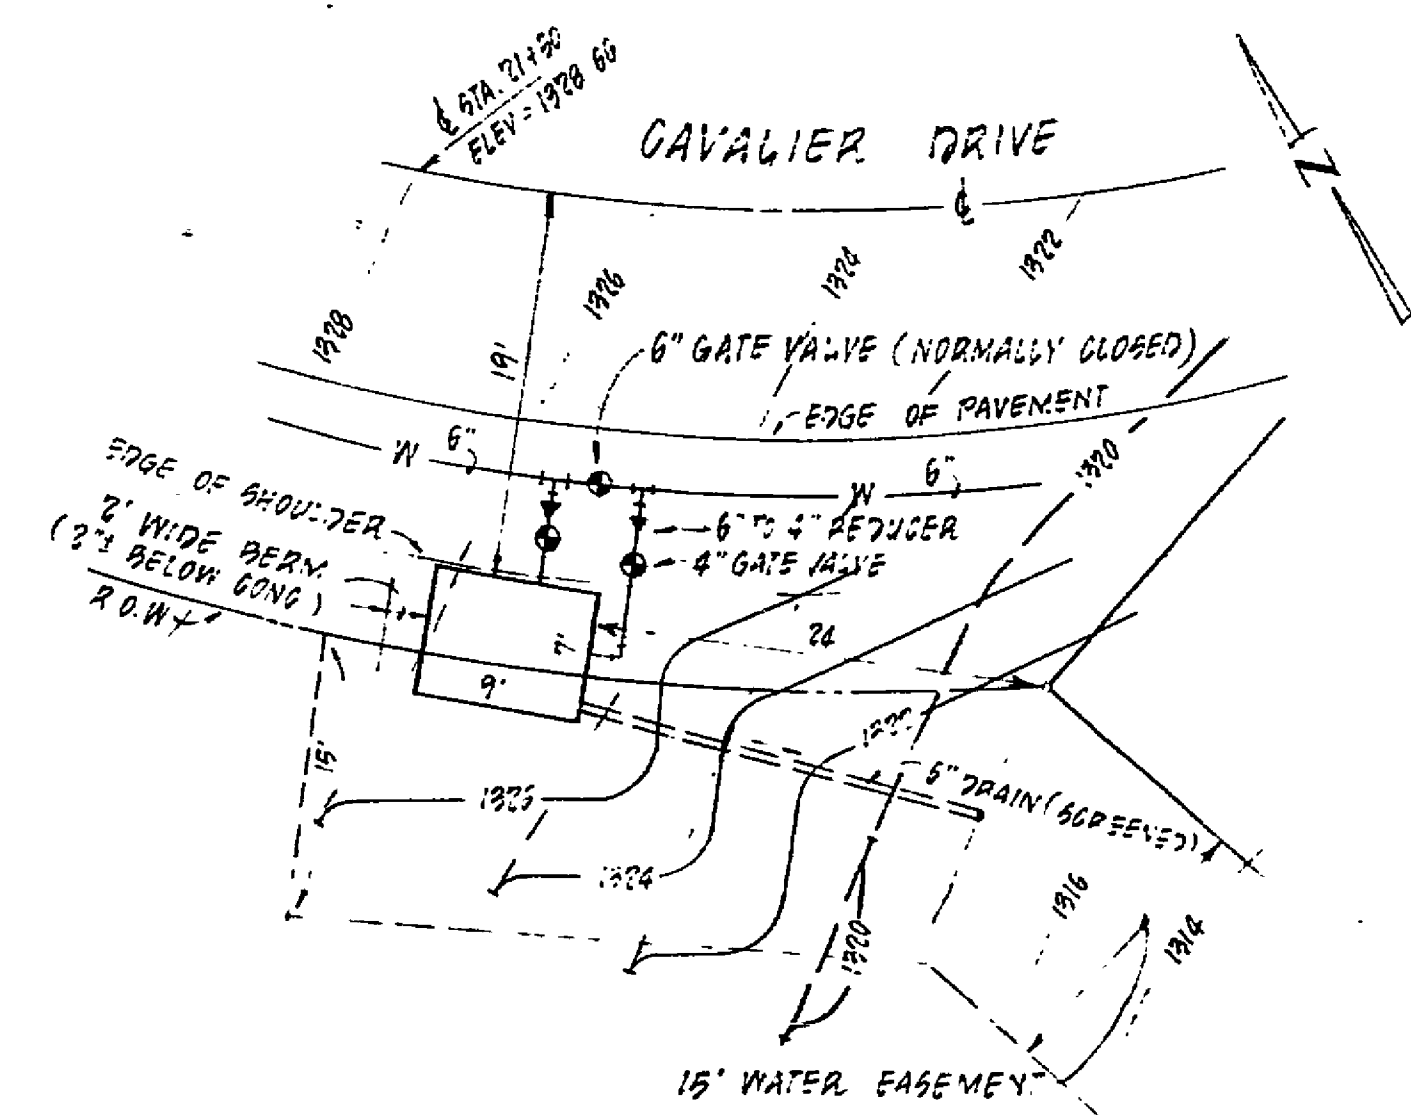


**SITE PLAN PUMP STATION**

SCALE: 1" = 10'

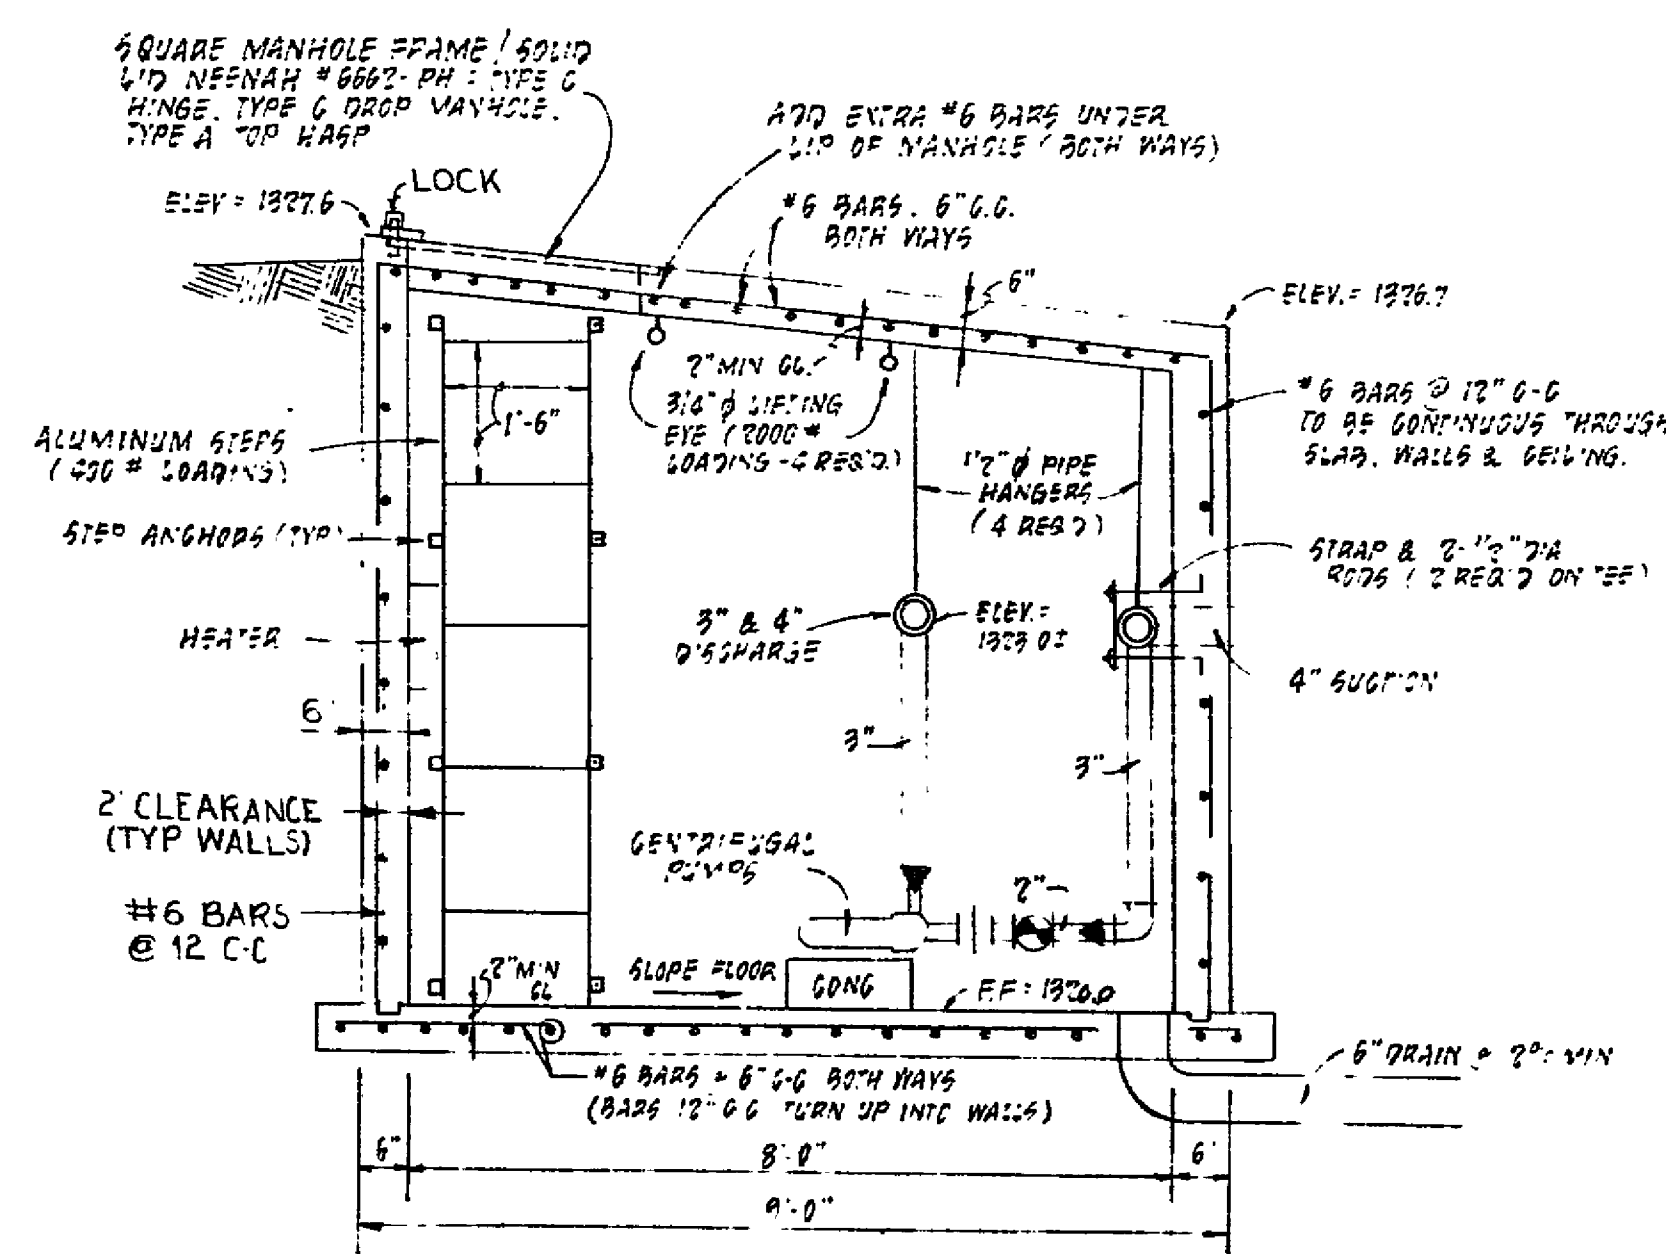


**SECTION A-A**

NO SCALE

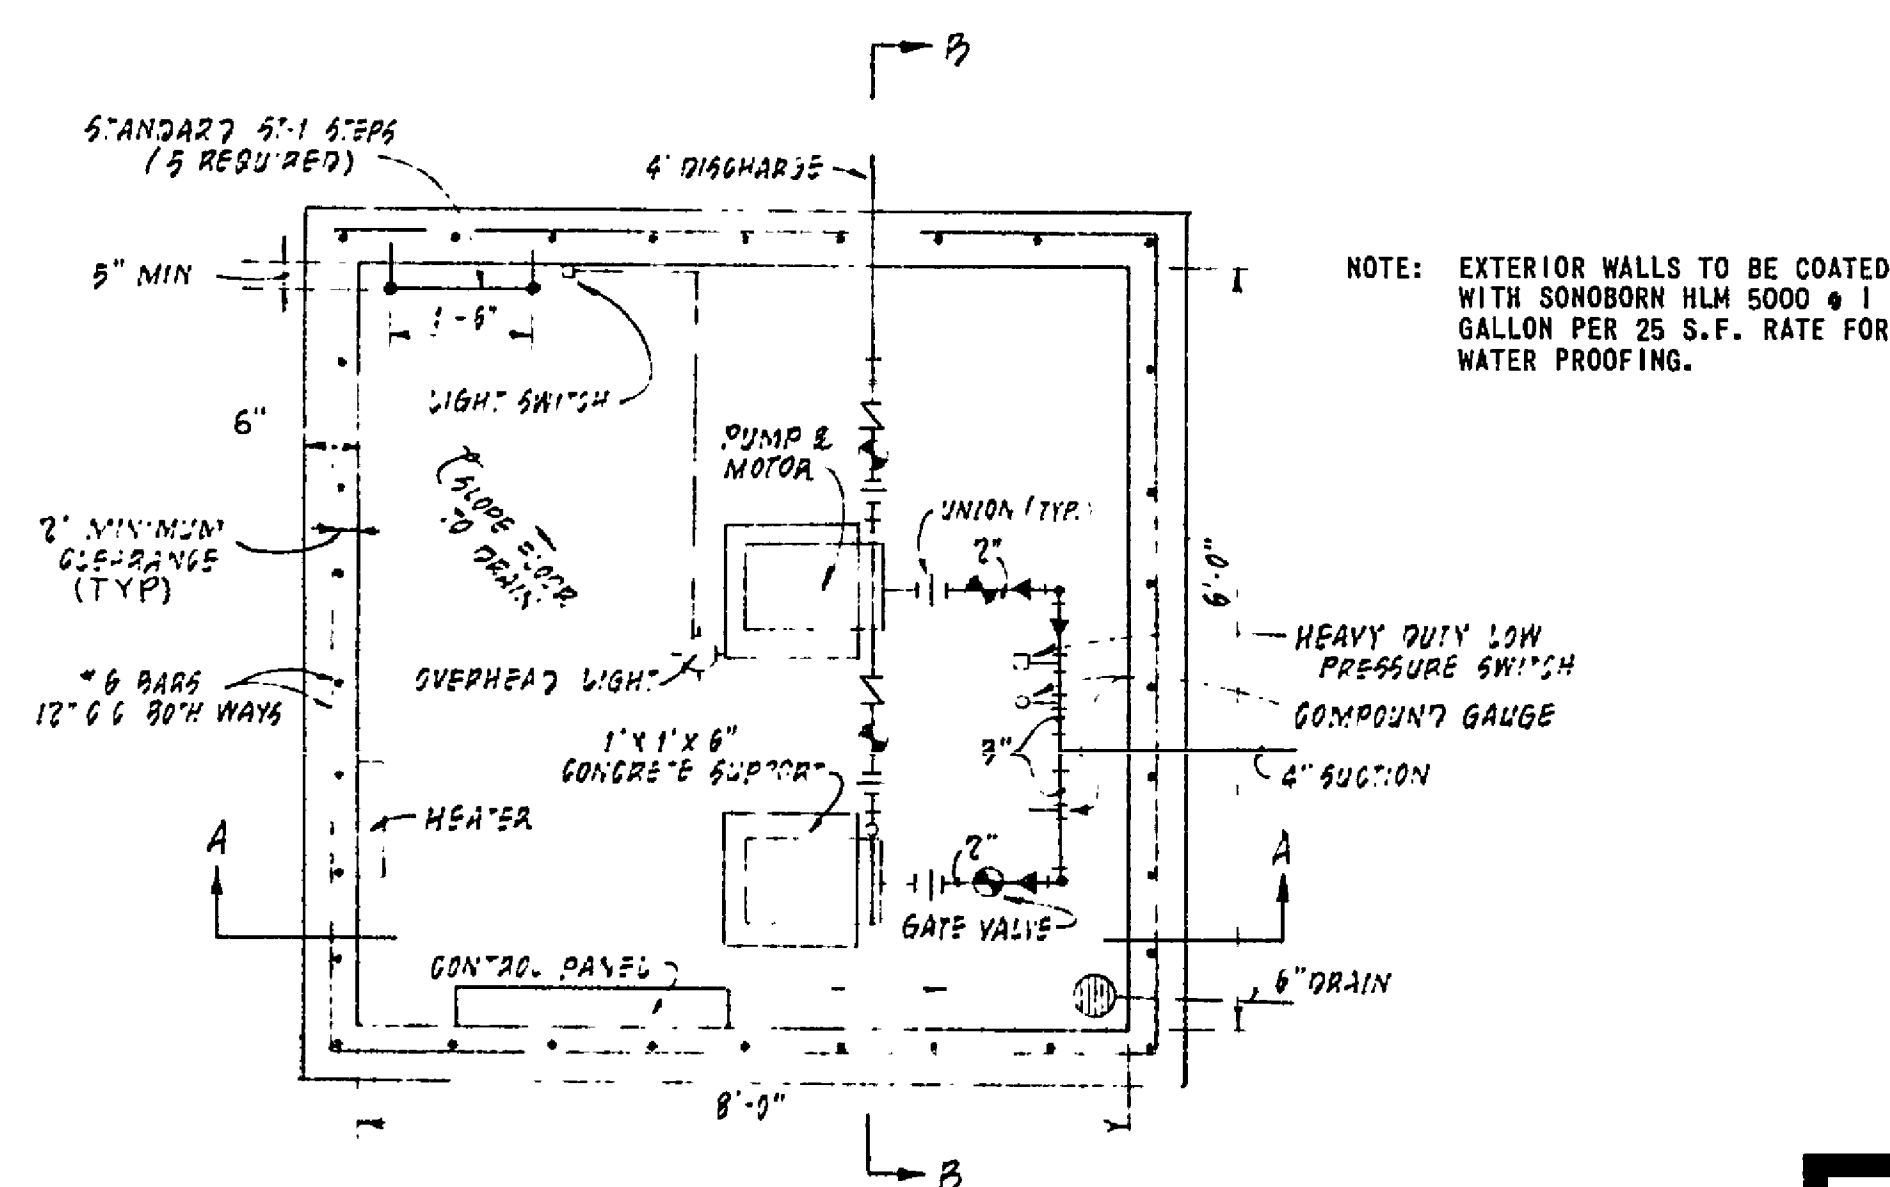


**PUMP STATION PLAN**

NO SCALE

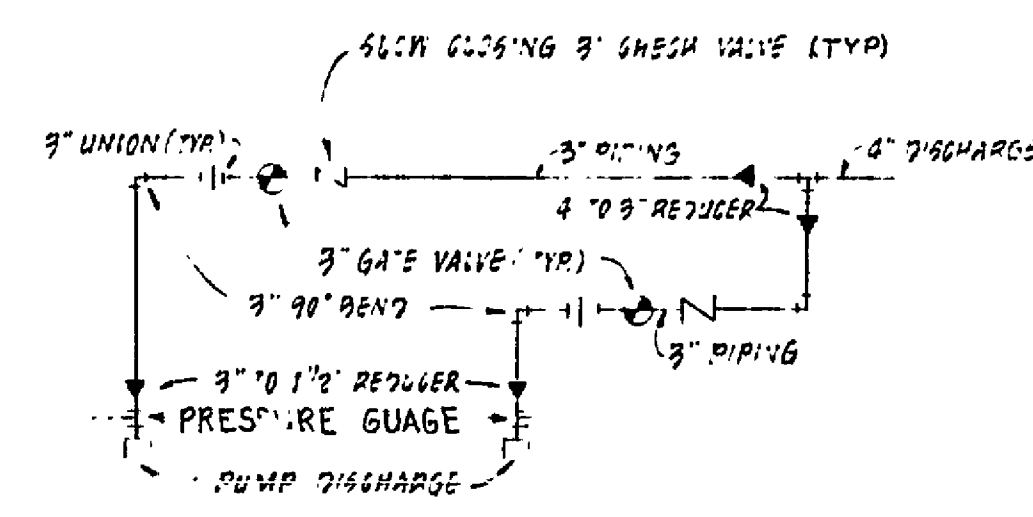


**SECTION B-B PIPING AT PUMPS**

NO SCALE

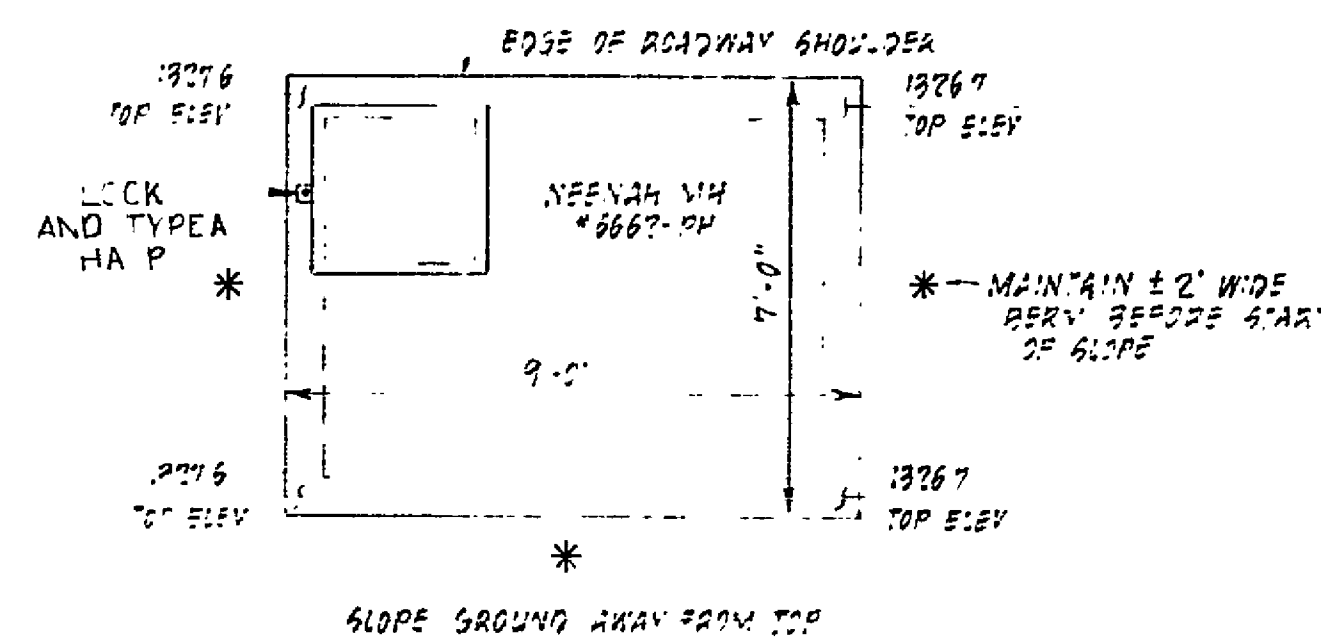


TOP

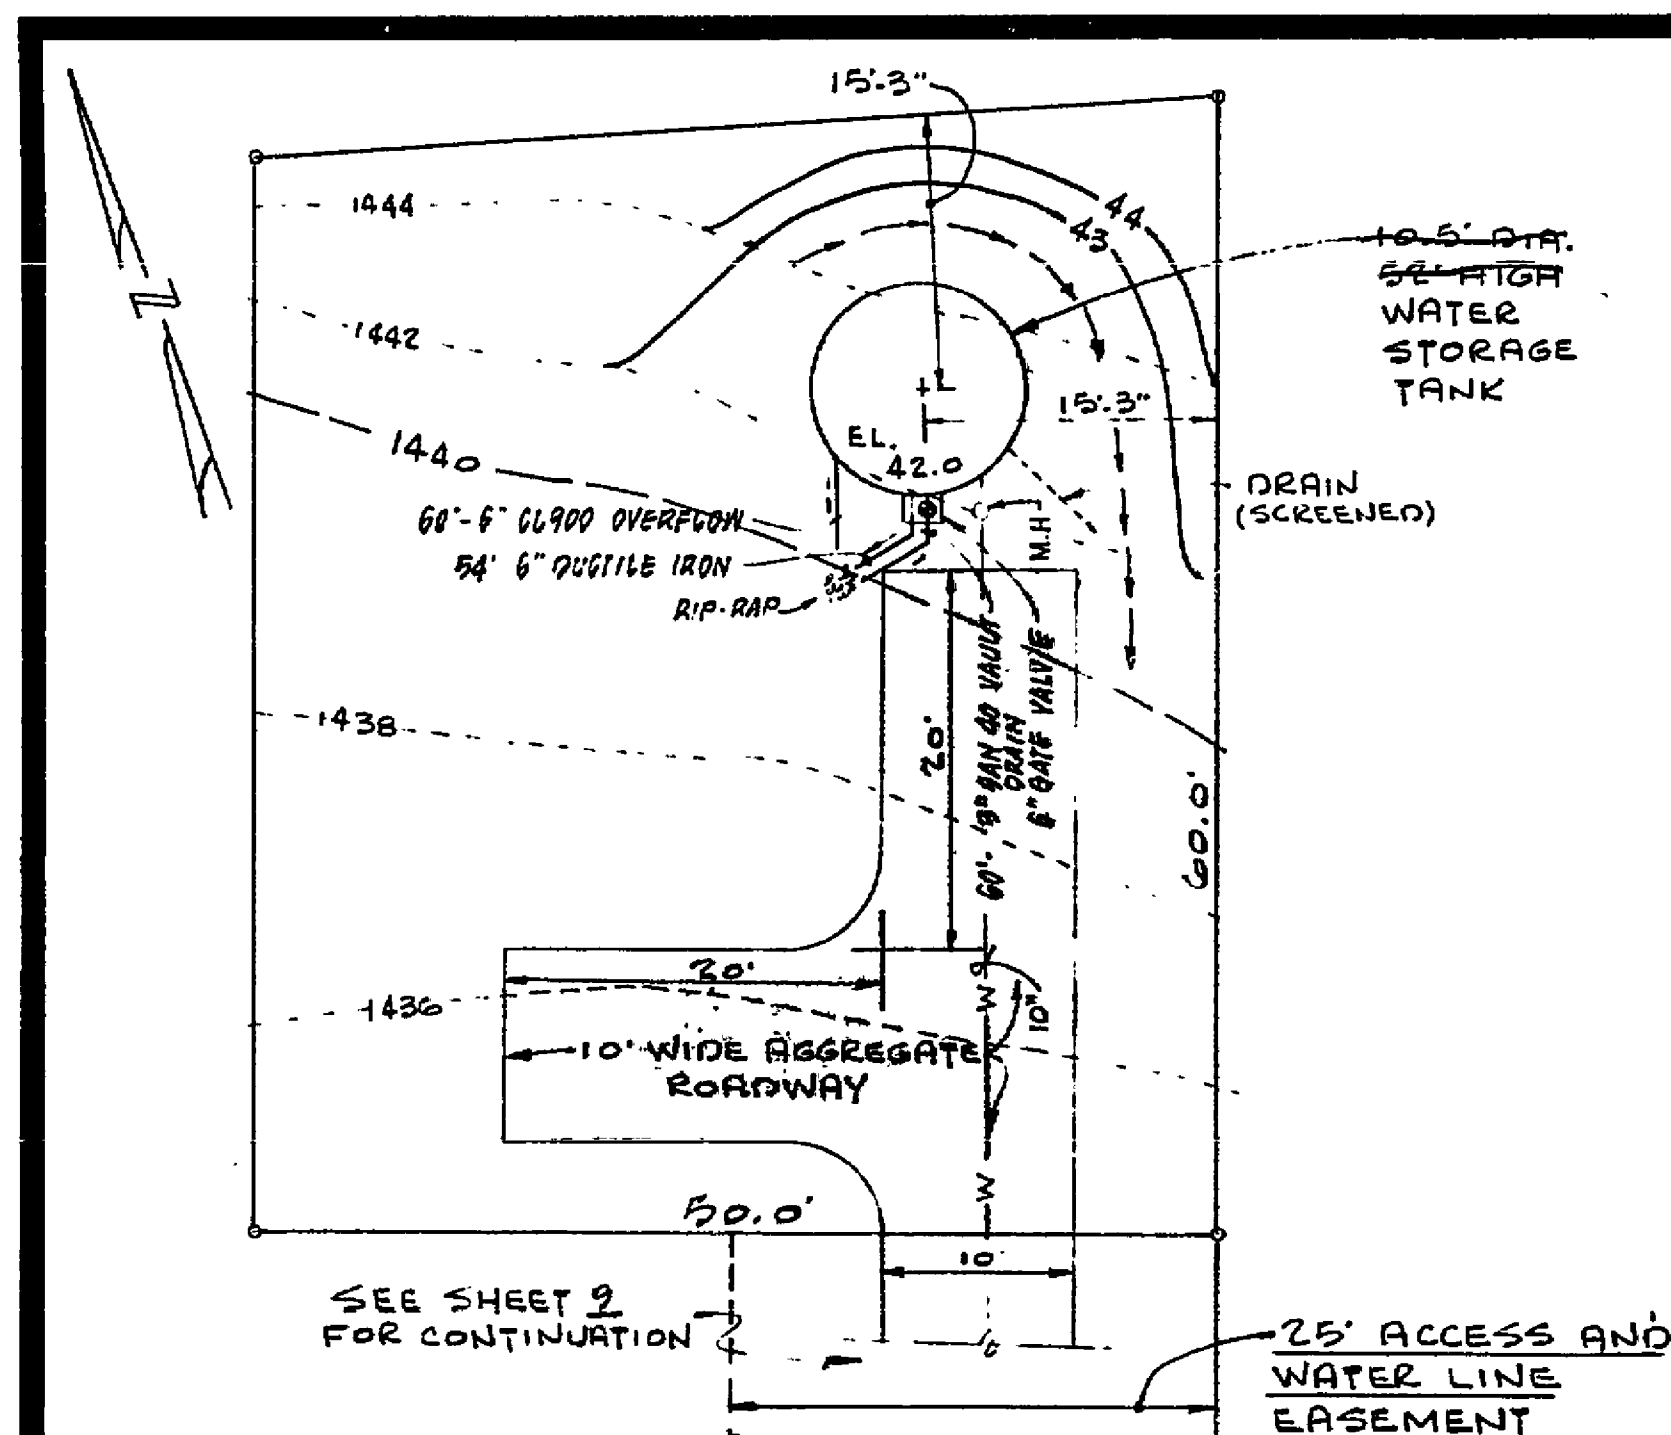


**TANK SITE PLAN**

NO SCALE

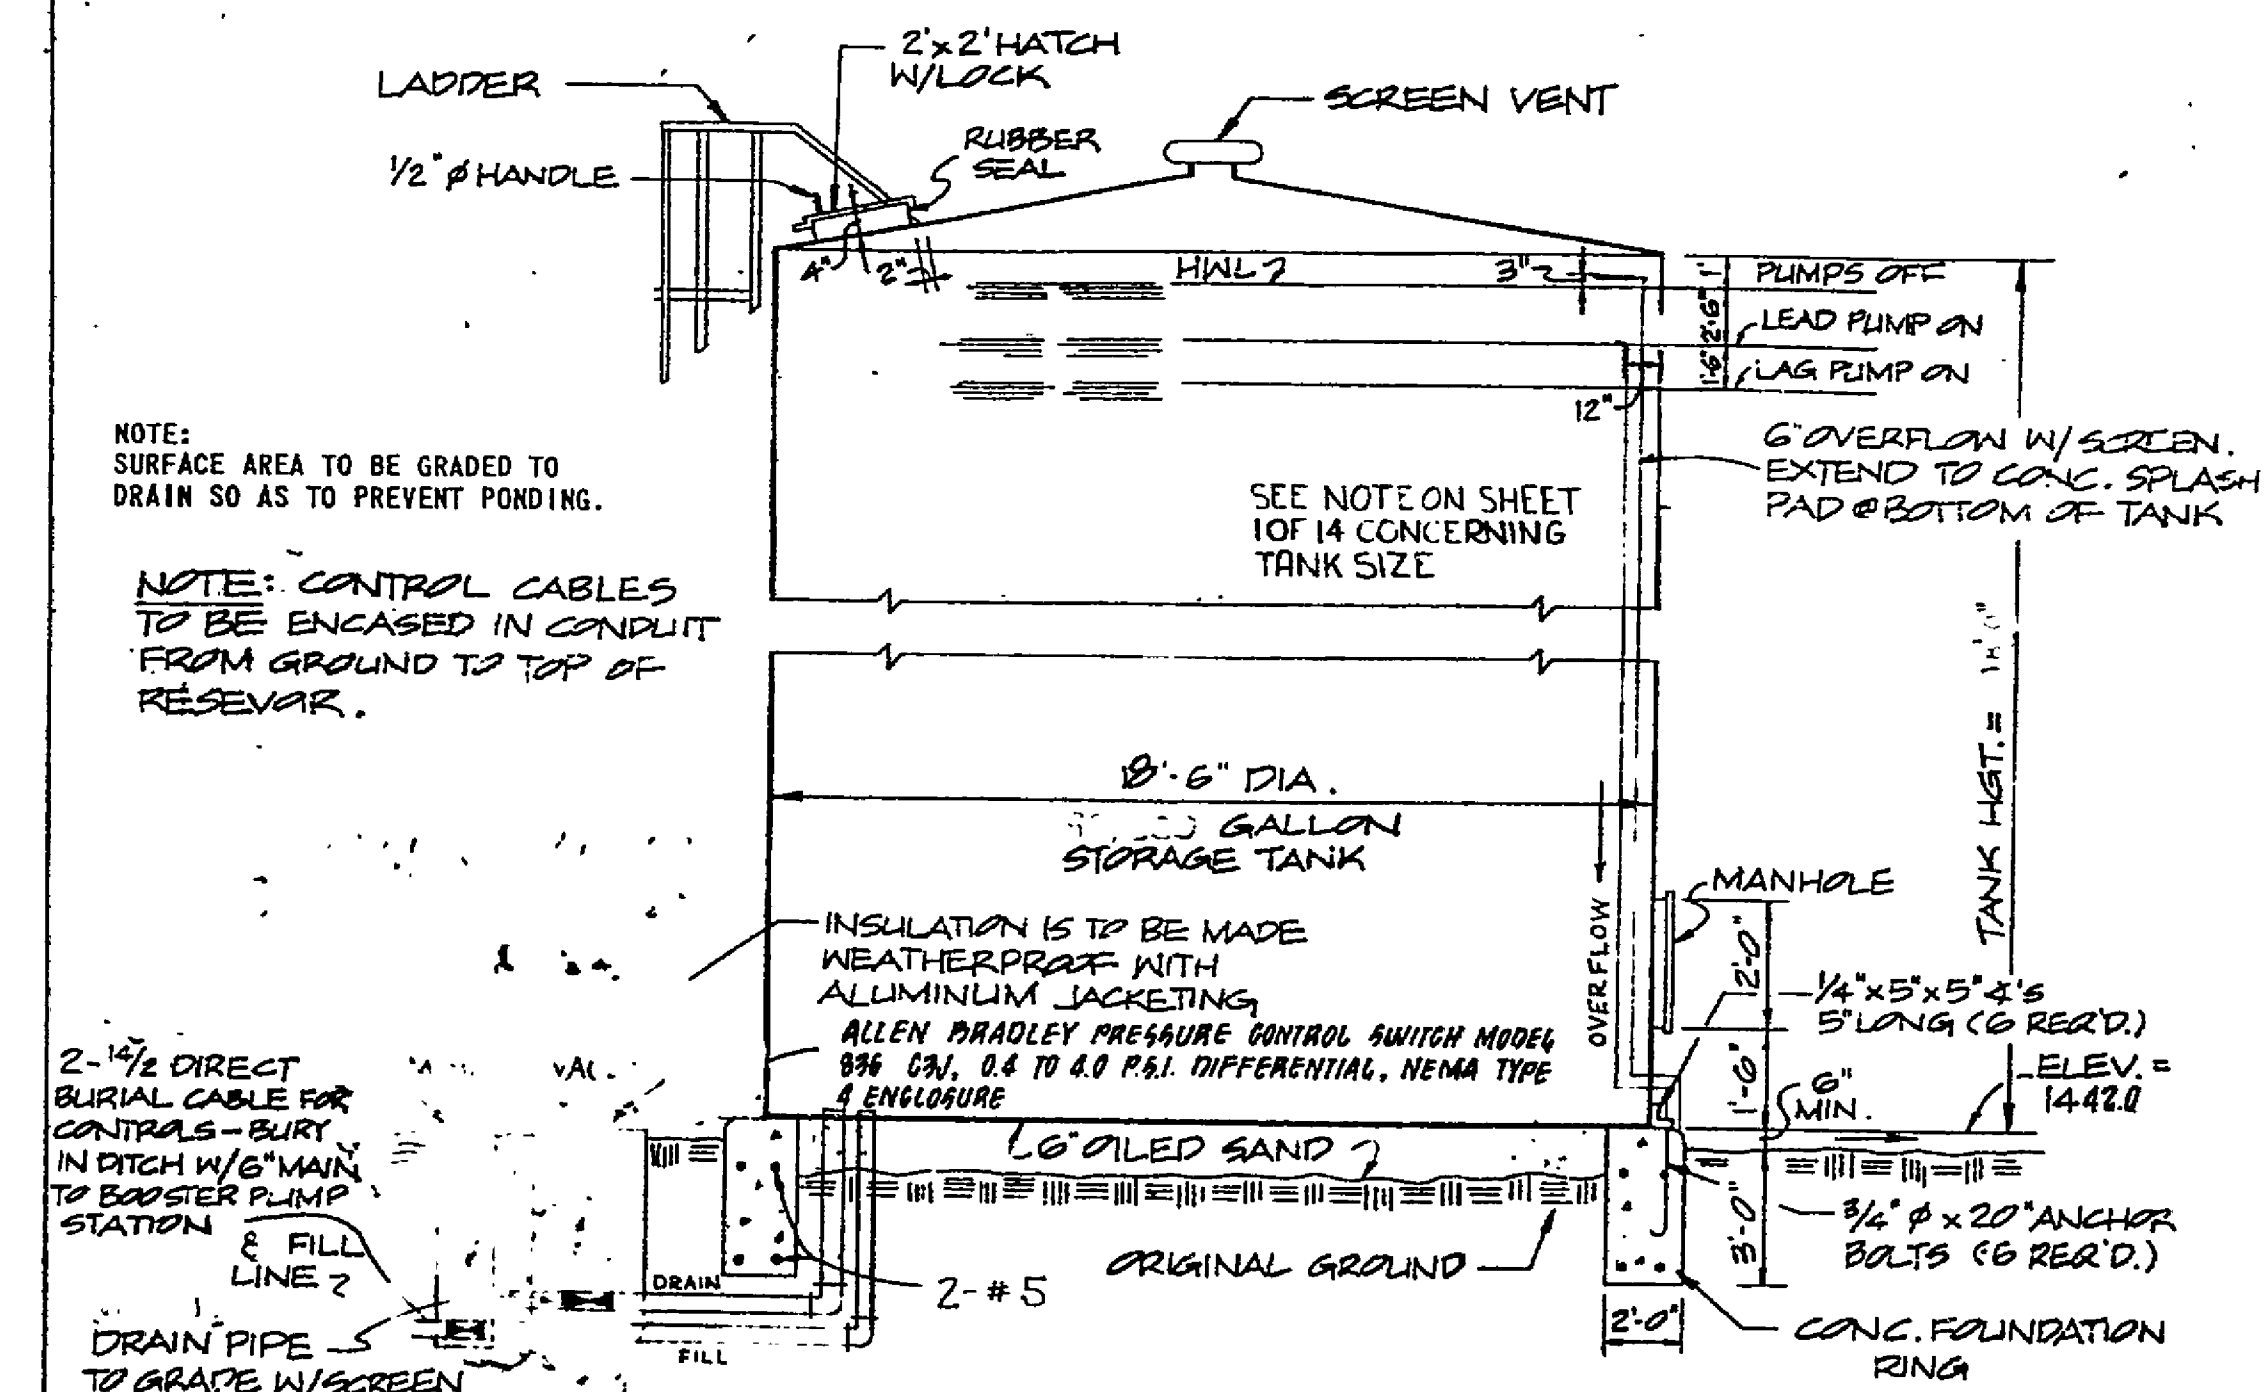


**ELEVATION**

NO SCALE

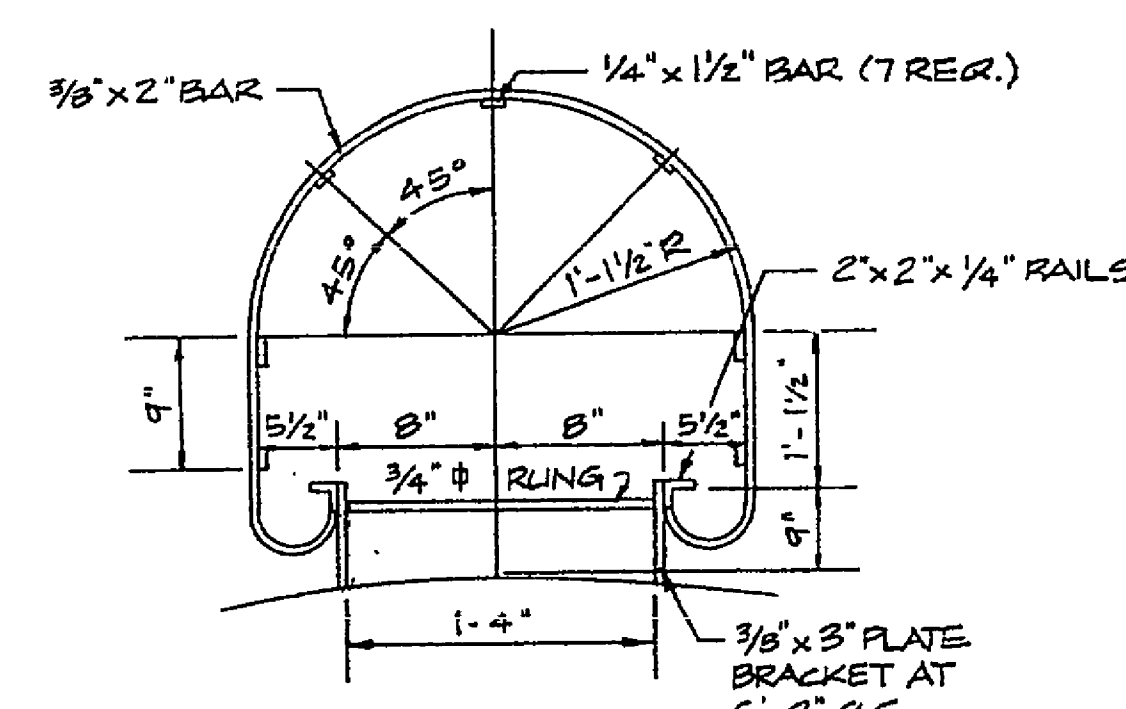


**OUTSIDE LADDER DETAIL**

NO SCALE

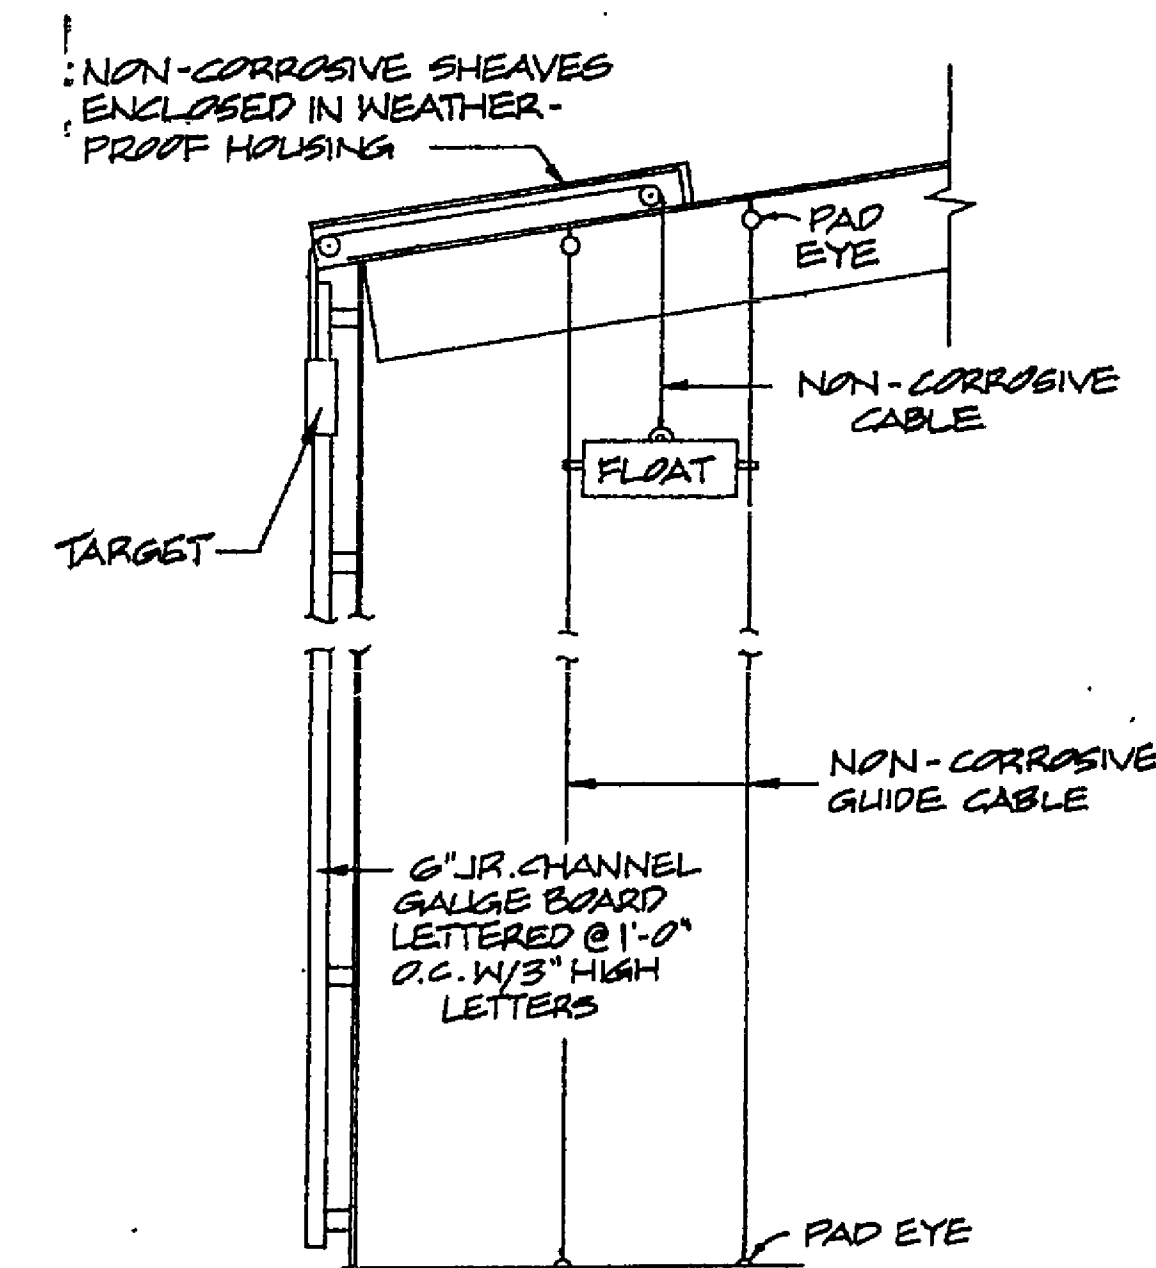


**INDICATOR GAUGE DETAIL**

NO SCALE

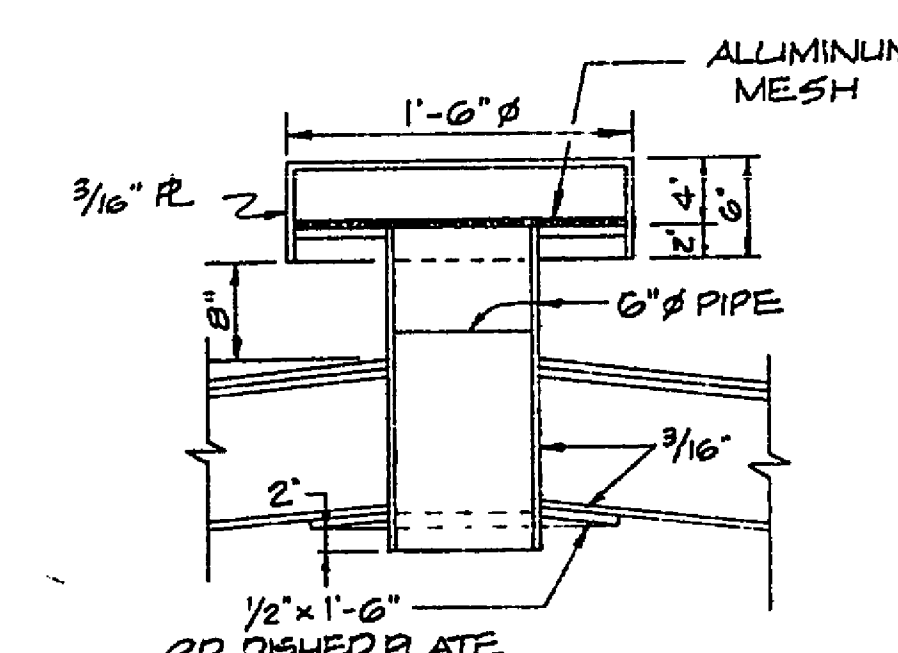

**VENT DETAIL**

NO SCALE

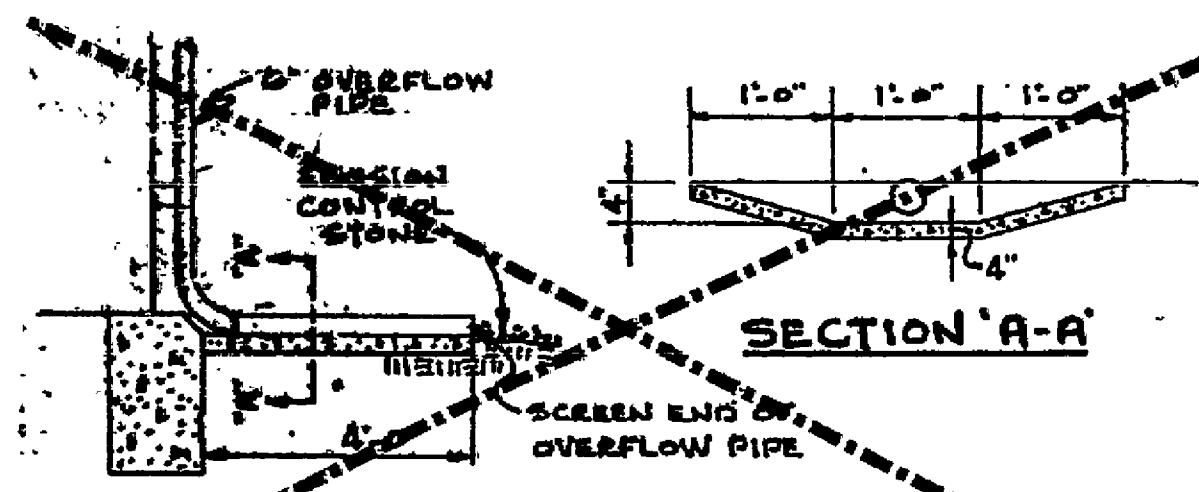

**SECTION A-A**

NO SCALE



**DETAIL: SPLASH PAD FOR OVERFLOW**

NO SCALE

**WATER DETAIL SHEET**

OF

SECTION No. 3

**"CANTERBURY PARK"**

CAVE SPRING MAGISTERIAL DISTRICT  
ROANOKE COUNTY, VIRGINIA

PROPERTY OF  
BOONE, BOONE & LOEB, INC.

SCALE: AS SHOWN DATE: 17 OCTOBER 1986  
30 JULY 1987 - "AS-BUILT" WATER  
10 NOV. 1988 - "AS-BUILT" WATER

SUFORD T. LUMSDEN & ASSOCIATES, P.C.  
ENGINEERS - SURVEYORS  
ROANOKE, VIRGINIA

\* 78-465 BBL

RC-1244 SHEET # 5 OF 14