


GENERAL UTILITIES NOTES:

1. CONTRACTOR SHALL MAINTAIN TWO-WAY TRAFFIC WHEN PRACTICAL WHEN WORKING WITHIN EXISTING STREETS. THE CONTRACTOR SHALL MAINTAIN EXISTING TRAFFIC PATTERNS, AND TURNISH FLAGMEN TO DIRECT TRAFFIC IN ACCORDANCE WITH THE WORK AREA TRAFFIC CONTROL HANDBOOK.
2. ALL PAVEMENT, CURBS, AND GUTTERS DISTURBED FOR INSTALLATION OF UTILITIES SHALL BE RESTORED TO ORIGINAL OR BETTER. THE CONTRACTOR SHALL MAINTAIN EXISTING TRAFFIC PATTERNS, AND TURNISH FLAGMEN TO DIRECT TRAFFIC IN ACCORDANCE WITH THE WORK AREA TRAFFIC CONTROL HANDBOOK.
3. THE CITY OF ROANOKE'S UTILITY LINE SERVICES WILL MAKE THE CONNECTION TO THE SEWER MAIN FOLLOWING EXCAVATION AND TAP FEE WILL BE CHARGED TO SCHEDULE THE TAP OF THE SEWER MAIN. THE CITY OF ROANOKE'S UTILITY LINE SERVICES AT THE MANHOLE TAP IS NEEDED. SEWER FEES SHOULD BE PAID AT LEAST ONE WEEK PRIOR TO THE DATE SEWER HOOKUP IS NEEDED.
4. THE WATER CONNECTION AND WATER TAPS WILL BE DONE BY THE CITY OF ROANOKE. THE CONTRACTOR SHALL MAINTAIN EXISTING TRAFFIC PATTERNS, AND TURNISH FLAGMEN TO DIRECT TRAFFIC IN ACCORDANCE WITH THE WORK AREA TRAFFIC CONTROL HANDBOOK.
5. CONTRACTOR SHALL MAINTAIN EXISTING TRAFFIC PATTERNS, AND TURNISH FLAGMEN TO DIRECT TRAFFIC IN ACCORDANCE WITH THE WORK AREA TRAFFIC CONTROL HANDBOOK.
6. CONTRACTOR SHALL CLEAN OUT EXISTING STORM LINE.
7. COORDINATE ACTUAL LOCATION OF 6" DIP FIRE SERVICE LINE WITH SPANNER CONTRACTOR.

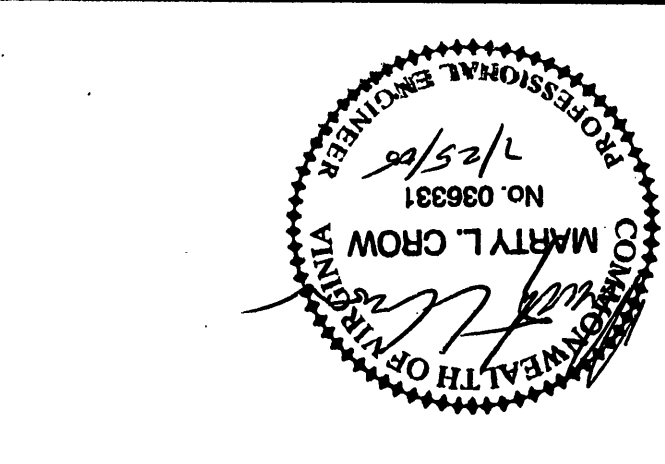

SEALS

CONSULTANT
HELMLUTH, OBATA + KASSABAUM, INC.
St. Louis, Missouri 63102 USA
TEL: (314) 436-1000 FAX: (314) 436-1001
WWW.HOK.COM

CONSULTANT
CARLION
Health System
CMC CONSOLIDATION
CARLION ROANOKE MEMORIAL HOSPITAL
ROANOKE, VIRGINIA
TEL: (804) 857-2100 FAX: (804) 857-2101
WWW.HSM.COM


ARCHITECTS
HSM
ENGINEERS
PLANNERS
HAYES, SEAY, MATTERN & MATTERN, INC.
ROANOKE, VA 24001
1315 FRANKLIN ROAD
TEL: (804) 857-2100 FAX: (804) 857-2101
WWW.HSM.COM

REV	DATE	DESCRIPTION
1	10/11/04	CITY COMMENTS 7/28/04
2	10/17/04	VALUE ENGINEERING
3	12/03/04	PHASE II APPROVAL SUBMITTAL
4	2/19/05	CITY APPROVED - INCLUDES S101-S115
5	08/24/05	OWNER REVISIONS
6	08/24/05	OWNER REVISIONS
7	07/25/05	S1155 REVISED PHASE II SITE


COMMIT NO: 40044A
ISSUE DATE: JUL 09, 2004
DESIGNED BY: TJS
CHECKED BY: MJC
SUBMITTED BY: BJC
© HAYES, SEAY, MATTERN & MATTERN, INC., 2005. ALL RIGHTS RESERVED.

CIVIL
UTILITY PLAN
CU105

GRAPHIC SCALES
1"=10'
0' 10' 20'

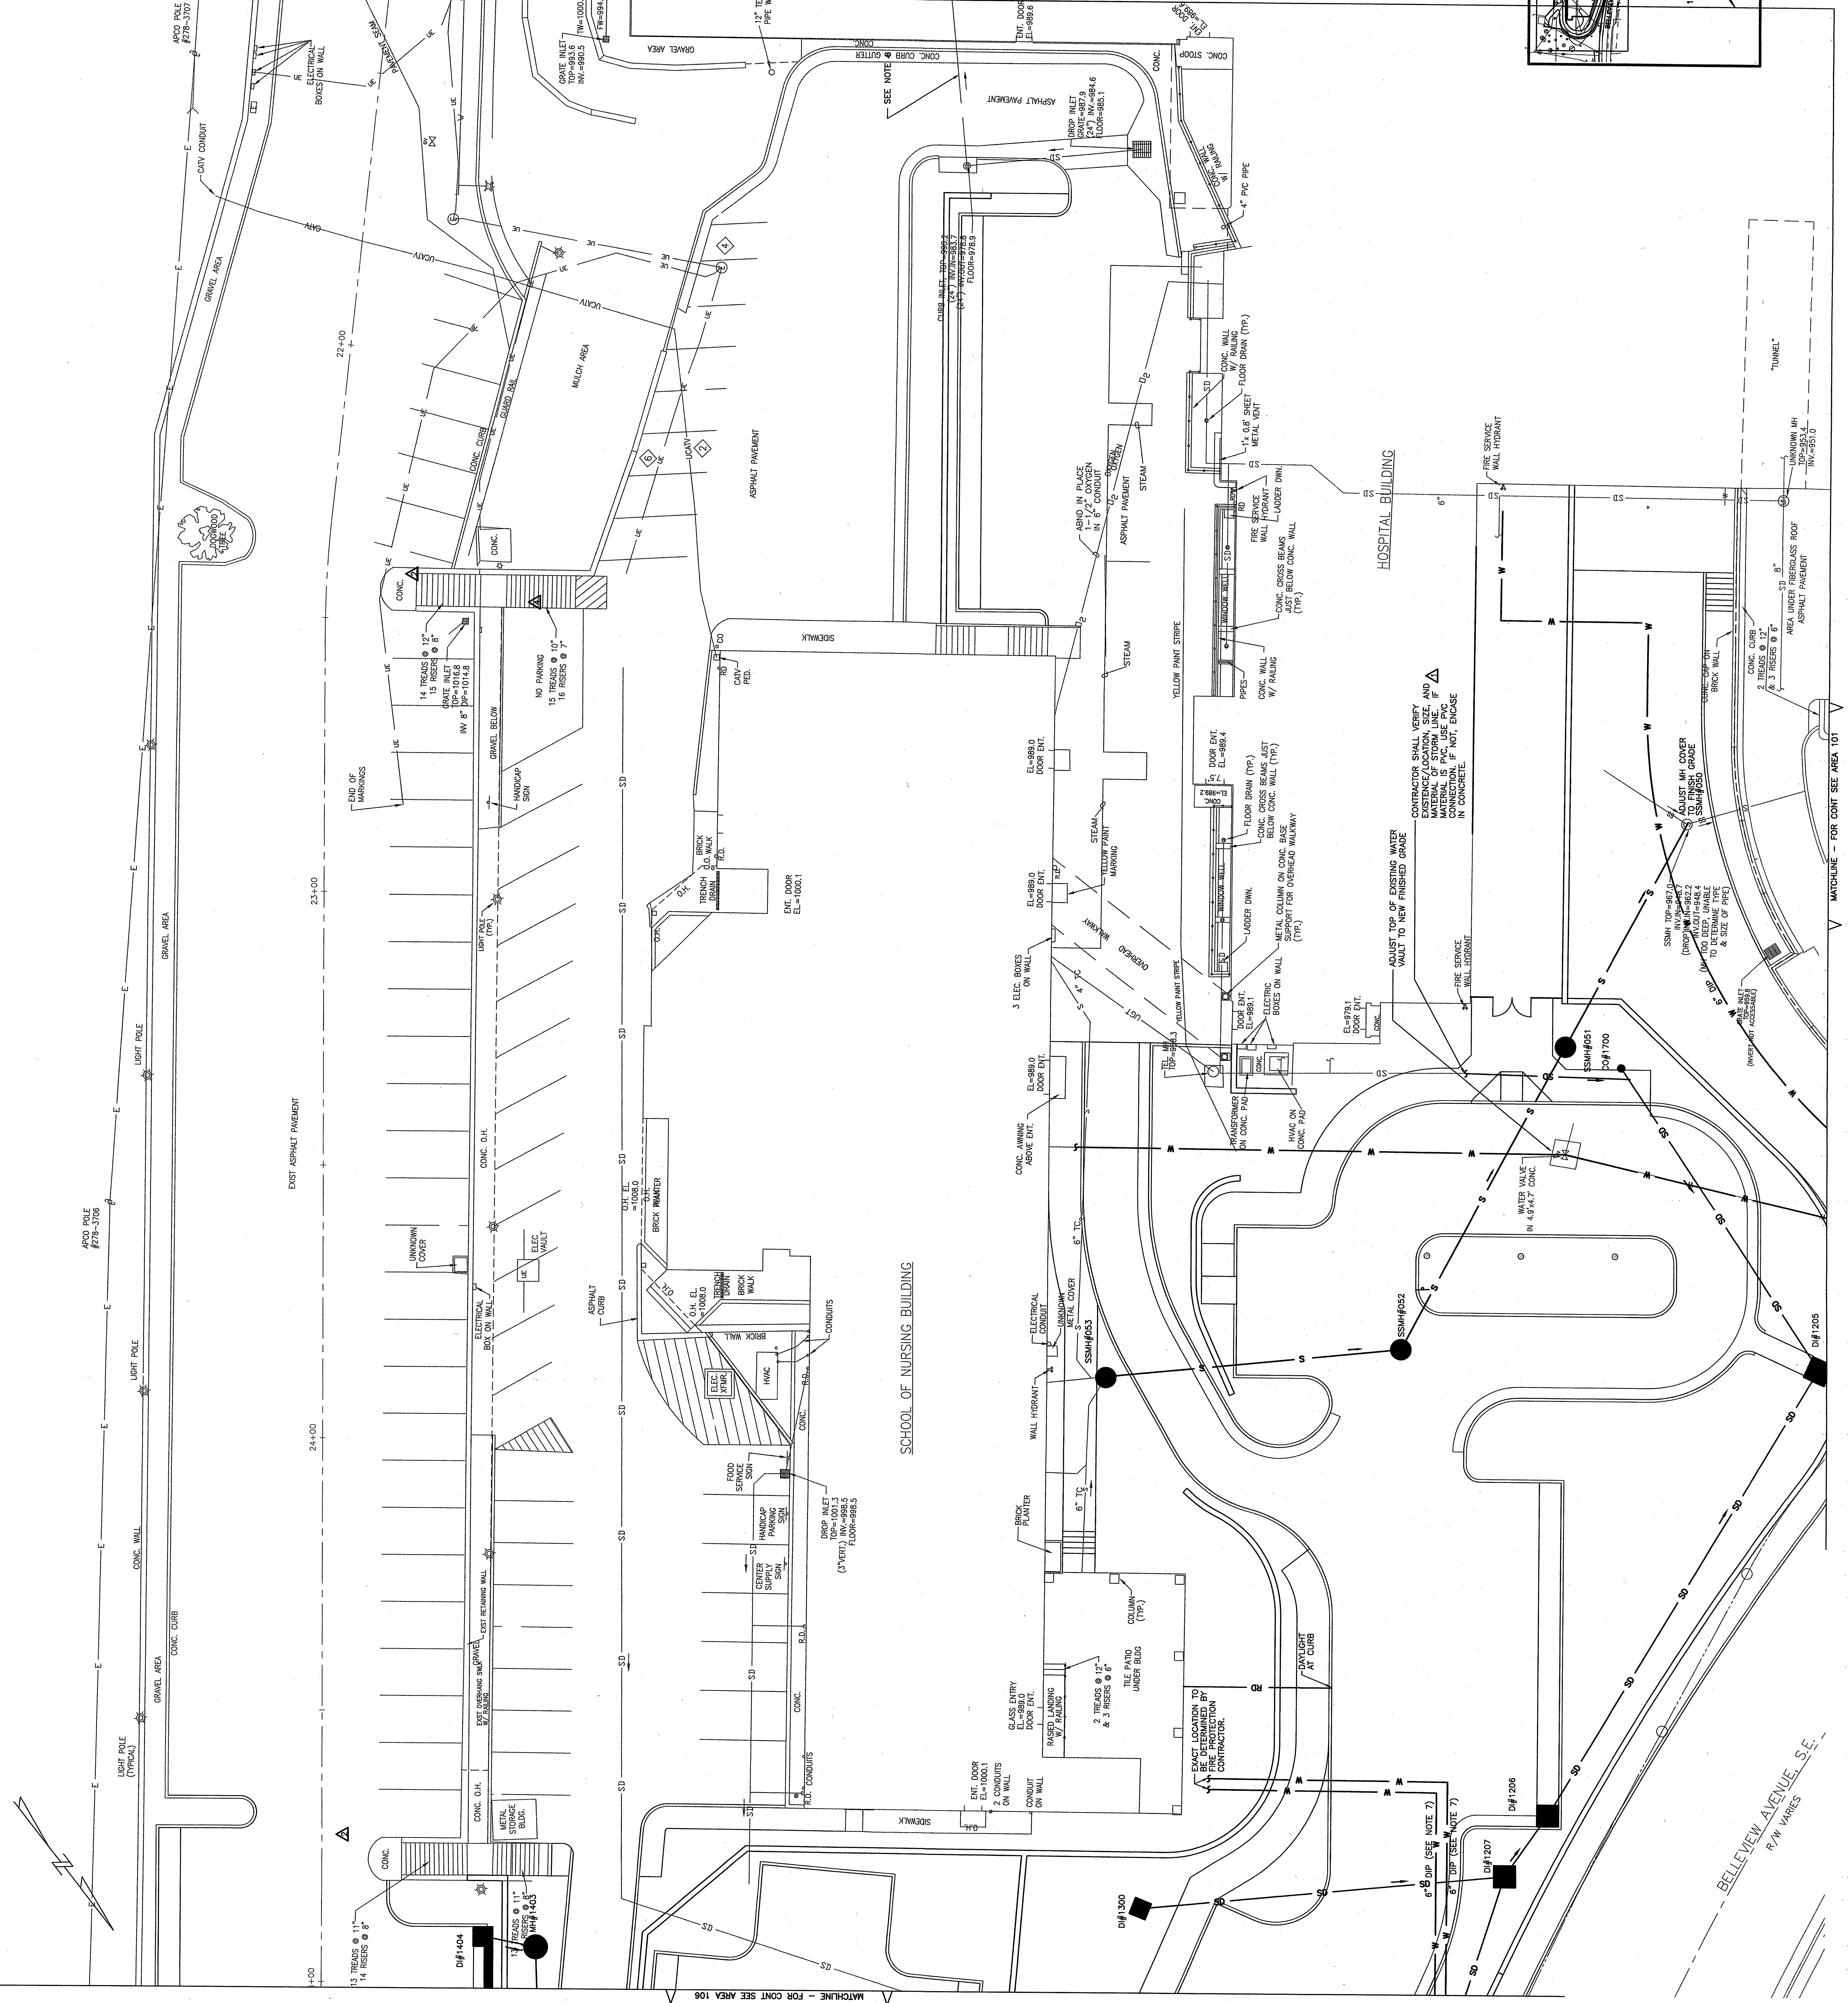

THE MAJORITY OF THIS SHEET HAS BEEN SUBMITTED, DATED JUNE 24, 2004.

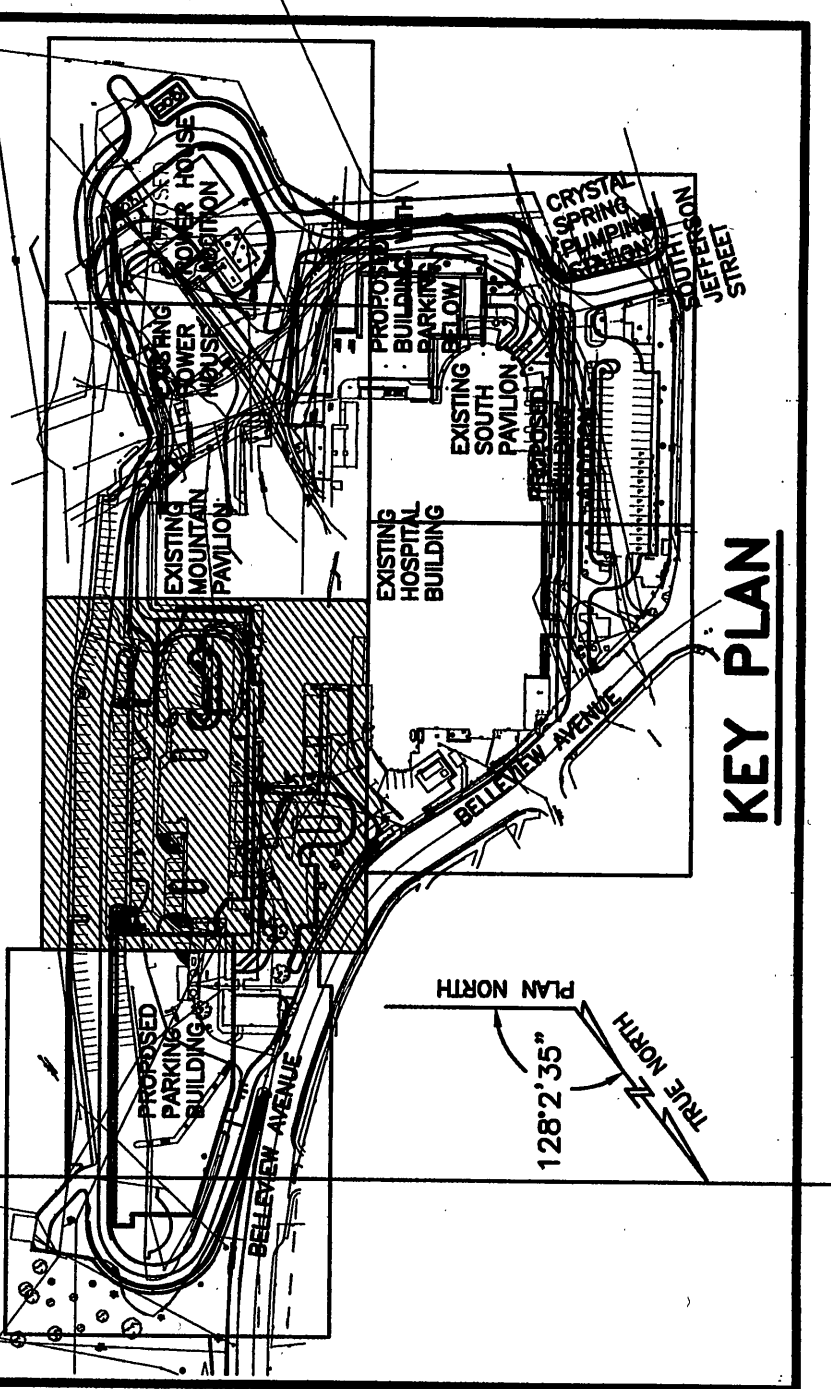

KEY PLAN