


DEMOLITION KEYNOTES

- 1 SAW CUT EXISTING PAVEMENT TO PROVIDE A SMOOTH TRANSITION BETWEEN EXISTING AND NEW PAVEMENT.
- 2 REMOVE EXISTING INLET AND PIPING SYSTEM. REFER TO STORM DRAINAGE PLAN FOR NEW INLET.
- 3 EXISTING TELEPHONE SERVICE LINE TO BE DISCONNECTED BY TELEPHONE COMPANY AND ABANDONED IN PLACE.
- 4 EXISTING ELECTRIC SERVICE LINE TO BE REMOVED BY ELECTRIC UTILITY COMPANY.
- 5 EXISTING GAS SERVICE LINE TO BE DISCONNECTED BY GAS COMPANY AND ABANDONED IN PLACE OR REMOVED WHERE IN CONFLICT WITH NEW WORK.
- 6 EXISTING WATER SERVICE TO BE SHUT-OFF BY CITY OF ROANOKE UTILITY LINE SERVICE (U.L.S.). WATER METER TO BE REMOVED AND RETURNED TO U.L.S.


DEMOLITION NOTES

- 1) WHERE INDICATED OR WHERE IN CONFLICT WITH NEW CONSTRUCTION EXISTING TOPOGRAPHICAL AND PLANIMETRIC FEATURES (E.G. PAVEMENT, CURB, BOLLARDS, WHEEL STOPS, FENCE, GUARD RAIL, LIGHT POLES, AND LANDSCAPING FEATURES) WITHIN DEMOLITION BOUNDARY ARE TO BE REMOVED.
- 2) ALL EXISTING UTILITIES TO REMAIN IN PLACE UNLESS OTHERWISE NOTED. COORDINATE WITH UTILITY SERVICE COMPANY PRIOR TO PERFORMING DEMOLITION WORK.
- 3) WHERE INDICATED OR WHERE IN CONFLICT WITH NEW CONSTRUCTION EXISTING ASPHALT ON SITE IS TO BE REMOVED.
- 4) THE CONTRACTOR SHALL CONTACT "MISS UTILITY" (1-800-552-7001) 48 HOURS PRIOR TO WORKING IN THE VICINITY OF THE EXISTING UTILITIES.

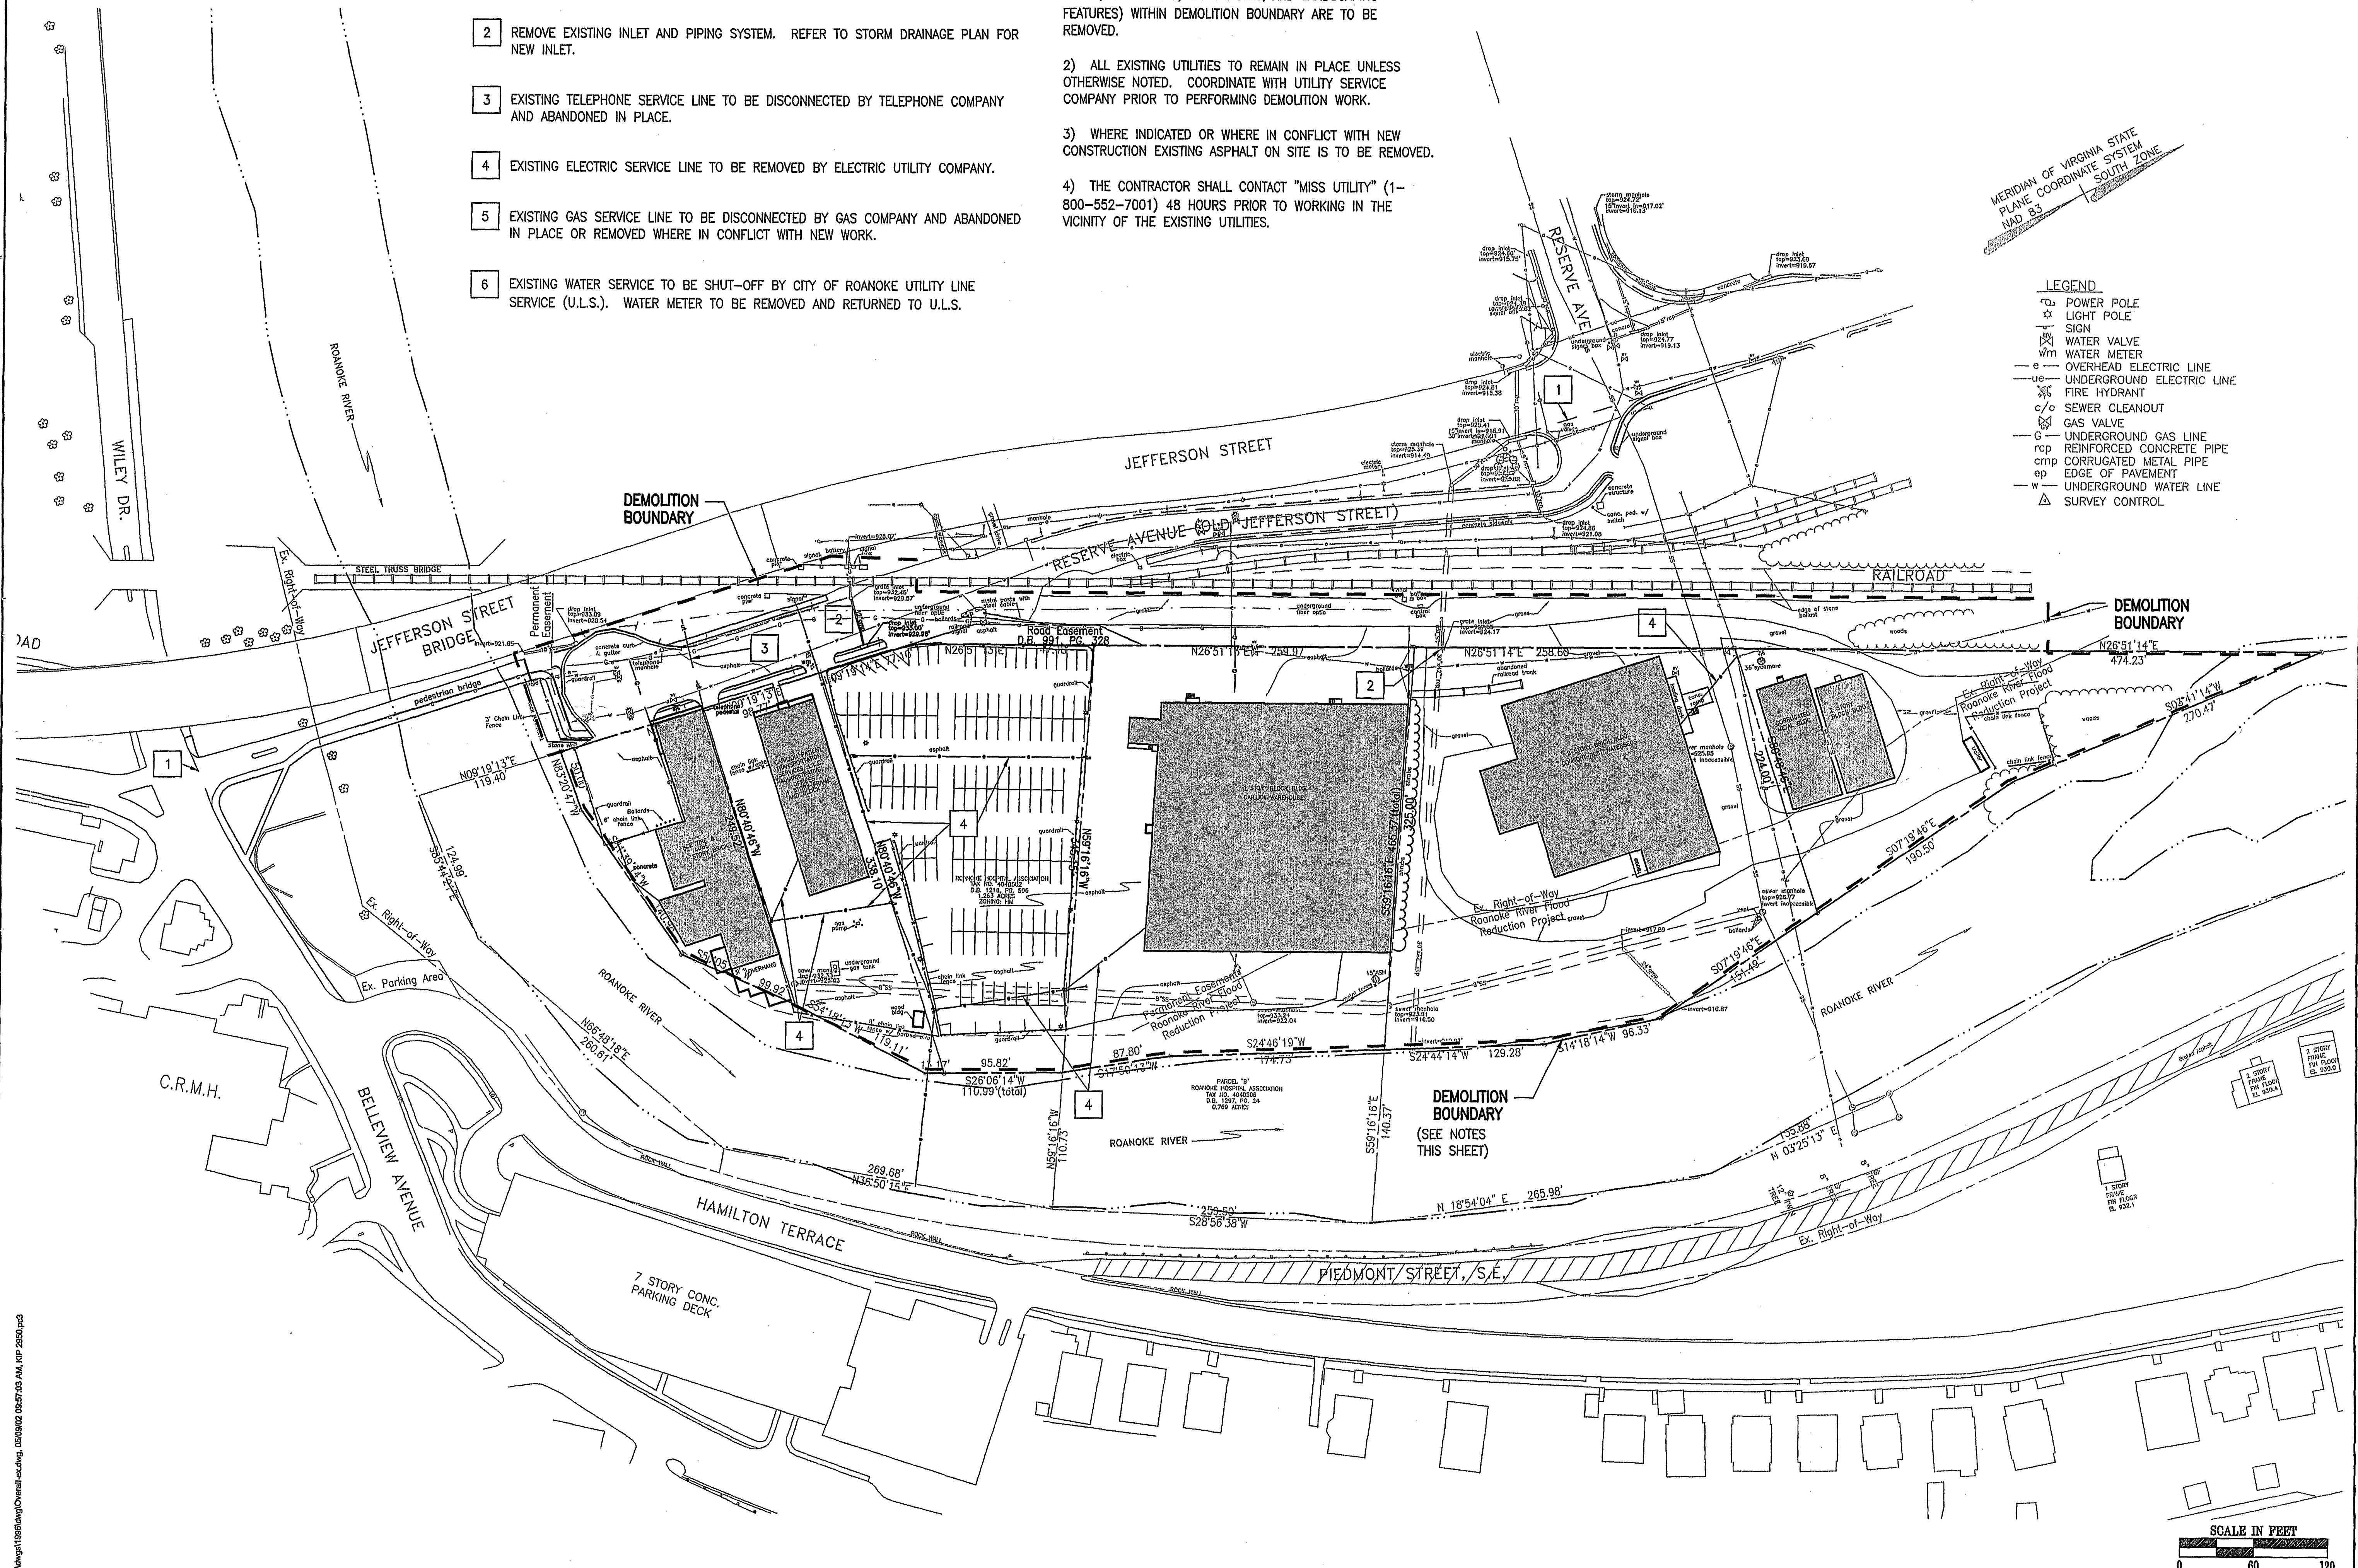

MERIDIAN OF VIRGINIA STATE
PLANE COORDINATE SYSTEM
NAD 83 SOUTH ZONE

- ## LEGEND
- POWER POLE
 - LIGHT POLE
 - SIGN
 - WATER VALVE
 - WATER METER
 - OVERHEAD ELECTRIC LINE
 - UNDERGROUND ELECTRIC LINE
 - FIRE HYDRANT
 - SEWER CLEANOUT
 - GAS VALVE
 - UNDERGROUND GAS LINE
 - REINFORCED CONCRETE PIPE
 - CORRUGATED METAL PIPE
 - EDGE OF PAVEMENT
 - UNDERGROUND WATER LINE
 - SURVEY CONTROL

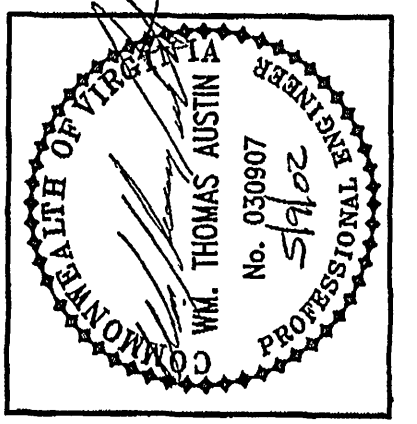

Revisions	Date
FOR REVIEW ONLY	
NOT FOR CONSTRUCTION	

Issue Date: 5/9/02
 Drawn By: CLZ
 Designed By: WTA
 Checked By: WTA
 Date: 5/9/02

Mattem & Craig
 CONSULTING ENGINEERS • SURVEYORS
 701 FIRST STREET, S.W.
 ROANOKE, VIRGINIA 24016
 (540) 345-9342
 FAX (540) 345-7891

CARLIN MEMORIAL HOSPITAL
 CRMH/CBI (RIVERWALK) PARKING DECK
**DEMOLITION AND
 REMOVAL PLAN**
 CITY OF ROANOKE, VIRGINIA


Vertical Scale:
N/A

Horizontal Scale:
1"=60'

Commission Number:
1996

Sheet No.:

C-3

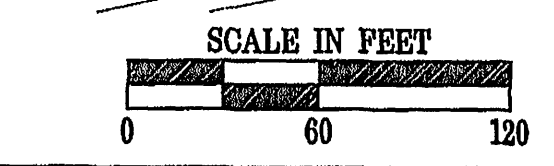

R:\DWGS\1996\DWG\OVERALL-EX.DWG