


File name: \\NA-AECOM\NET\COM\US\AMER\ROANOKE-USRNK1\DCS\PROJECTS\BID\160609975\000_CAD_GIS\910_CAD\15-SHEET\SC160609975_C-105.DWG

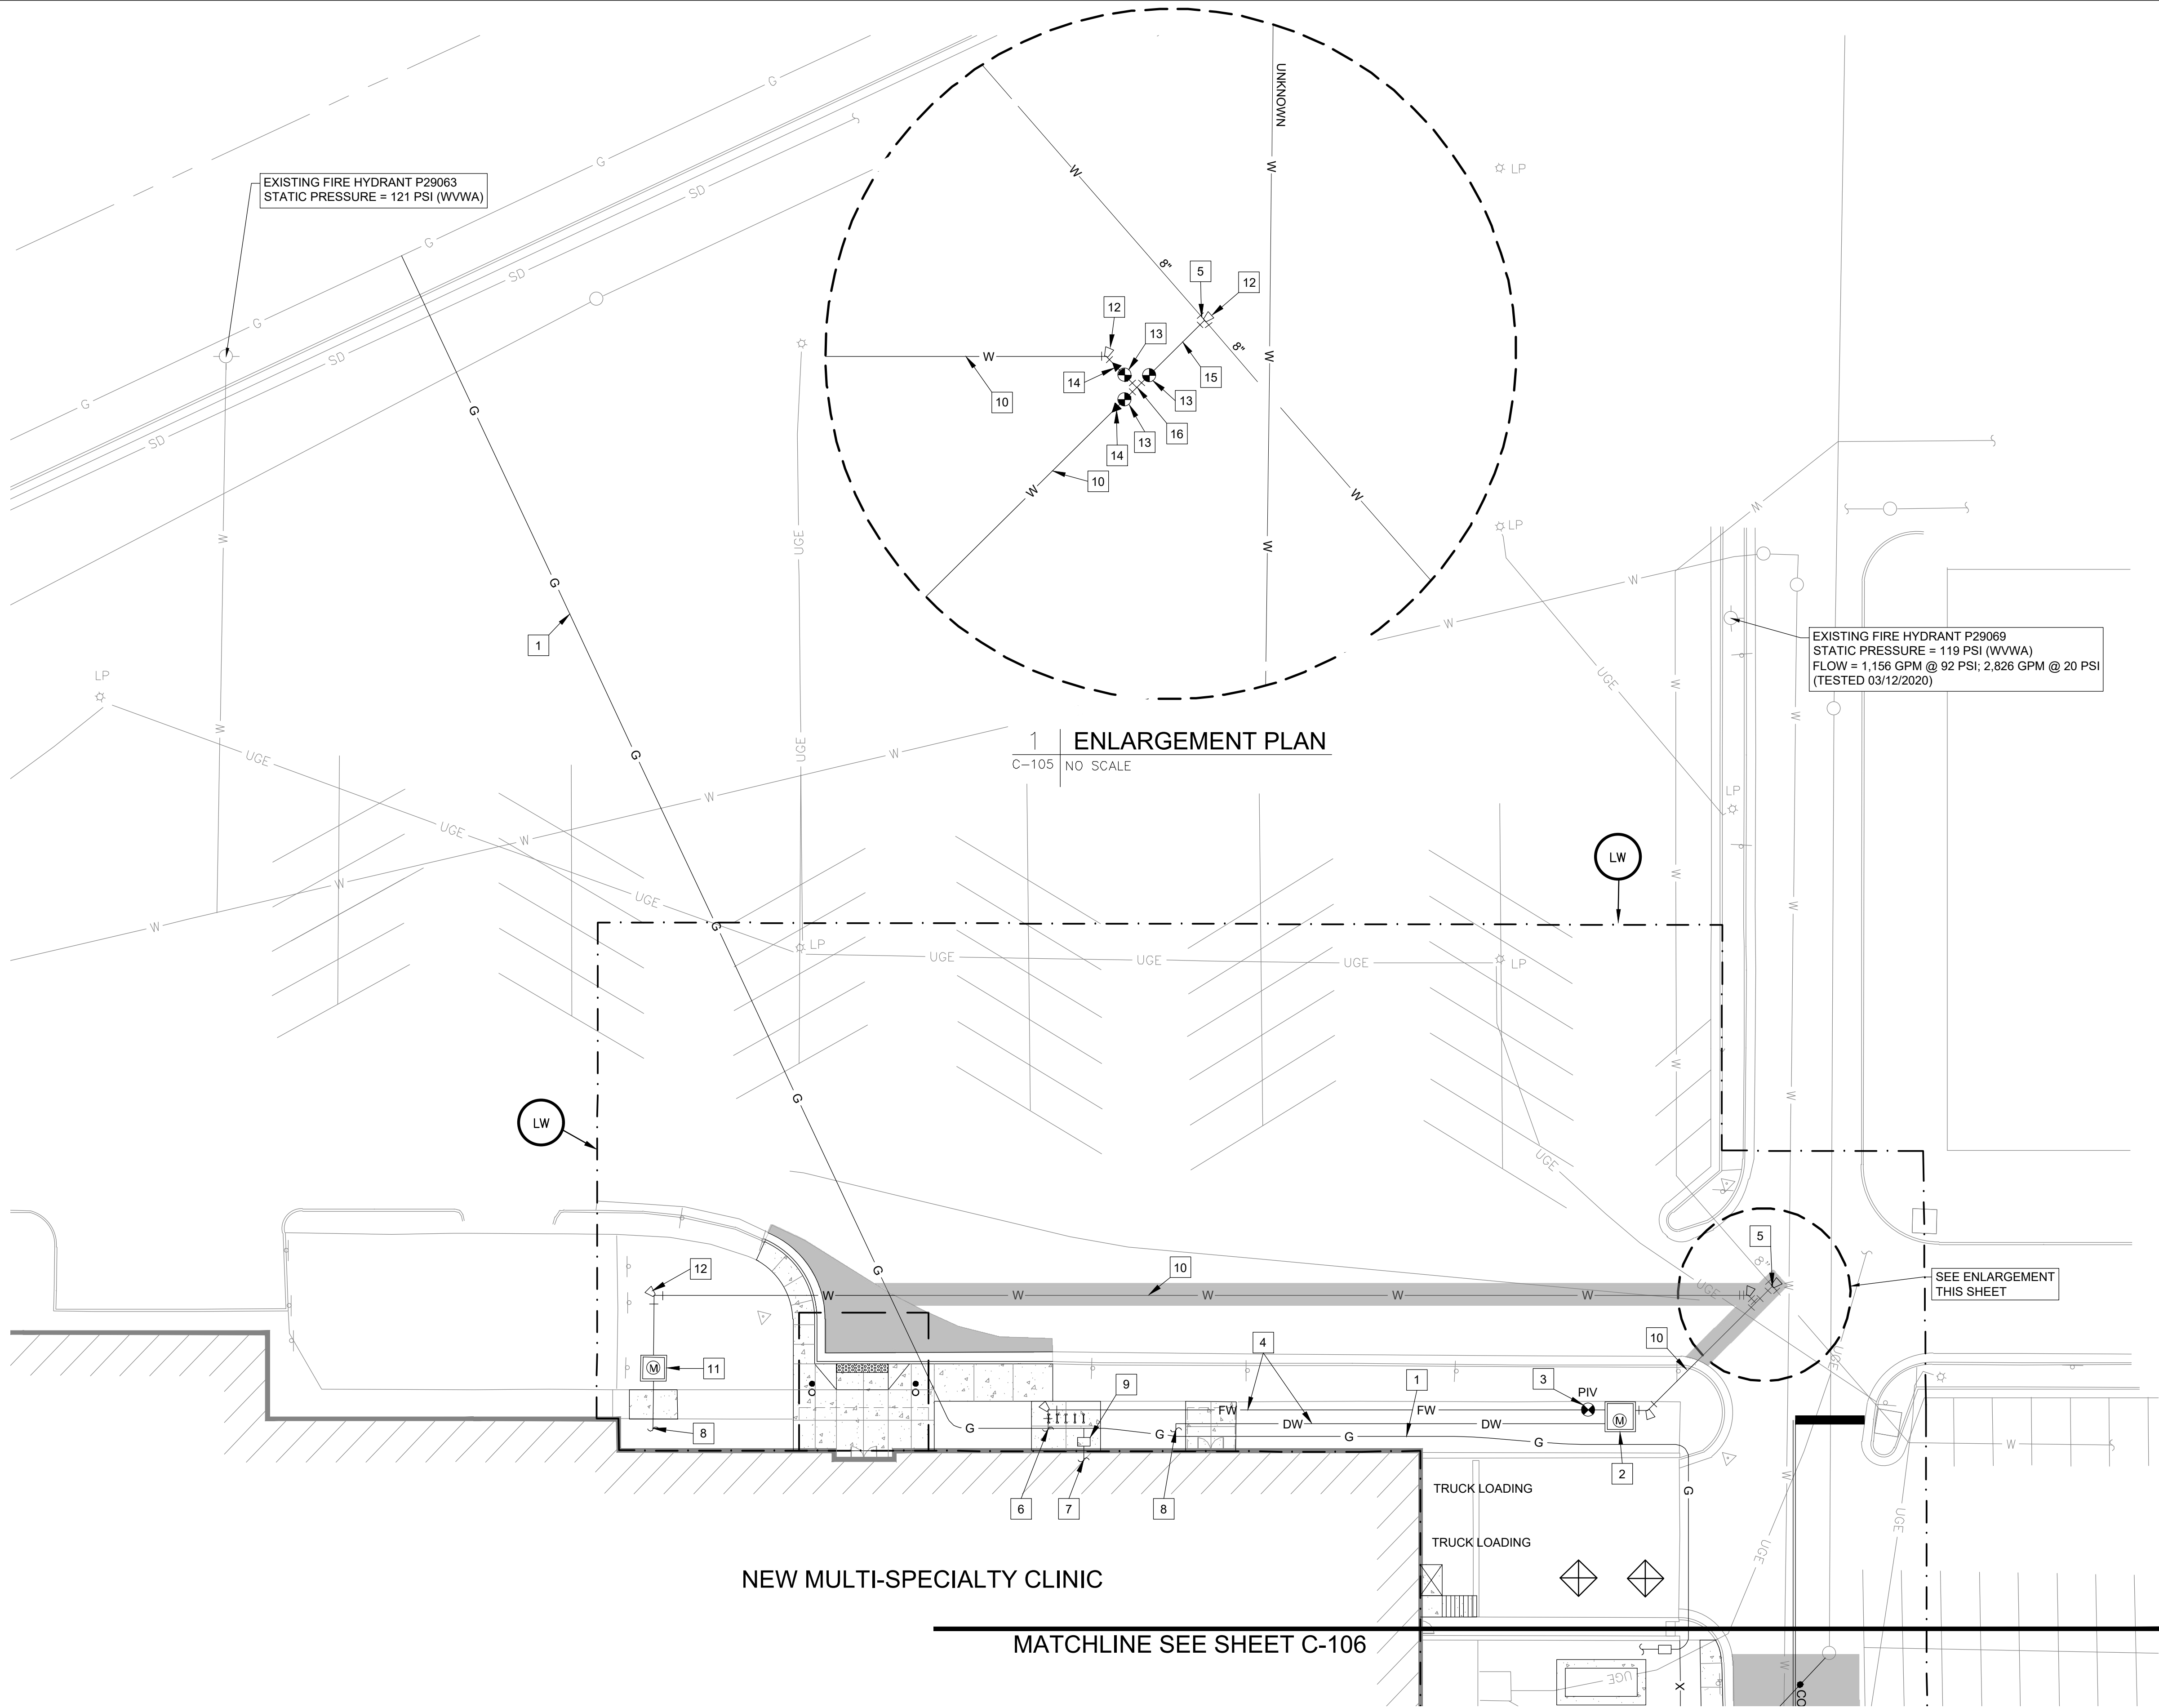

GENERAL NOTES THIS SHEET

- A. APPROVAL OF SITE PLAN DOES NOT INCLUDE THE DESIGN OF THE FIRE SPRINKLER SYSTEM UNDERGROUND PIPING. PRIOR TO INSTALLATION, SHOP DRAWINGS AND SEPARATE PERMIT APPLICATION MUST BE SUBMITTED THROUGH THE ROANOKE COUNTY DEPARTMENT OF BUILDING INSPECTIONS FOR REVIEW AND APPROVAL.
- B. GAS METER AND SERVICE BY ROANOKE GAS. COORDINATE LOCATION, SIZE, AND CAPACITY WITH ROANOKE GAS.

SHEET KEYNOTES:

- GAS SUPPLY LINE BY ROANOKE GAS. USE TRENCHLESS INSTALLATION METHOD BENEATH EXISTING PARKING LOT.
- PROVIDE WVWA W-7 COMMERCIAL FIRE/WATER VAULT AND 6\"/>

AECOM

PROJECT

**CARILION
TANGLEWOOD
MULTI-SPECIALTY
CLINIC**

TANGLEWOOD MALL
4444 ELECTRIC ROAD
ROANOKE, VIRGINIA 24018

CLIENT



CONSULTANT

AECOM

10 South Jefferson Street, Suite 1600
Roanoke, Virginia 24011
540.857.3100 tel 540.857.3180 fax
www.aecom.com

REGISTRATION



ISSUE/REVISION

I/R	DATE	DESCRIPTION
1	09/23/2020	COUNTY SITE DEV PLAN [2]
I	06/19/2020	COUNTY SITE DEV PLAN
I	05/04/2020	DESIGN DEVELOPMENT

PROJECT NUMBER


60609975

SHEET TITLE

**SITE UTILITY PLAN -
NORTH**

SHEET NUMBER

C-105

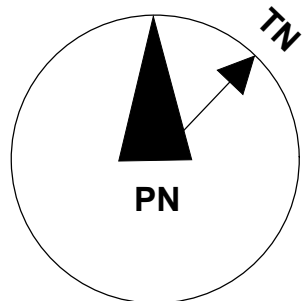

1"=20'

GRAPHIC SCALES