


File name: \\NA-AECOM\NET\COM\FS\AMER\ROANOKE-USRNK1\DCS\PROJECTS\BID\10609975\000_CAD_GIS\910_CAD\15-SHEET\15-C10609975_C-105.DWG

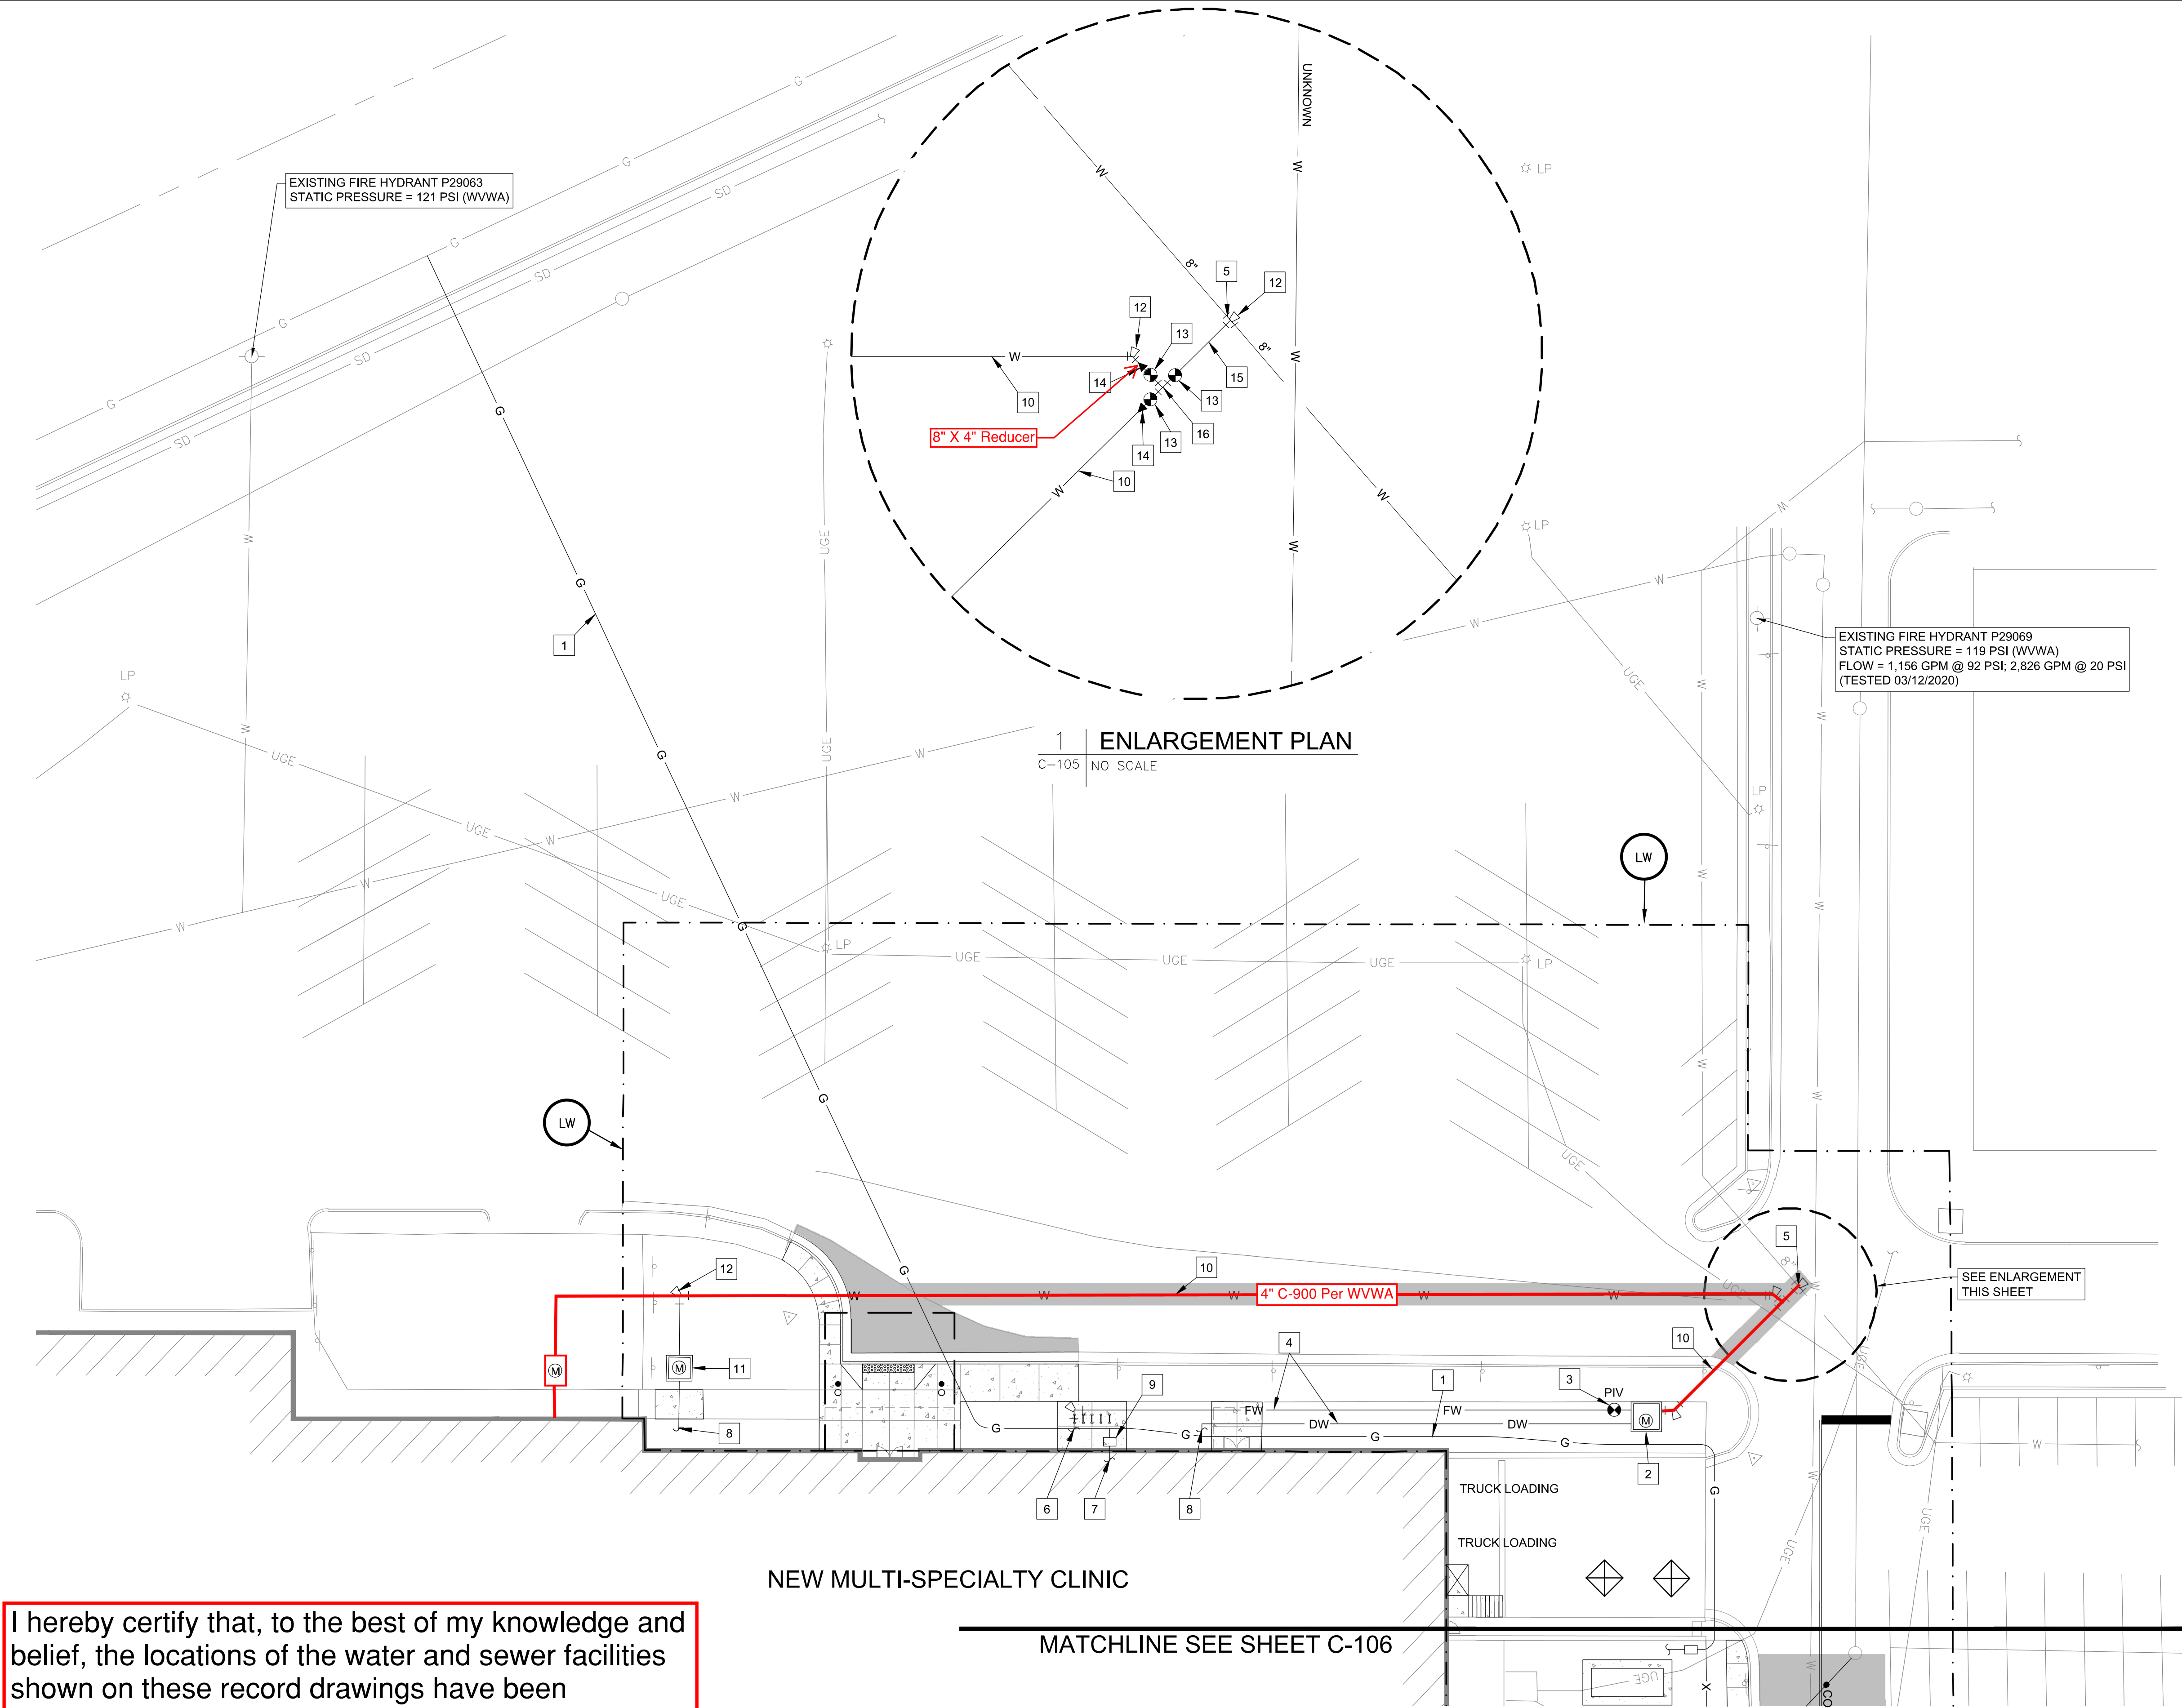

I hereby certify that, to the best of my knowledge and belief, the locations of the water and sewer facilities shown on these record drawings have been constructed in accordance with approved plans and specs.

Devin J. Bowman
Name: Devin J. Bowman V.P.
Date: March 16, 2021
Signature: _____

GENERAL NOTES THIS SHEET

- A. APPROVAL OF SITE PLAN DOES NOT INCLUDE THE DESIGN OF THE FIRE SPRINKLER SYSTEM UNDERGROUND PIPING. PRIOR TO INSTALLATION, SHOP DRAWINGS AND SEPARATE PERMIT APPLICATION MUST BE SUBMITTED THROUGH THE ROANOKE COUNTY DEPARTMENT OF BUILDING INSPECTIONS FOR REVIEW AND APPROVAL.
- B. GAS METER AND SERVICE BY ROANOKE GAS. COORDINATE LOCATION, SIZE, AND CAPACITY WITH ROANOKE GAS.

SHEET KEYNOTES:

1. GAS SUPPLY LINE BY ROANOKE GAS. USE TRENCHLESS INSTALLATION METHOD BENEATH EXISTING PARKING LOT.
2. PROVIDE WVWA W-7 COMMERCIAL FIRE/WATER VAULT AND 6\"/>



PROJECT

CARILION TANGLEWOOD MULTI-SPECIALTY CLINIC

TANGLEWOOD MALL
4444 ELECTRIC ROAD
ROANOKE, VIRGINIA 24018

CLIENT



CONSULTANT

AECOM

10 South Jefferson Street, Suite 1600
Roanoke, Virginia 24011
540.857.3100 tel 540.857.3180 fax
www.aecom.com

REGISTRATION



ISSUE/REVISION

NO.	DATE	DESCRIPTION
1	09/23/2020	COUNTY SITE DEV PLAN [2]
I	06/19/2020	COUNTY SITE DEV PLAN
I	05/04/2020	DESIGN DEVELOPMENT
I/R	DATE	DESCRIPTION

PROJECT NUMBER

60609975


SHEET TITLE

SITE UTILITY PLAN -
NORTH

WVWA RED LINE DRAWING

SHEET NUMBER

C-105

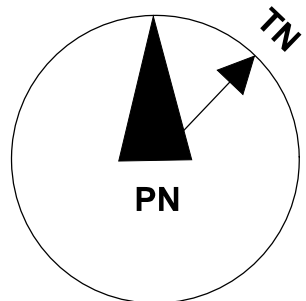

1"=20'

20' 10' 0' 20' 40'

GRAPHIC SCALES