
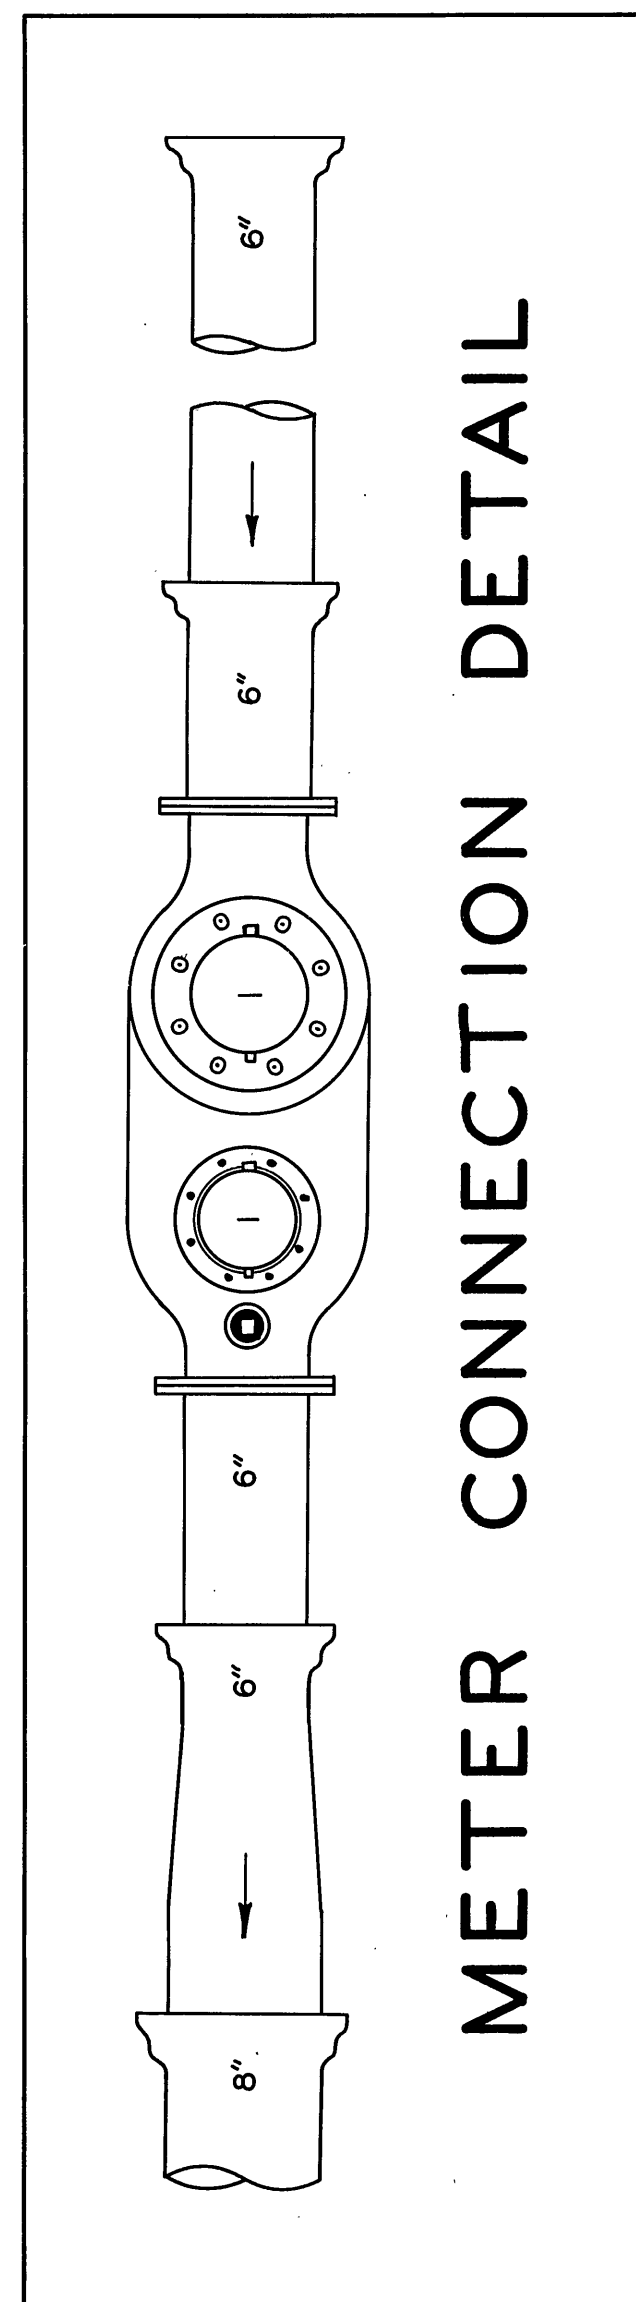


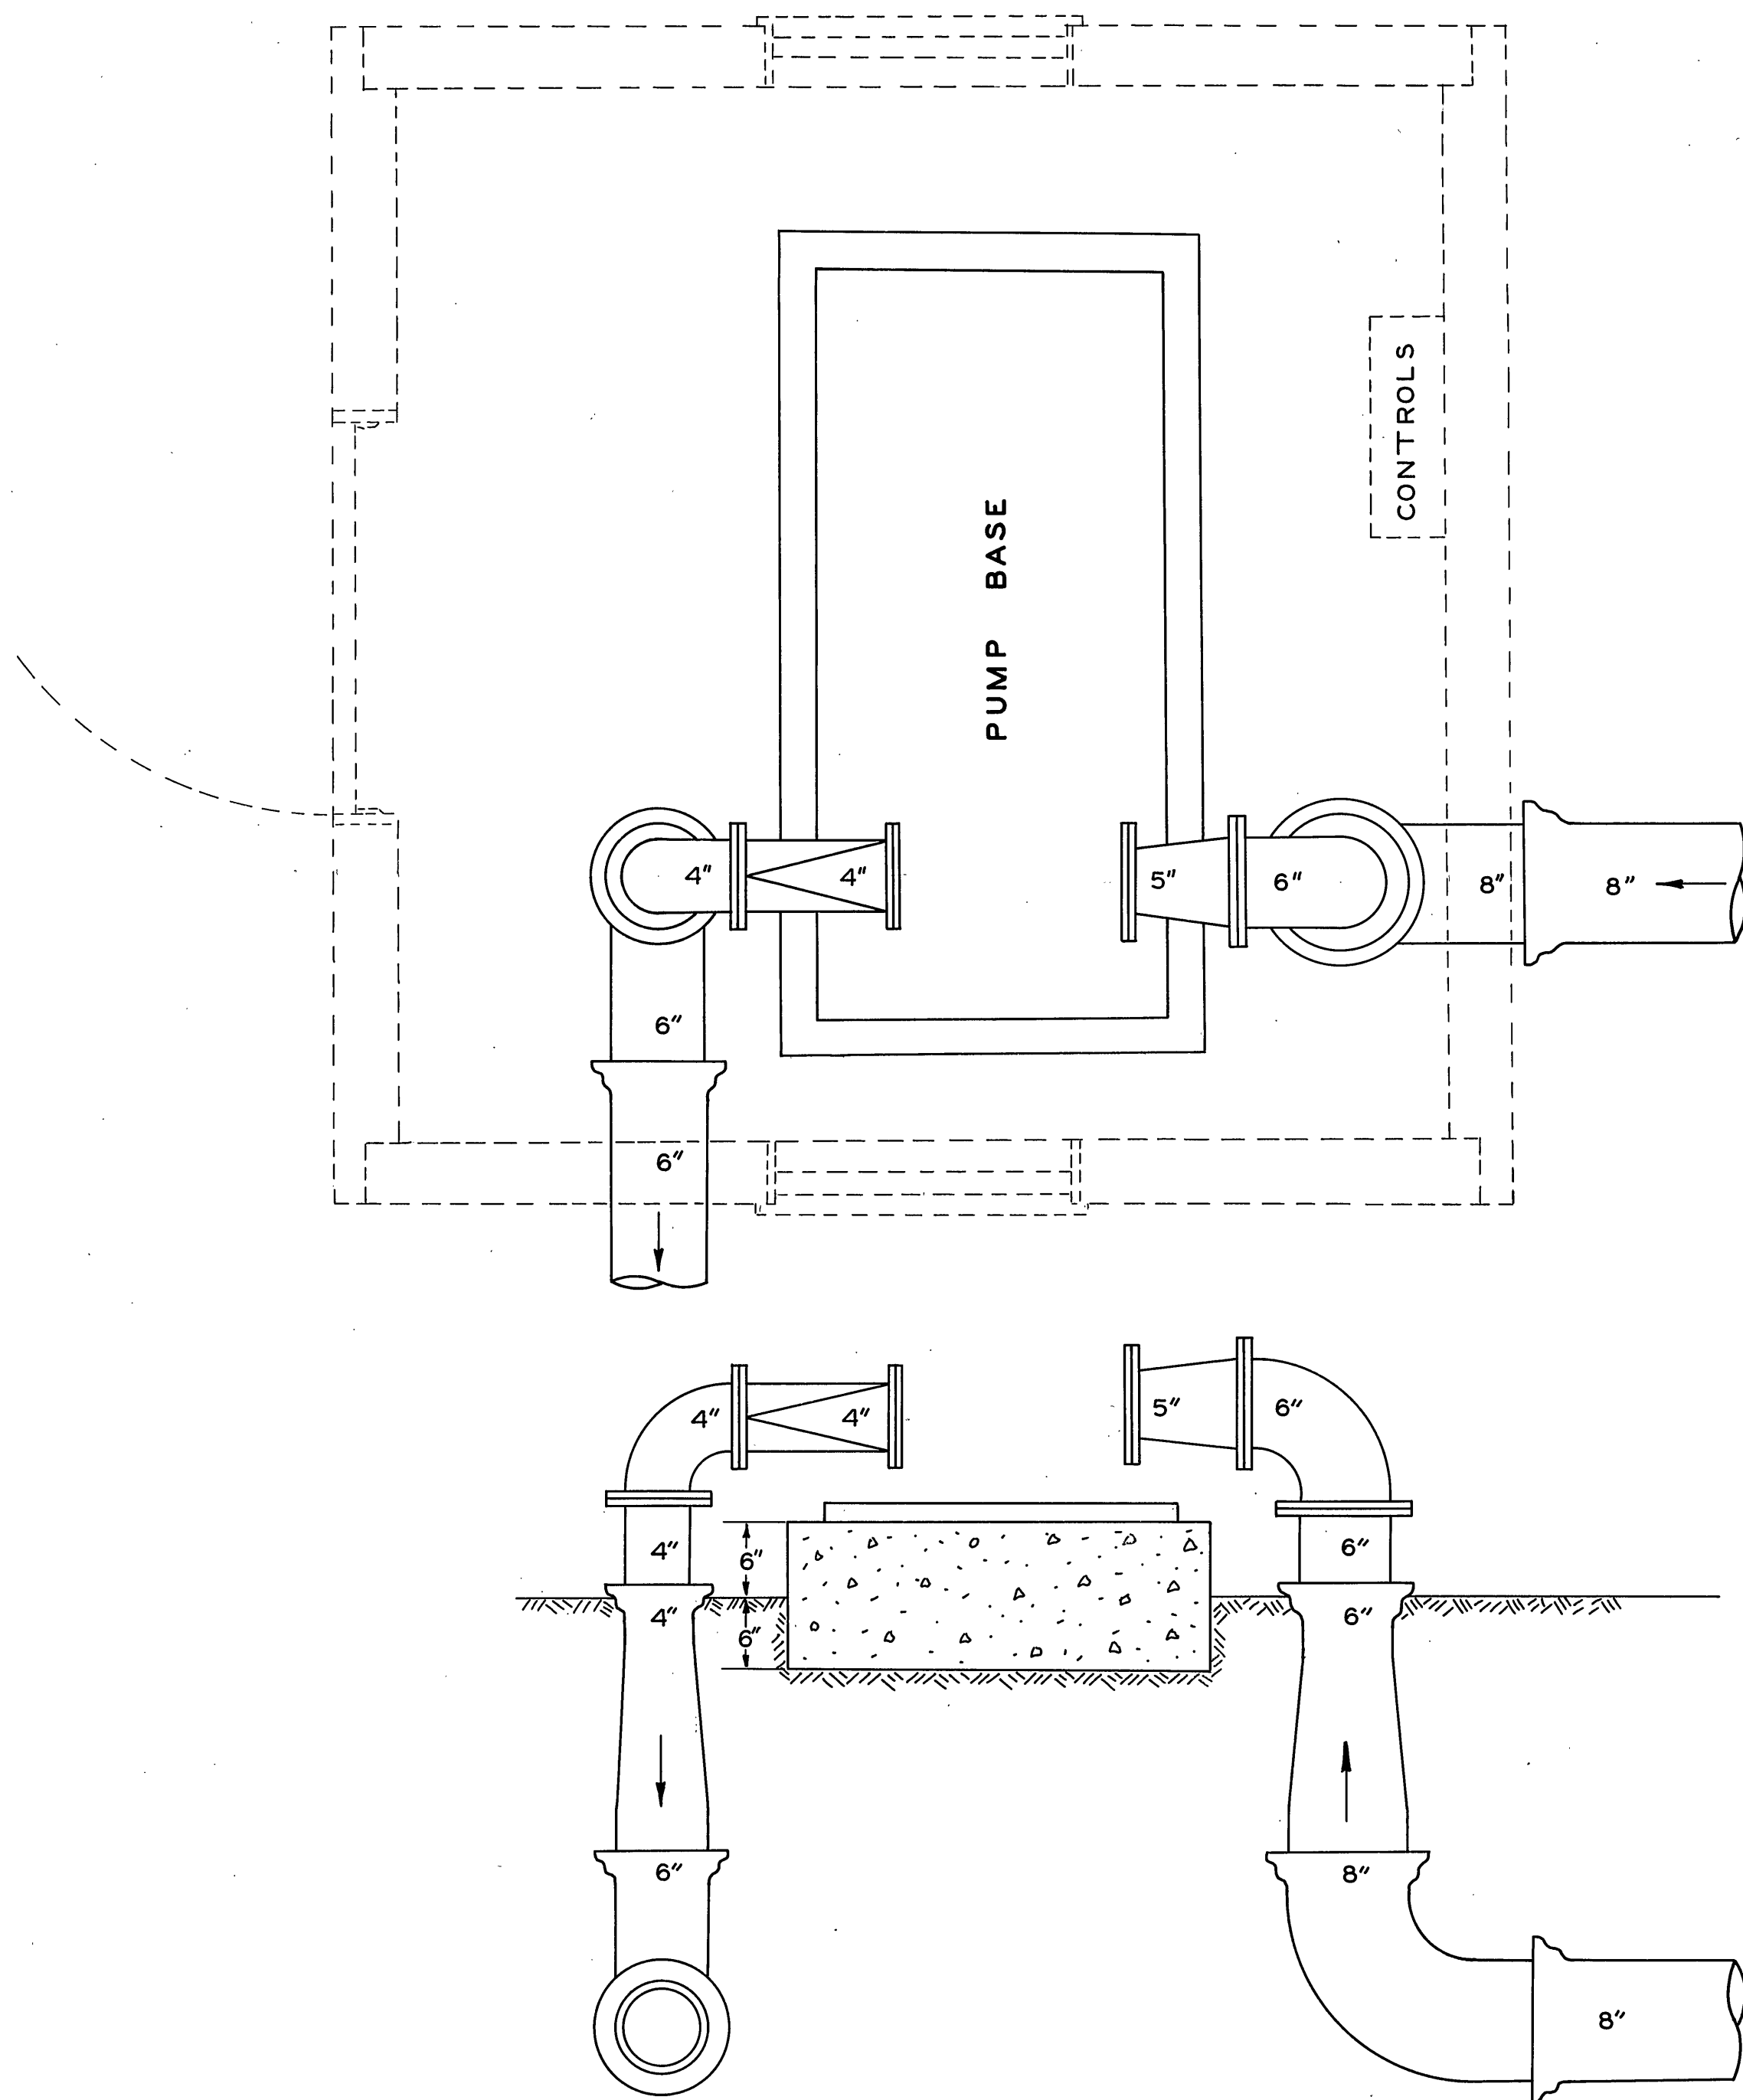

PIPING LAYOUT

PROPOSED CARROLL AVE. PUMPING STATION
 SCALE: 1" = 1'

DATE: JULY 22, 1959