



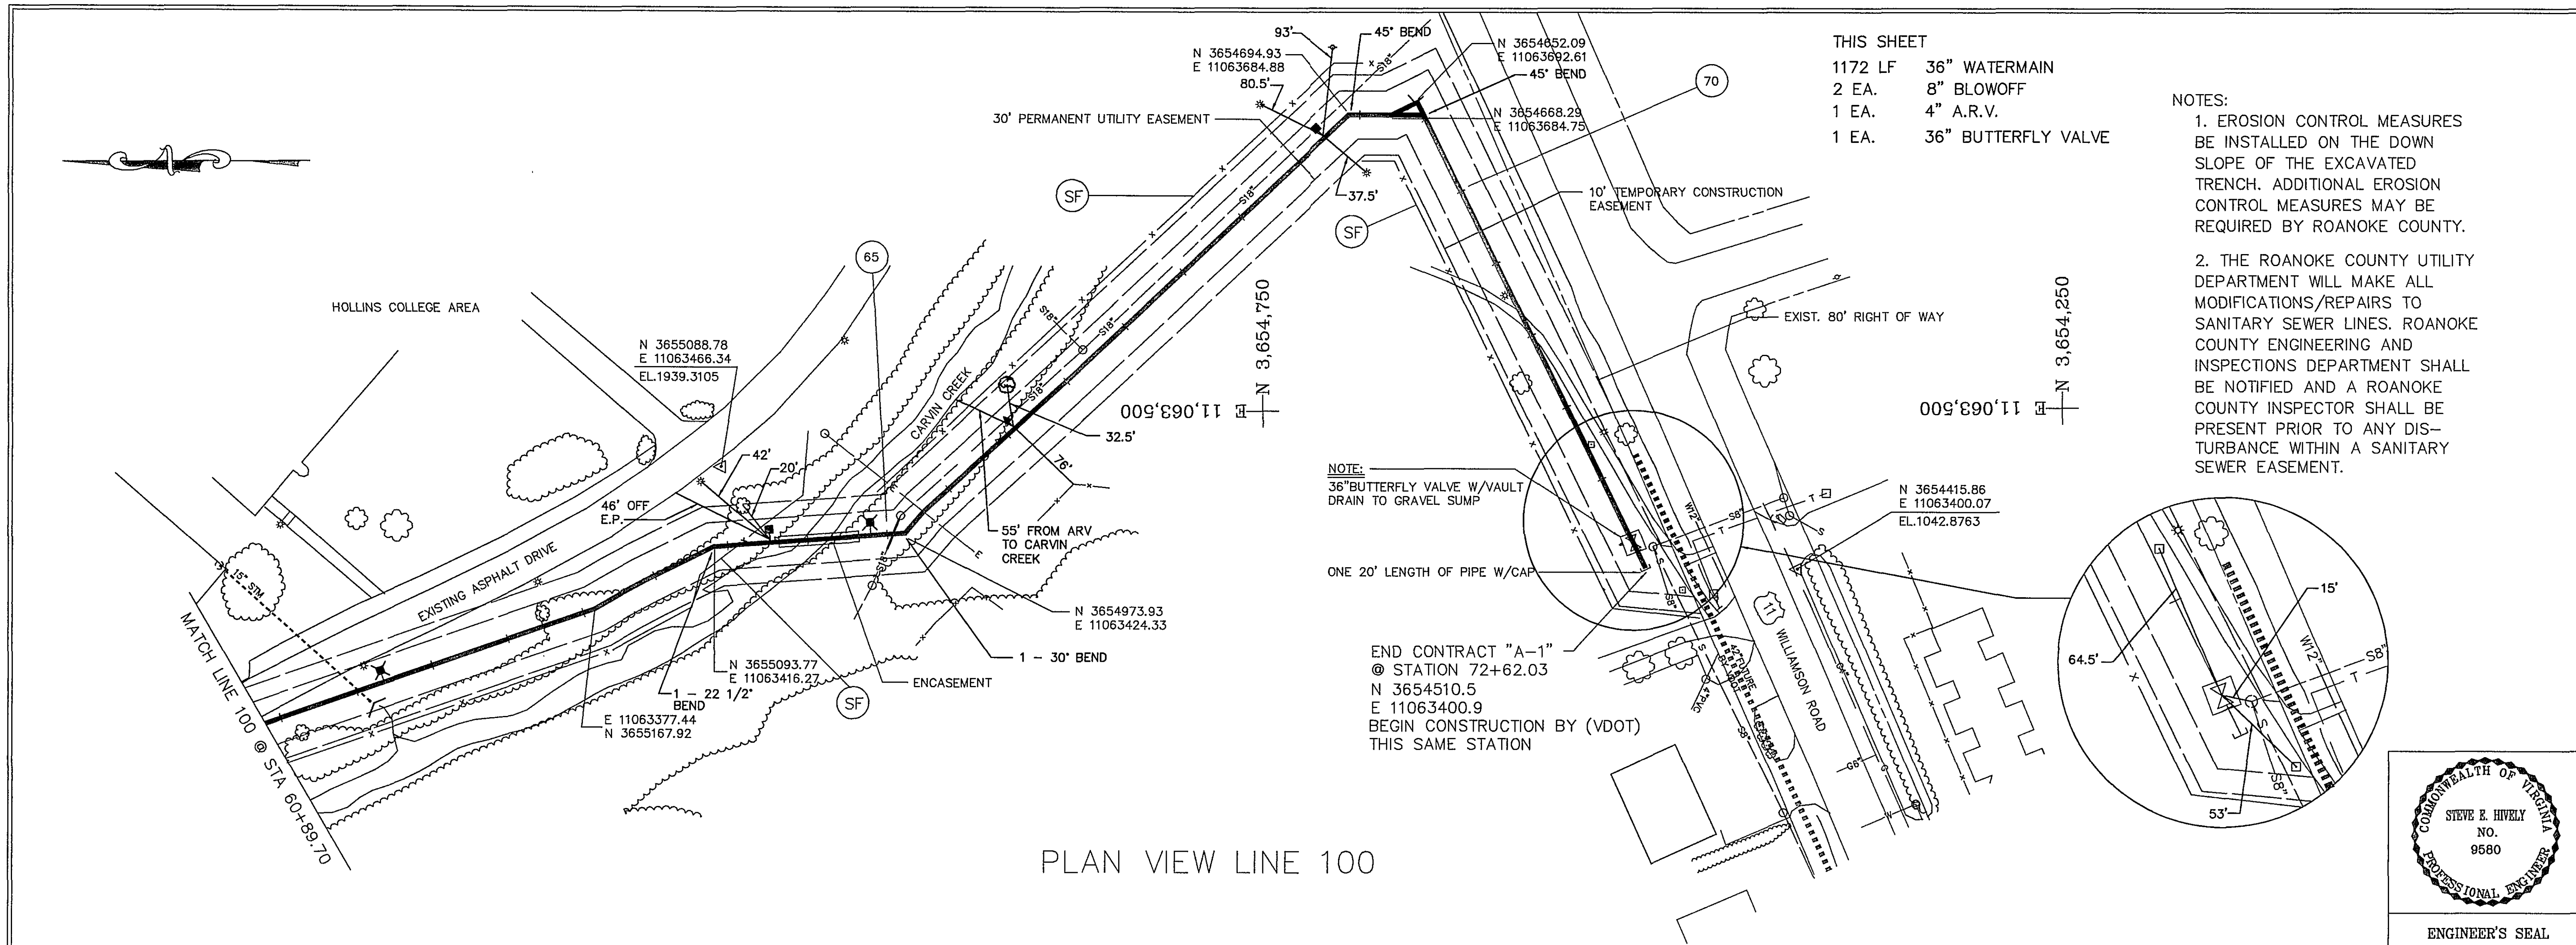


PLAN VIEW LINE 100

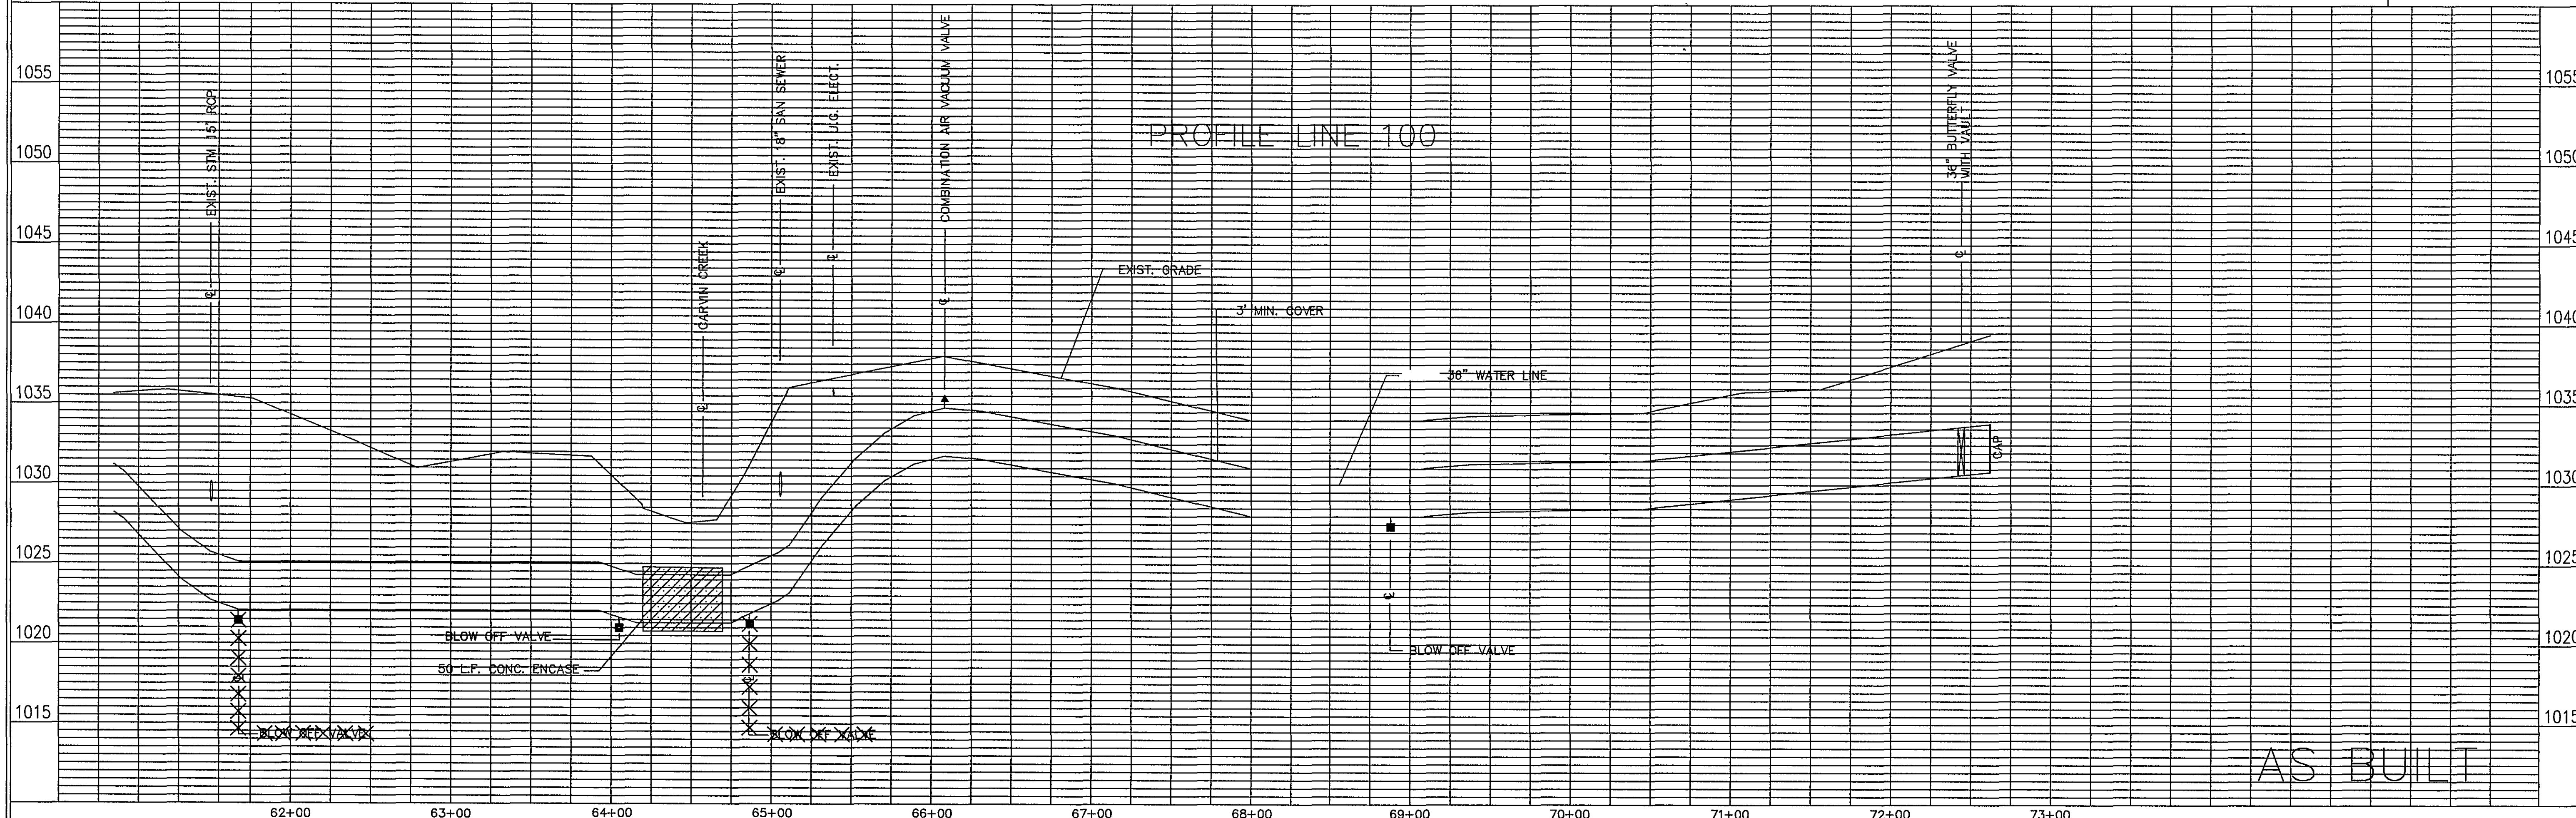

AS BUILT

THIS SHEET
1172 LF 36" WATERMAIN
2 EA. 8" BLOWOFF
1 EA. 4" A.R.V.
1 EA. 36" BUTTERFLY VALVE

- NOTES:
1. EROSION CONTROL MEASURES BE INSTALLED ON THE DOWN SLOPE OF THE EXCAVATED TRENCH. ADDITIONAL EROSION CONTROL MEASURES MAY BE REQUIRED BY ROANOKE COUNTY.
 2. THE ROANOKE COUNTY UTILITY DEPARTMENT WILL MAKE ALL MODIFICATIONS/REPAIRS TO SANITARY SEWER LINES. ROANOKE COUNTY ENGINEERING AND INSPECTIONS DEPARTMENT SHALL BE NOTIFIED AND A ROANOKE COUNTY INSPECTOR SHALL BE PRESENT PRIOR TO ANY DISTURBANCE WITHIN A SANITARY SEWER EASEMENT.

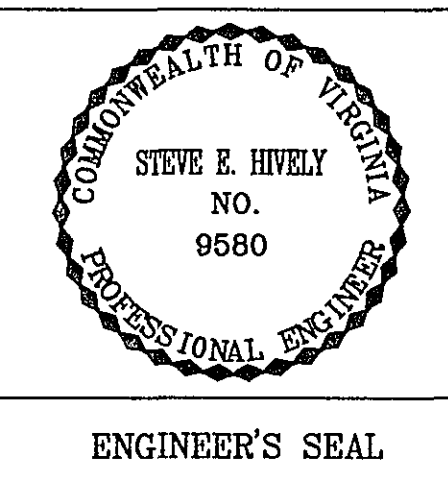

Dewberry & Davis
Architects
Engineers
Planners
Surveyors
5238 Valleypointe Parkway, Suite One-B
Roanoke, Virginia 24019
703.362.7725

Carvins Cove, Phase II
City of Roanoke
Roanoke, Virginia

CONTRACT "A-1"
LINE 100
STA 60+89.70 - 72+62.03

Drawn By ACF/REH
Designed By RBS
Checked By SEH
Date DEC. 1993
Scale V: 1" = 5'
H: 1" = 50'
Plan Number F6
Zoned NONE
Sheet 6 of 9
File Number C1160