



THIS SHEET
1012 LF 36" WATERMAIN
1 EA. 8" BLOWOFF
1 EA. 6" A.R.V.
1 EA. 36" BUTTERFLY VALVE

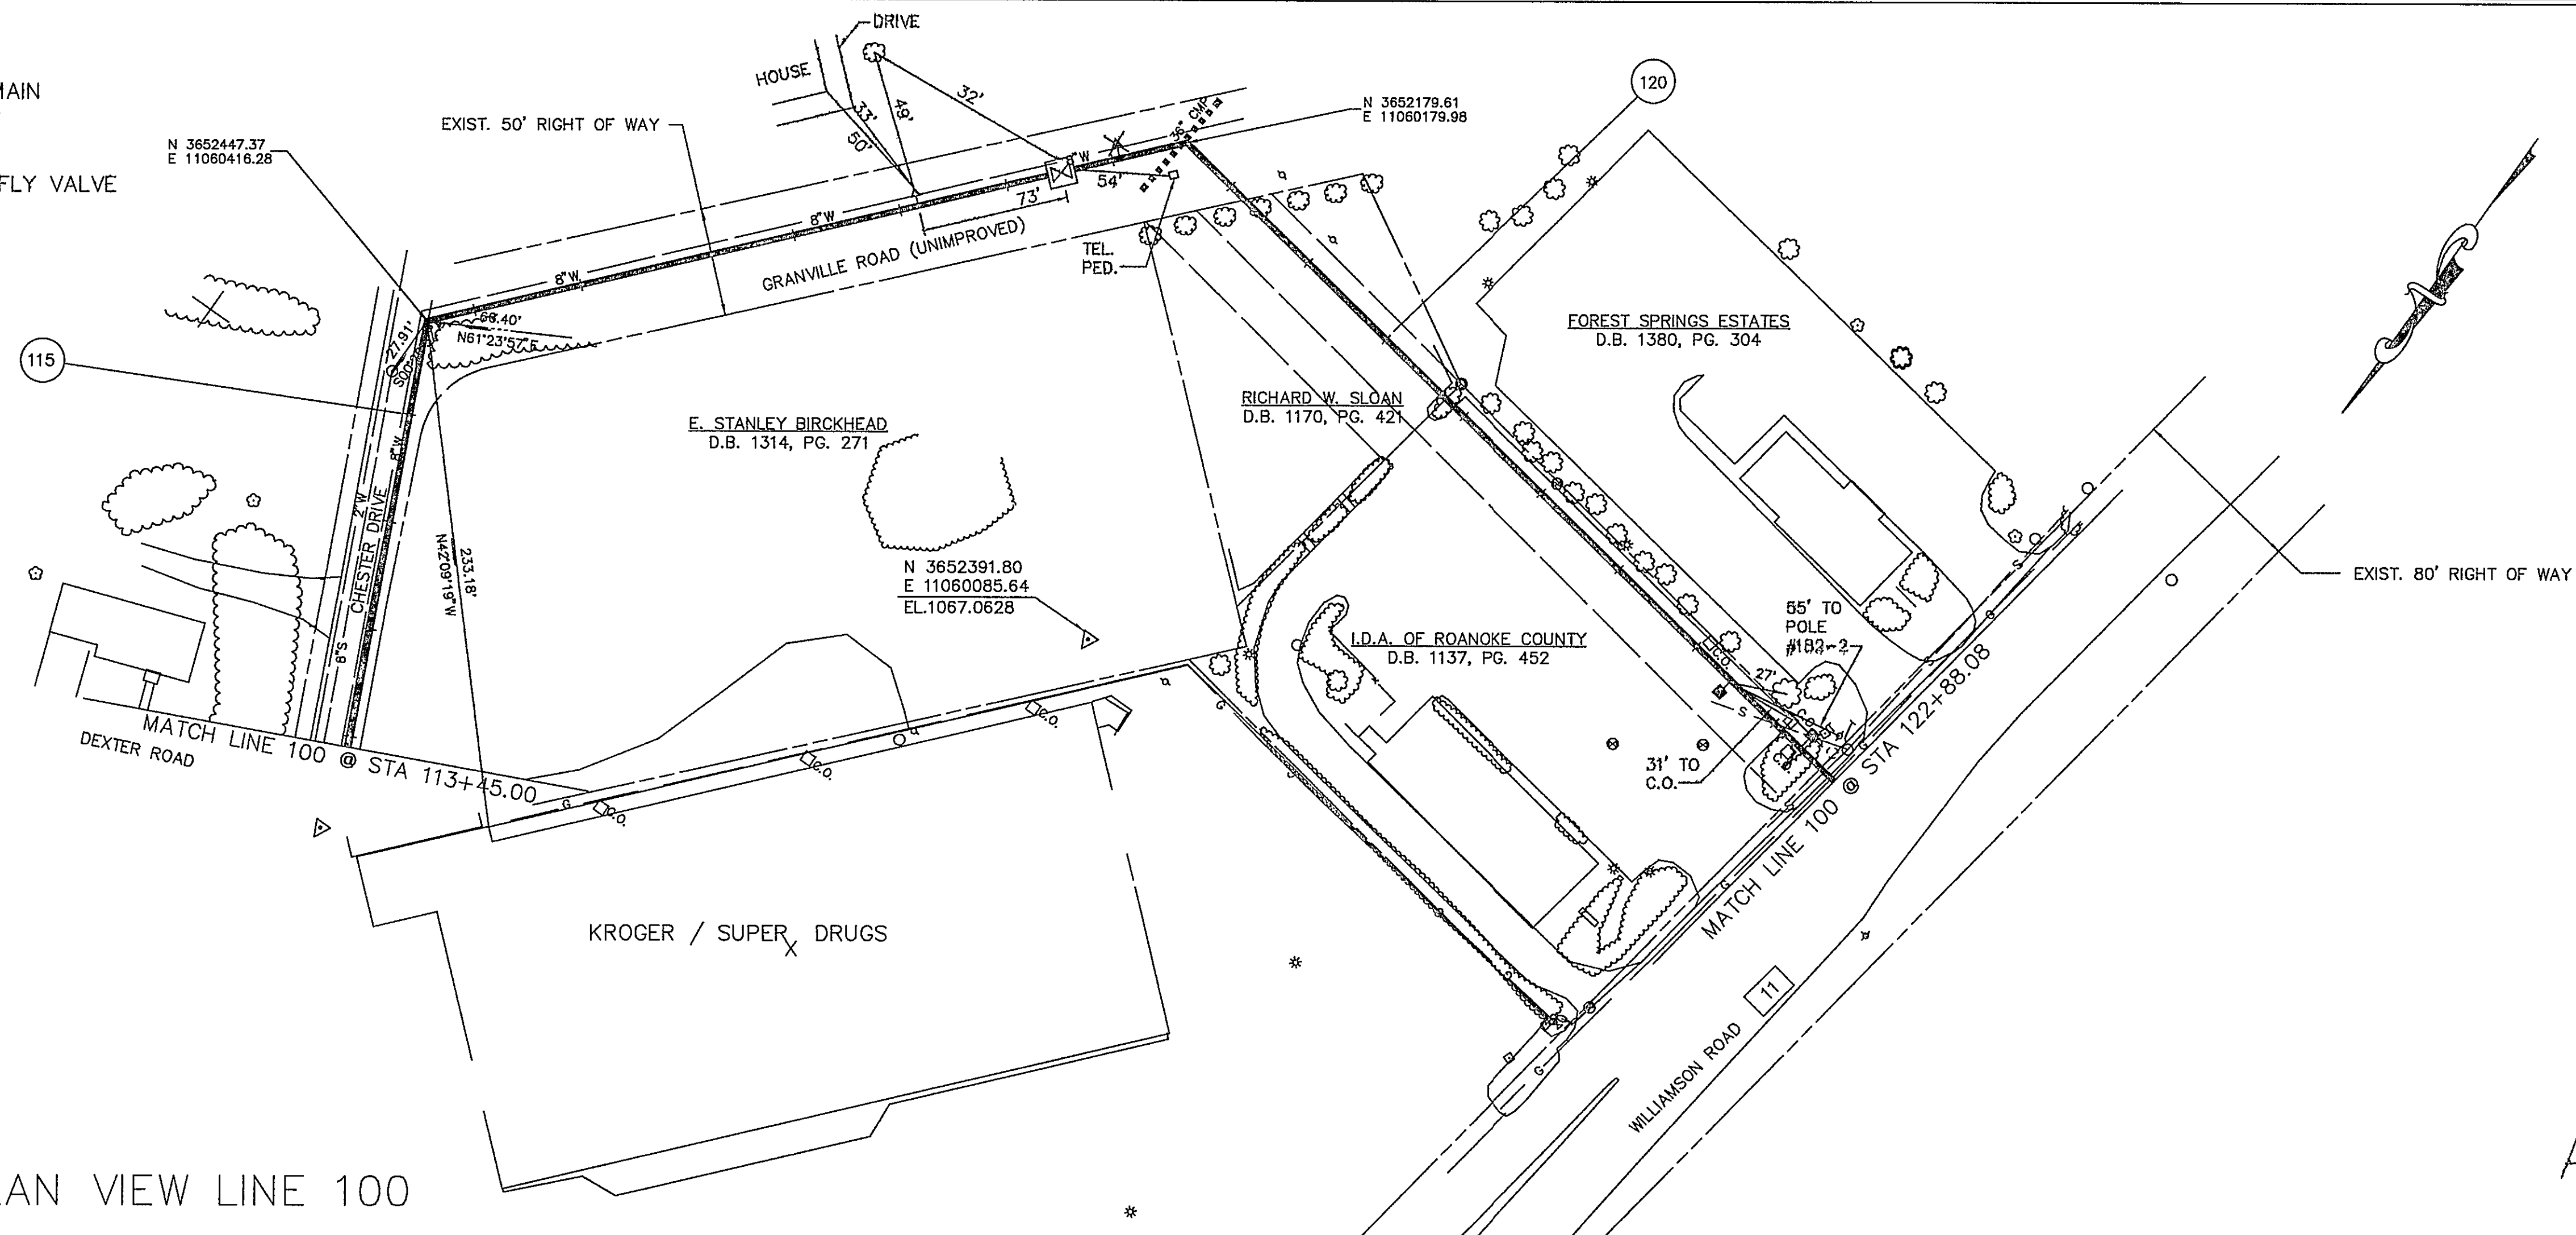


- NOTES:
1. EROSION CONTROL MEASURES BE INSTALLED ON THE DOWN SLOPE OF THE EXCAVATED TRENCH. ADDITIONAL EROSION CONTROL MEASURES MAY BE REQUIRED BY ROANOKE COUNTY.
 2. THE ROANOKE COUNTY UTILITY DEPARTMENT WILL MAKE ALL MODIFICATIONS/REPAIRS TO SANITARY SEWER AND WATER LINES. ROANOKE COUNTY ENGINEERING INSPECTIONS DEPARTMENT SHALL BE NOTIFIED AT LEAST 72 HOURS PRIOR TO WORK AND A COUNTY INSPECTOR SHALL BE PRESENT PRIOR TO ANY DISTURBANCE WITHIN A SANITARY SEWER OR WATER EASEMENT.

PLAN VIEW LINE 100

AS BUILT

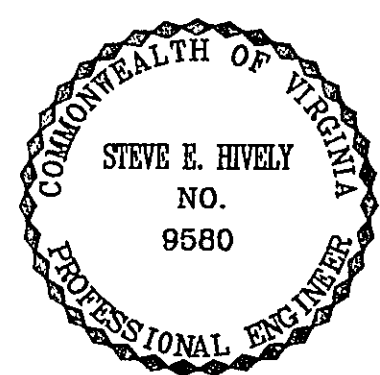

ENGINEER'S SEAL

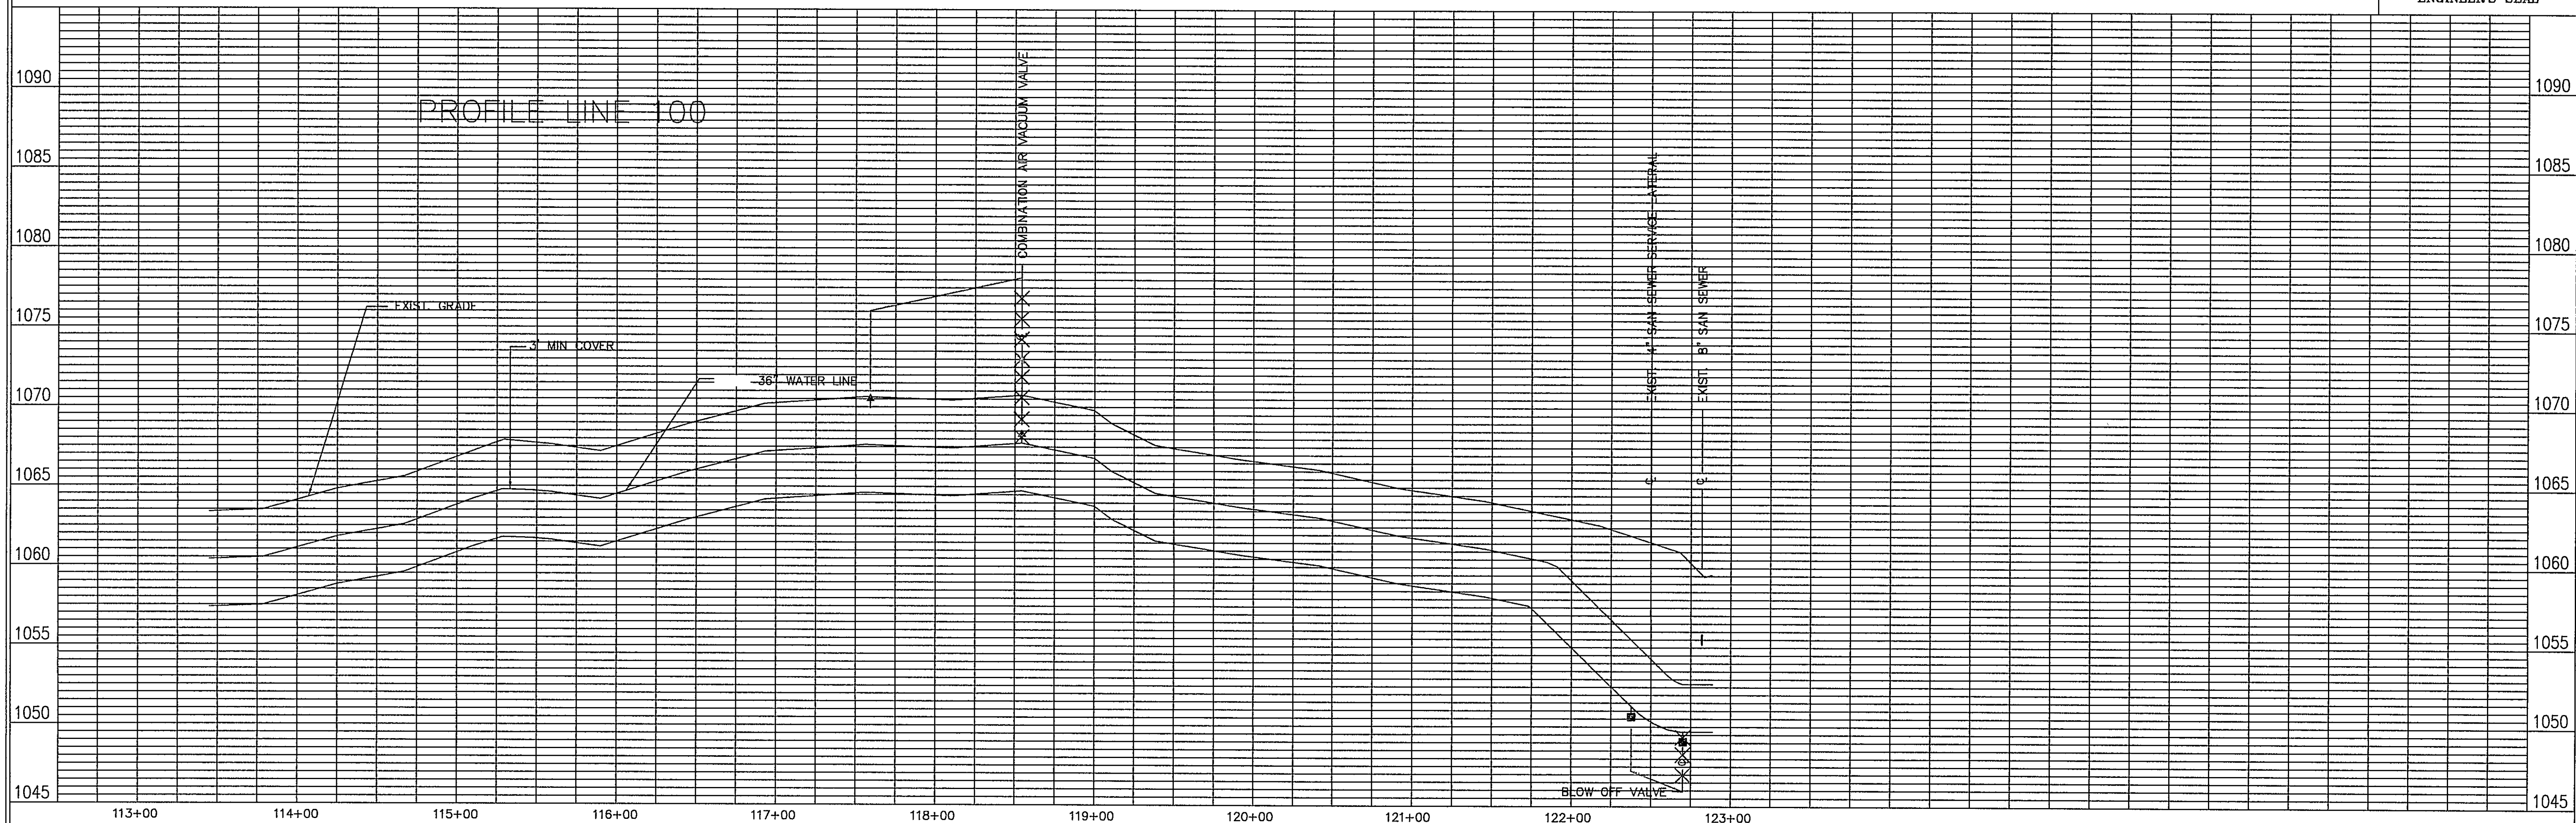

Architects
Engineers
Planners
Surveyors

Dewberry & Davis

5238 Valleypointe Parkway, Suite One-B
Roanoke, Virginia 24019
703-362-7725

Carvins Cove, Phase II
City of Roanoke
Roanoke, Virginia

CONTRACT "A-2"
LINE 100
STA 113+45.00 - 122+88.08

Drawn By REH/ACF
Designed By RBS
Checked By SEH
Date DEC. 1993
Scale
V: 1" = 5'
H: 1" = 50'
Plan Number F9A
Zoned NONE
Sheet 3 of 12
File Number C1160