

092,690,750 N 3,651,250

092,690,750 N 3,650,500

- NOTES:
1. EROSION CONTROL MEASURES BE INSTALLED ON THE DOWN SLOPE OF THE EXCAVATED TRENCH. ADDITIONAL EROSION CONTROL MEASURES MAY BE REQUIRED BY ROANOKE COUNTY.
 2. THE ROANOKE COUNTY UTILITY DEPARTMENT WILL MAKE ALL MODIFICATIONS/REPAIRS TO SANITARY SEWER LINES. ROANOKE COUNTY ENGINEERING AND INSPECTIONS DEPARTMENT SHALL BE NOTIFIED AND A ROANOKE COUNTY INSPECTOR SHALL BE PRESENT PRIOR TO ANY DISTURBANCE WITHIN A SANITARY SEWER EASEMENT.


NOTE:
36" BUTTERFLY VALVE W/VAULT
DRAINED TO GRADE

N 3650598.01
E 11059476.92
EL.1037.6348


NOTE:
36" BUTTERFLY VALVE W/VAULT
DRAINED TO GRADE

THIS SHEET

1379 LF	36" WATERMAIN
1 EA.	8" BLOWOFF
1 EA.	2" A.R.V.
1 EA.	36" BUTTERFLY VALVE

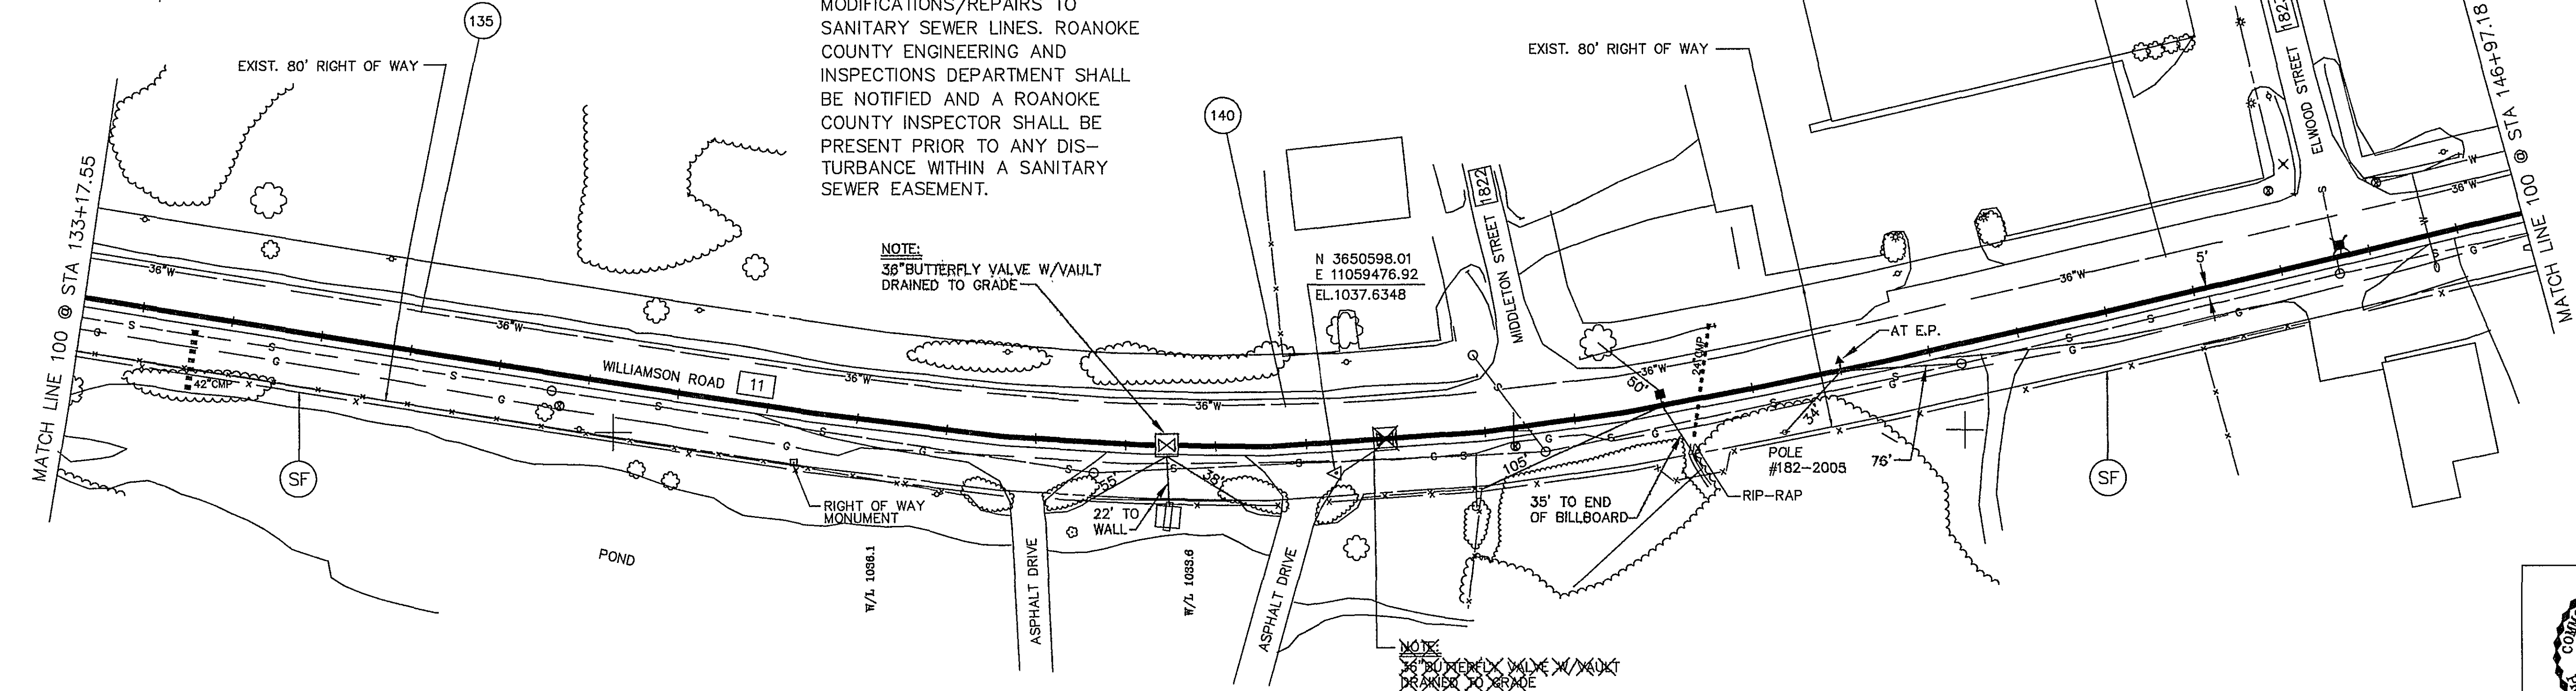


AS BUILT

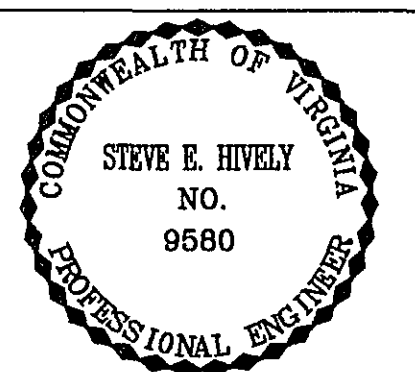

ENGINEER'S SEAL

PROFILE LINE 100

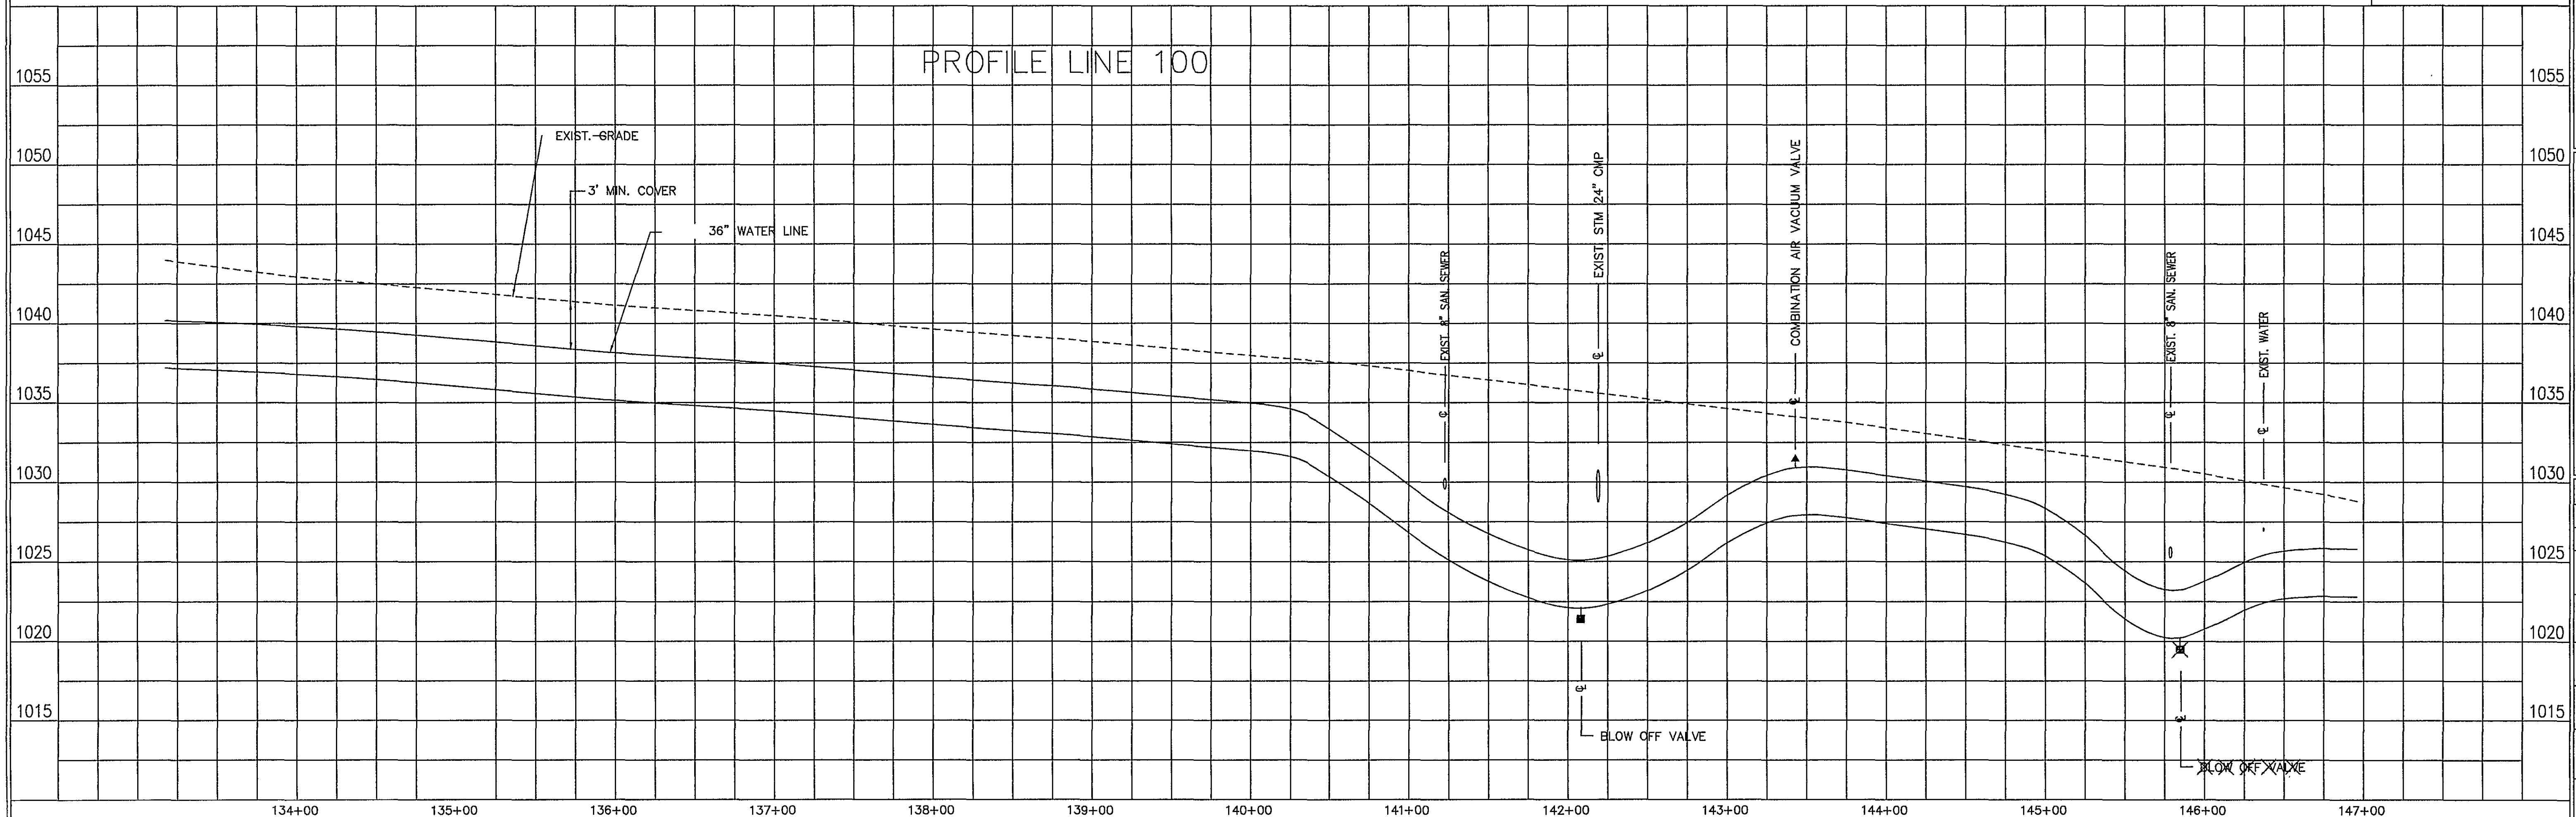

Architects
Engineers
Planners
Surveyors

Dewberry & Davis
5238 Valleypointe Parkway, Suite One-B
Roanoke, Virginia 24019
703 362-7725

Carvins Cove, Phase II
City of Roanoke
Roanoke, Virginia

CONTRACT "A-2"
LINE 100
STA 133+17.55 - 146+97.18

Drawn By REH/ACF
Designed By RBS
Checked By SEH
Date MARCH 1995
Scale V: 1" = 5'
H: 1" = 50'
Plan Number F11.DWG
Zoned NONE
Sheet 5 of 12
File Number C1160