


MATCH LINE 100 @ STA 160+39.22


THIS SHEET
1425 LF 36" WATERMAIN
2 EA. 8" BLOWOFF
1 EA. 2" A.R.V.
2 EA. 6" A.R.V.
1 EA. 36" BUTTERFLY VALVE

BROOKSIDE PAR 3 GOLF COURSE, INC.
D.B. 1341, PG. 1064
TAX MAP NO. 38.06-08-01
38.06-08-02

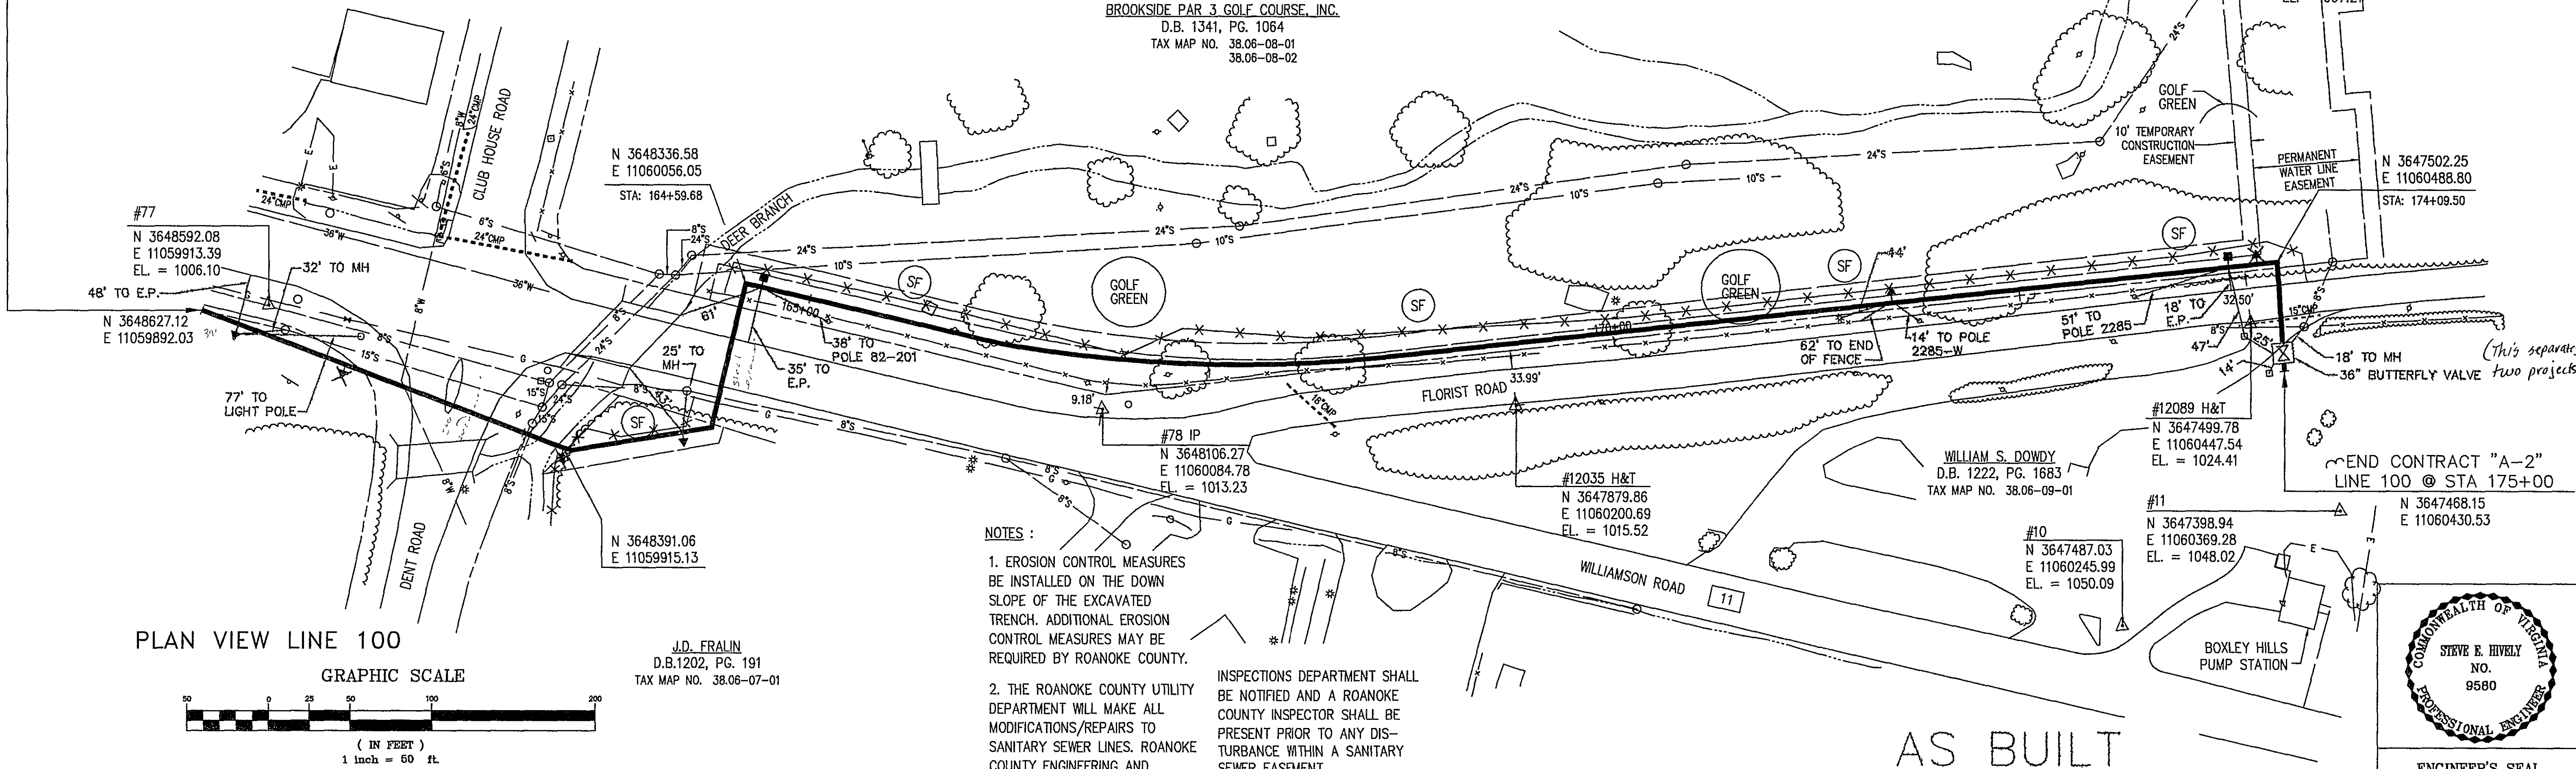

PLAN VIEW LINE 100

GRAPHIC SCALE

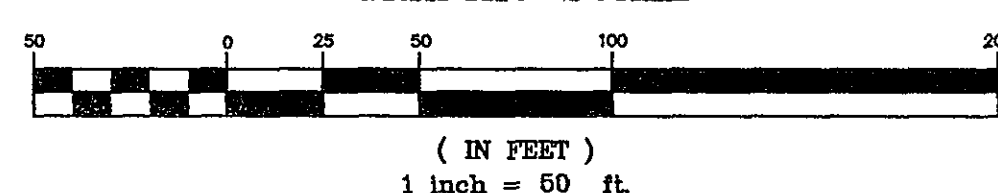


J.D. FRALIN
D.B.1202, PG. 191
TAX MAP NO. 38.06-07-01

NOTES :

1. EROSION CONTROL MEASURES BE INSTALLED ON THE DOWN SLOPE OF THE EXCAVATED TRENCH. ADDITIONAL EROSION CONTROL MEASURES MAY BE REQUIRED BY ROANOKE COUNTY.
2. THE ROANOKE COUNTY UTILITY DEPARTMENT WILL MAKE ALL MODIFICATIONS/REPAIRS TO SANITARY SEWER LINES. ROANOKE COUNTY ENGINEERING AND


INSPECTIONS DEPARTMENT SHALL BE NOTIFIED AND A ROANOKE COUNTY INSPECTOR SHALL BE PRESENT PRIOR TO ANY DISTURBANCE WITHIN A SANITARY SEWER EASEMENT.

AS BUILT

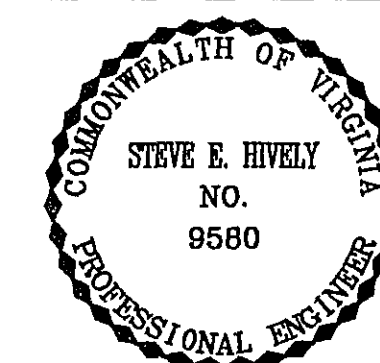

ENGINEER'S SEAL

PROFILE LINE 100

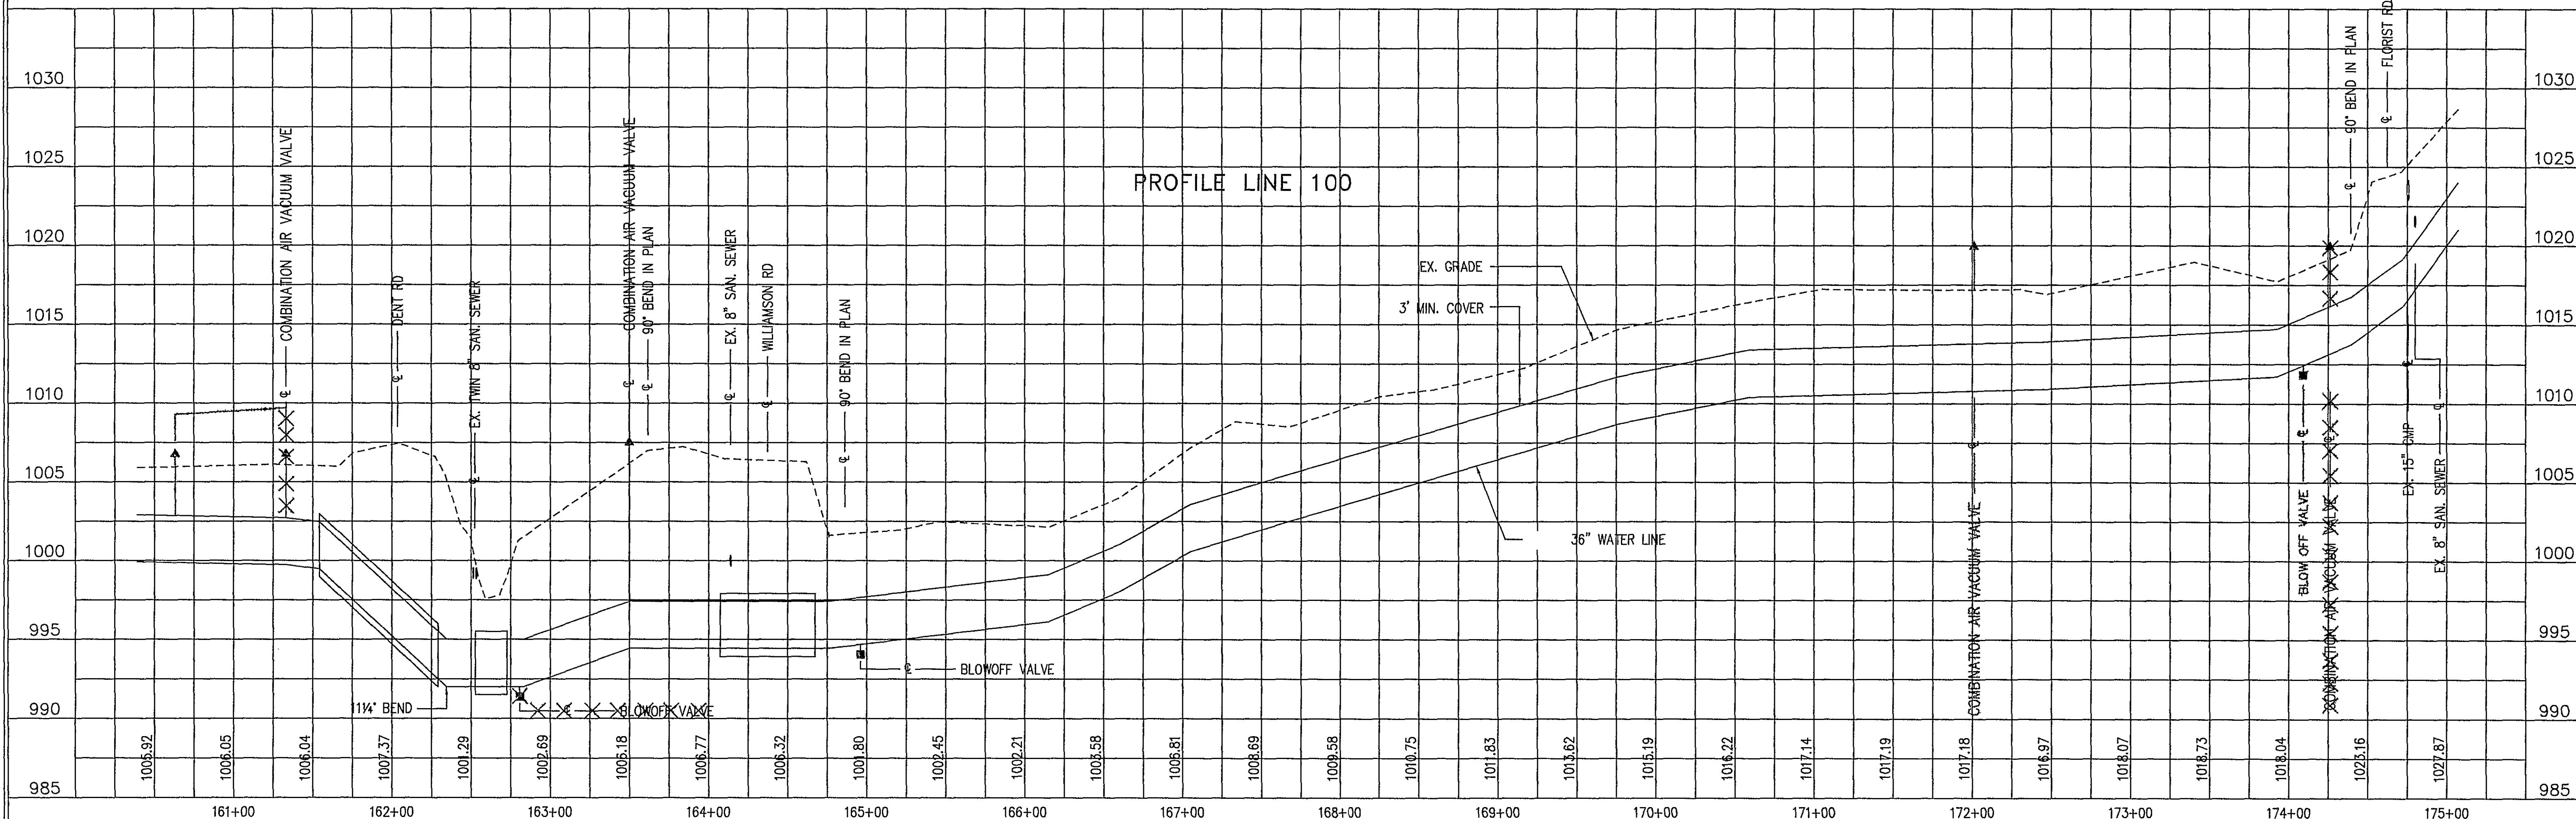

Architects
Engineers
Planners
Surveyors

Dewberry & Davis

5238 Valleypointe Parkway, Suite One-B
Roanoke, Virginia 24019
☎ 703 362-7725

Carvins Cove, Phase II

City of Roanoke
Roanoke, Virginia

CONTRACT "A-2"
LINE 100
STA 160+39.22 - 175+00

Drawn By ACF
Designed By
Checked By
Date SEPTEMBER 1994
Scale V: 1" = 5'
H: 1" = 50'
Plan Number F13REV1.DWG
Zoned NONE
Sheet 12 of 12
File Number C1160