


PROJECT LOCATION MAP

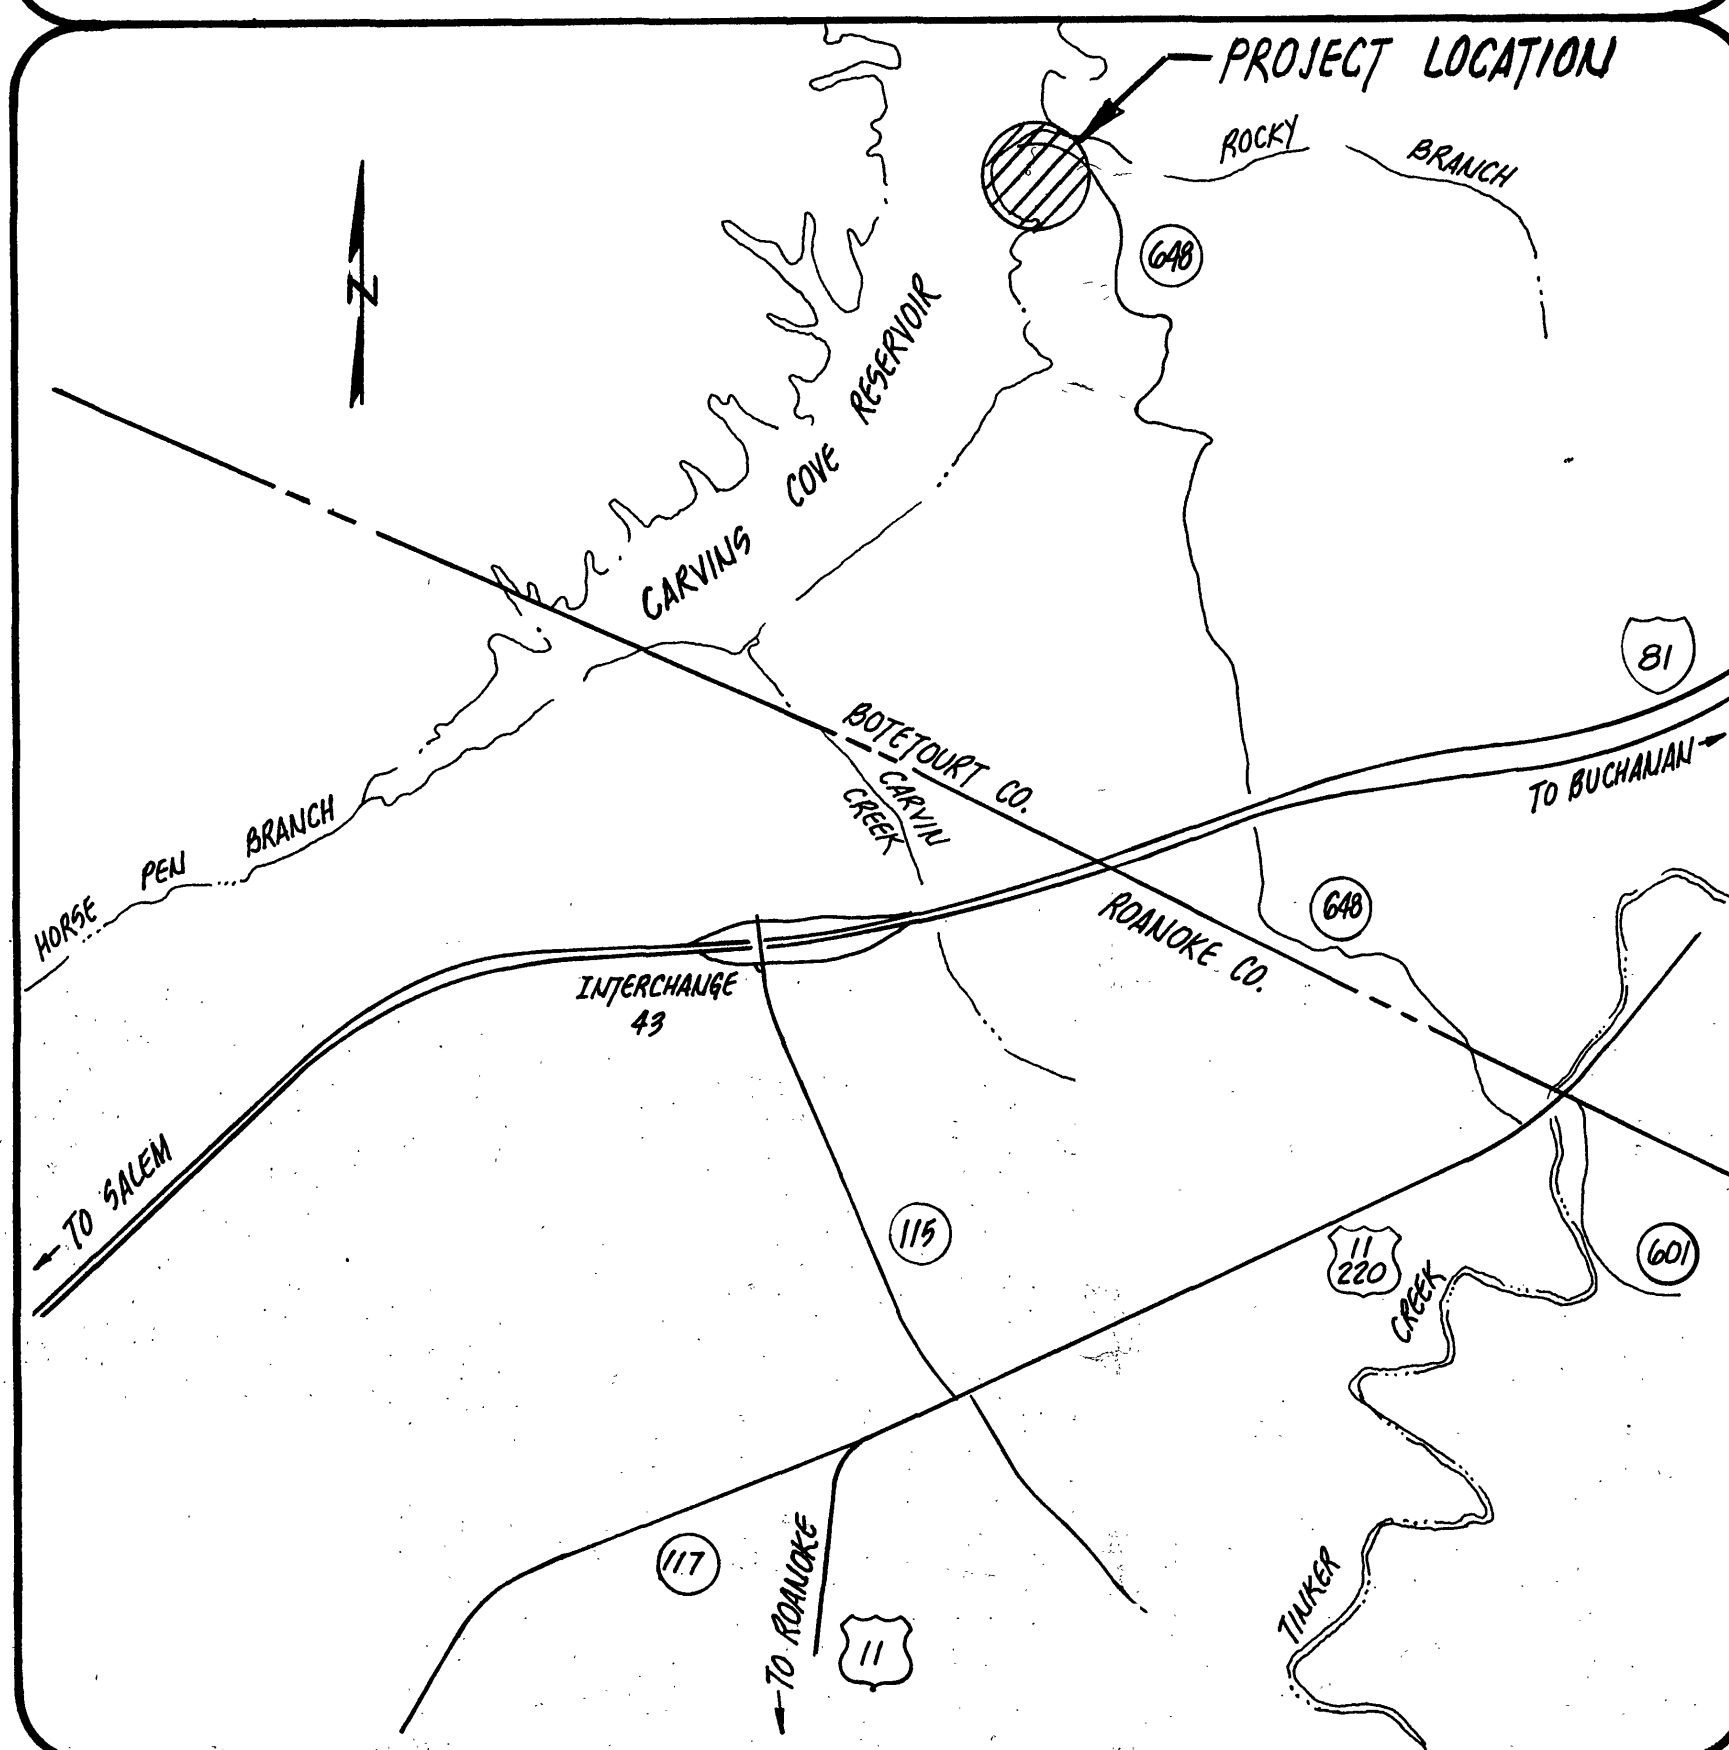

OFFICE OF CITY ENGINEER
ROOM 350
MUNICIPAL BUILDING
215 CHURCH AVENUE, S.W.
ROANOKE, VIRGINIA 24011

INDEX OF SHEETS

SHEET NO.	TITLE
1	TITLE SHEET
2	ABBREVIATIONS AND LEGEND
3	SITE PLAN
4	PIER DETAILS
A-1	FLOOR PLAN
A-2	ELEVATIONS / SECTIONS
A-3	EXTERIOR DETAILS
	ROOF FRAMING PLAN
P-1	PLUMBING
ME-1	MECHANICAL / ELECTRICAL

CONSULTING ENGINEERS

MATTERN AND CRAIG
CONSULTING ENGINEERS
707 SOUTH JEFFERSON STREET
SUITE 401
ROANOKE, VIRGINIA
24011

COMMISSION NUMBER: **COMM 480**

--	--	--

PROJECT NAME

**CARVINS COVE CONCESSION STAND
AND PIER**

PROJECT NUMBER: **84-11**

REVISION	BY	DESCRIPTION:	DATE
REVISION	BY	DESCRIPTION:	DATE
REVISION	BY	DESCRIPTION:	DATE
REVISION	BY	DESCRIPTION:	DATE

APPROVED FOR CONSTRUCTION

ROANOKE CITY ENGINEER	DATE
DIRECTOR OF PUBLIC WORKS	DATE
DIRECTOR OF UTILITIES AND OPERATIONS	DATE
	DATE
	DATE

ADVERTISED DATE: **10/27/85**

SET NUMBER: **4**

SHEET NUMBER: **1** OF **4**

As Advertised

84-11