
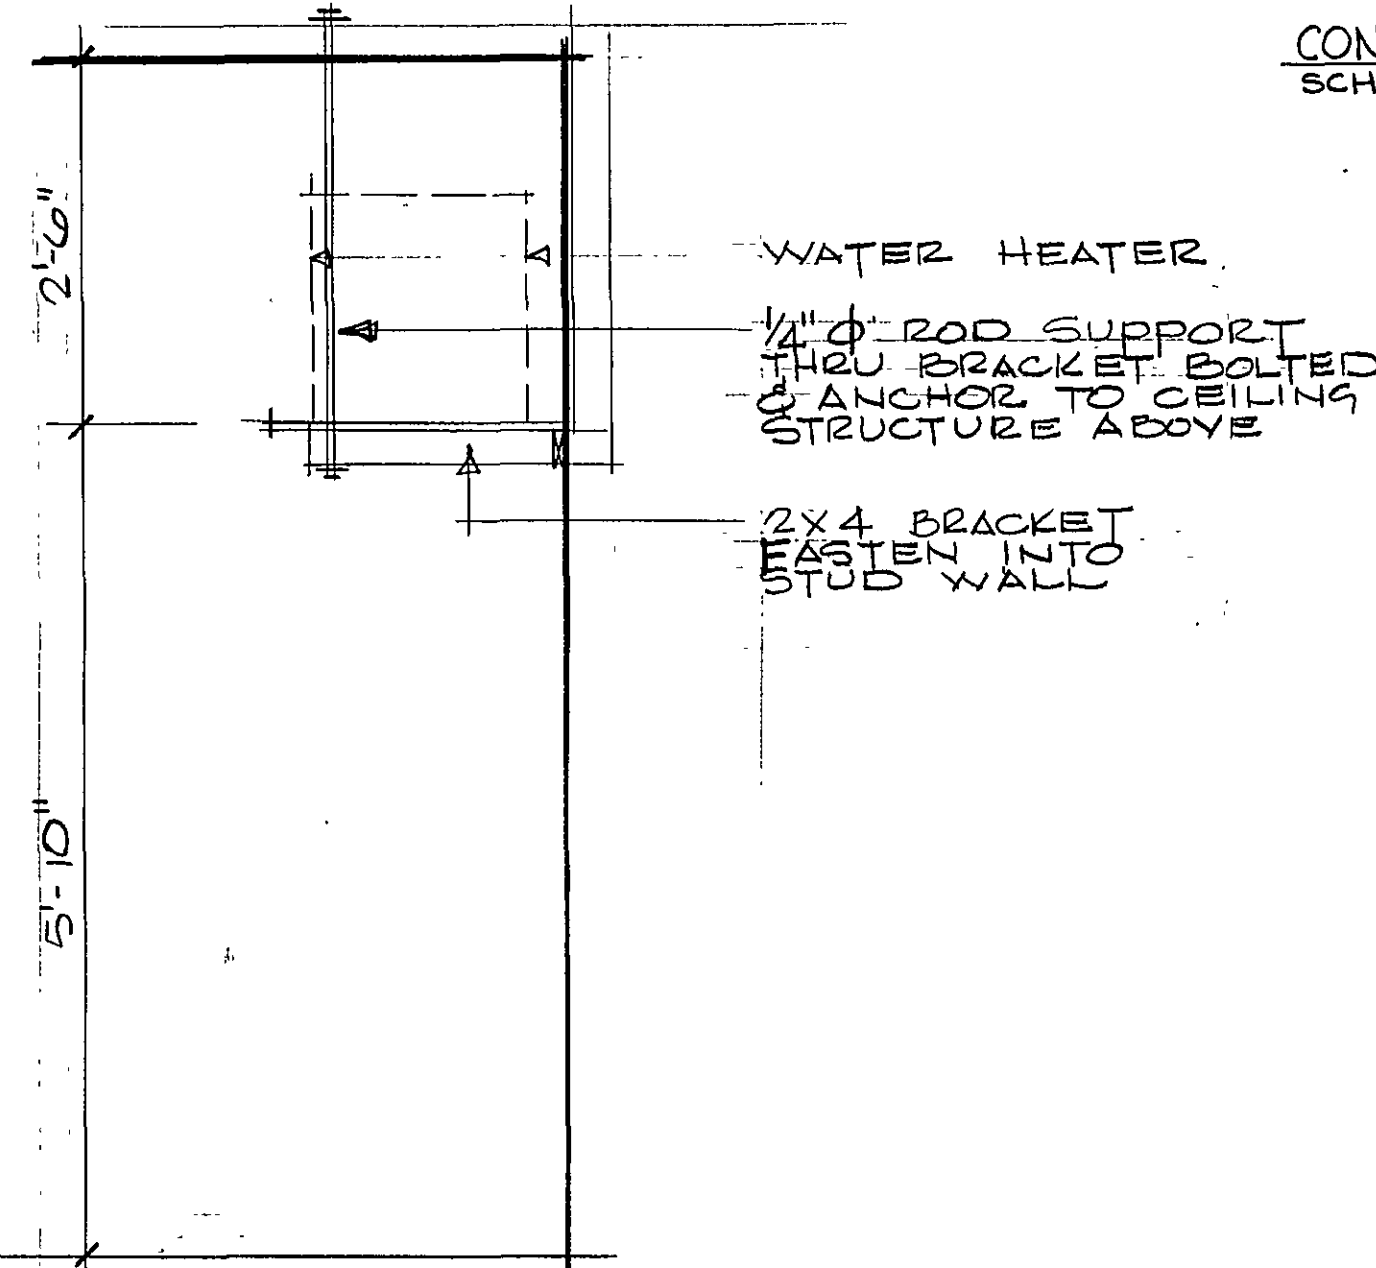



GENERAL NOTES

1. ALL TRAPS ARE TO COMPLY WITH UNIFORM VIRGINIA STATEWIDE BUILDING CODE.
2. MAKE PROPER H&C, W, V, ETC. PIPING CONNECTIONS TO ALL FIXTURES AND EQUIPMENT EVEN THOUGH ALL BRANCH MAINS, ELBOWS AND CONNECTIONS ARE NOT SHOWN.
3. SEE SITE PLAN FOR THE EXTENT OF ALL PIPING LEAVING AND ENTERING BUILDING.
4. SLOPES AND INVERT ELEVATIONS OF SANITARY SEWER, ETC. SHALL BE ESTABLISHED AND VERIFIED BY CONTRACTOR BEFORE ANY PIPING IS INSTALLED IN ORDER THAT PROPER SLOPES WILL BE MAINTAINED AND NECESSARY INVERT ELEVATIONS OBTAINED.
5. PROVIDE 20" LONG X 4" WIDE X 1/8" THICK STEEL PLATES FOR HOLDING SUPPORTING BOLTS FOR WALL HANGERS ON LAVATORIES. PLATE TO BE INSTALLED IN WALL CONSTRUCTION BEHIND FIXTURES.
6. UNLESS OTHERWISE NOTED, ALL SANITARY PIPING IS LOCATED BELOW THE FLOOR. DOMESTIC WATER PIPING AND VENT PIPING IS LOCATED ABOVE THE CEILING.
7. ALL WATER PIPING INSTALLED ABOVE THE CEILING SHALL BE INSTALLED BELOW THE INSULATION. INSULATION MUST BE SOLID, WITH NO OPENINGS OR GAPS.
8. SEE ARCHITECTURAL ELEVATIONS FOR MOUNTING HEIGHTS OF FIXTURES.
9. PROVIDE ACCESS PANELS FOR ALL VALVES LOCATED ABOVE CEILINGS.
10. CONCEAL ALL PIPING IN FINISHED AREAS ABOVE CEILINGS OR IN WALLS.
11. ALL VENTS SHALL SLOPE BACK TO WASTE PIPE.
12. MAKE 1" CW CONNECTIONS TO WATER CLOSETS, 1/2" CW TO ELECTRIC WATER COOLER, 1/2" H & CW TO LAV'S AND SINKS.


LEGEND & ABBREVIATIONS	
COLD WATER	_____
HOT WATER	_____
SANITARY SEWER	_____
VENT	_____
GATE VALVE (PLAN)	⌵
GATE VALVE (VERTICAL)	⌵
FLOOR DRAIN W/ TRAP	⊙
ELBOW DOWN	⌒
ELBOW UP	⌒
CLEANOUT	⊙
DIRECTION OF SLOPE	—>
AD-ACCESS DOOR	W-WASTE
CO-CLEANOUT	WH-WALL HYDRANT
CW-COLD WATER	V-VENT
FD-FLOOR DRAIN	VTR-VENT THRU ROOF
HB-HOSE BIBB	
HW-HOT WATER	
P&T-PRESSURE & TEMPERATURE	

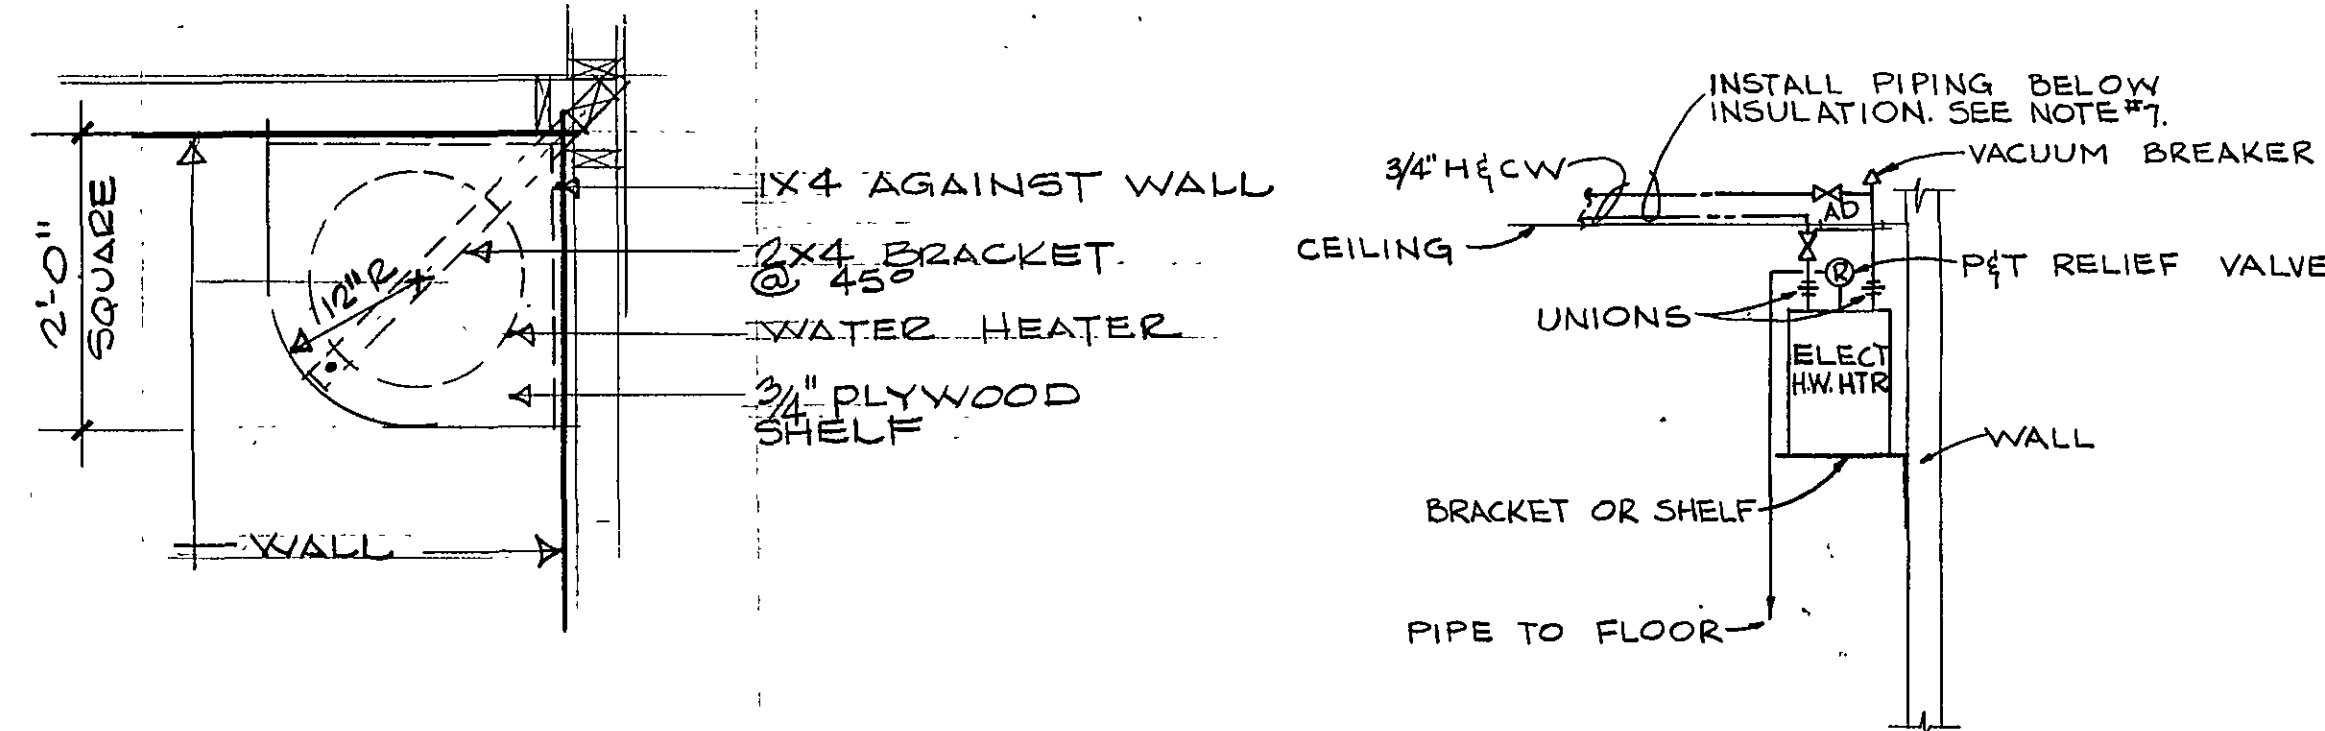

WATER HEATER SHELF
3/4" = 1'-0"

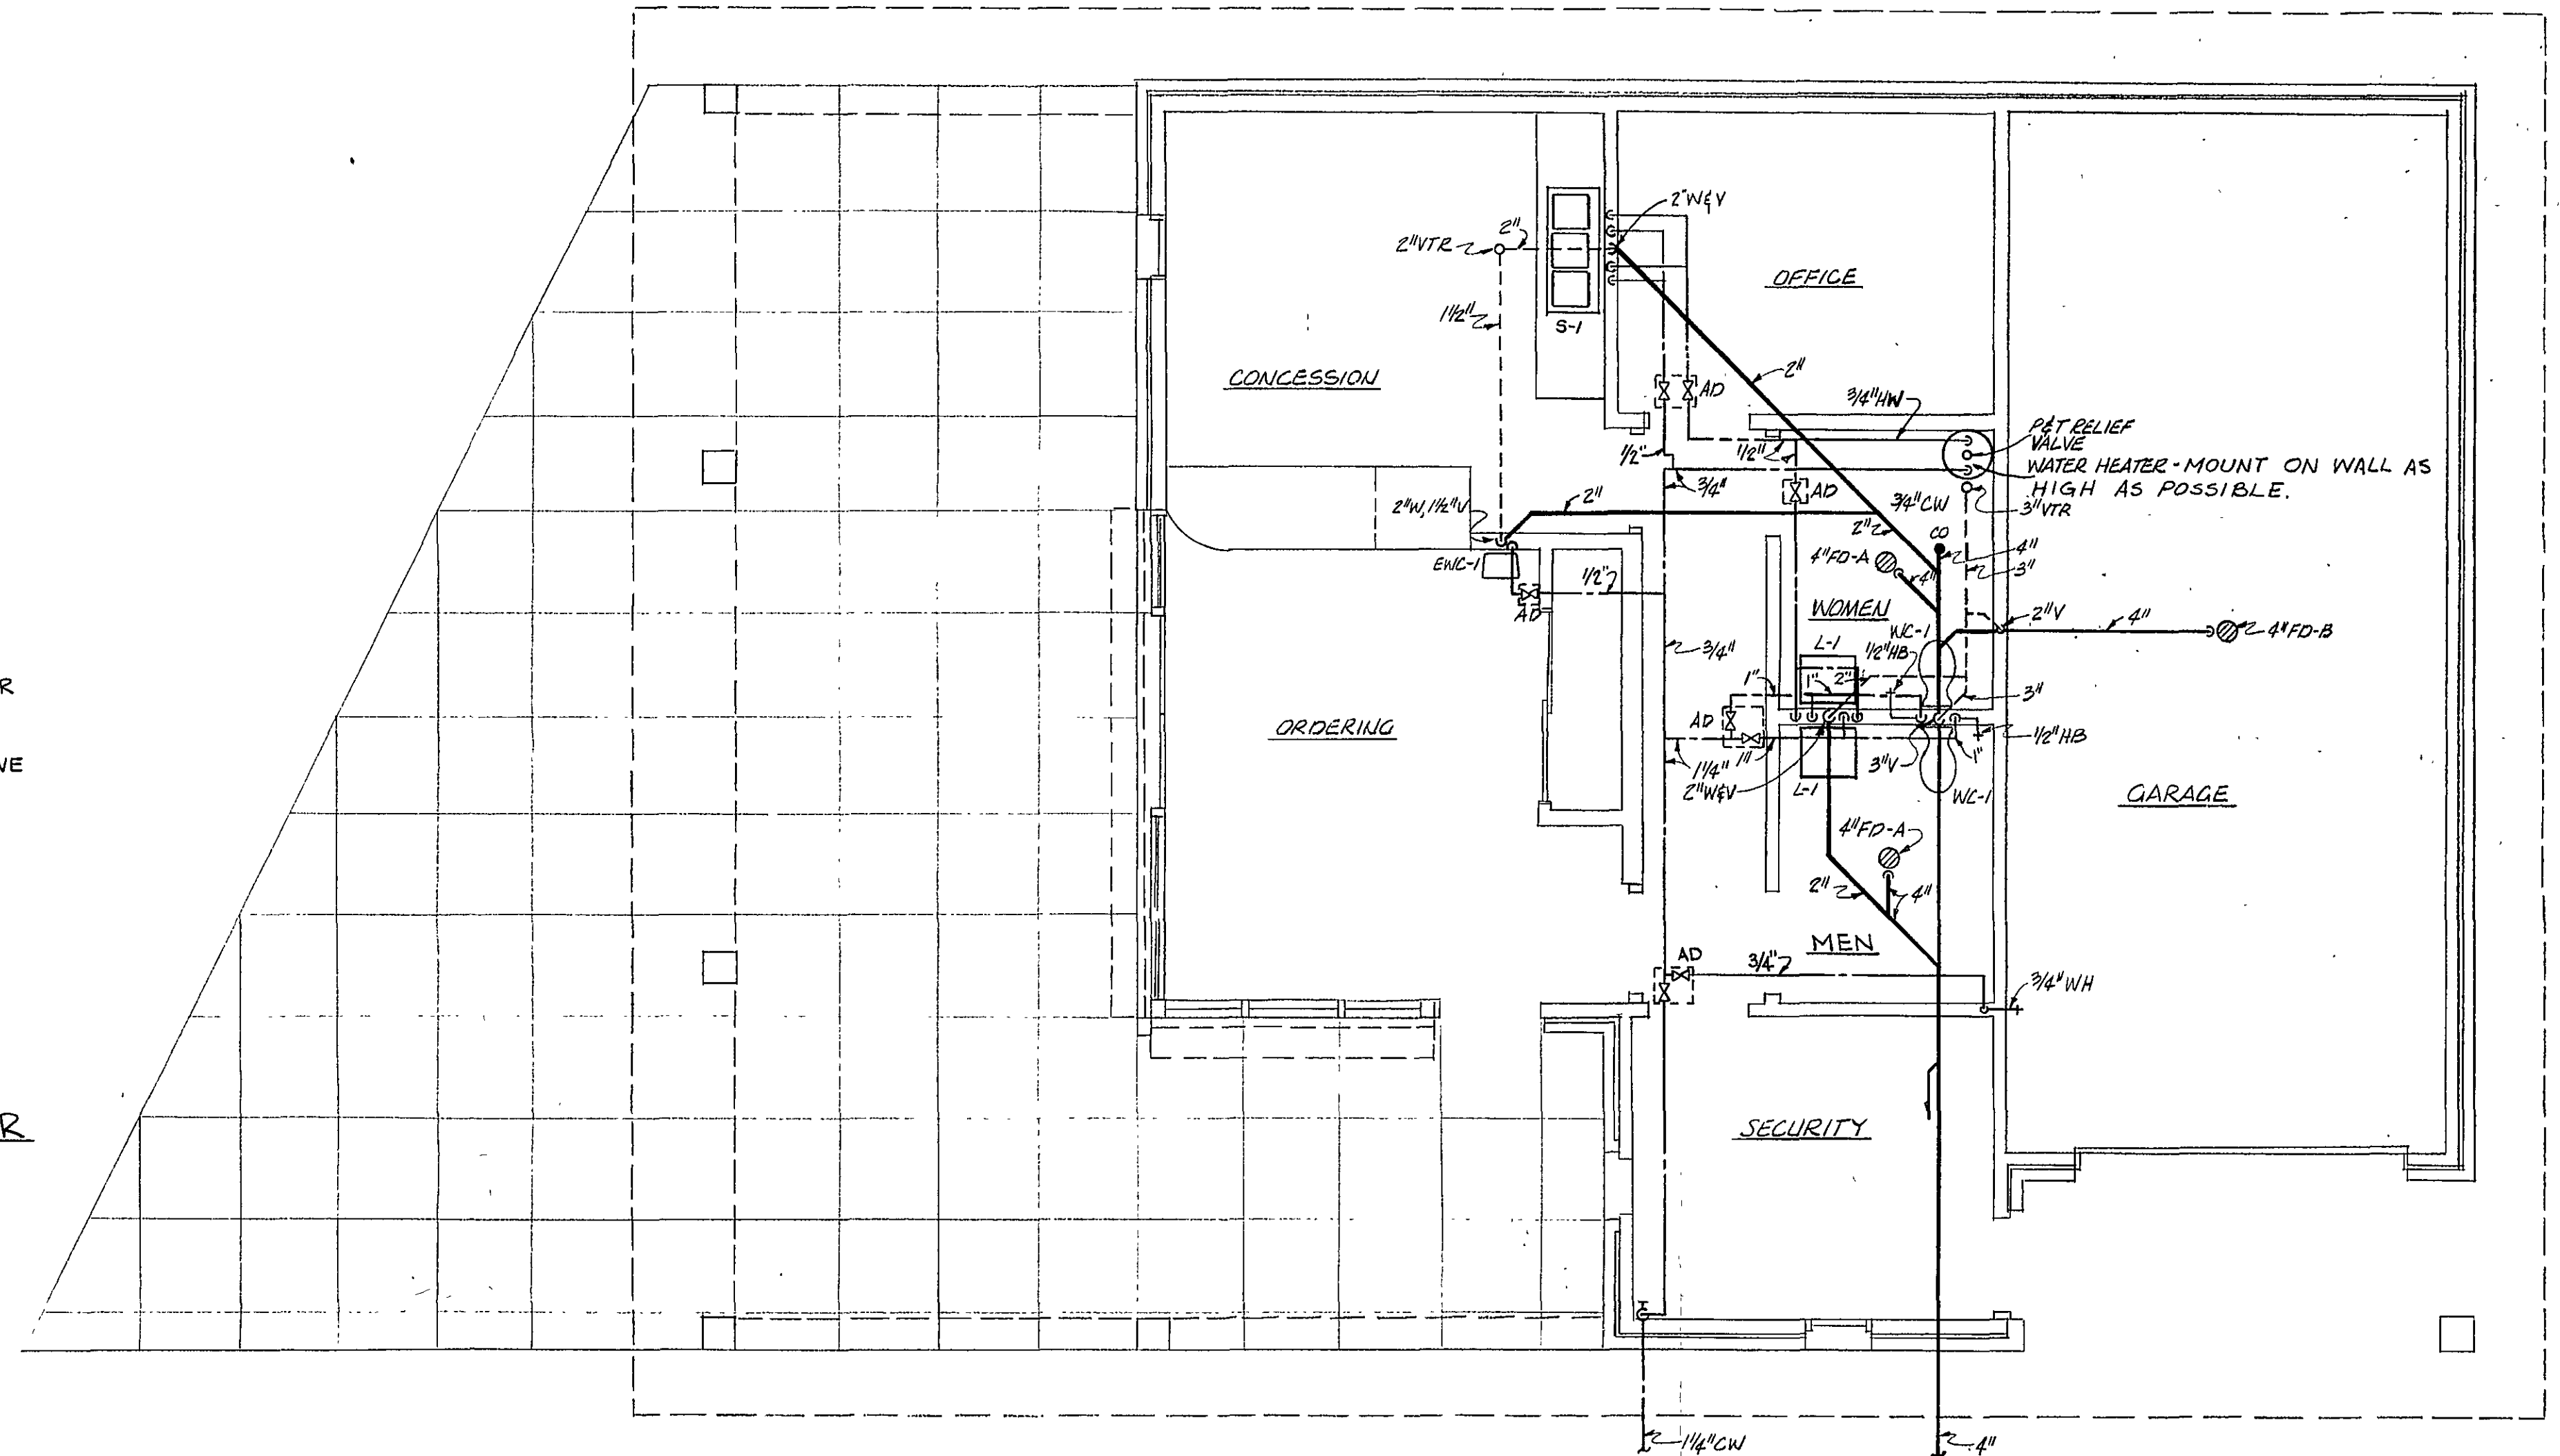

FLOOR PLAN
SCALE: 1/4" = 1'-0"

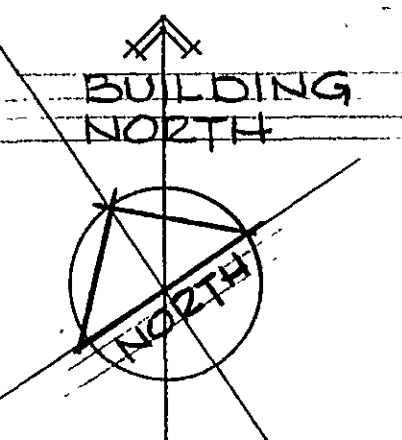

REVISION	DATE	DESCRIPTION	BY	APP.
DESIGNED RNM		CARVINS COVE		
DRAWN RAM/RNM		CONCESSION STAND AND PIER		
CHECKED RNM		PLUMBING		
APPROVED				
SUBMITTED				
Mattern & Craig		SCALE: 1/4" = 1'-0"	DATE:	SHEET P-1
CONSULTING ENGINEERS				