


1. ONE SWITCH SHALL CONTROL FAN AND OTHER SWITCH SHALL CONTROL FAN LIGHTS.
2. FAN/LIGHT FIXTURE SHALL BE FURNISHED BY GENL. CONTR. ELEC. SUBCONTR. SHALL MAKE ALL NECESSARY CONNECTIONS COMPLETE.
3. WEATHERPROOF RECEPTACLE W/JOE, MOUNT 48" ABOVE FIN. FLOOR.
4. 2P, 30A NONFUSIBLE DISC. SW. MTD ADJACENT TO WATER HEATER.
5. NOT USED
6. 3/4" EMPTY CONDUIT FROM PANEL 'A' STUBBED FLUSH WITH FLOOR. PROVIDE FLUSH THREADED PLUG.
7. SEE SITE PLAN SHEET C-4 FOR ADDITIONAL ELECTRICAL WORK.
8. PROVIDE STANDARD SWITCH BOX FOR TELEPHONES. BUILDING WILL BE PREWIRED BY TELEPHONE CO.
9. TIME CLOCK FLUSH MTD AT 5'-0" ABOVE FLOOR. TO CONTROL CIRCUIT A-21 CLOCK SHALL HAVE ASTRO DIAL AND DRST CONTACTS WITH 120V CLOCK MOTOR.
10. RECEPTACLE SHALL BE NEMA 6-50.

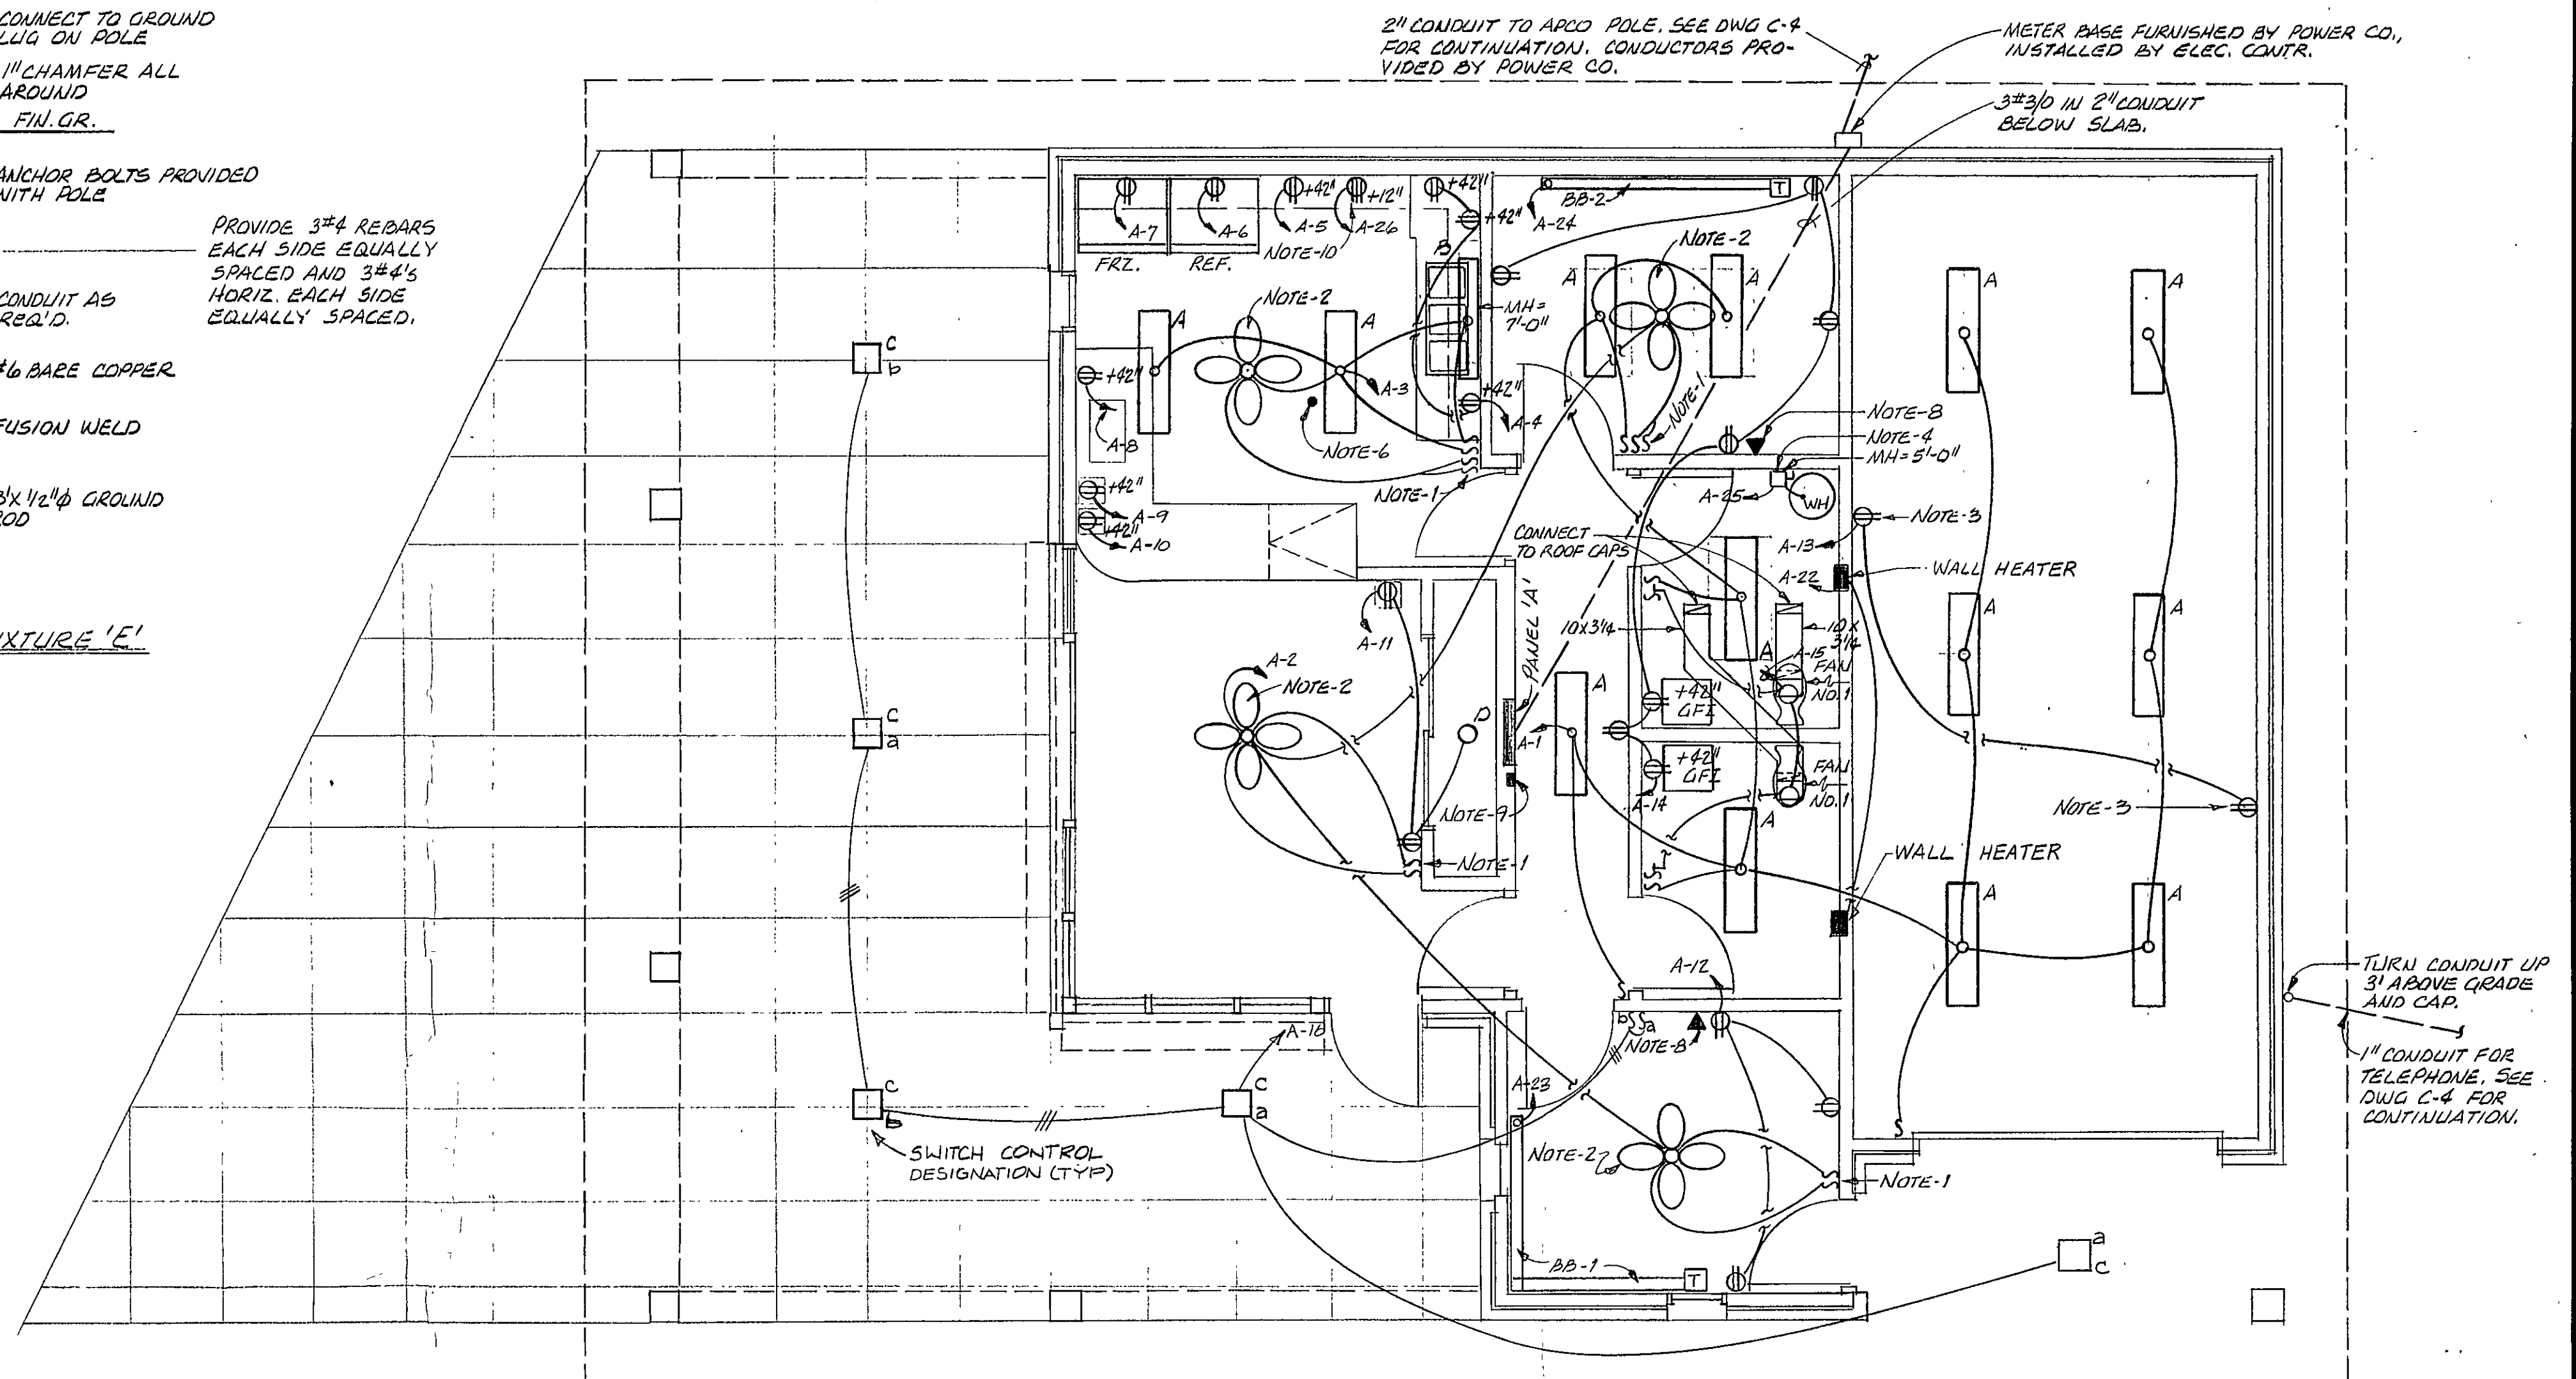

FIXTURE SCHEDULE				
TYPE	MANUFACTURER & CATALOG NUMBER	LAMP TYPE	VOLTS	REMARKS
A	GUTH NO. ACR6780 OR APPD EQUAL	2-F40	120	
B	GUTH NO. AP46713 OR APPD EQUAL	2-F40	↓	
C	MOLDCAST NO. 2345-A-70-120-LE	70W HPS		OR APPD EQUAL
D	P45 33-WL OR APPD EQUAL	150W INCANDESCENT		
E	MOLDCAST MT-2-3-40-24-1-0-0-BZ	400W HPS	240	SEE NOTE BELOW.

REVISION	DATE	DESCRIPTION			BY APP.
DESIGNED	RAM	<u>CARVINS COVE</u> <u>CONCESSION STAND AND PIER</u> <u>MECHANICAL/ELECTRICAL</u>			
DRAWN	RAM				
CHECKED	WDC				
APPROVED					
SUBMITTED					
 Mattern & Craig CONSULTING ENGINEERS		SCALE: 1/4" = 1'-0"			
		DATE:	SHEET ME-1		