



THE ENGINEER AND/OR SURVEYOR TAKES NO RESPONSIBILITY FOR THE LOCATION OR ACCURACY OF THE UTILITIES AS SHOWN HEREON OR ANY UTILITIES WITHIN THE PROJECT THAT MAY NOT BE SHOWN HEREON. THE CONTRACTOR SHALL BE RESPONSIBLE FOR CONTACTING THE UTILITY COMPANIES TO SEE IF ANY UTILITIES EXIST WITHIN THE AREA OF THE PROJECT BEFORE ANY CONSTRUCTION BEGINS. ANY COSTS INCURRED BY DAMAGING ANY UTILITY WITHIN THE PROJECT SHALL BE AT THE EXPENSE OF THE CONTRACTOR.

PLAN
SHEET 2 OF 4
DATE 6-23-86
BY WMB
CHECKED ESE

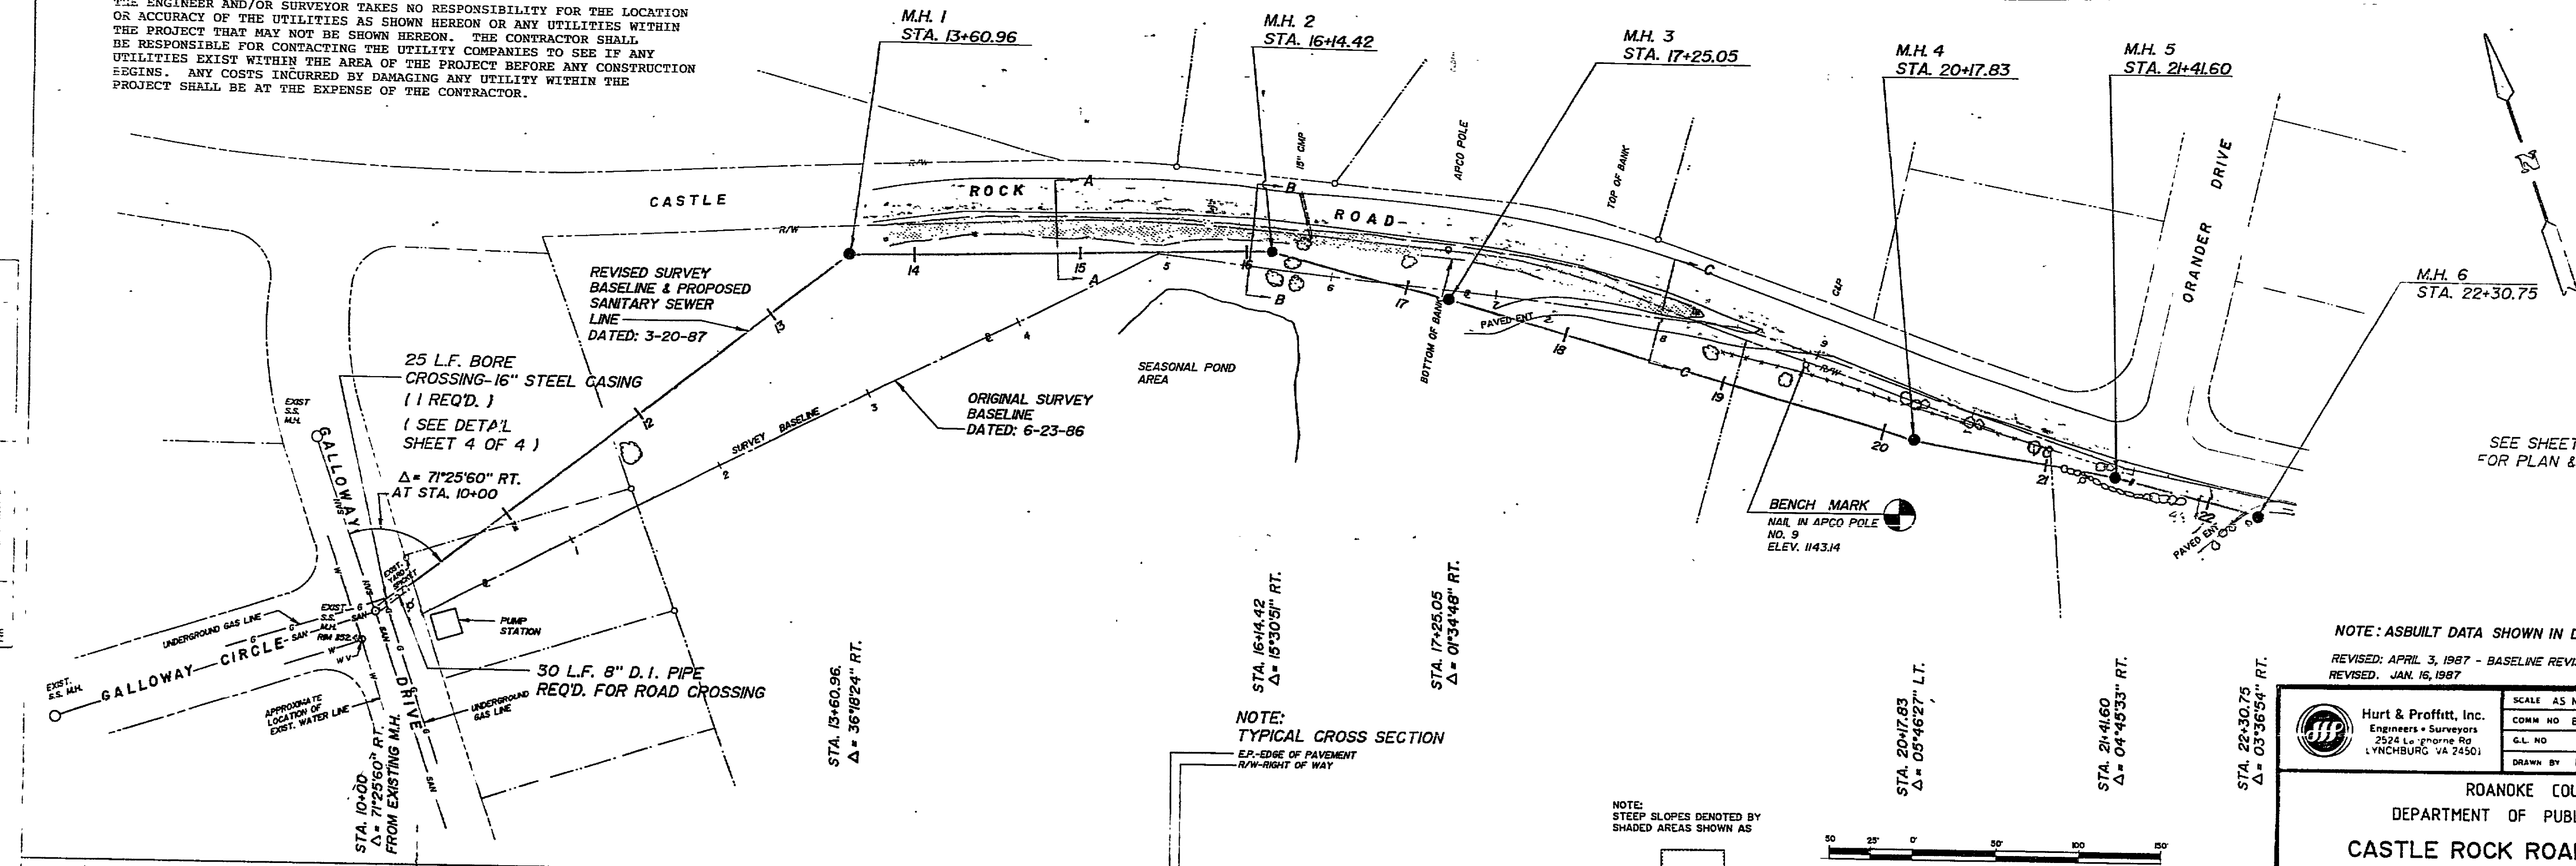

SEE SHEET 3 OF 4
FOR PLAN & PROFILE

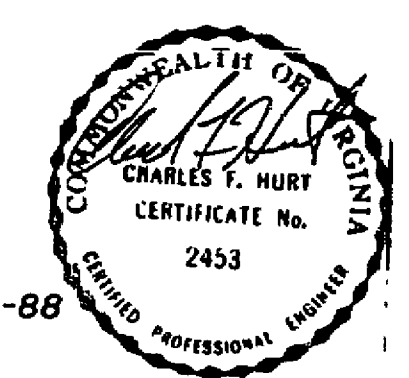

NOTE: ASBUILT DATA SHOWN IN C.I. 9-9-88
 REVISED: APRIL 3, 1987 - BASELINE REVISED
 REVISED: JAN. 16, 1987

Hurt & Proffitt, Inc. Engineers & Surveyors 2524 Lehigh Rd. LYNCHBURG, VA 24501	SCALE AS NOTED	DATE 6-23-86
	COMM NO. 86834	DESIGN BY WMB
	C.I. NO.	FILE NO. C-974
	DRAWN BY RVL	CHECKED BY ESE

ROANOKE COUNTY
 DEPARTMENT OF PUBLIC FACILITIES
CASTLE ROCK ROAD SEWER LINE

PROFILE
SHEET 2 OF 4
DATE 6-23-86
BY WMB
CHECKED ESE

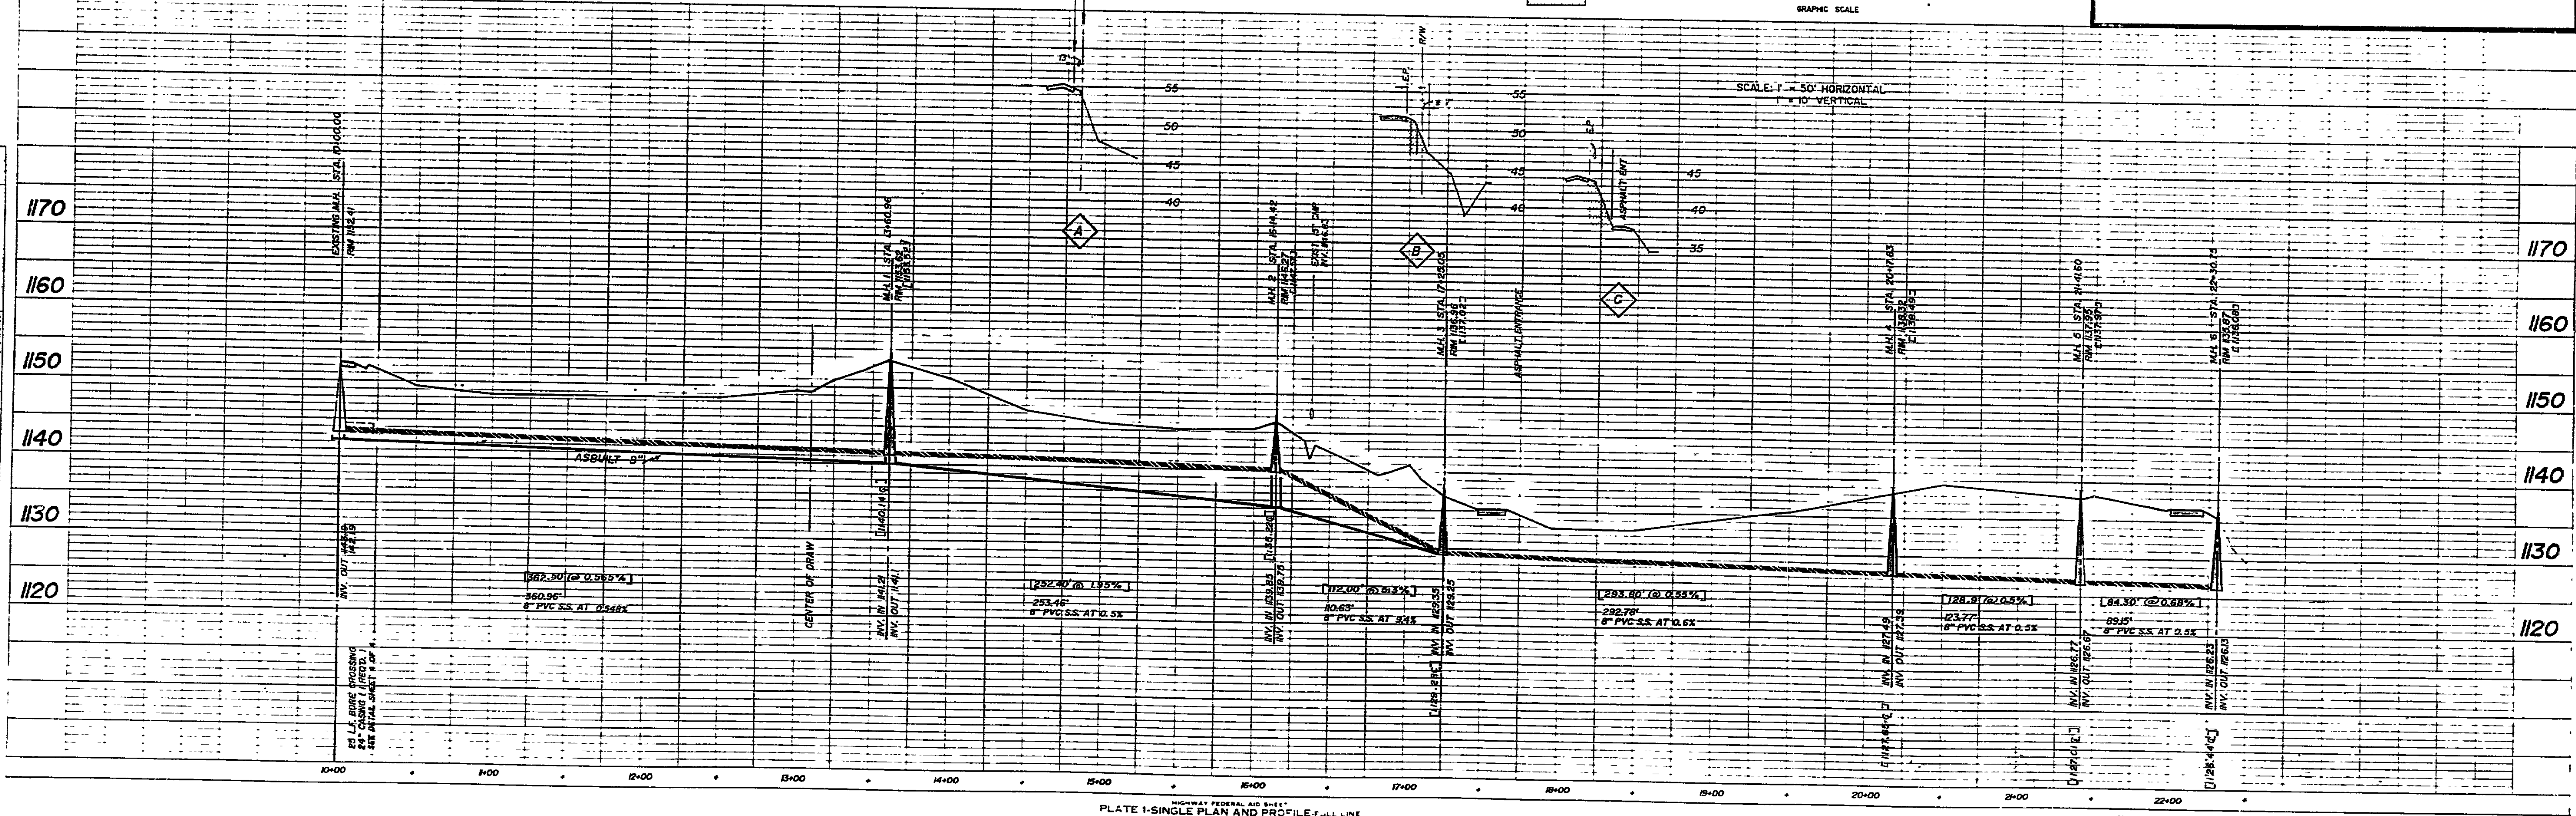


PLATE 1-SINGLE PLAN AND PROFILE FULL LINE
 PRINTED IN U.S.A.

