
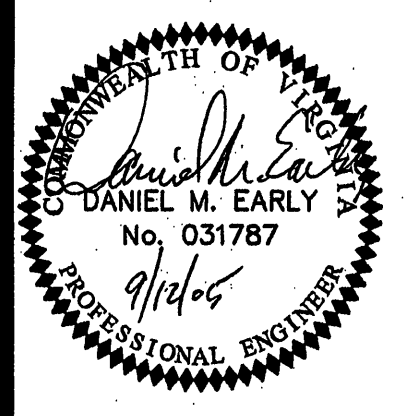
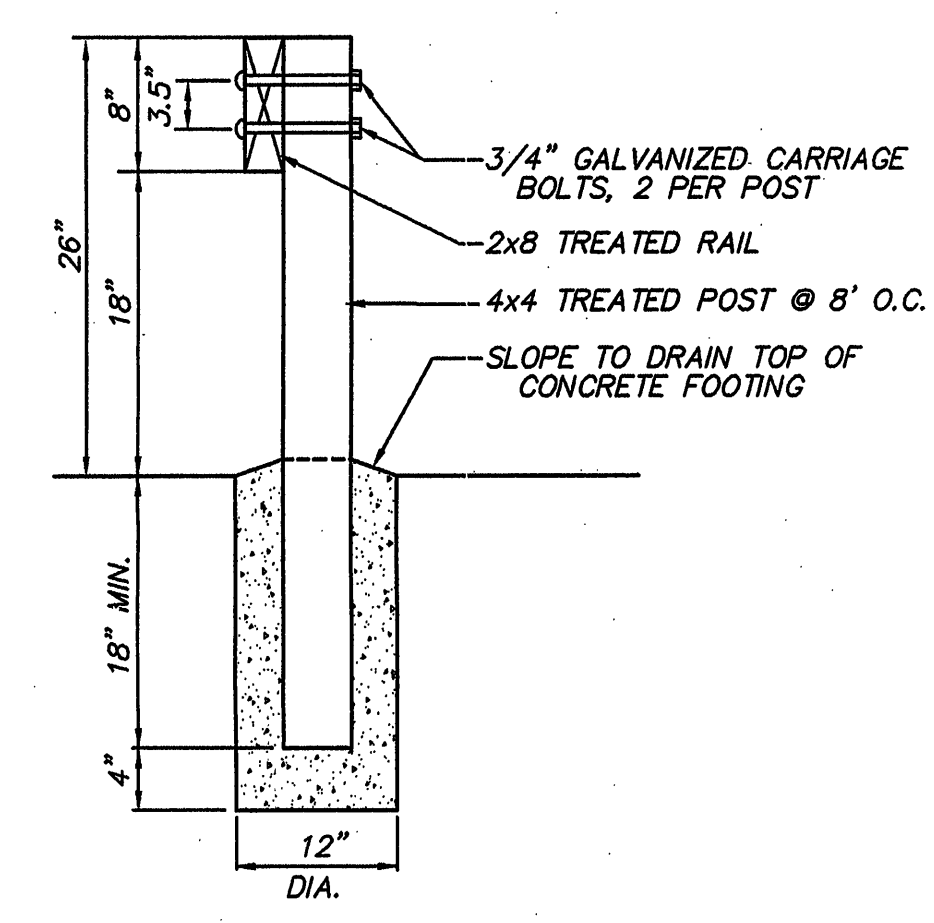
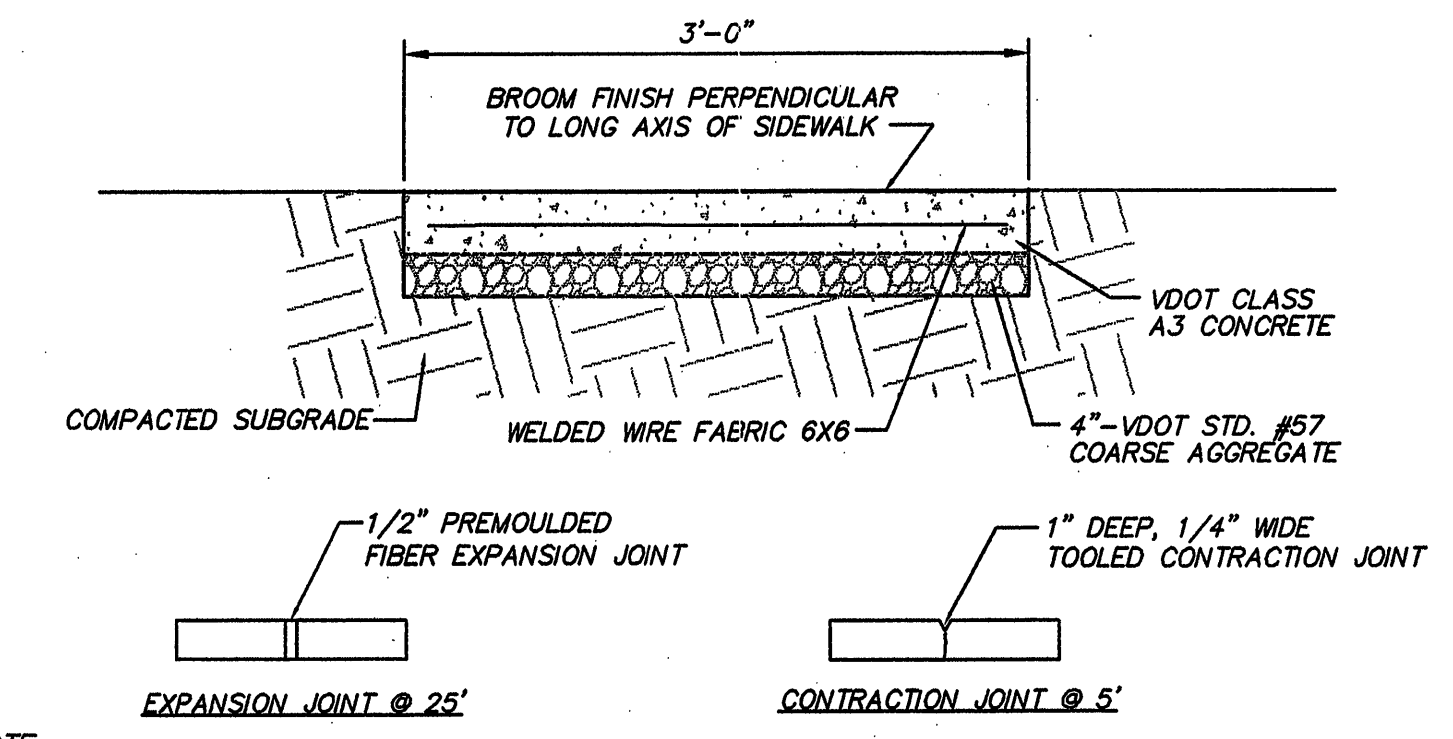
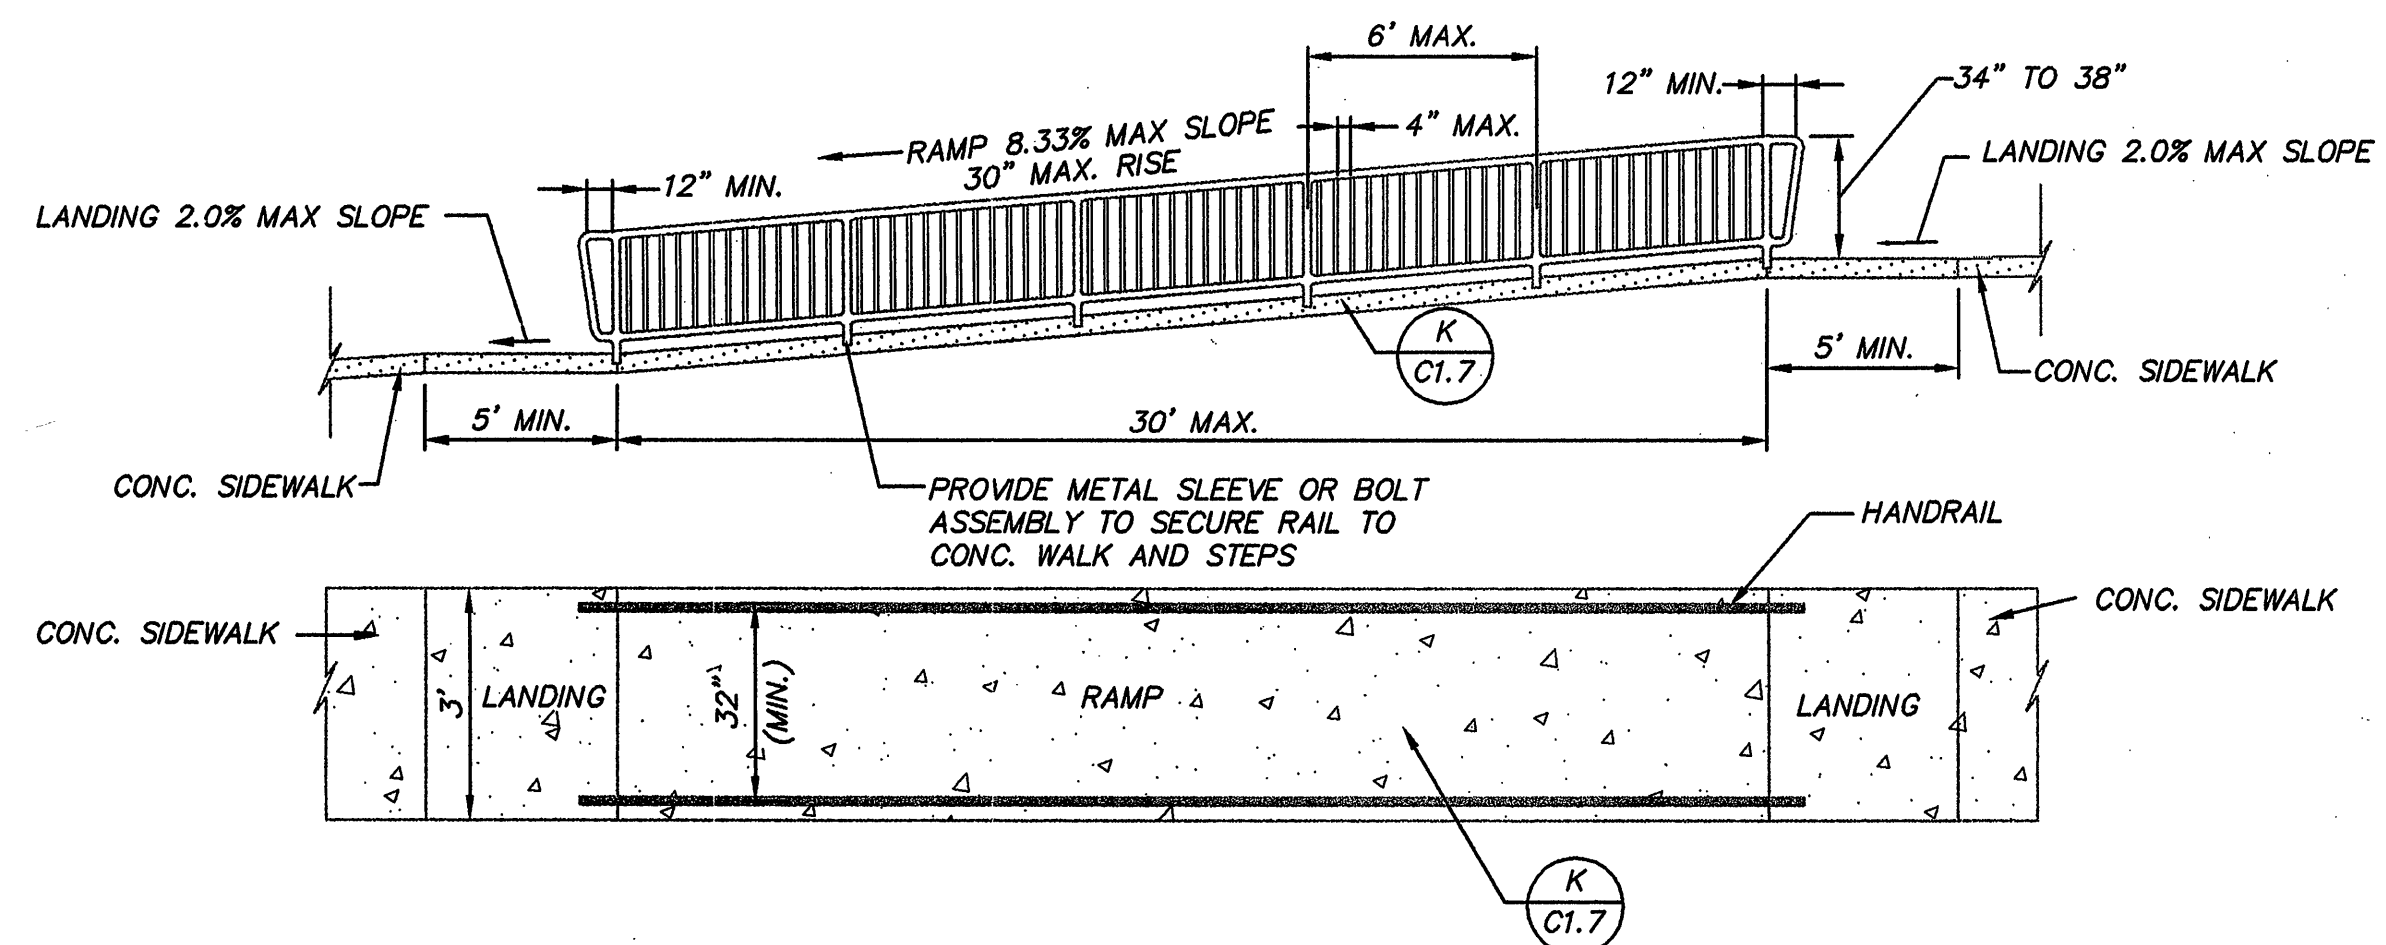
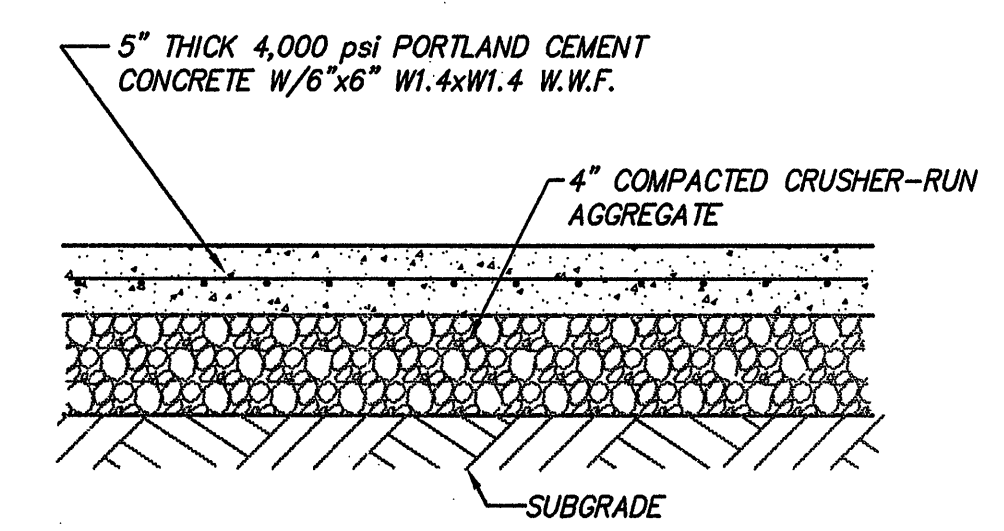


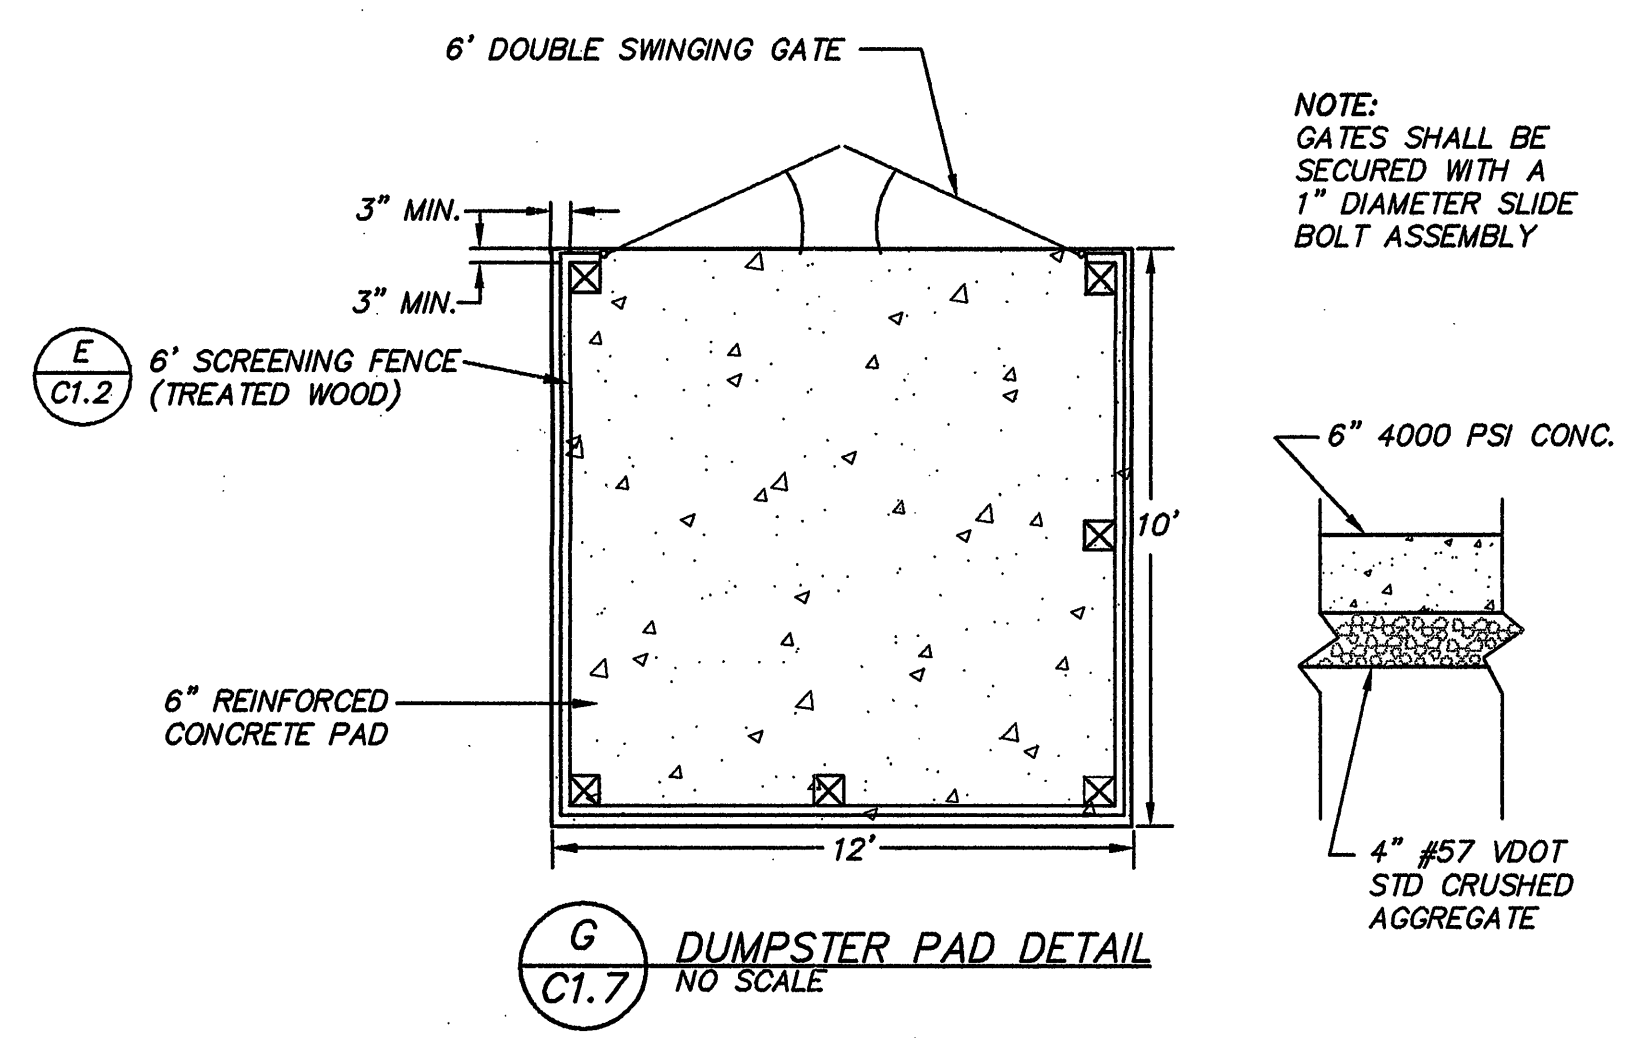

ACS DESIGN

Engineering-Planning-Surveying
Construction Management
2203 Peters Creek Road, NW
Roanoke, Virginia 24017
Phone: 540 562 2345
Fax: 540 562 2344
Email: info@acsdesignllc.com
www.acsdesignllc.com

**PHASE 2 SITE PLAN
FOR
CAVENESS PROPERTIES
ROANOKE COUNTY, VIRGINIA**

DRAWN BY: M.L.L.
DESIGNED BY: M.L.L.
CHECKED BY:
DATE: AUG. 1, 2005
SCALE: 1"=20'

REVISION	DATE	COMMENT

SHEET No.
C1.7
CONSTRUCTION DETAILS
JOB No. 05004