

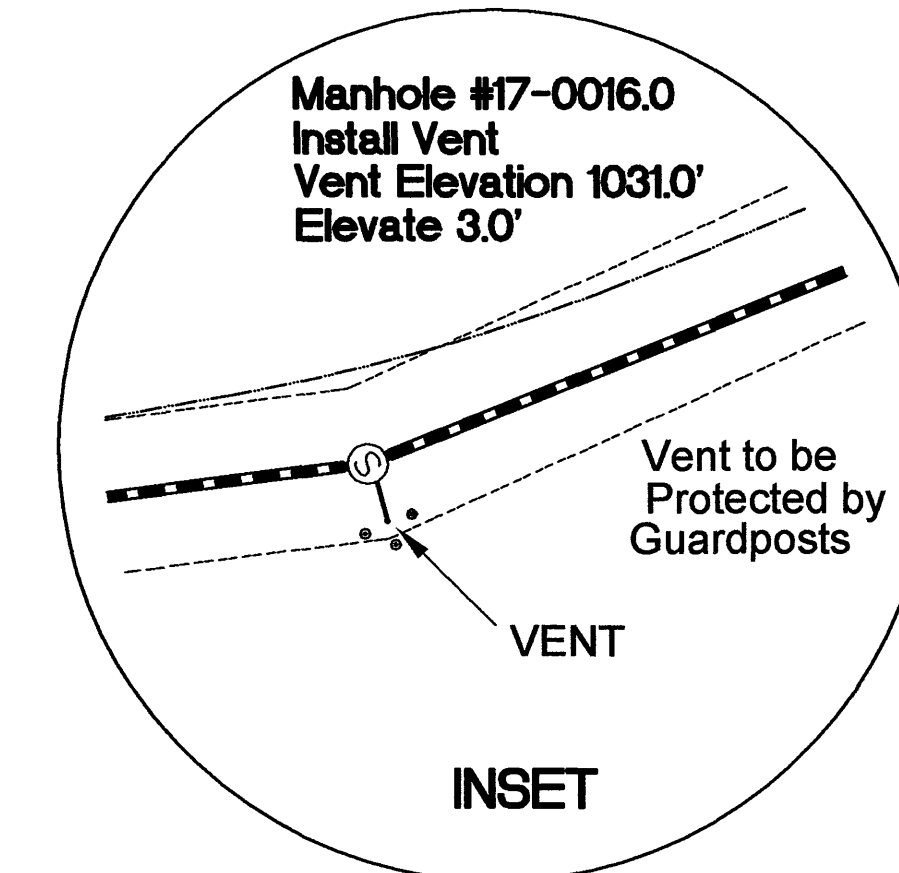


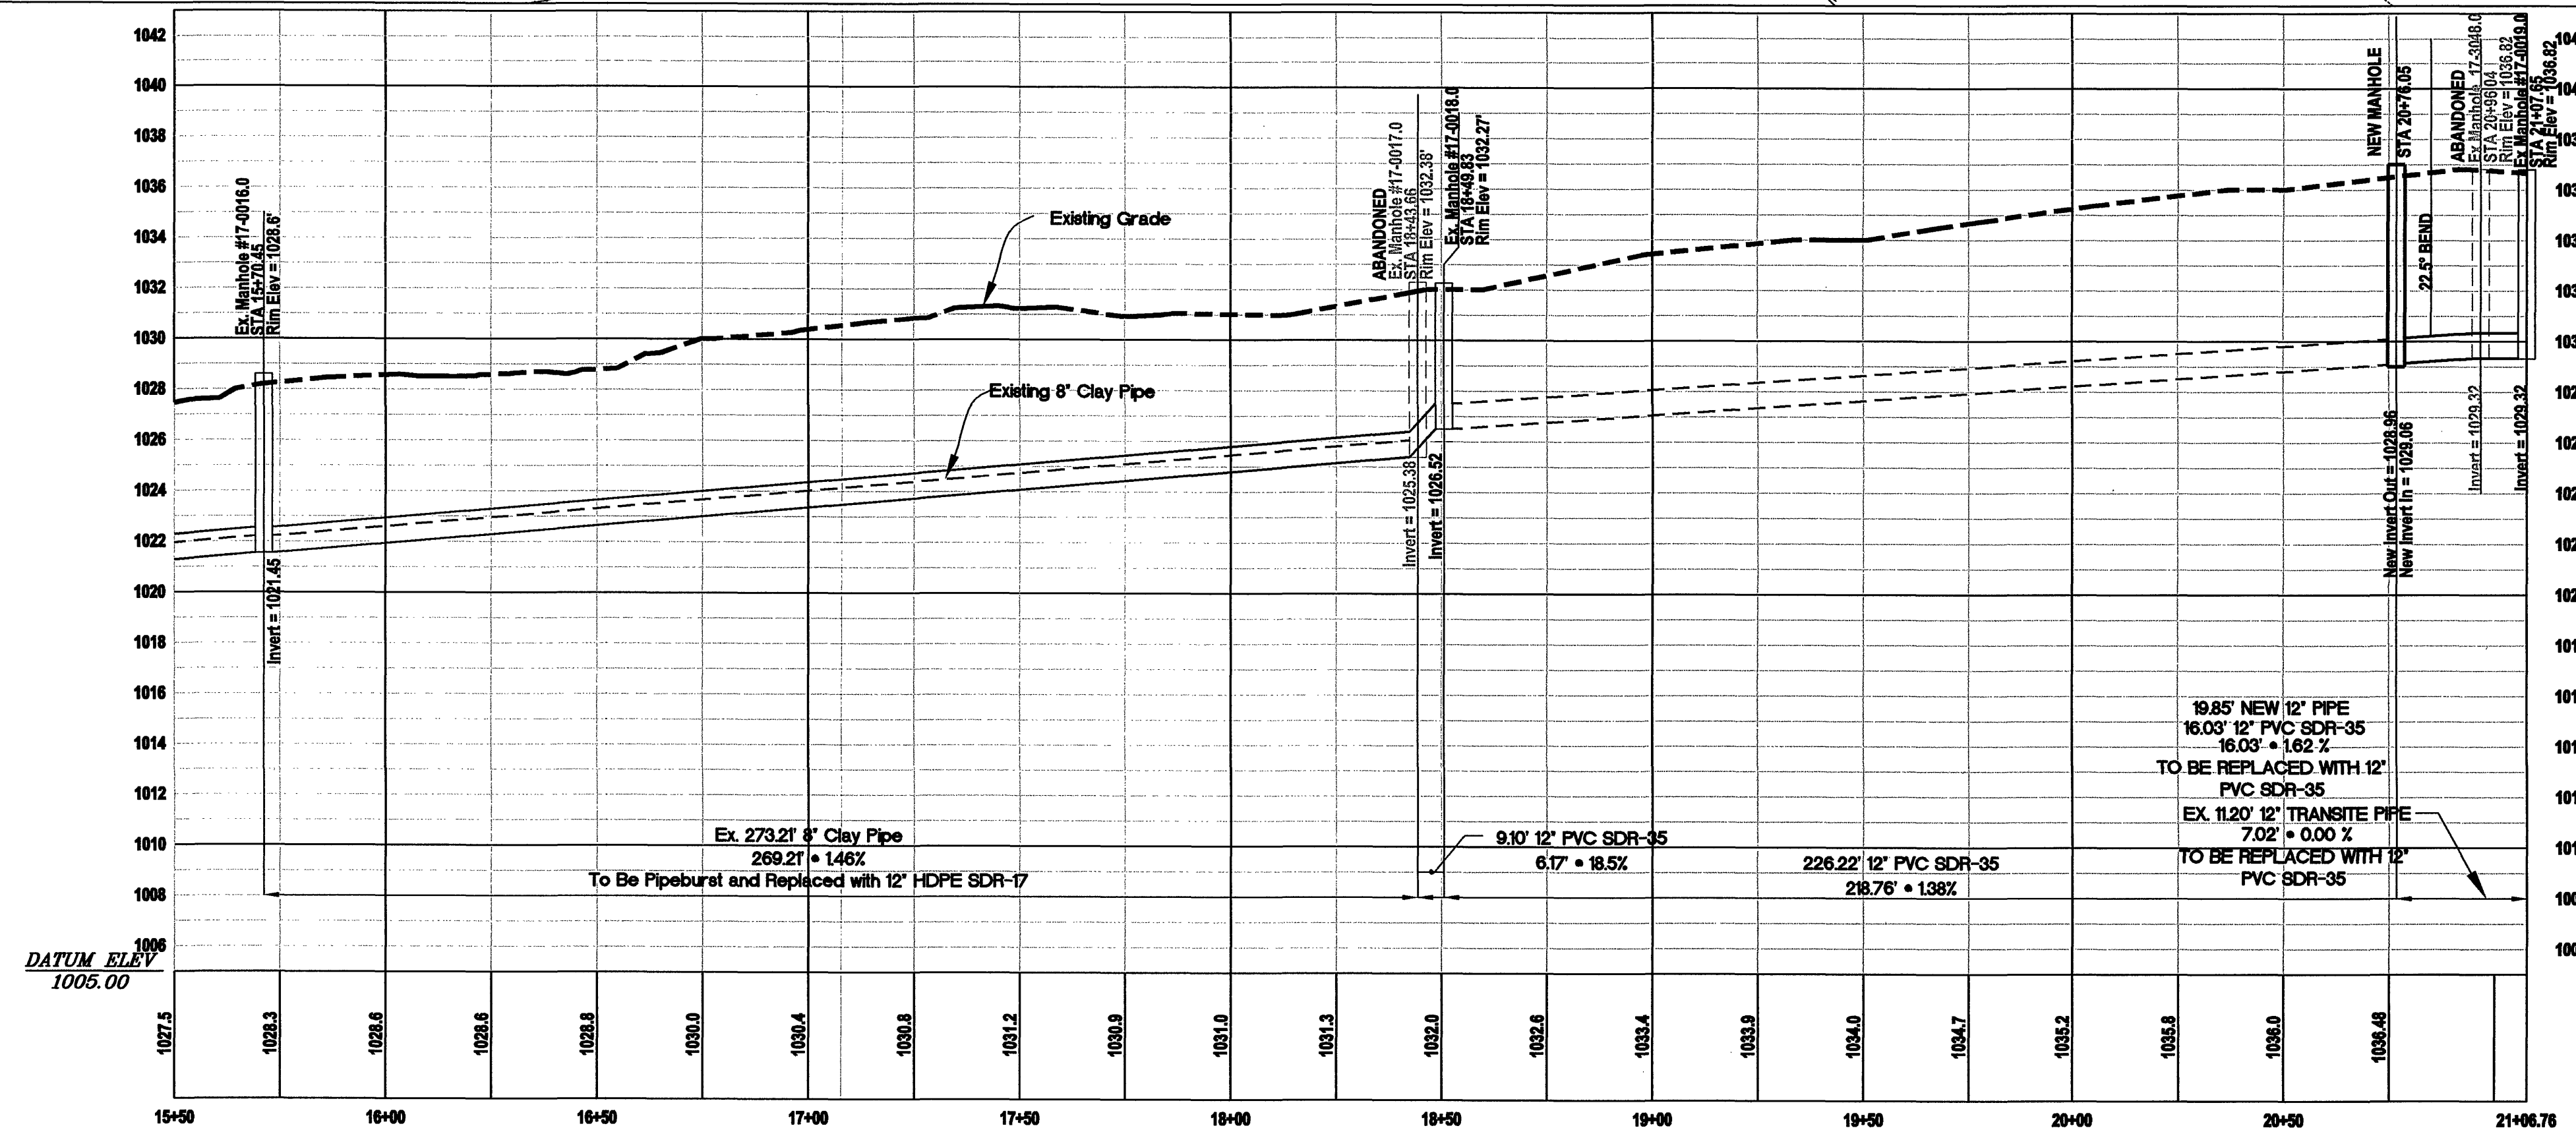

Record Drawings 5/1/2006

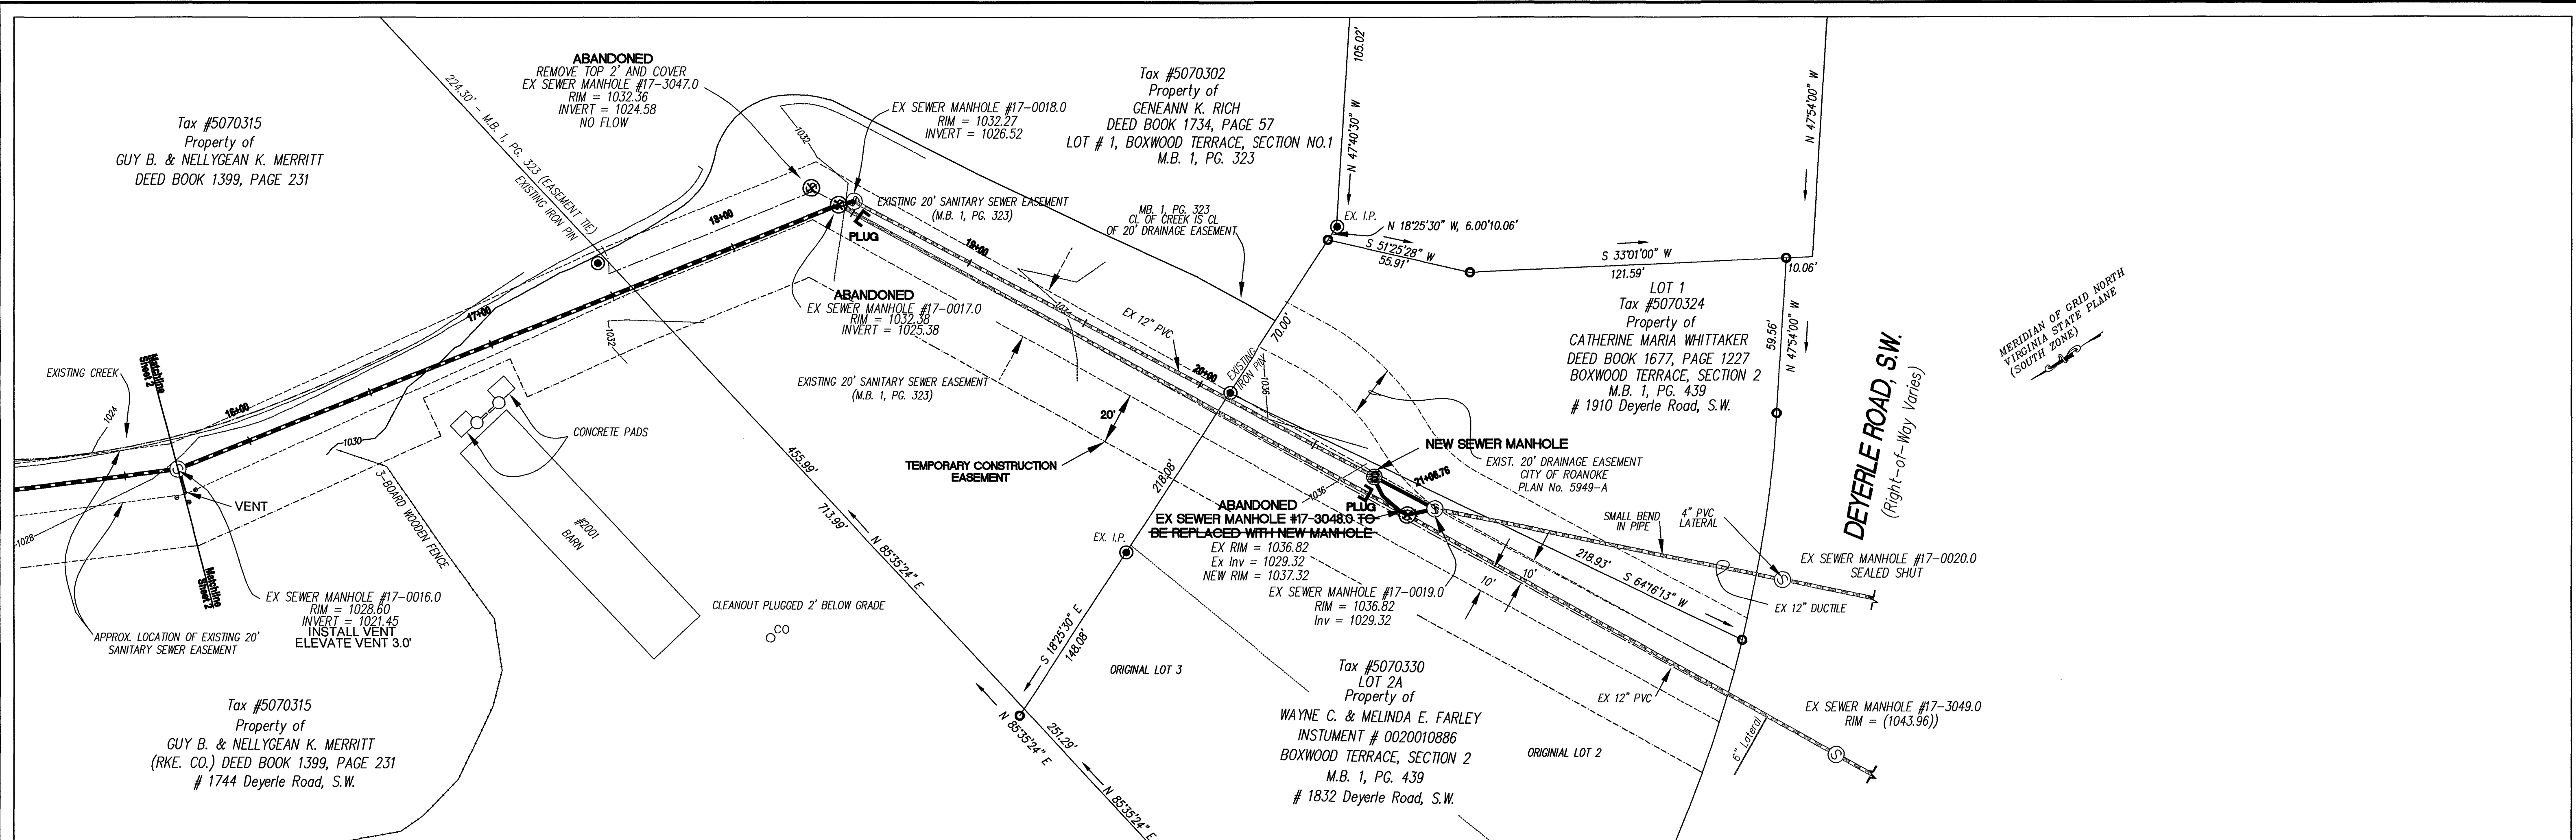

ENGINEERING SERVICES
601 S. JEFFERSON STREET
ROANOKE, VIRGINIA 24011
PHONE: (540) 853-5641

DESIGNED:


CDA

DRAWN:

CDA

CHECKED:

JGR

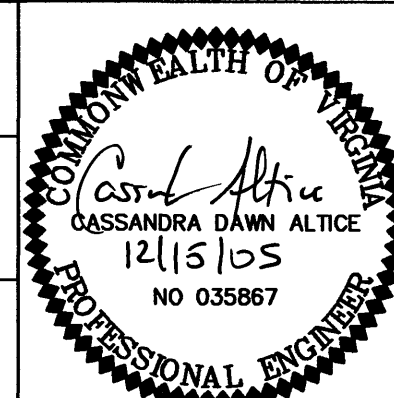

VERTICAL SCALE:

1" = 5'

HORIZONTAL SCALE:

1" = 30'

REV.

DATE:

5/1/06

ASBUILT

DESCRIPTION

DATE:

3/15/06

AUTOCAD DRAWING NAME:

CLARA AVENUE SEWER UPSIZING -
PIPEBURSTING/OPEN CUT OPTION
PLAN AND PROFILE
CITY of ROANOKE, VIRGINIA

SHEET

3 of 5

PLAN NO.

6HAL94