


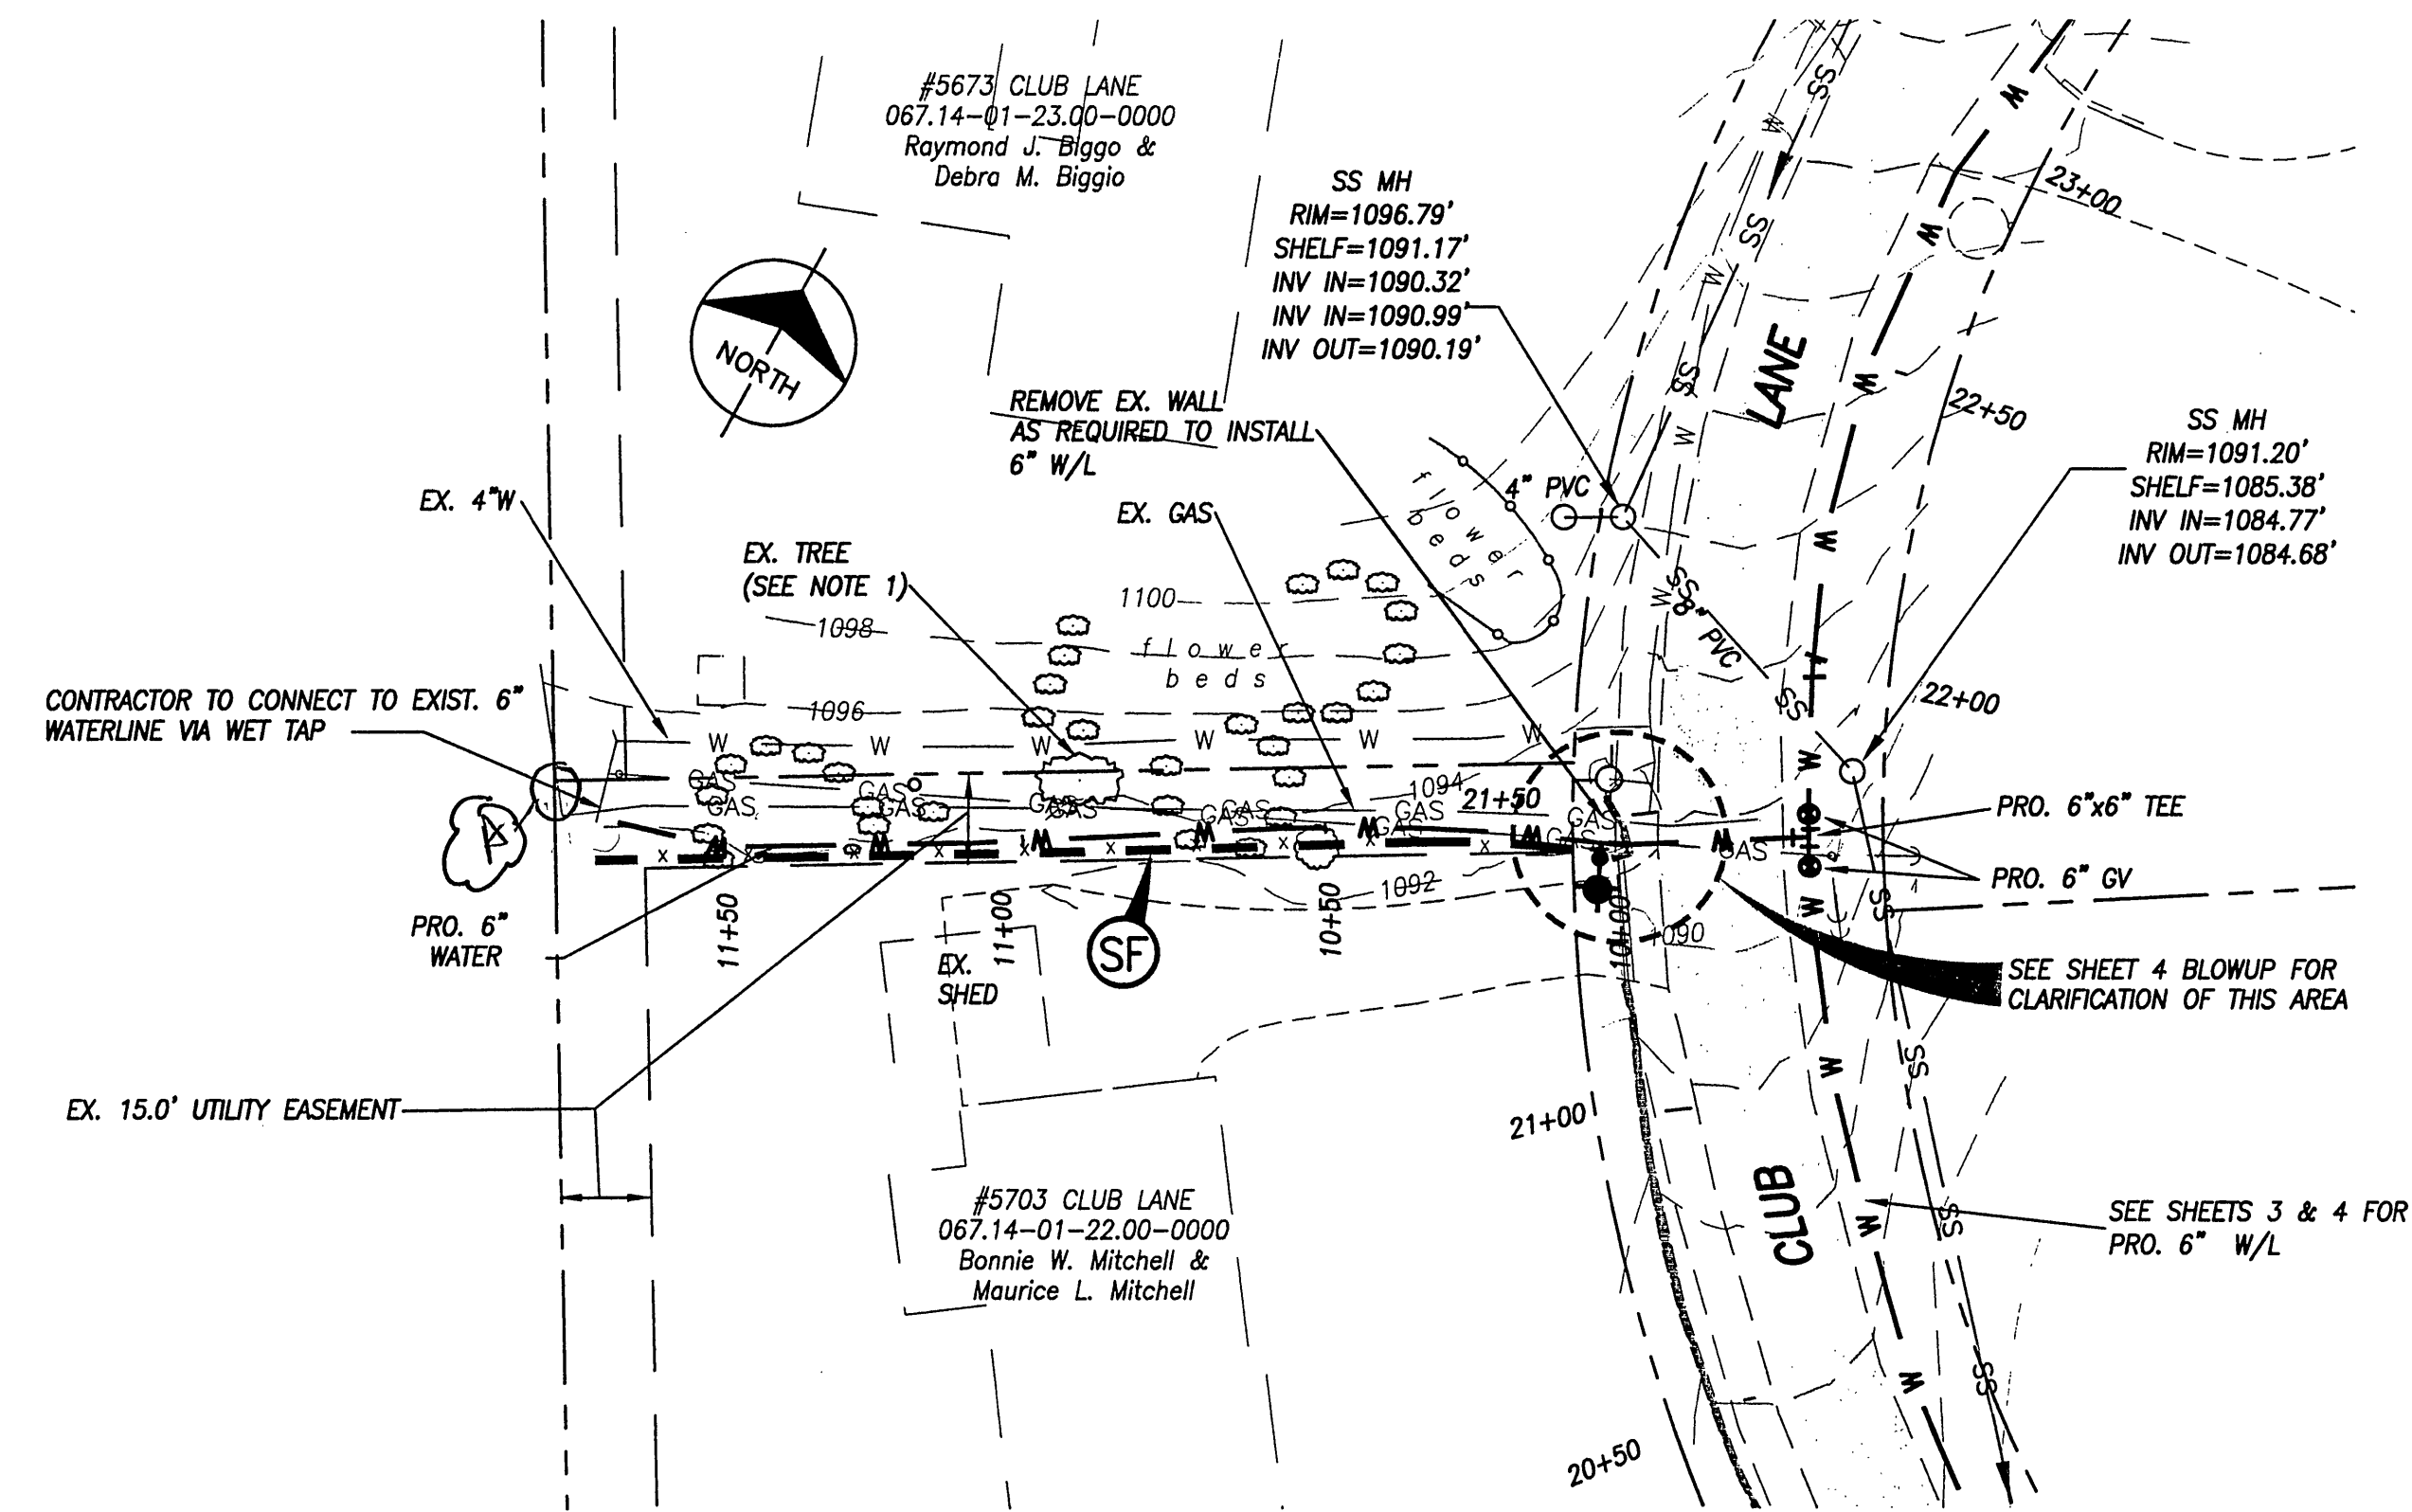




**PLAN OF CLUB LANE 6" CONNECTION
WATERLINE REPLACEMENT**

SCALE: 1"=30'

PSMU NOTE: ALL DISTURBED AREAS NOT TO RECEIVE HARDSCAPE MATERIAL SHALL BE SEEDED AND MULCHED IMMEDIATELY AFTER CONSTRUCTION.


NOTE 1:
EXISTING 30" MAPLE TREE SHALL BE PROTECTED IN ACCORDANCE WITH THE GENERAL NOTES. CONTRACTOR SHALL PROTECT ALL OTHER EXISTING TREES TO THE EXTENT POSSIBLE.

Lannie Twine
may need to help
Richard and/or Jim
locate new & existing
lines. ELS

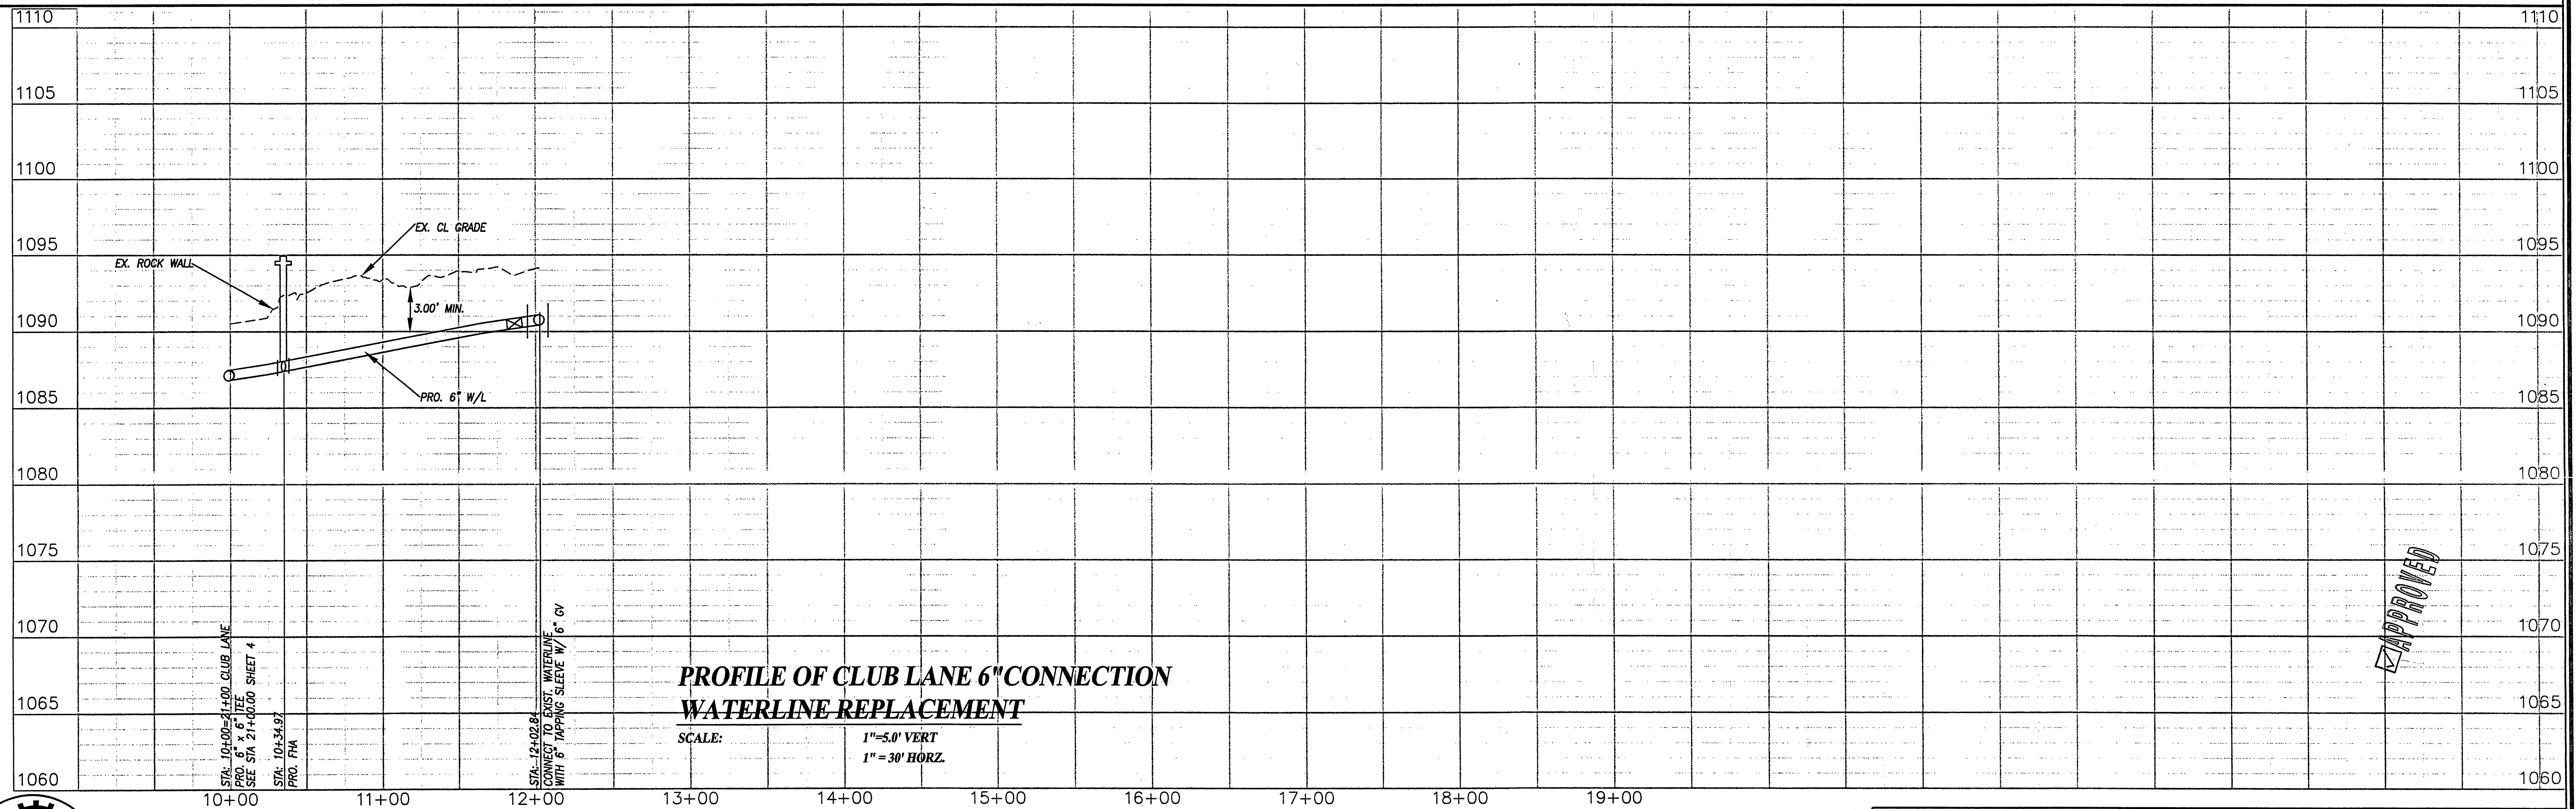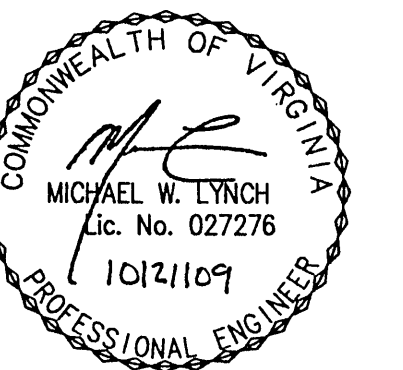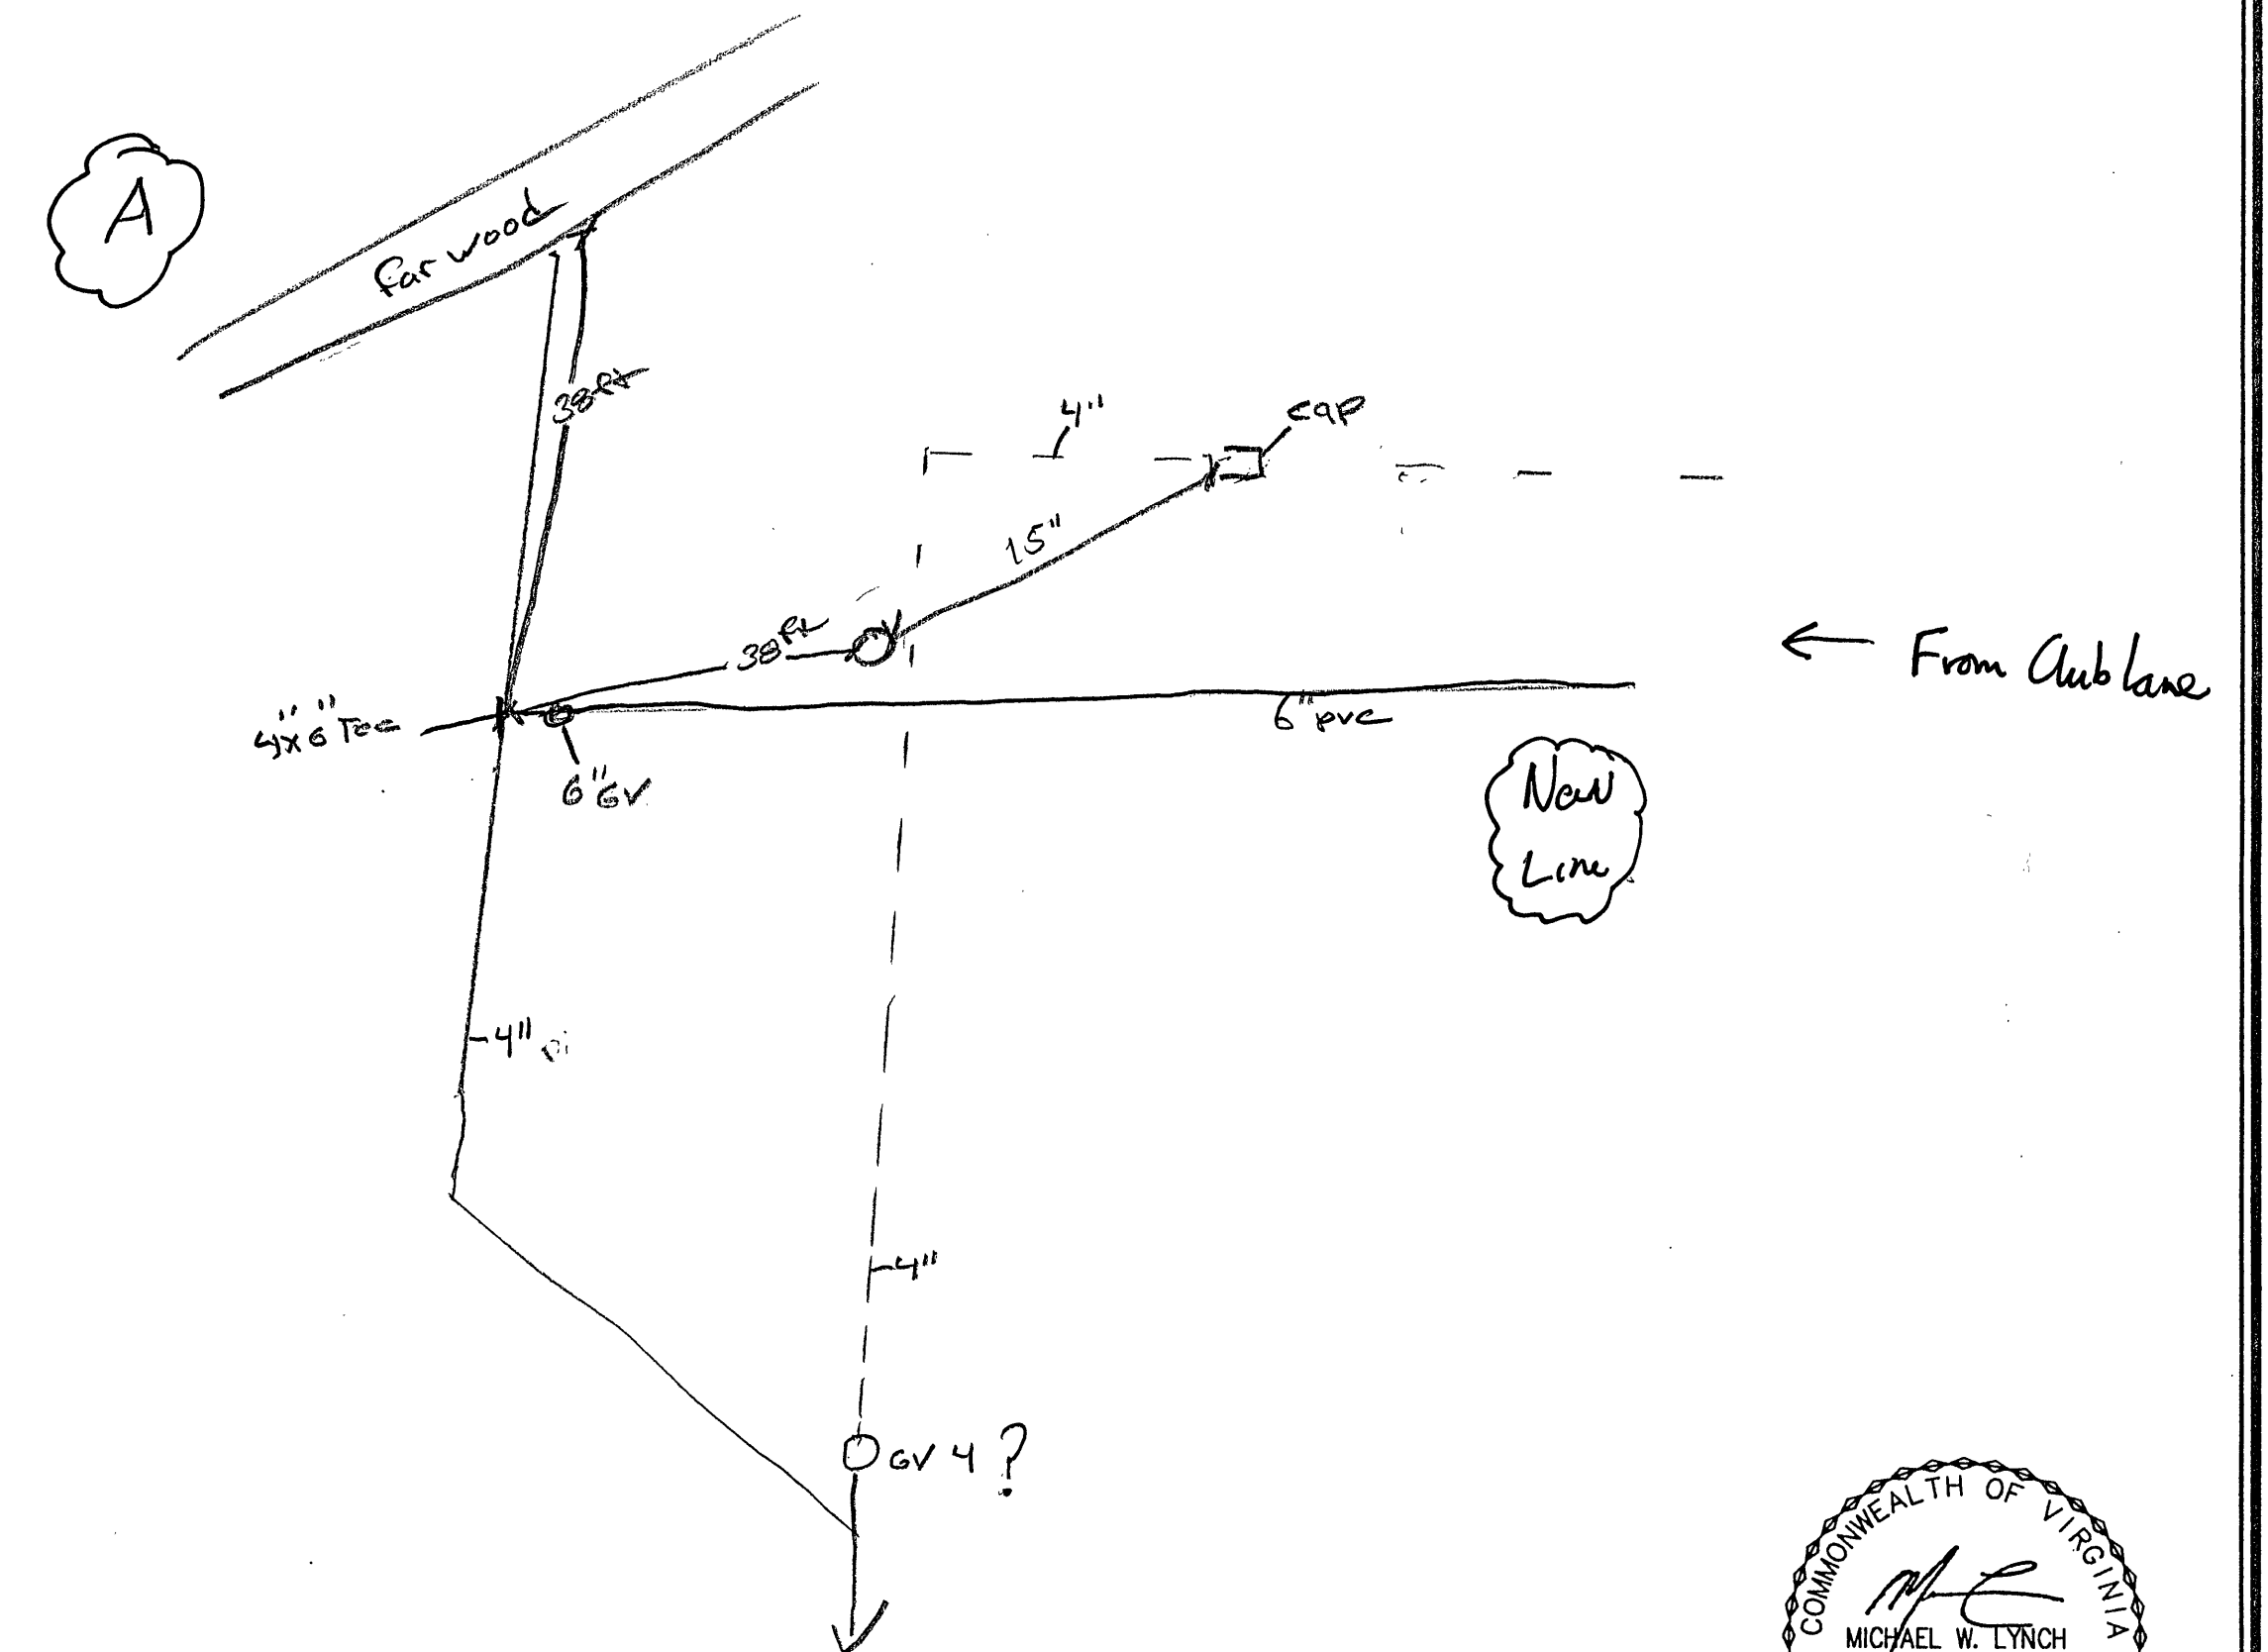

**PROFILE OF CLUB LANE 6" CONNECTION
WATERLINE REPLACEMENT**

SCALE: 1"=5.0' VERT
1"=30' HORIZ.

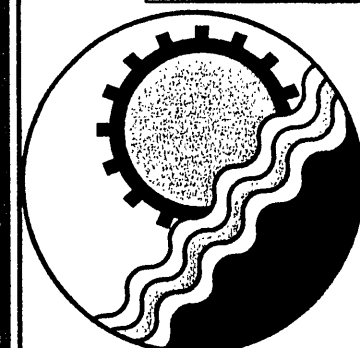

ENGINEERING CONCEPTS, INC.

20 S. ROANOKE ST., PO BOX 619
FINCASTLE, VIRGINIA 24090
540.473.1253 FAX: 540.473.1254

Drawn	MWL	PLAN AND PROFILE CLUB LANE 6" CONNECTION WESTERN VA. WATER AUTHORITY	SCALE: AS NOTED
Designed	MWL		DATE: OCT. 9, 2009
Checked	MWL		PROJECT:
Approved			6