

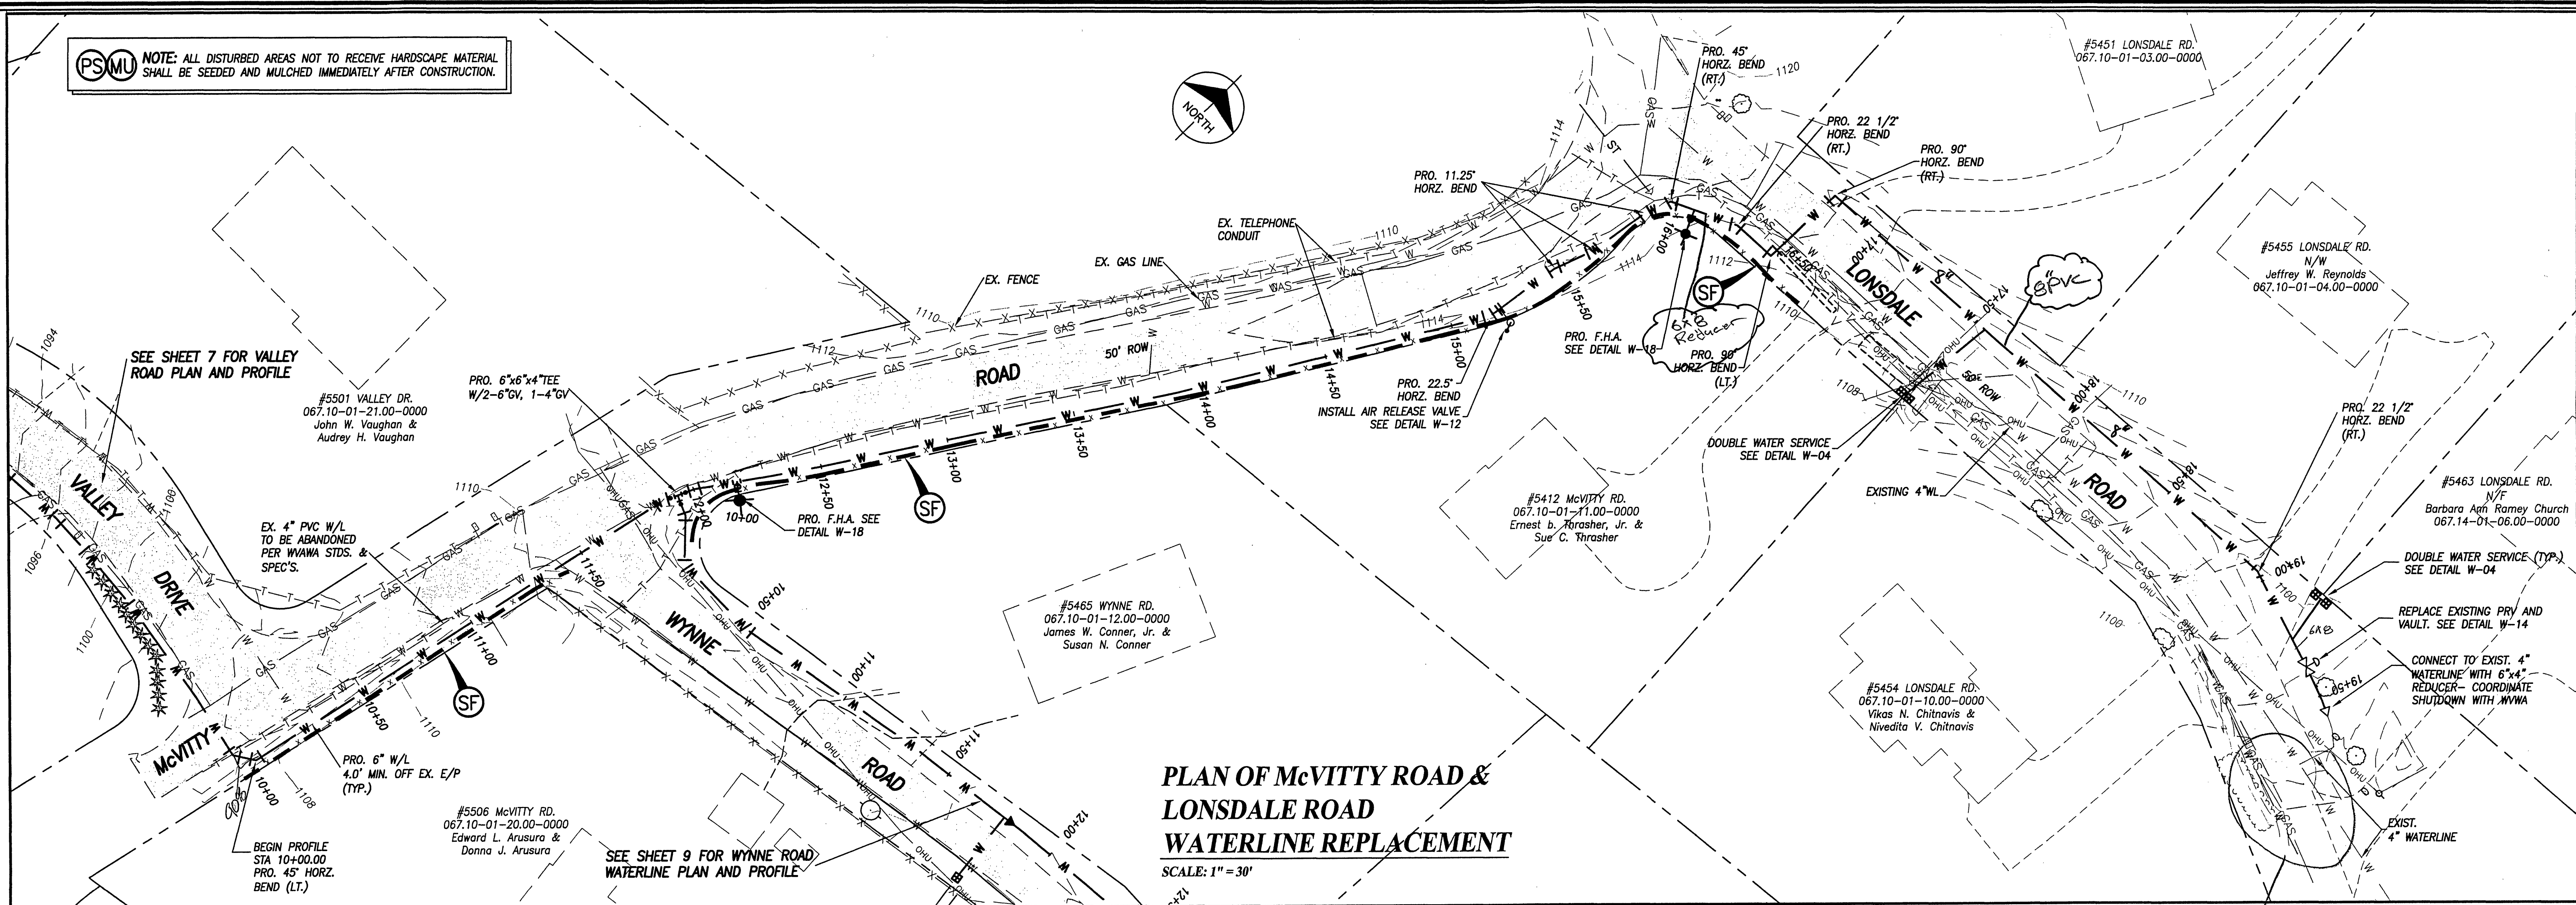



PSMU NOTE: ALL DISTURBED AREAS NOT TO RECEIVE HARDSCAPE MATERIAL SHALL BE SEEDED AND MULCHED IMMEDIATELY AFTER CONSTRUCTION.

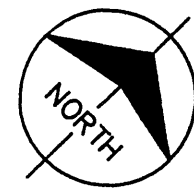


**PLAN OF MCVITTY ROAD & LONSDALE ROAD
WATERLINE REPLACEMENT**
SCALE: 1" = 30'

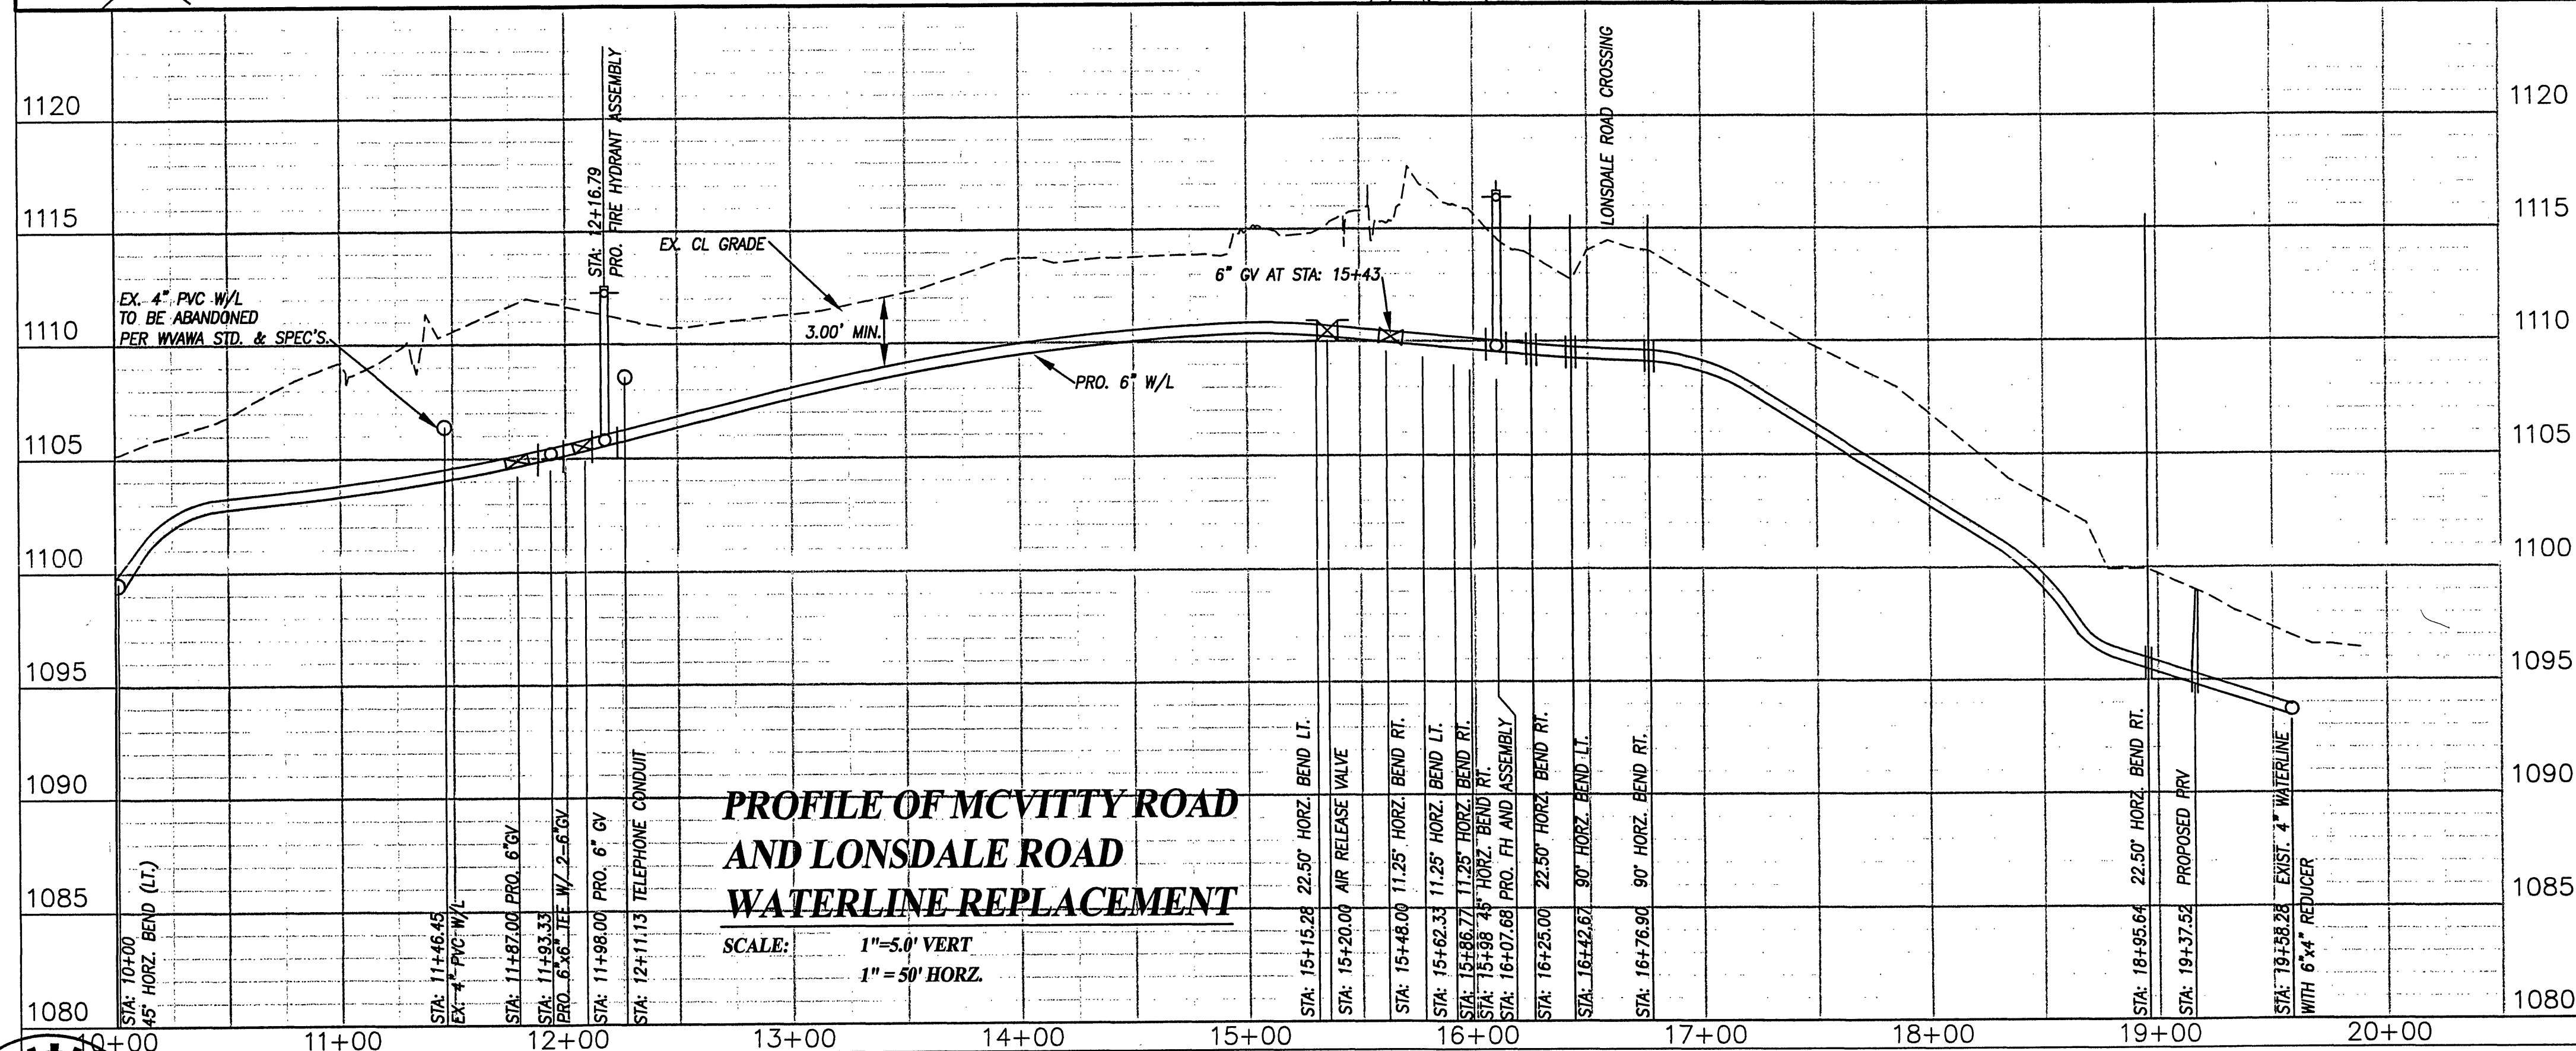

**PROFILE OF MCVITTY ROAD
AND LONSDALE ROAD
WATERLINE REPLACEMENT**
SCALE: 1" = 5.0' VERT
1" = 50' HORIZ.

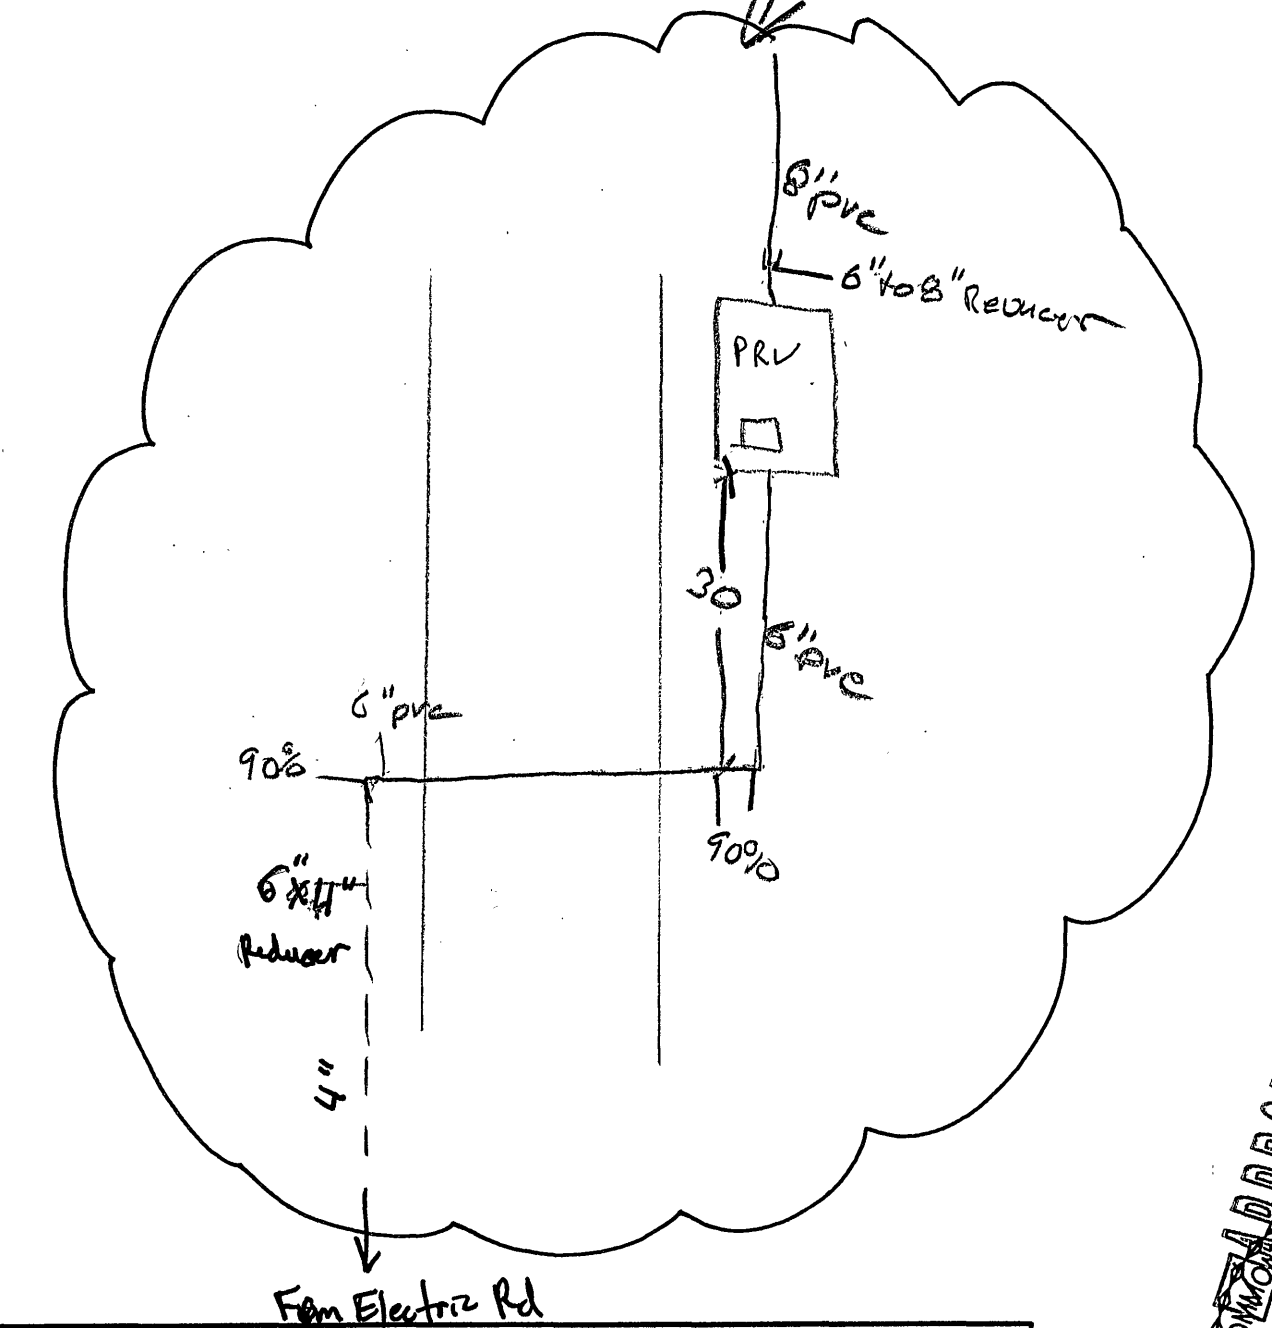

EXISTING WATER METERS SHALL BE EXAMINED AND APPROVED FOR RE-INSTALLATION BY THE AUTHORITY. CONTRACTOR SHALL INSTALL APPROVED EXISTING METERS IN NEW WATER SERVICES. THE AUTHORITY'S CONSTRUCTION INSPECTOR SHALL BE PRESENT WHEN EXISTING METERS ARE TRANSFERRED TO NEW WATER SERVICES TO ENSURE EXISTING METER CONTINUES TO SERVE THE DESIGNATED CUSTOMER.

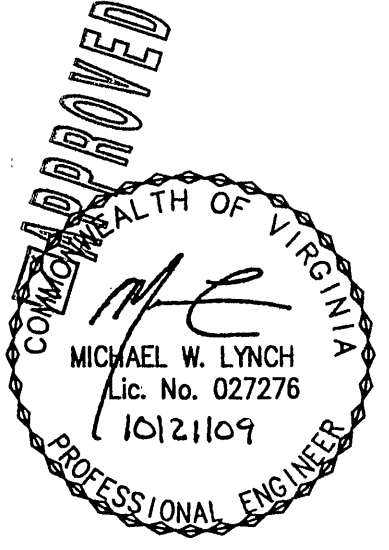

ENGINEERING CONCEPTS, INC.
20 S. ROANOKE ST., PO BOX 619
FINCASTLE, VIRGINIA 24090
540.473.1253 FAX: 540.473.1254

Drawn	MWL	PLAN AND PROFILE MCVITTY RD & LONSDALE RD WESTERN VA. WATER AUTHORITY	SCALE: AS NOTED DATE: OCT. 9, 2009 PROJECT: 07053 8
Designed	MWL		
Checked	MWL		
Approved			