

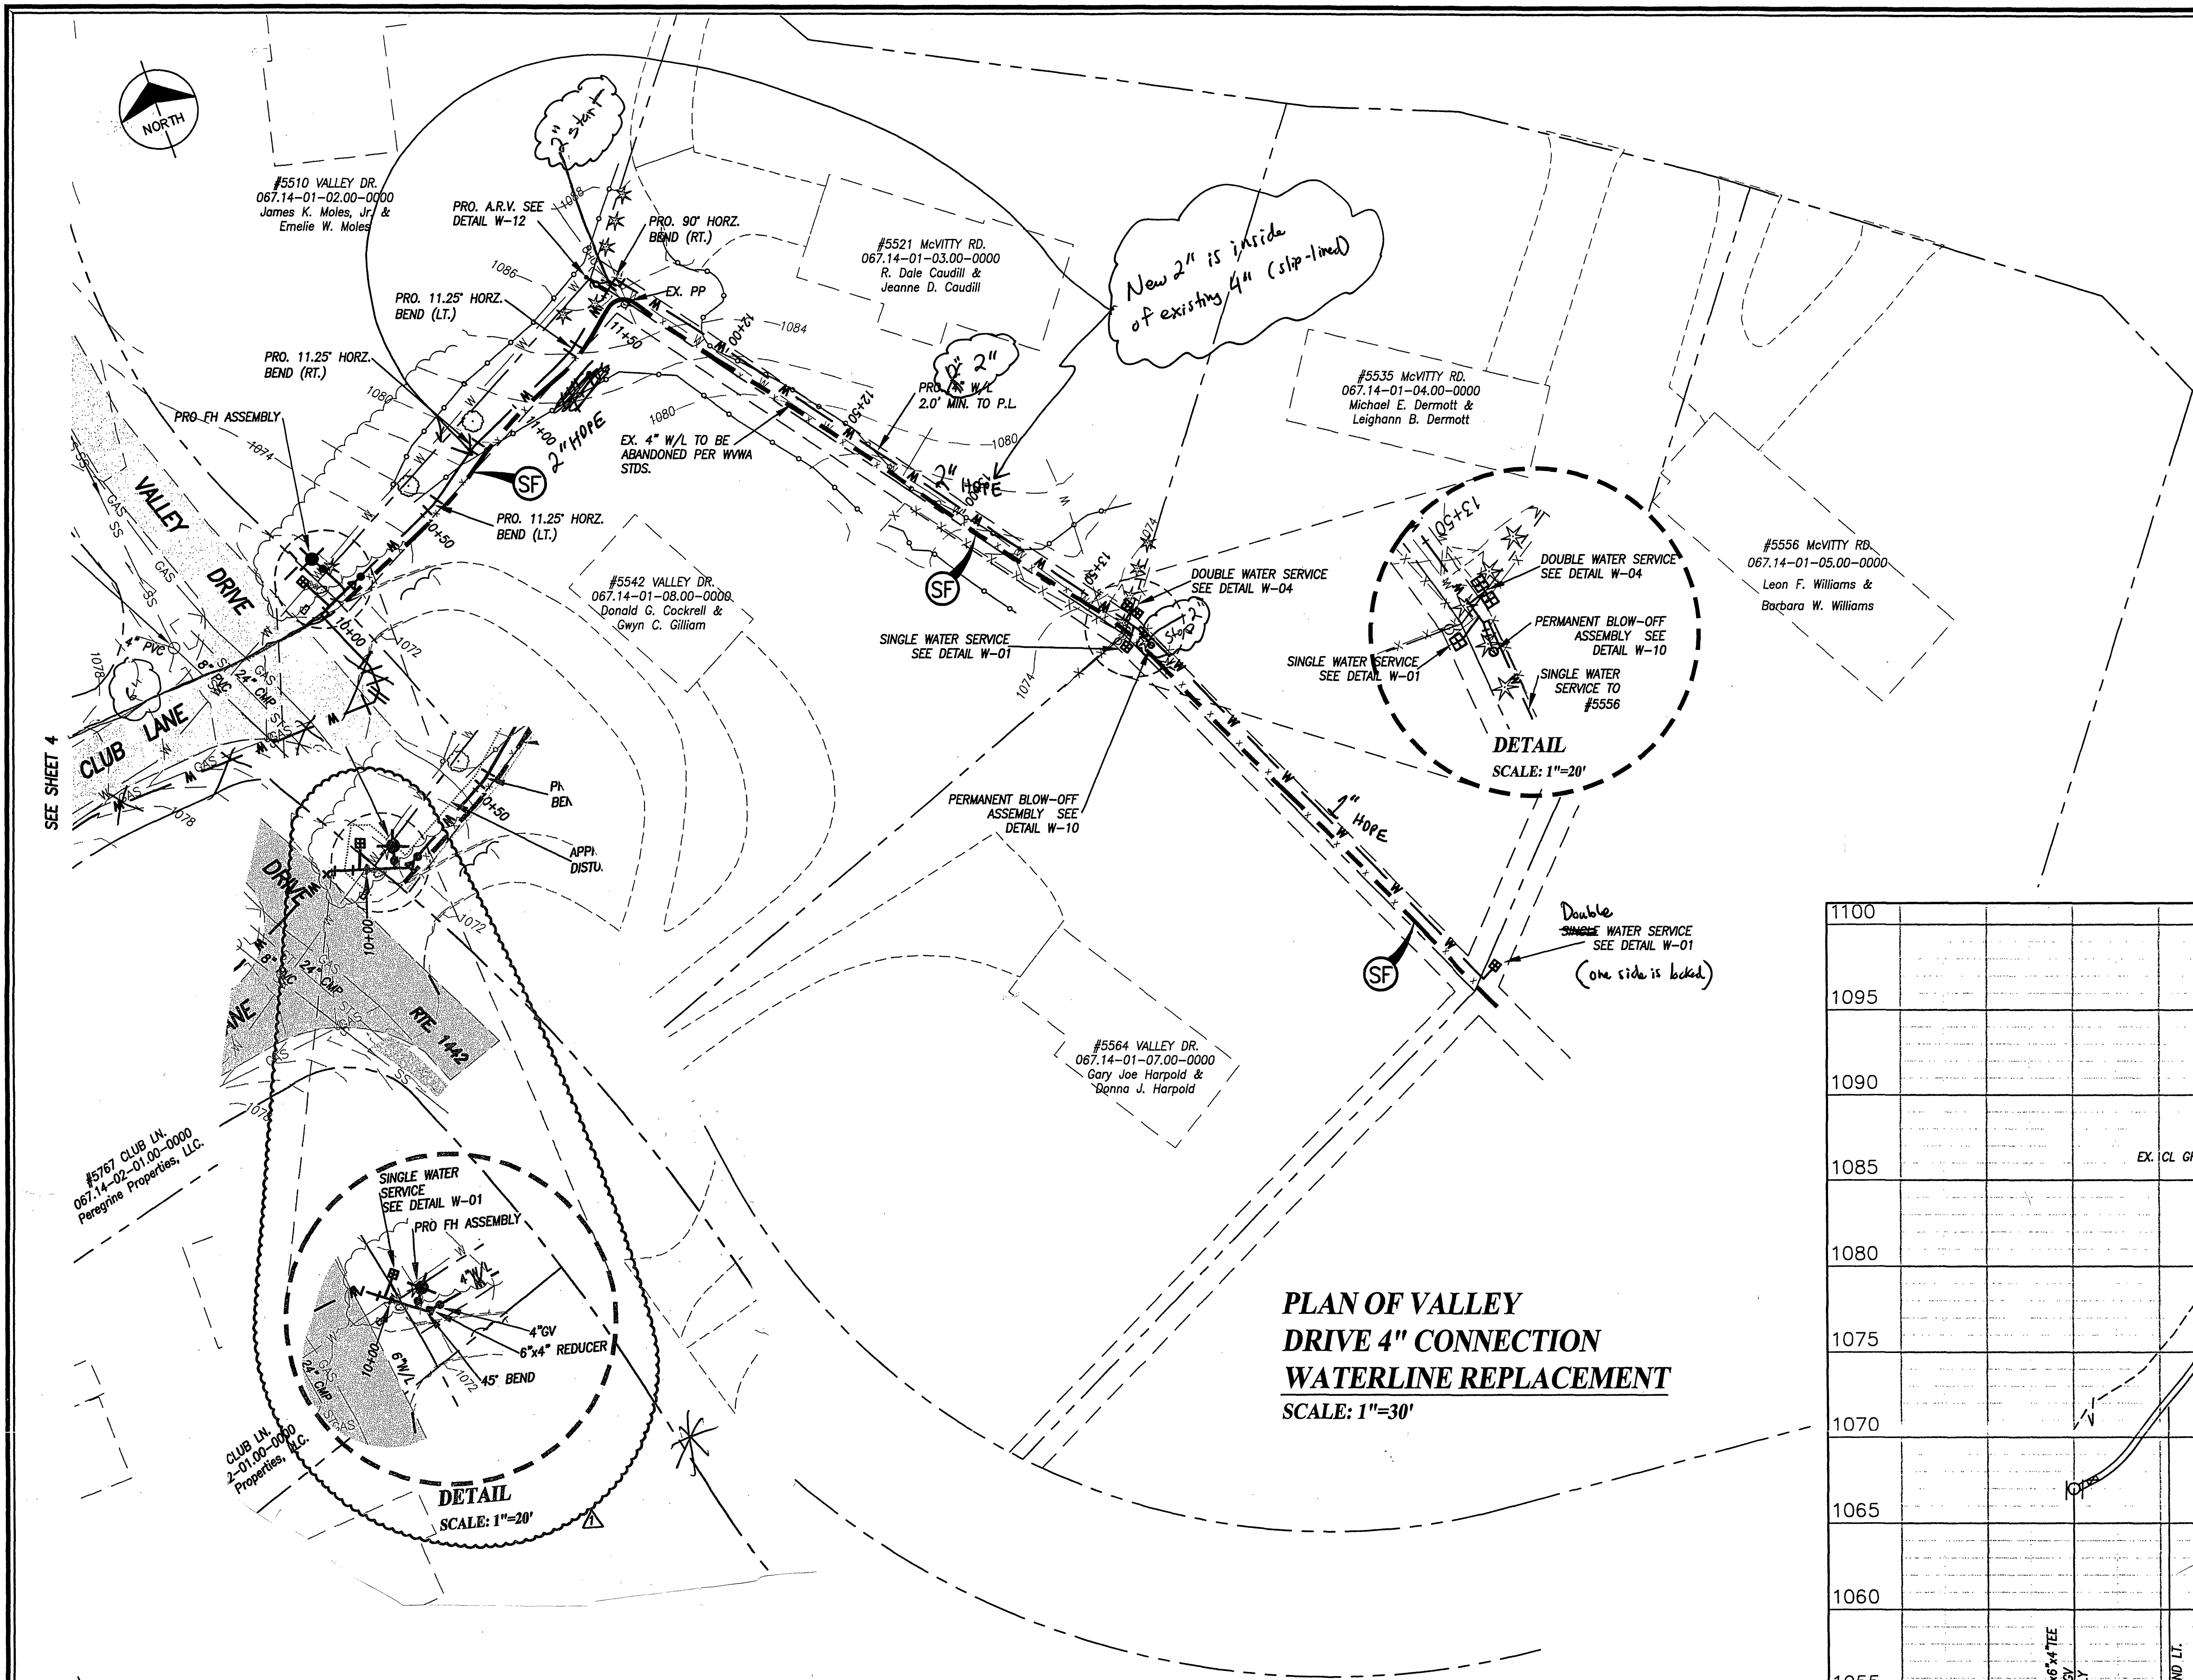


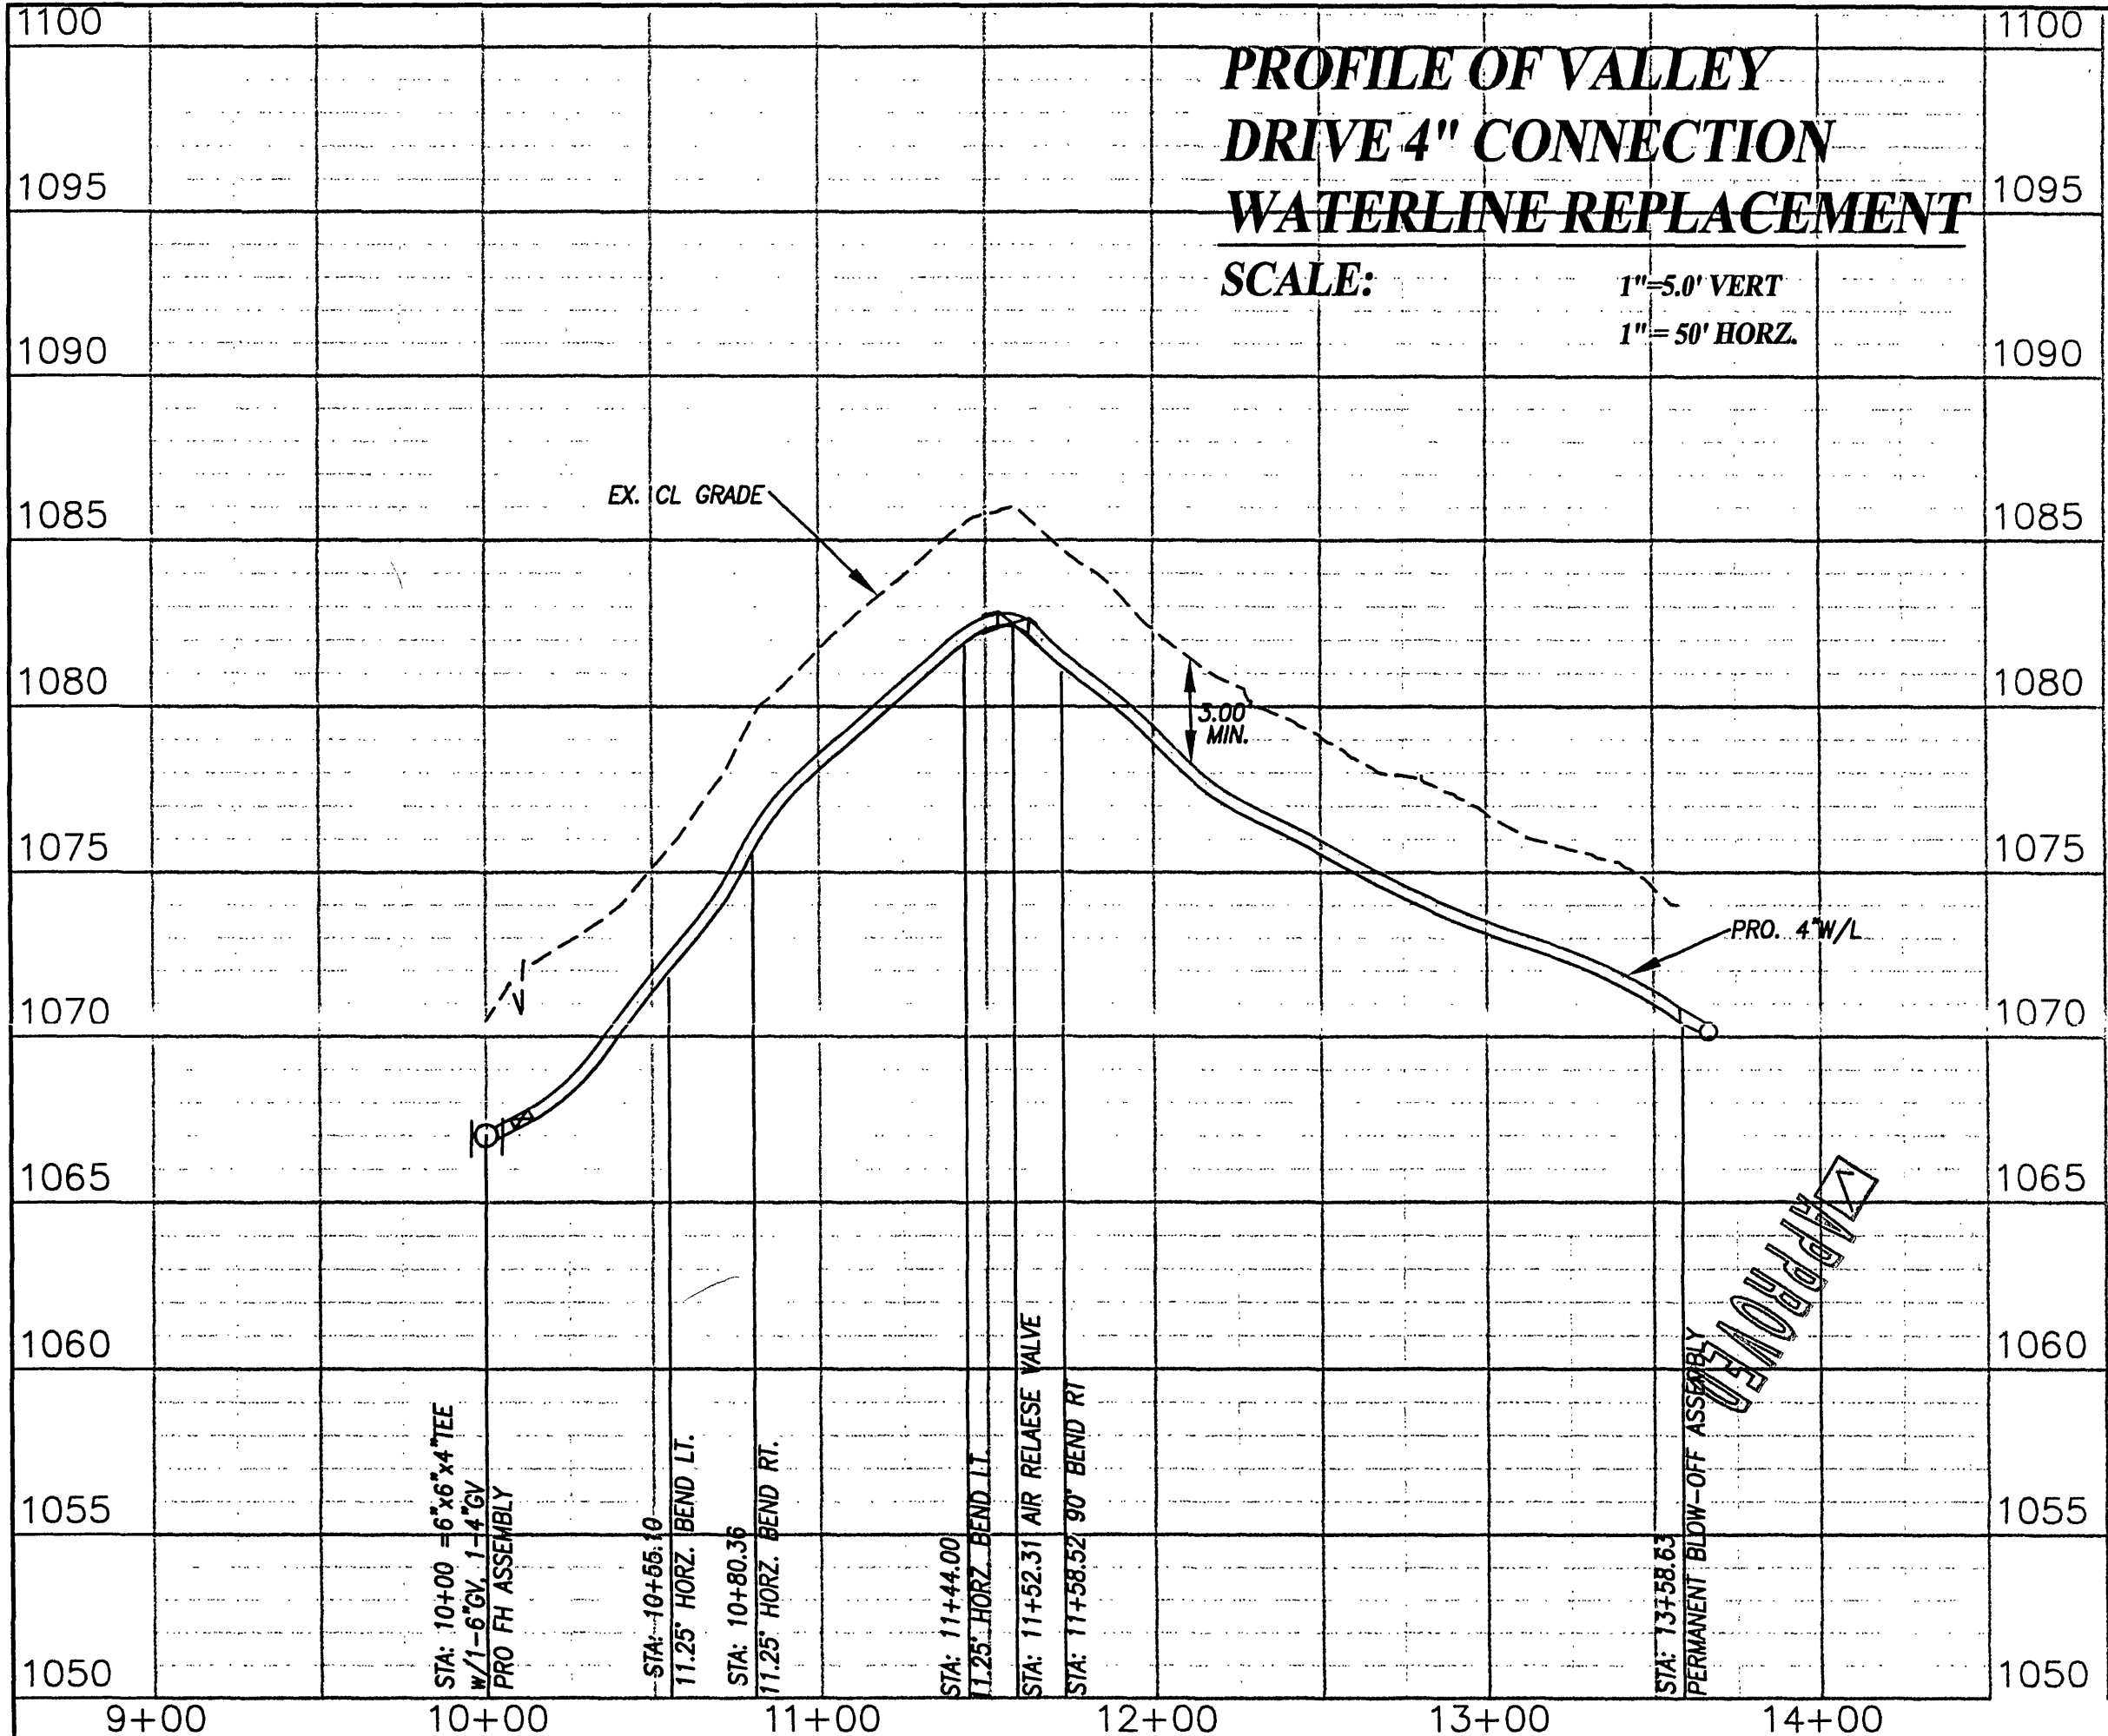

**PLAN OF VALLEY
DRIVE 4" CONNECTION
WATERLINE REPLACEMENT**
SCALE: 1"=30'

EXISTING WATER METERS SHALL BE EXAMINED AND APPROVED FOR RE-INSTALLATION BY THE AUTHORITY. CONTRACTOR SHALL INSTALL APPROVED EXISTING METERS IN NEW WATER SERVICES. THE AUTHORITY'S CONSTRUCTION INSPECTOR SHALL BE PRESENT WHEN EXISTING METERS ARE TRANSFERRED TO NEW WATER SERVICES TO ENSURE EXISTING METER CONTINUES TO SERVE THE DESIGNATED CUSTOMER.

PSMU NOTE: ALL DISTURBED AREAS NOT TO RECEIVE HARDSCAPE MATERIAL SHALL BE SEEDED AND MULCHED IMMEDIATELY AFTER CONSTRUCTION.

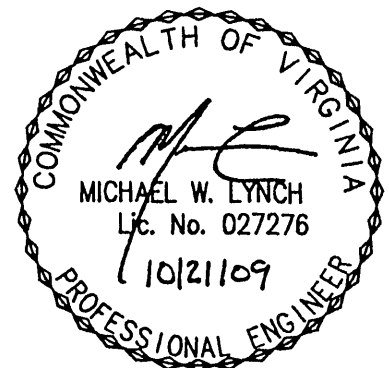

**PROFILE OF VALLEY
DRIVE 4" CONNECTION
WATERLINE REPLACEMENT**
SCALE: 1"=5.0' VERT
1"=50' HORZ.

Drawn	MWL	PLAN AND PROFILE VALLEY DRIVE 4" CONNECTION	SCALE: AS NOTED
Designed	MWL		DATE: OCT. 9, 2009
Checked	MWL		PROJECT: 07053
Approved	MWL		10
		WESTERN VA. WATER AUTHORITY	