


PI #3 NORTHING EASTING
11113.7186 11007.4351



RECORD DRAWINGS



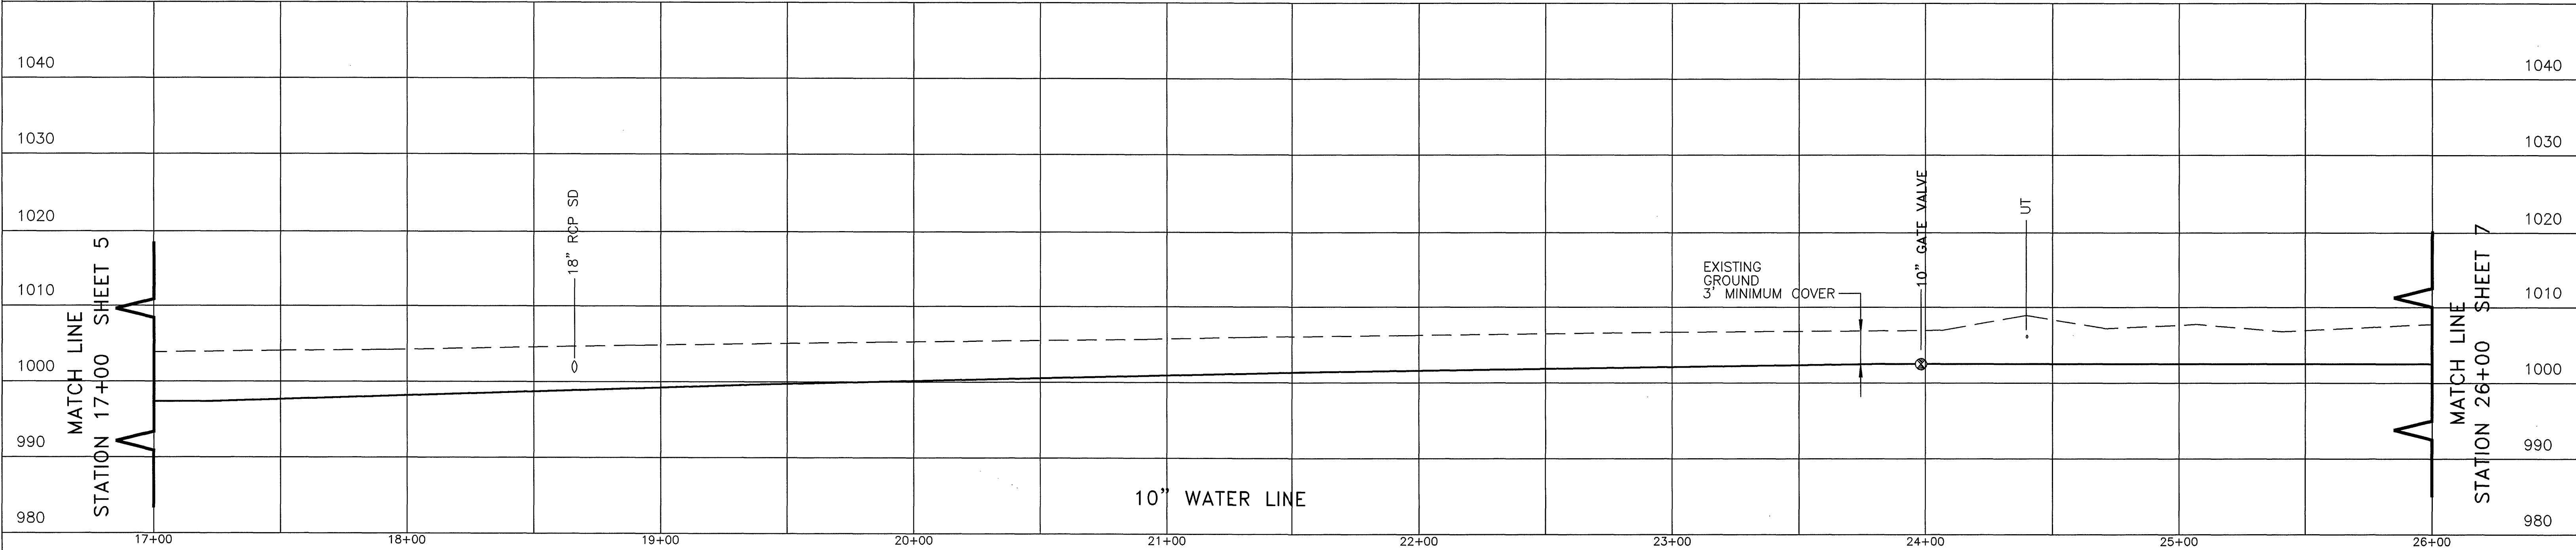

Mattern & Craig
CONSULTING ENGINEERS – SURVEYORS

DESIGNED: BCC
DRAWN: FMP
CHECKED: SWH

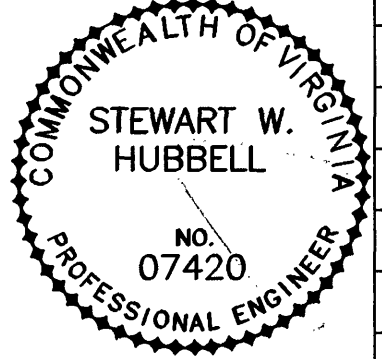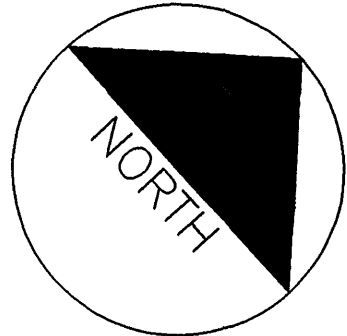

REV.	DATE	DESCRIPTION	BY	APP.

DATE
NOVEMBER 1995
COMM. NO.
1417

COYNER SPRINGS WATER LINE
PLAN AND PROFILE
CITY OF ROANOKE, VIRGINIA
SCALE: 1"=30' HORIZONTAL
1"=10' VERTICAL

SHEET
6