




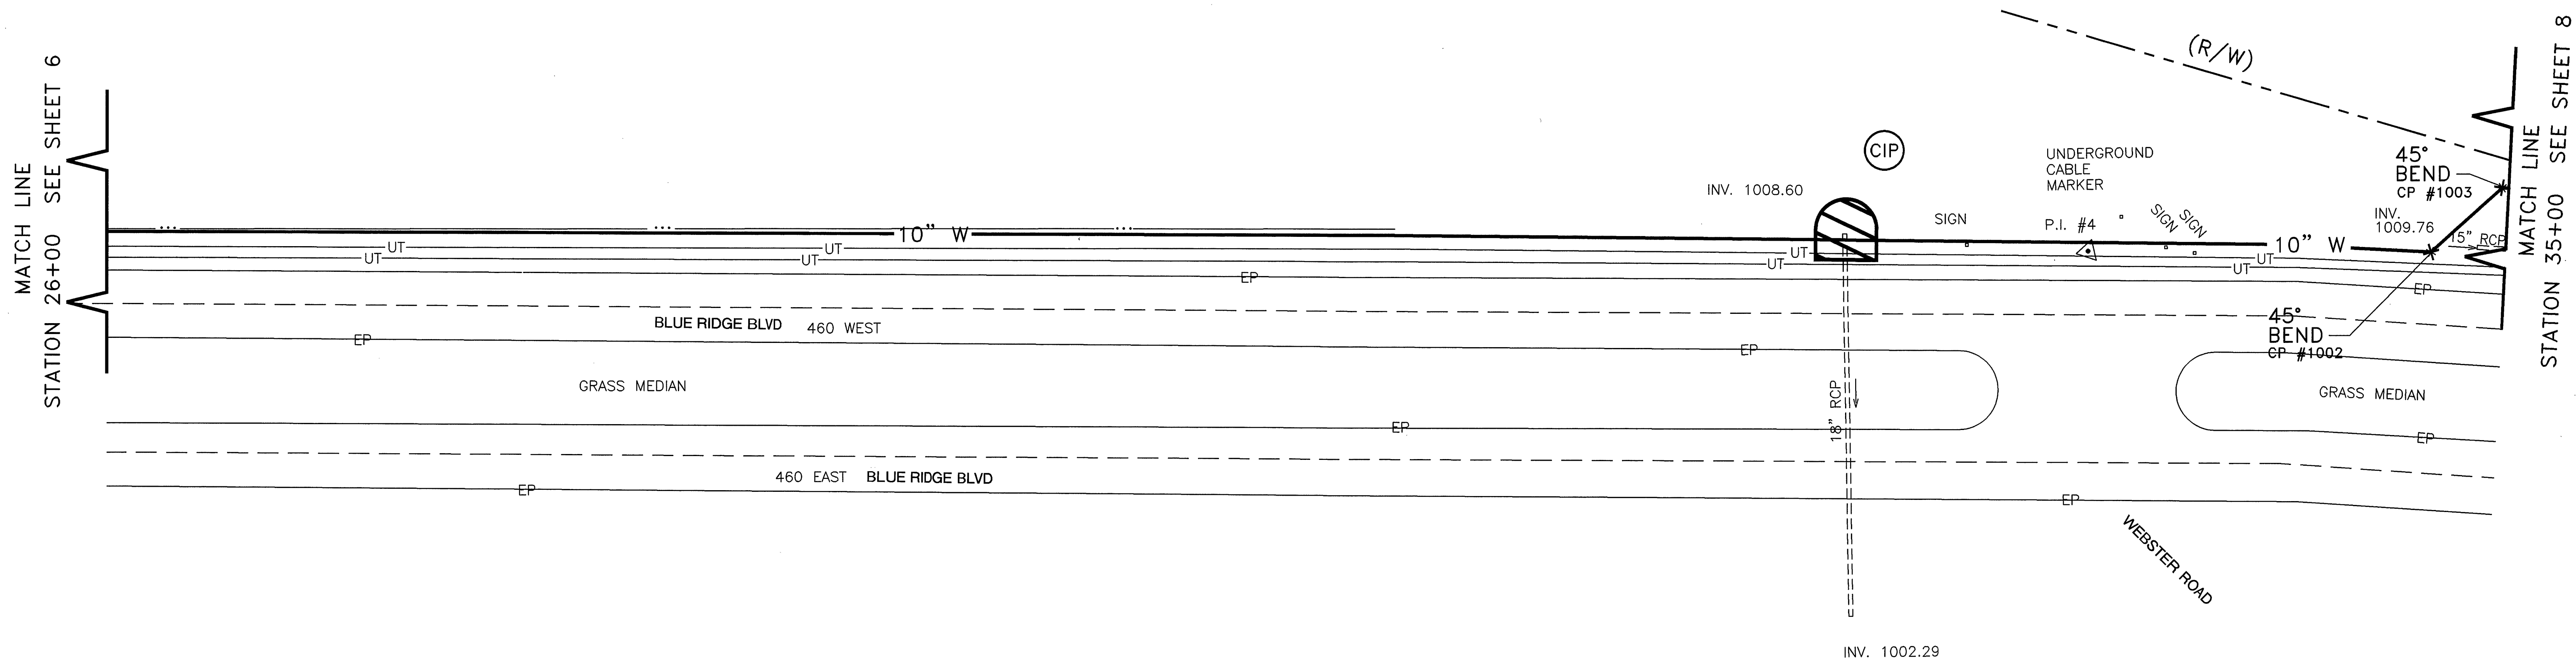

	NORTHING	EASTING
PI #4	11728.4536	11561.6740
CP #1002	11822.7090	11647.1476
CP #1003	11858.6336	11646.7173



RECORD DRAWINGS

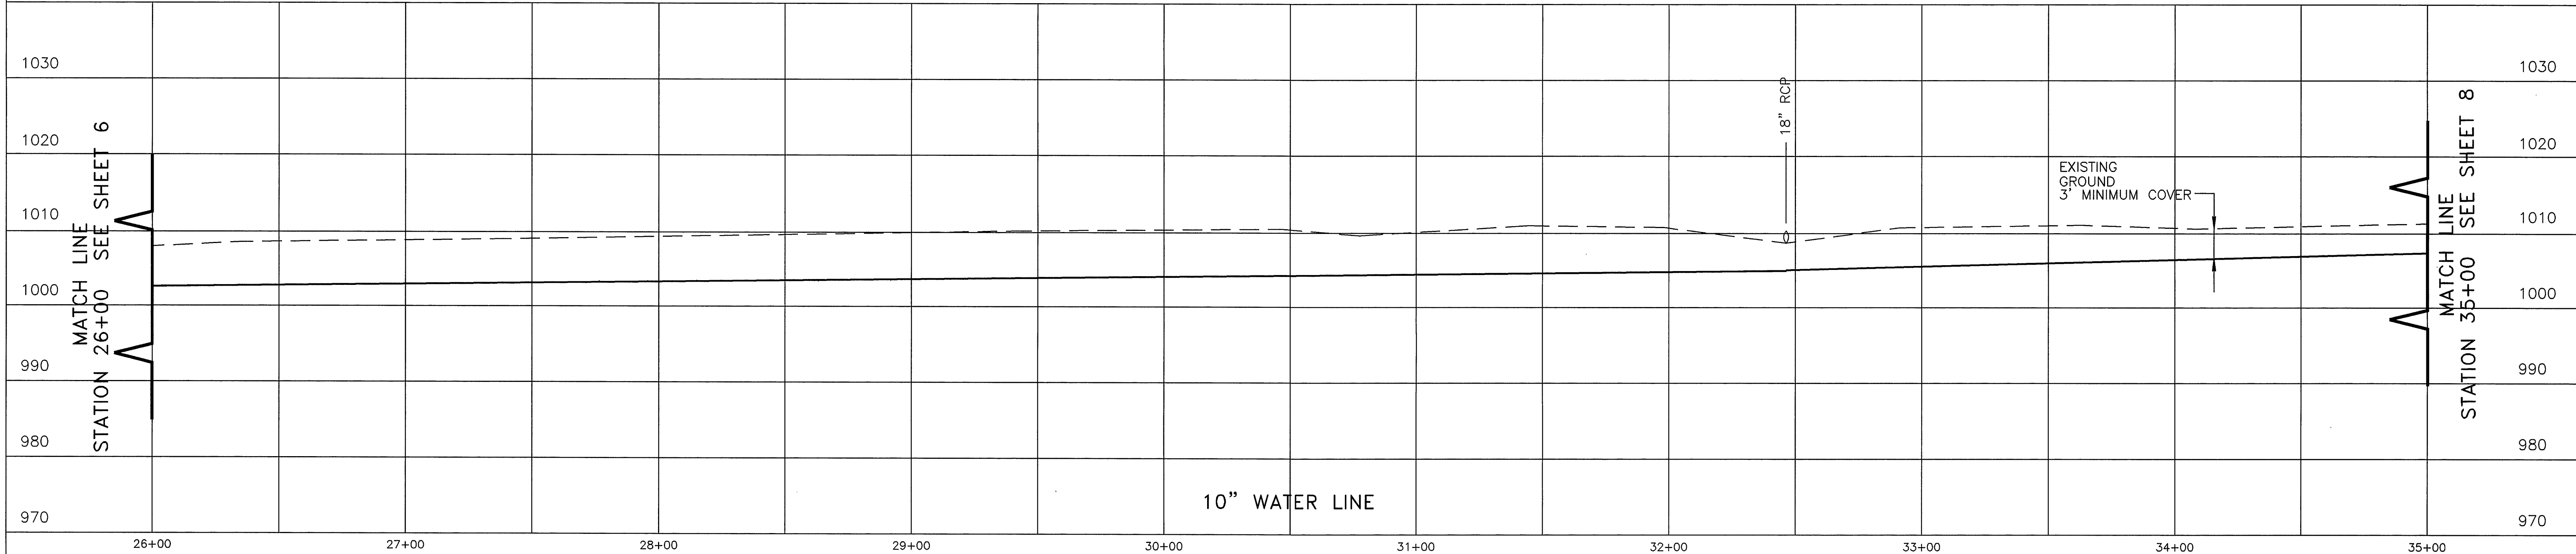

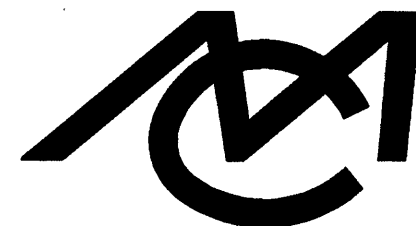

Mattern & Craig
CONSULTING ENGINEERS – SURVEYORS

DESIGNED: BCC
DRAWN: FMP
CHECKED: SWH

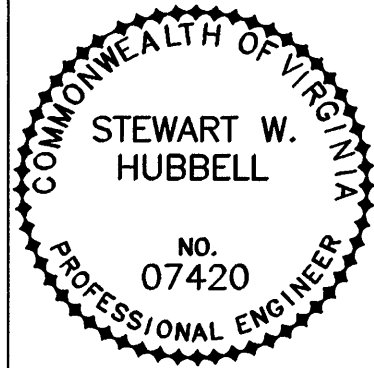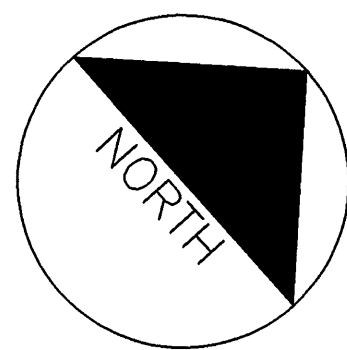

REV.	DATE	DESCRIPTION	BY	APP.

DATE
NOVEMBER 1995
COMM. NO.
1417

COYNER SPRINGS WATER LINE
PLAN AND PROFILE

CITY OF ROANOKE,VIRGINIA

SCALE: 1"=30' HORIZONTAL
1"=10' VERTICAL

SHEET

7