



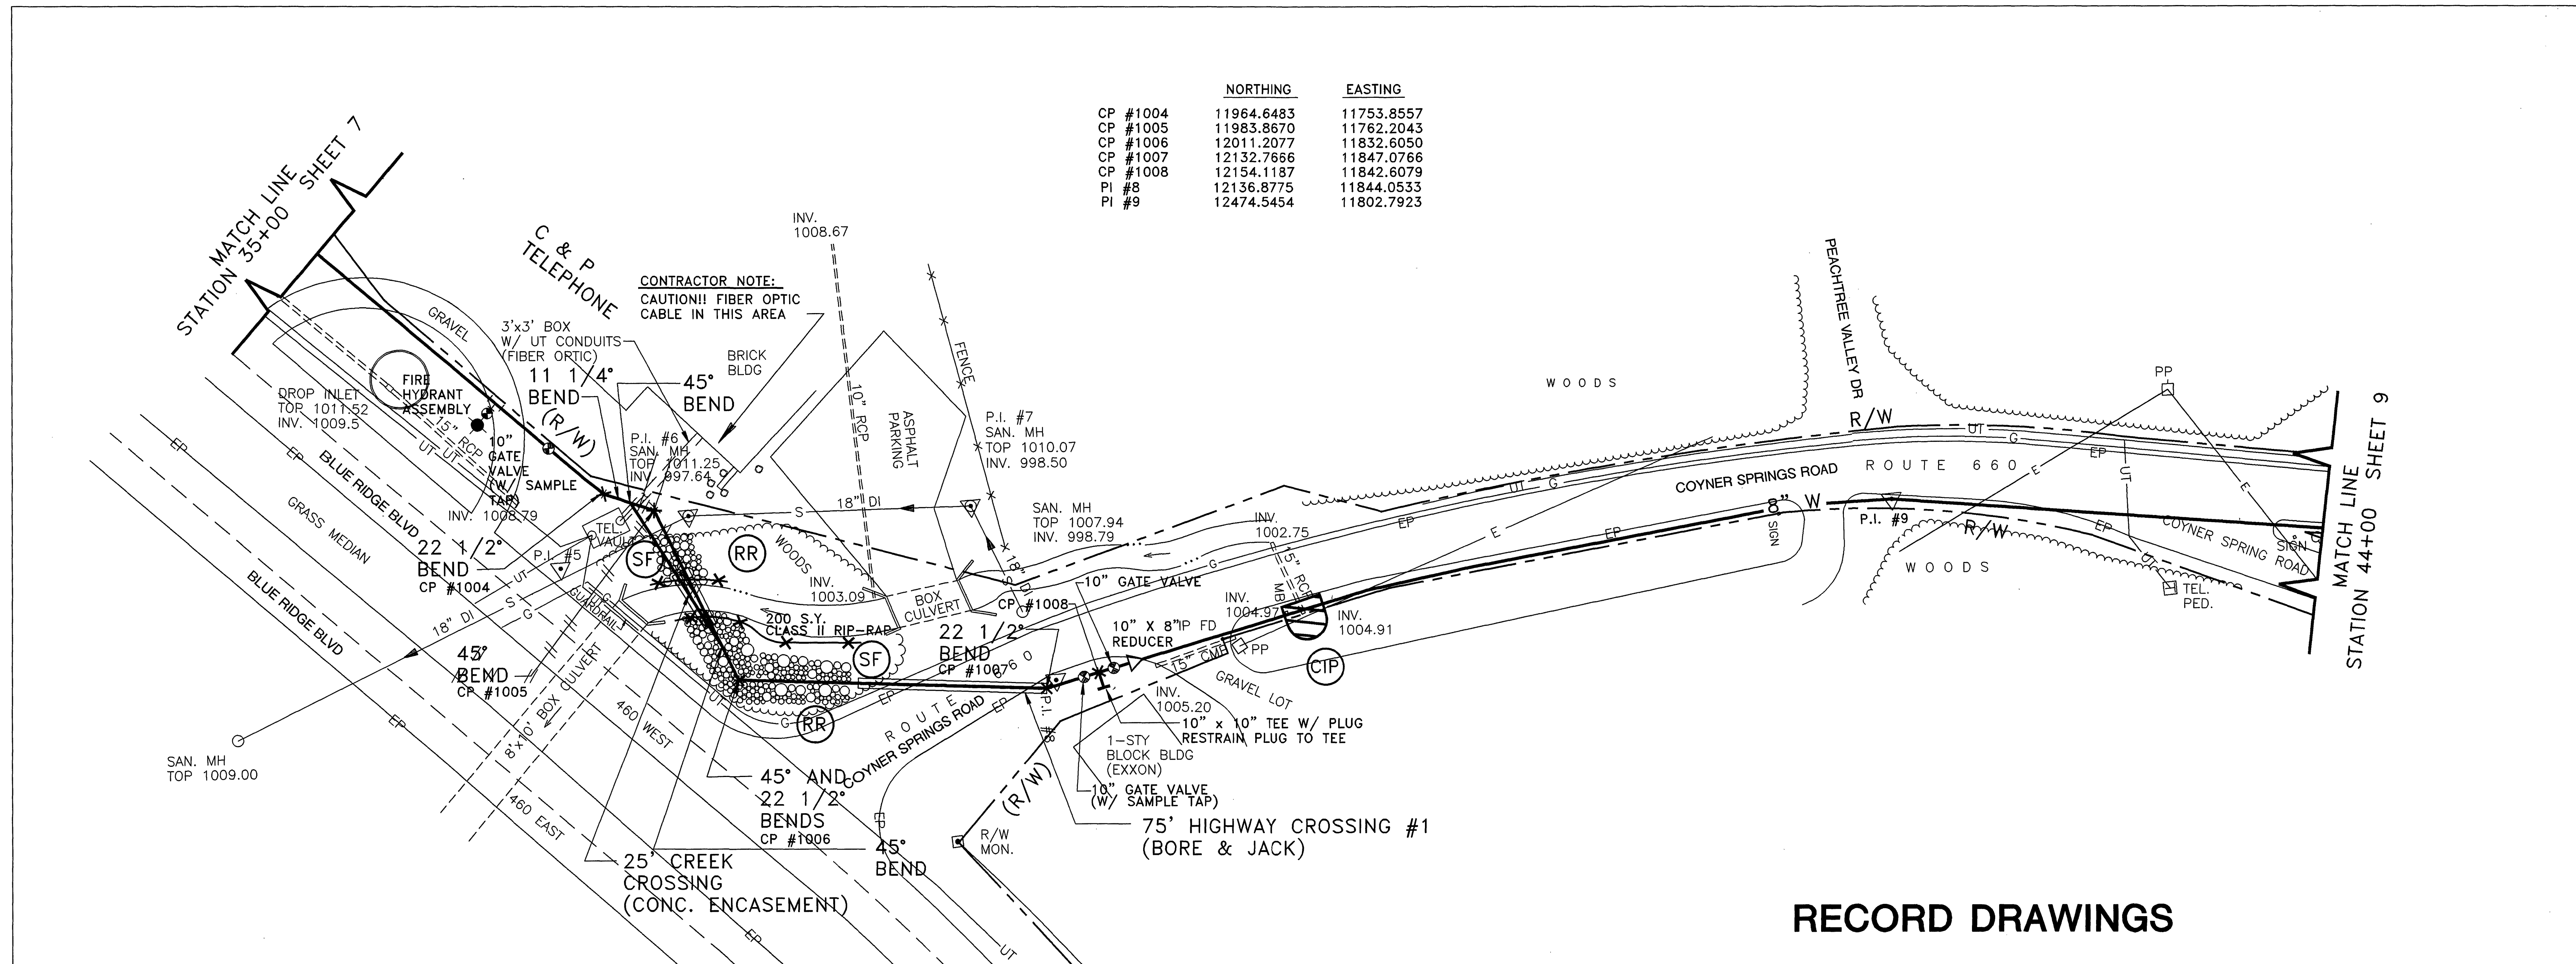

	NORTHING	EASTING
CP #1004	11964.6483	11753.8557
CP #1005	11983.8670	11762.2043
CP #1006	12011.2077	11832.6050
CP #1007	12132.7666	11847.0766
CP #1008	12154.1187	11842.6079
PI #8	12136.8775	11844.0533
PI #9	12474.5454	11802.7923

RECORD DRAWINGS

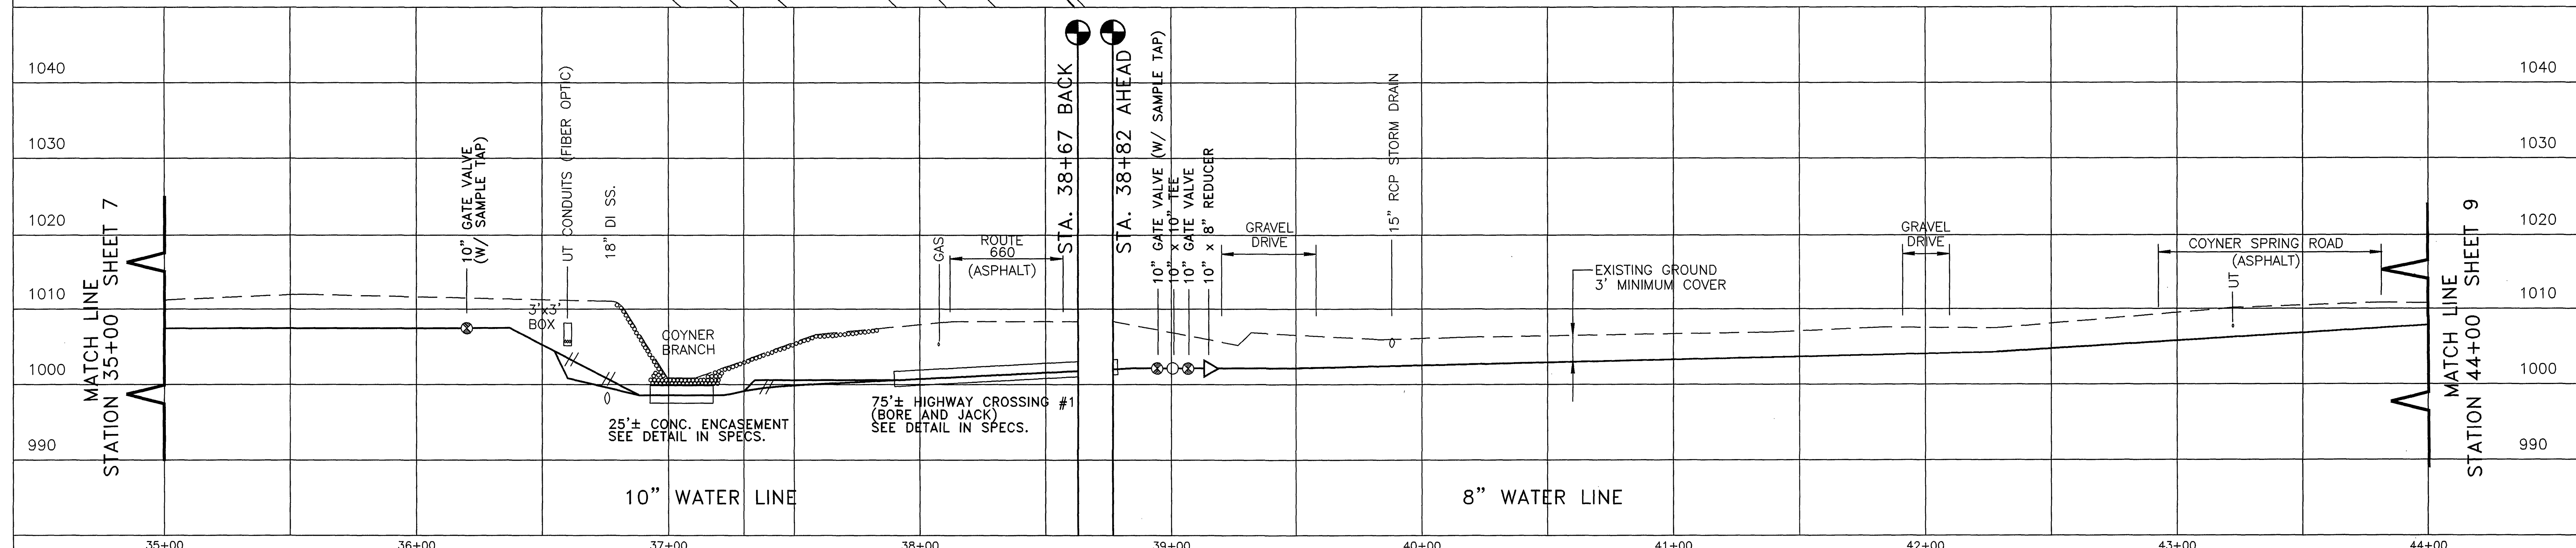

Mattern & Craig CONSULTING ENGINEERS - SURVEYORS	DESIGNED: BCC			REV.	DATE	DESCRIPTION	BY	APP.	DATE	COYNER SPRINGS WATER LINE PLAN AND PROFILE CITY OF ROANOKE, VIRGINIA SCALE: 1"=30' HORIZONTAL 1"=10' VERTICAL	SHEET	
	DRAWN: FMP											8
	CHECKED: SWH											