
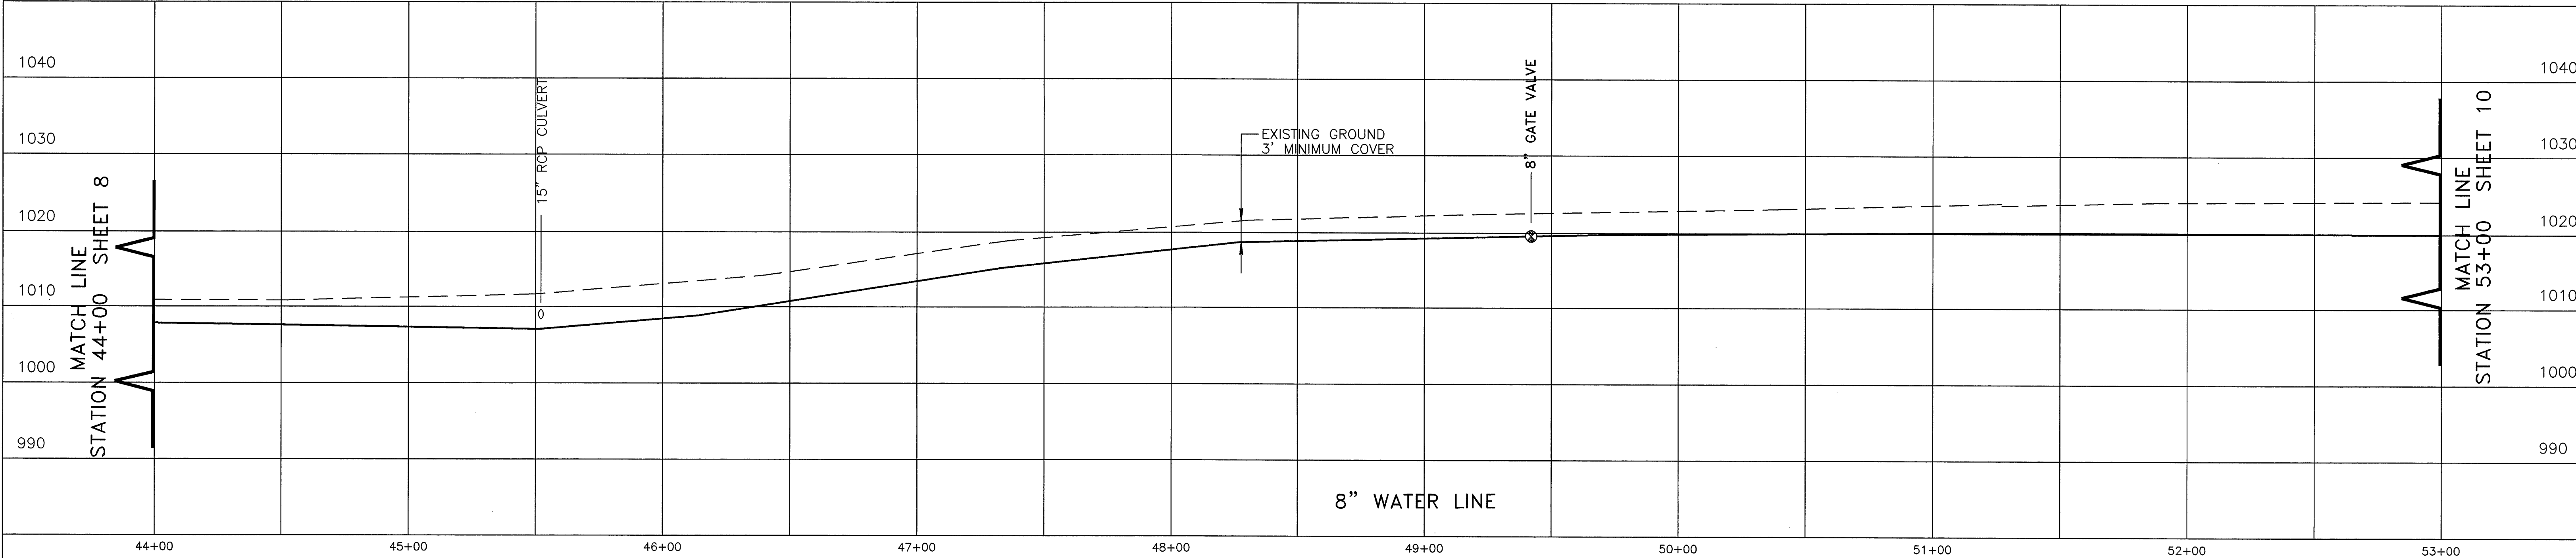
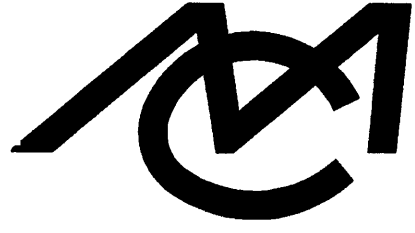
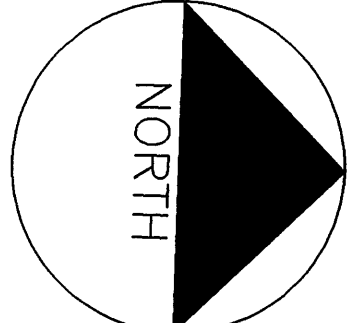


RECORD DRAWINGS

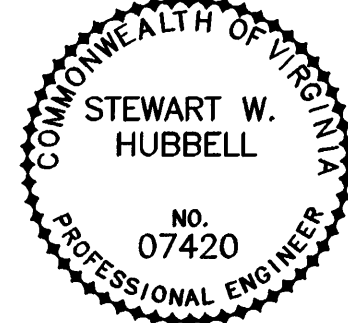

 Mattern & Craig CONSULTING ENGINEERS - SURVEYORS	DESIGNED: BCC			REV.	DATE	DESCRIPTION	BY	APP.	<u>DATE</u> NOVEMBER 1995 <u>COMM. NO.</u> 1417	COYNER SPRINGS WATER LINE PLAN AND PROFILE CITY OF ROANOKE, VIRGINIA SCALE: 1"=30' HORIZONTAL 1"=10' VERTICAL	<u>SHEET</u> 9	
	DRAWN: FMP											
	CHECKED: SWH											