







RECORD DRAWINGS

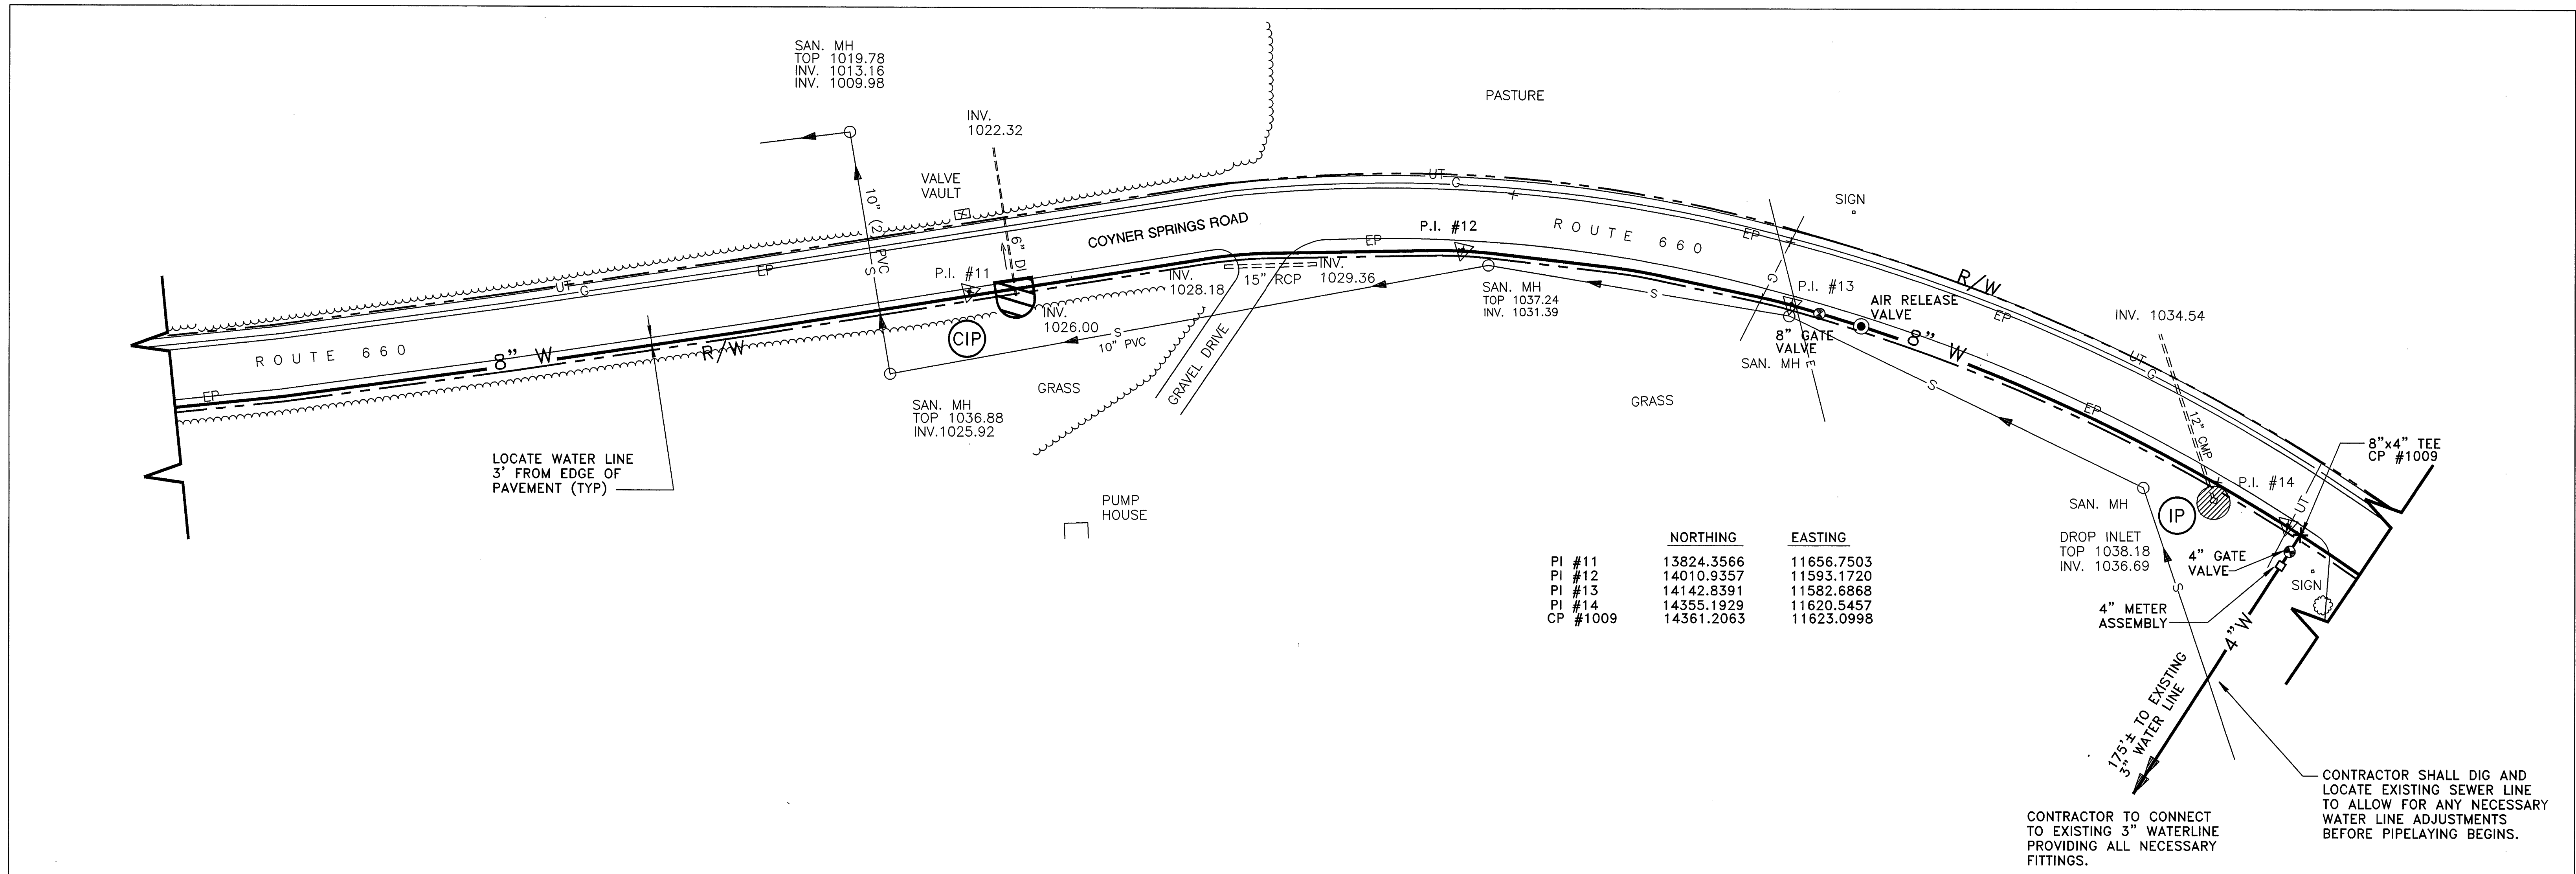

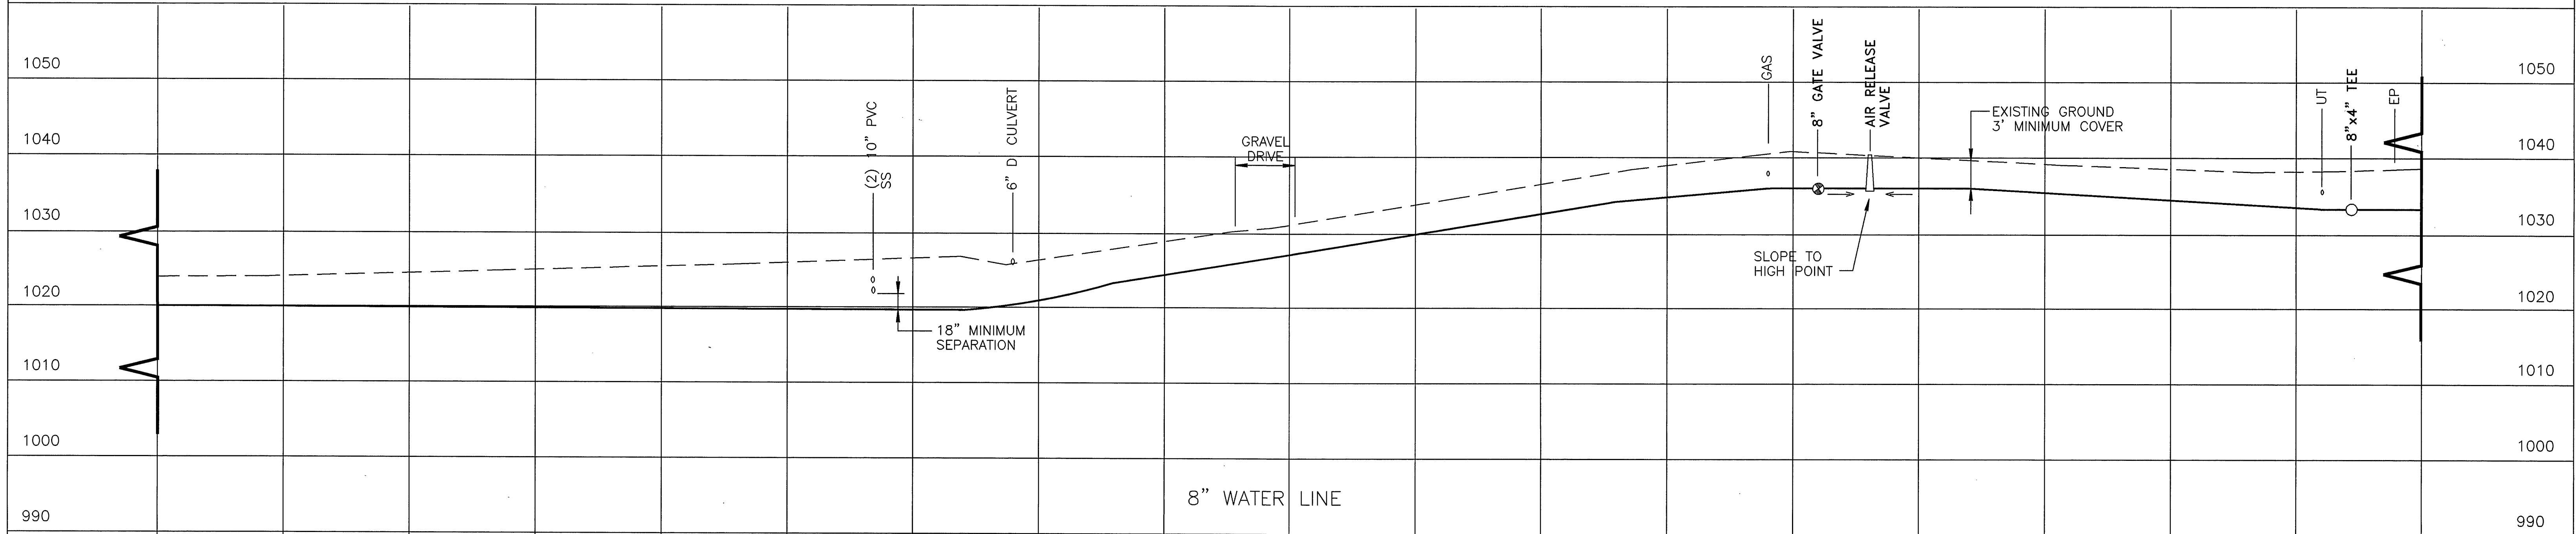

Mattern & Craig
CONSULTING ENGINEERS – SURVEYORS

DESIGNED: BCC
DRAWN: FMP
CHECKED: SWH

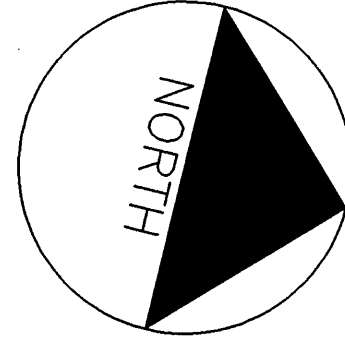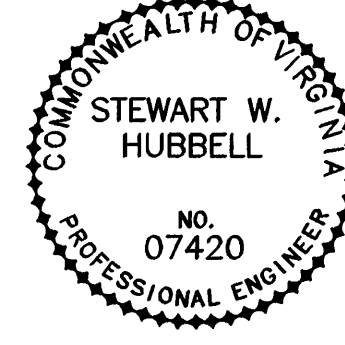REV.	DATE	DESCRIPTION	BY	APP.

DATE: NOVEMBER 1995
COMM. NO.: 1417

COYNER SPRINGS WATER LINE
PLAN AND PROFILE
CITY OF ROANOKE, VIRGINIA

SCALE: 1"=30' HORIZONTAL
1"=10' VERTICAL

SHEET 10