
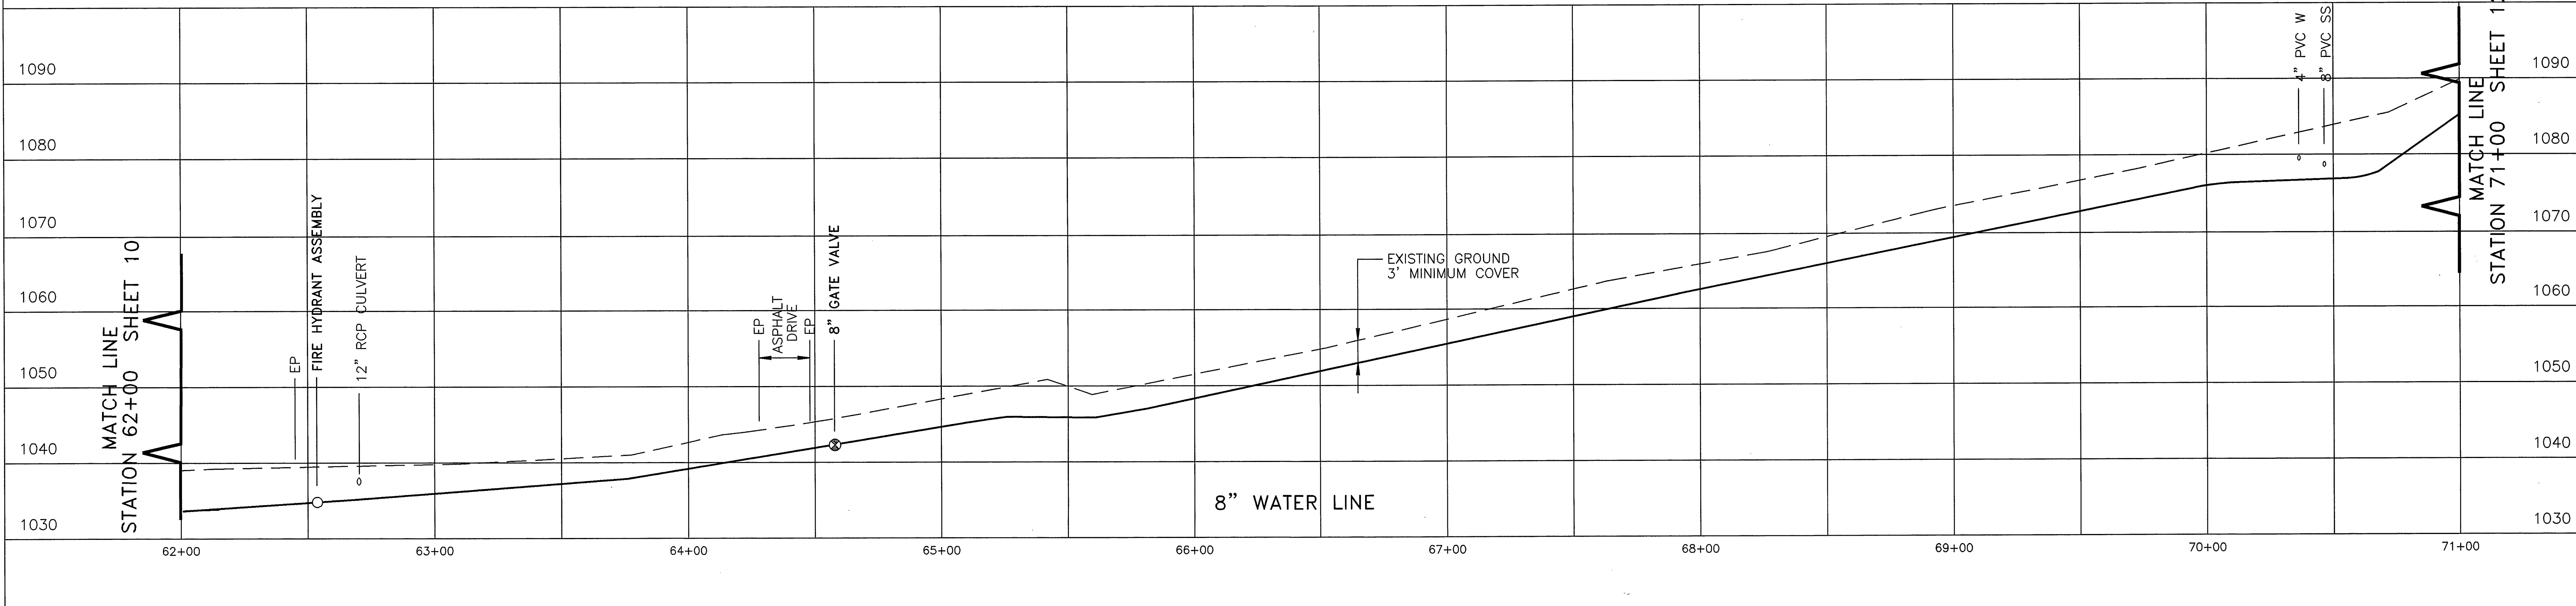
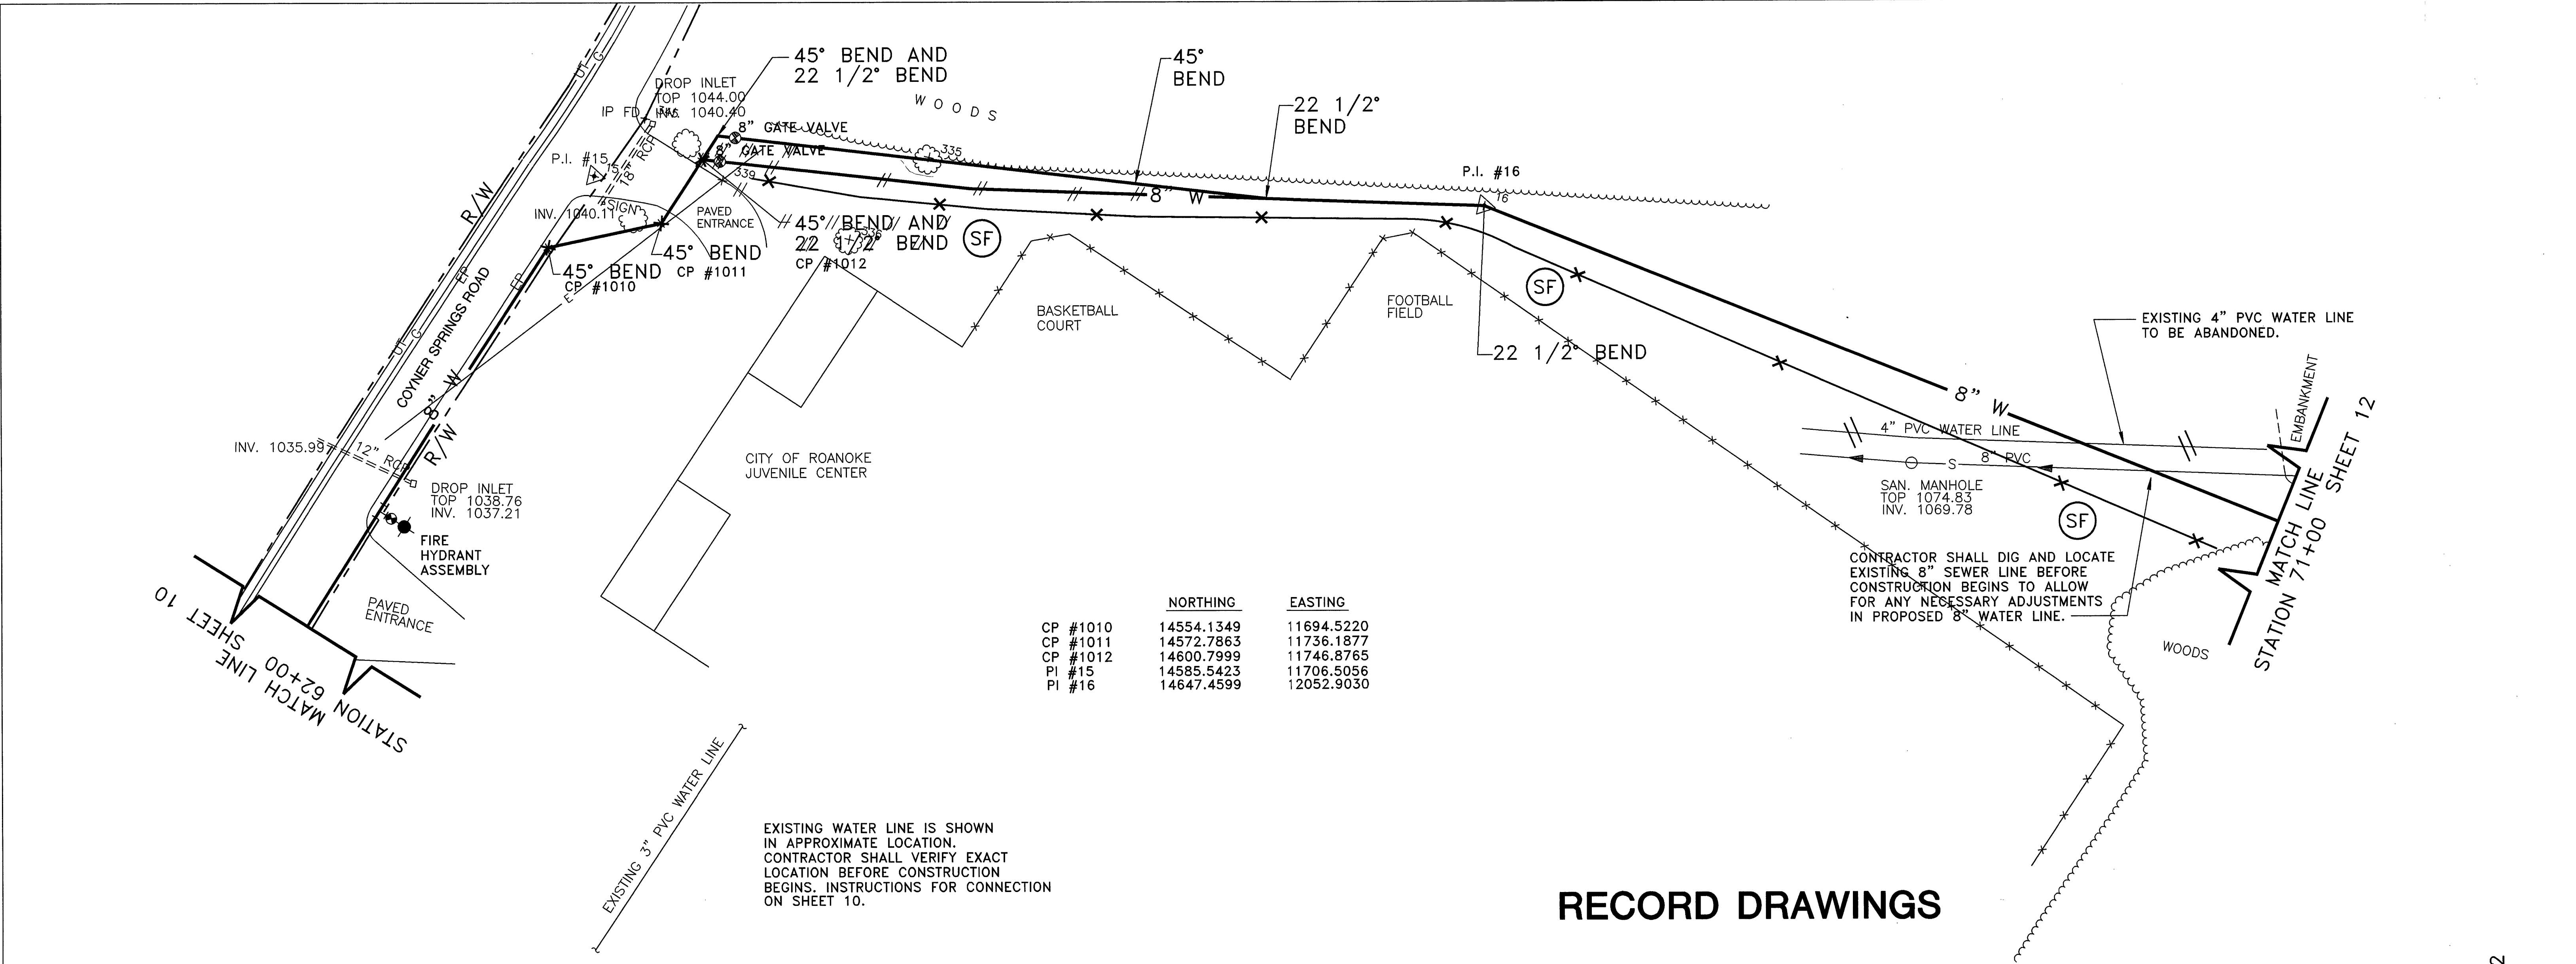
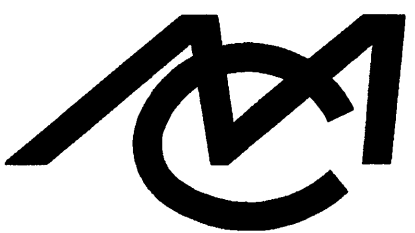
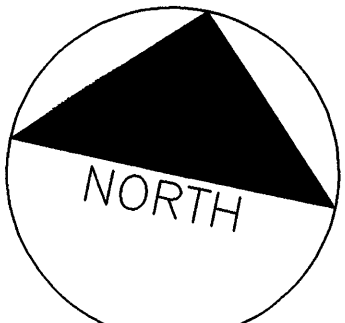


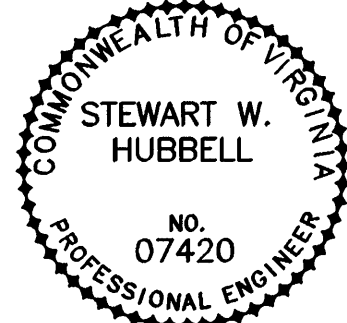

 Mattern & Craig CONSULTING ENGINEERS - SURVEYORS	DESIGNED: BCC			REV.	DATE	DESCRIPTION	BY	APP.	DATE	COYNES SPRINGS WATER LINE PLAN AND PROFILE CITY OF ROANOKE, VIRGINIA SCALE: 1"=30' HORIZONTAL 1"=10' VERTICAL	SHEET 11
	DRAWN: FMP								NOVEMBER 1995		
	CHECKED: SWH								COMM. NO. 1417		