



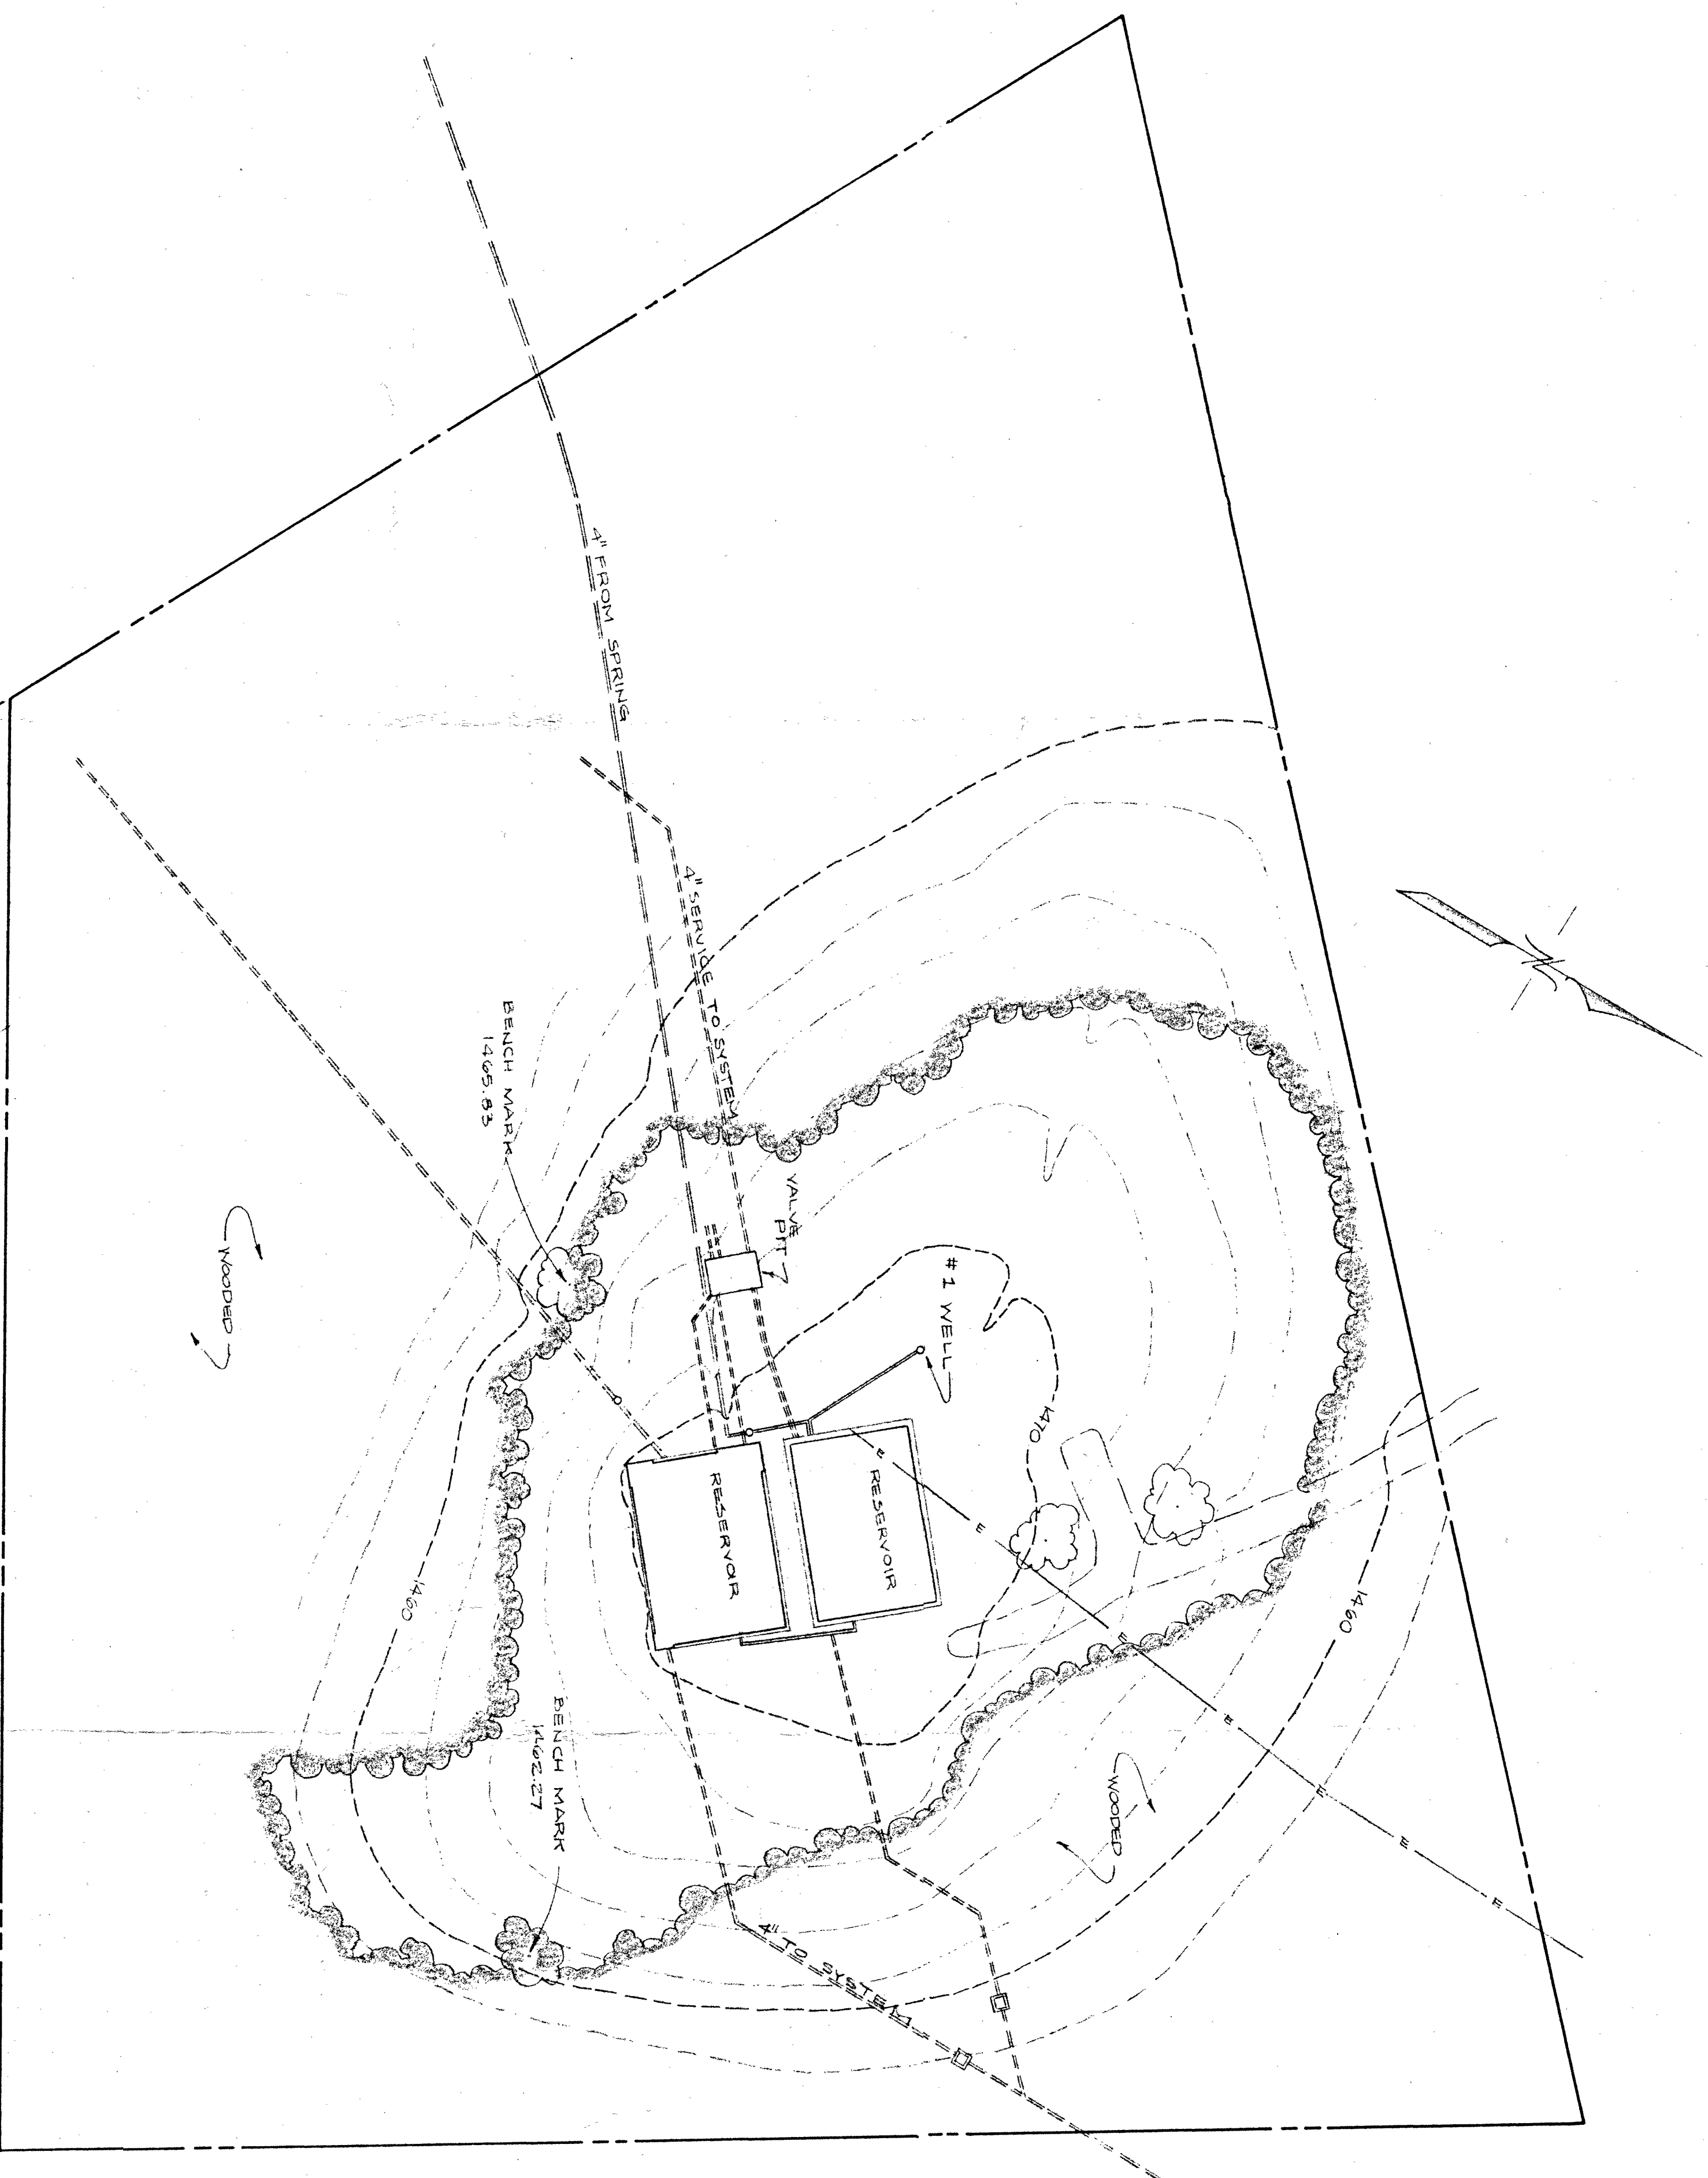


EXISTING SITE PLAN

1" = 20'

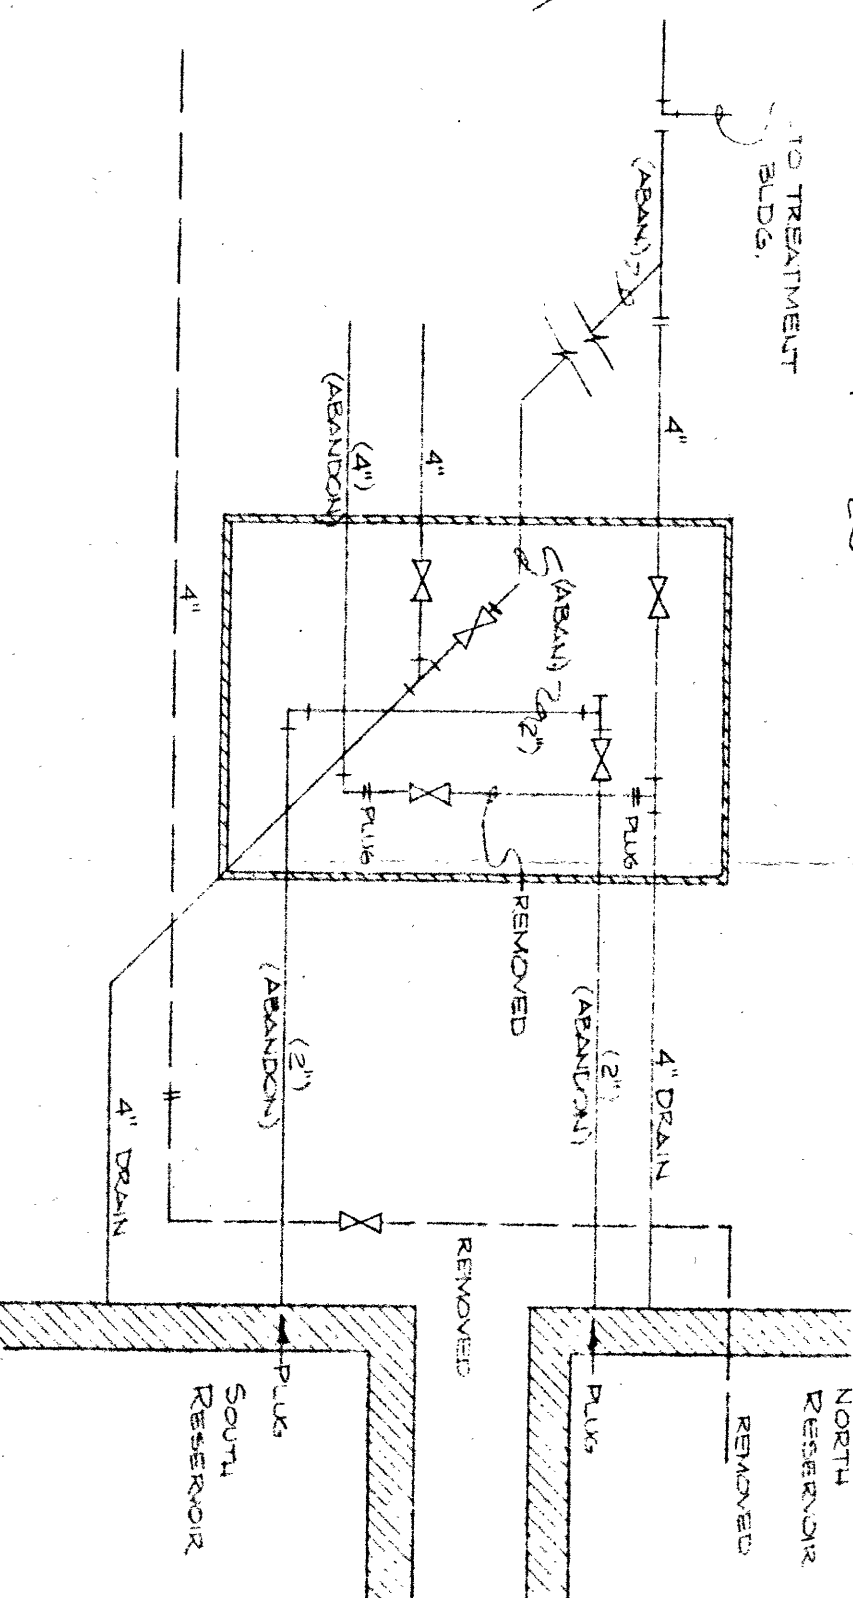


VALVE SHED DETAIL

NOT TO SCALE

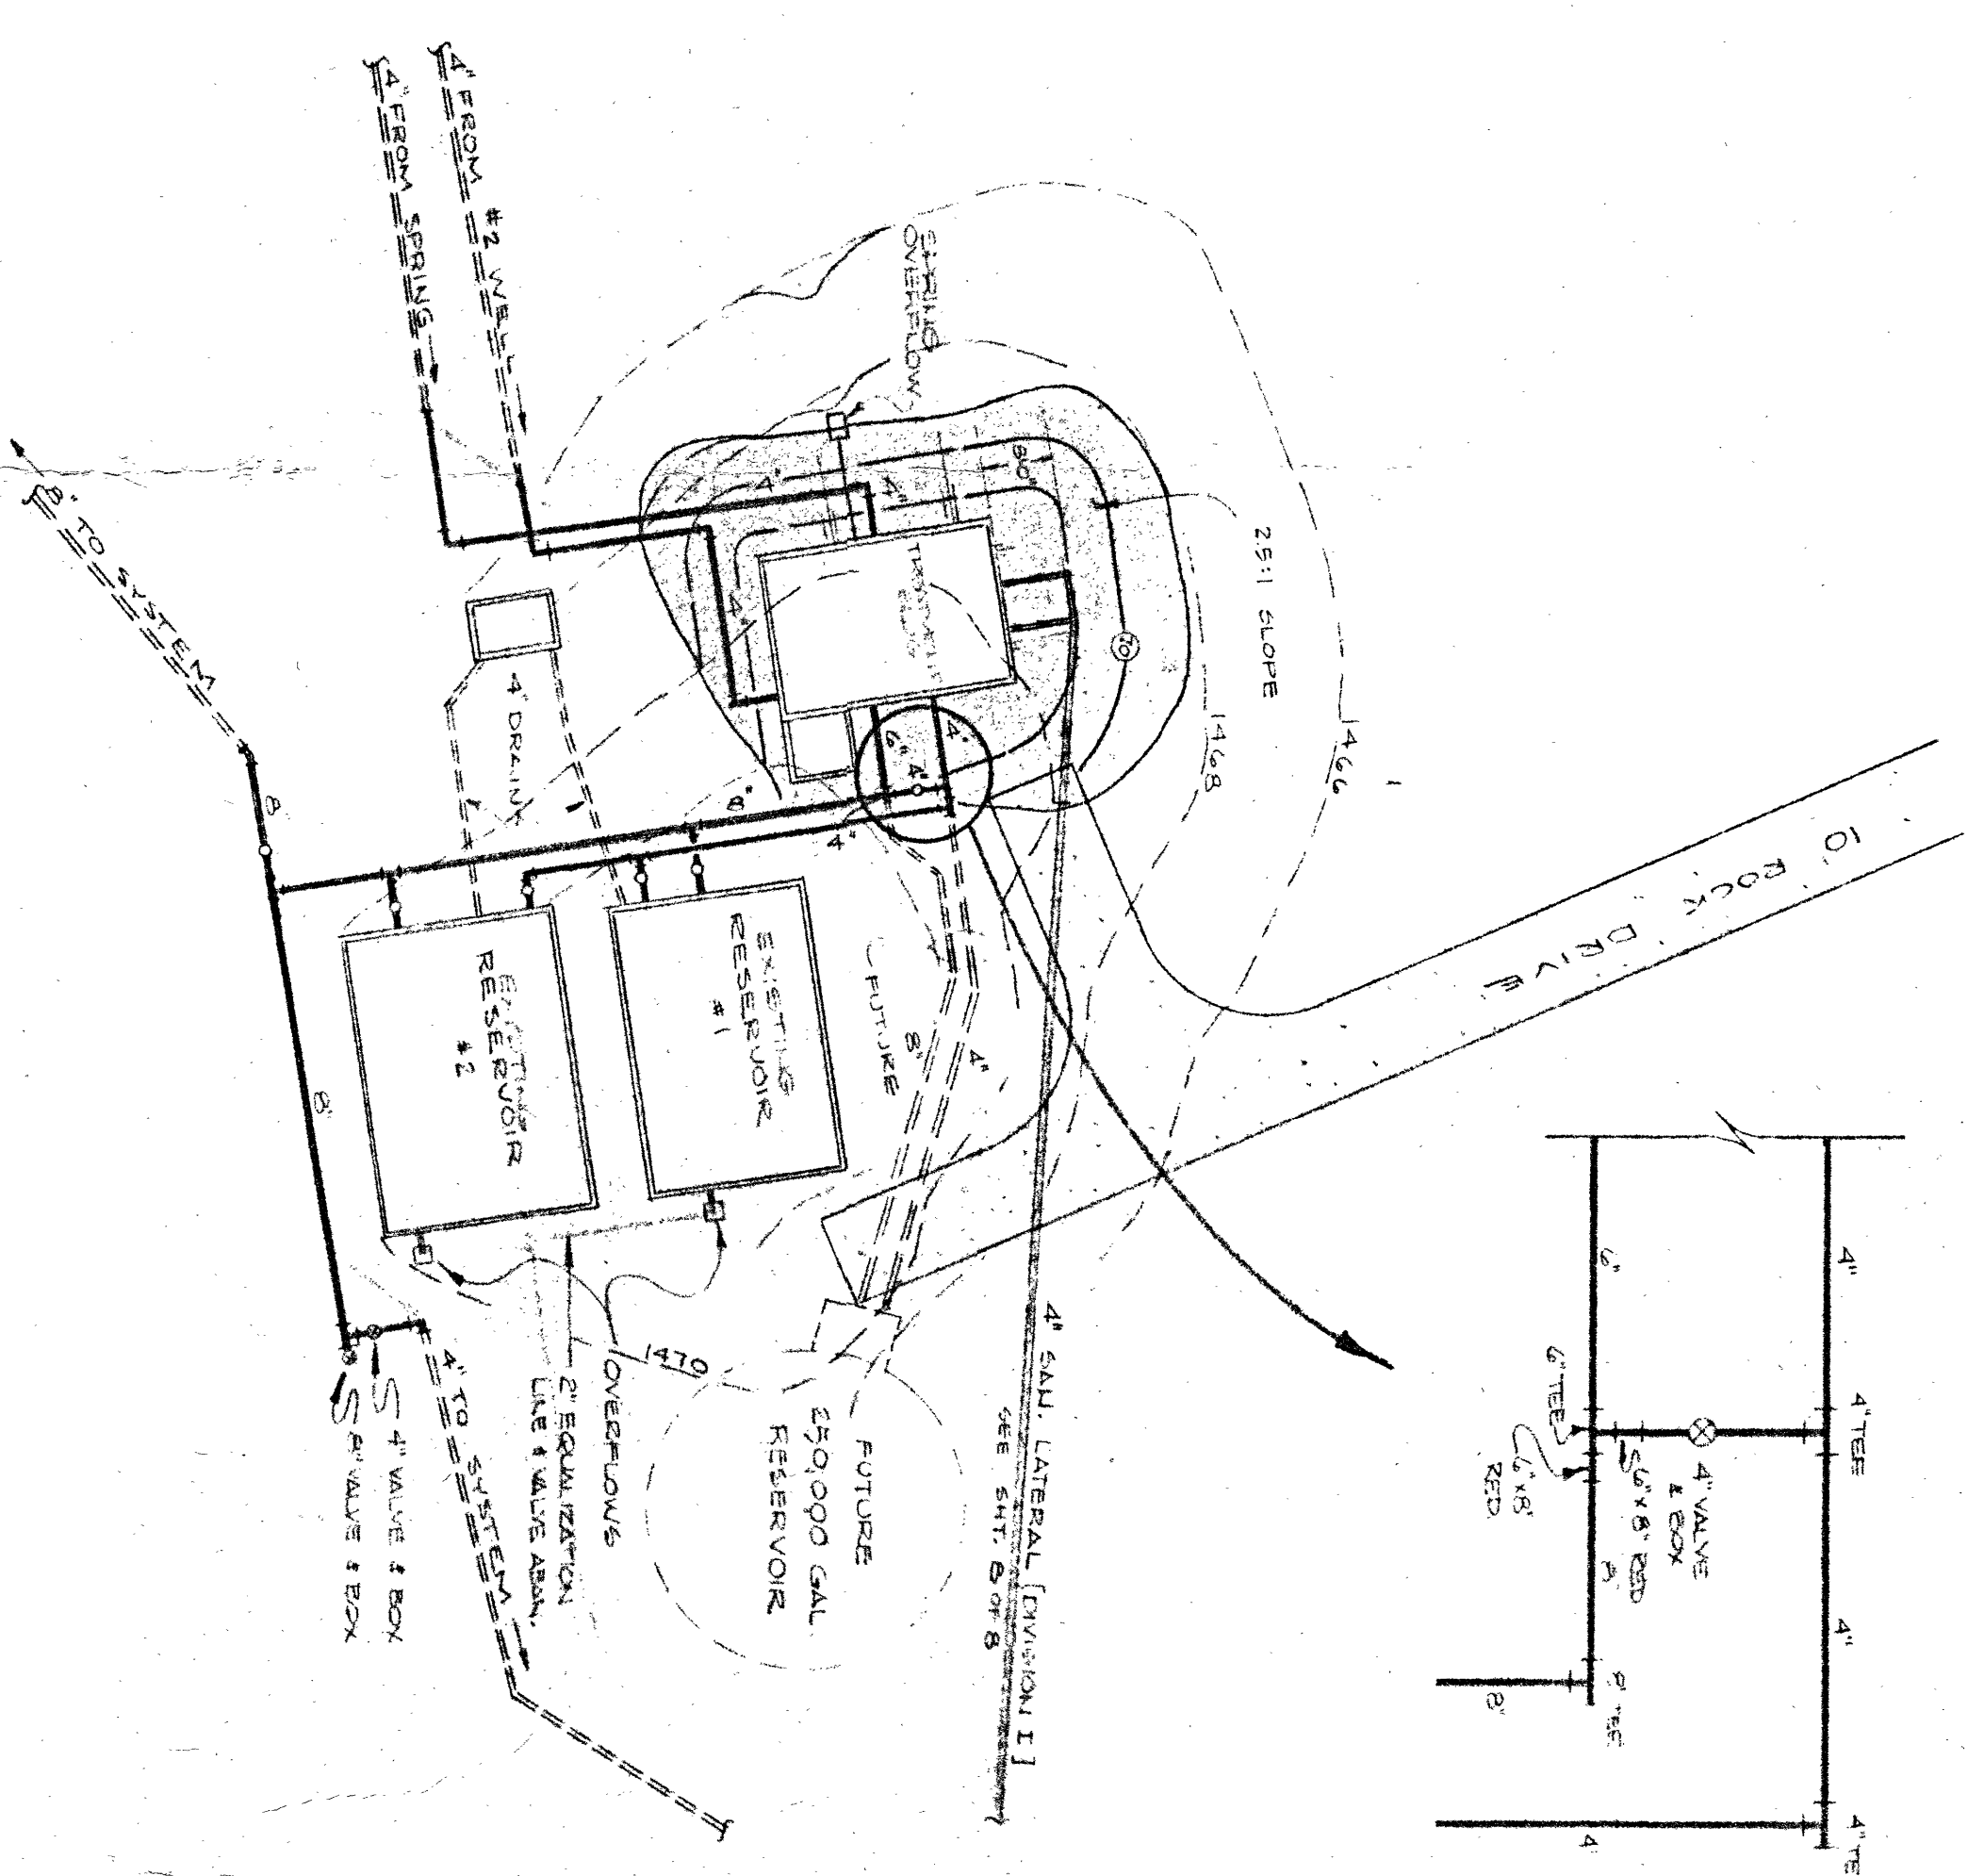

PROPOSED SITE PLAN

1" = 20'

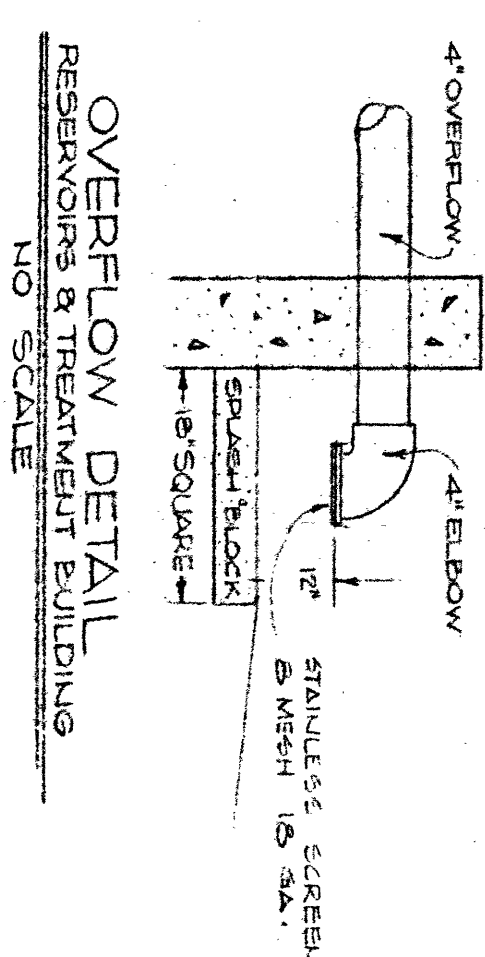

OVERFLOW DETAIL
RESERVOIRS & TREATMENT BUILDING

NO SCALE

ANDERSON & ASSOCIATES
BLACKSBURG
CONSULTING ENGINEERS
VIRGINIA

NEW CASTLE
WATER SYSTEM IMPROVEMENTS

SITE PLAN - RESERVOIR

DATE: 21 MARCH 1980
SCALE: AS SHOWN
DESIGNED: G.S.C.
CHECKED: S.V.A.
REVISIONS
JUN 1977
SHEET
14 OF 8