

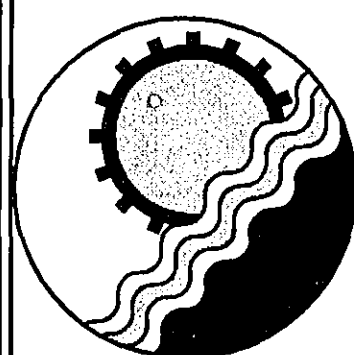


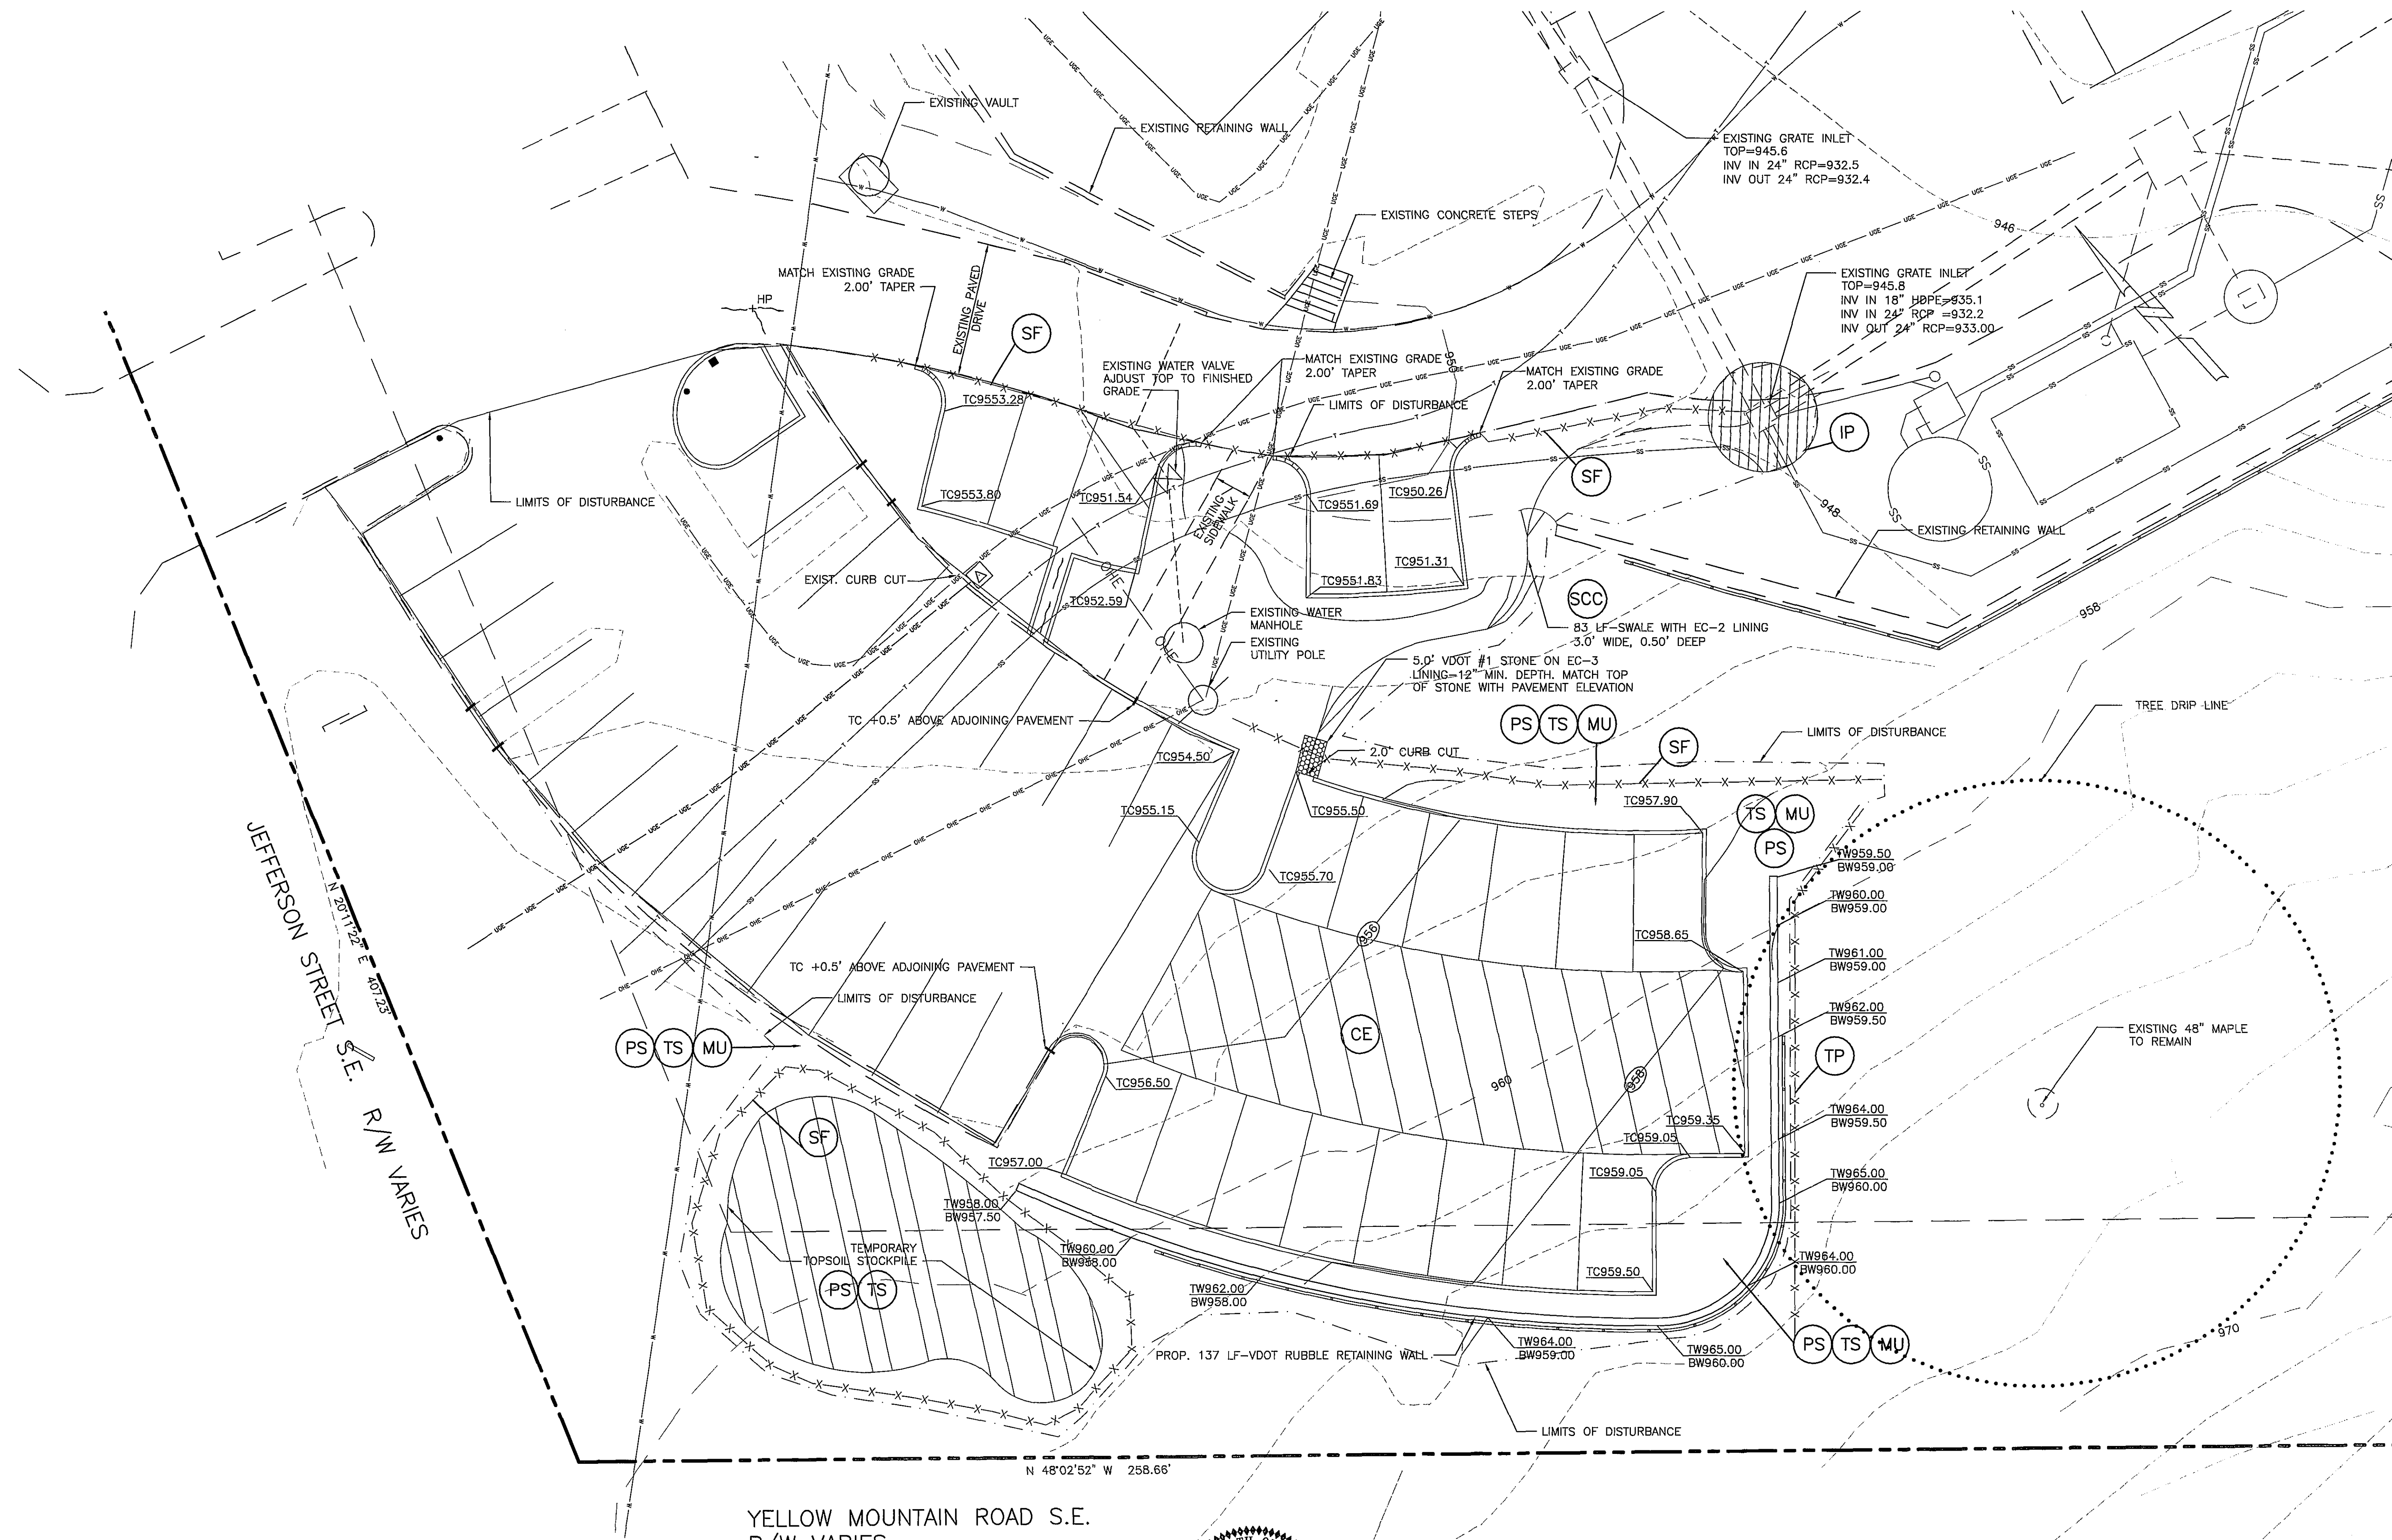

ENGINEERING CONCEPTS, INC.
 3433 BRAMBLETON AVENUE, SUITE 200B
 ROANOKE, VIRGINIA 24018
 540.776.5715 FAX: 540.776.8543

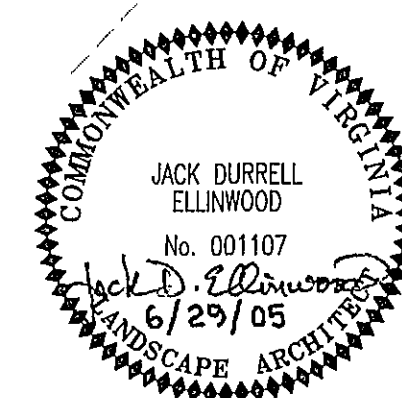

No.	Revision	By	Appd.	Date	Drawn	DRB
1	REV PER CITY COMMENTS 7/5/05	DRB	JDE	8/1/05	Designed	JDE
					Checked	JDE
					Approved	JDE

**WESTERN VIRGINIA WATER AUTHORITY
 PARKING LOT EXPANSION**
**GRADING & EROSION CONTROL PLAN
 ROANOKE, VIRGINIA**

SCALE: 1"=10'
 JUNE 29, 2005
 PROJECT: 05052
6