
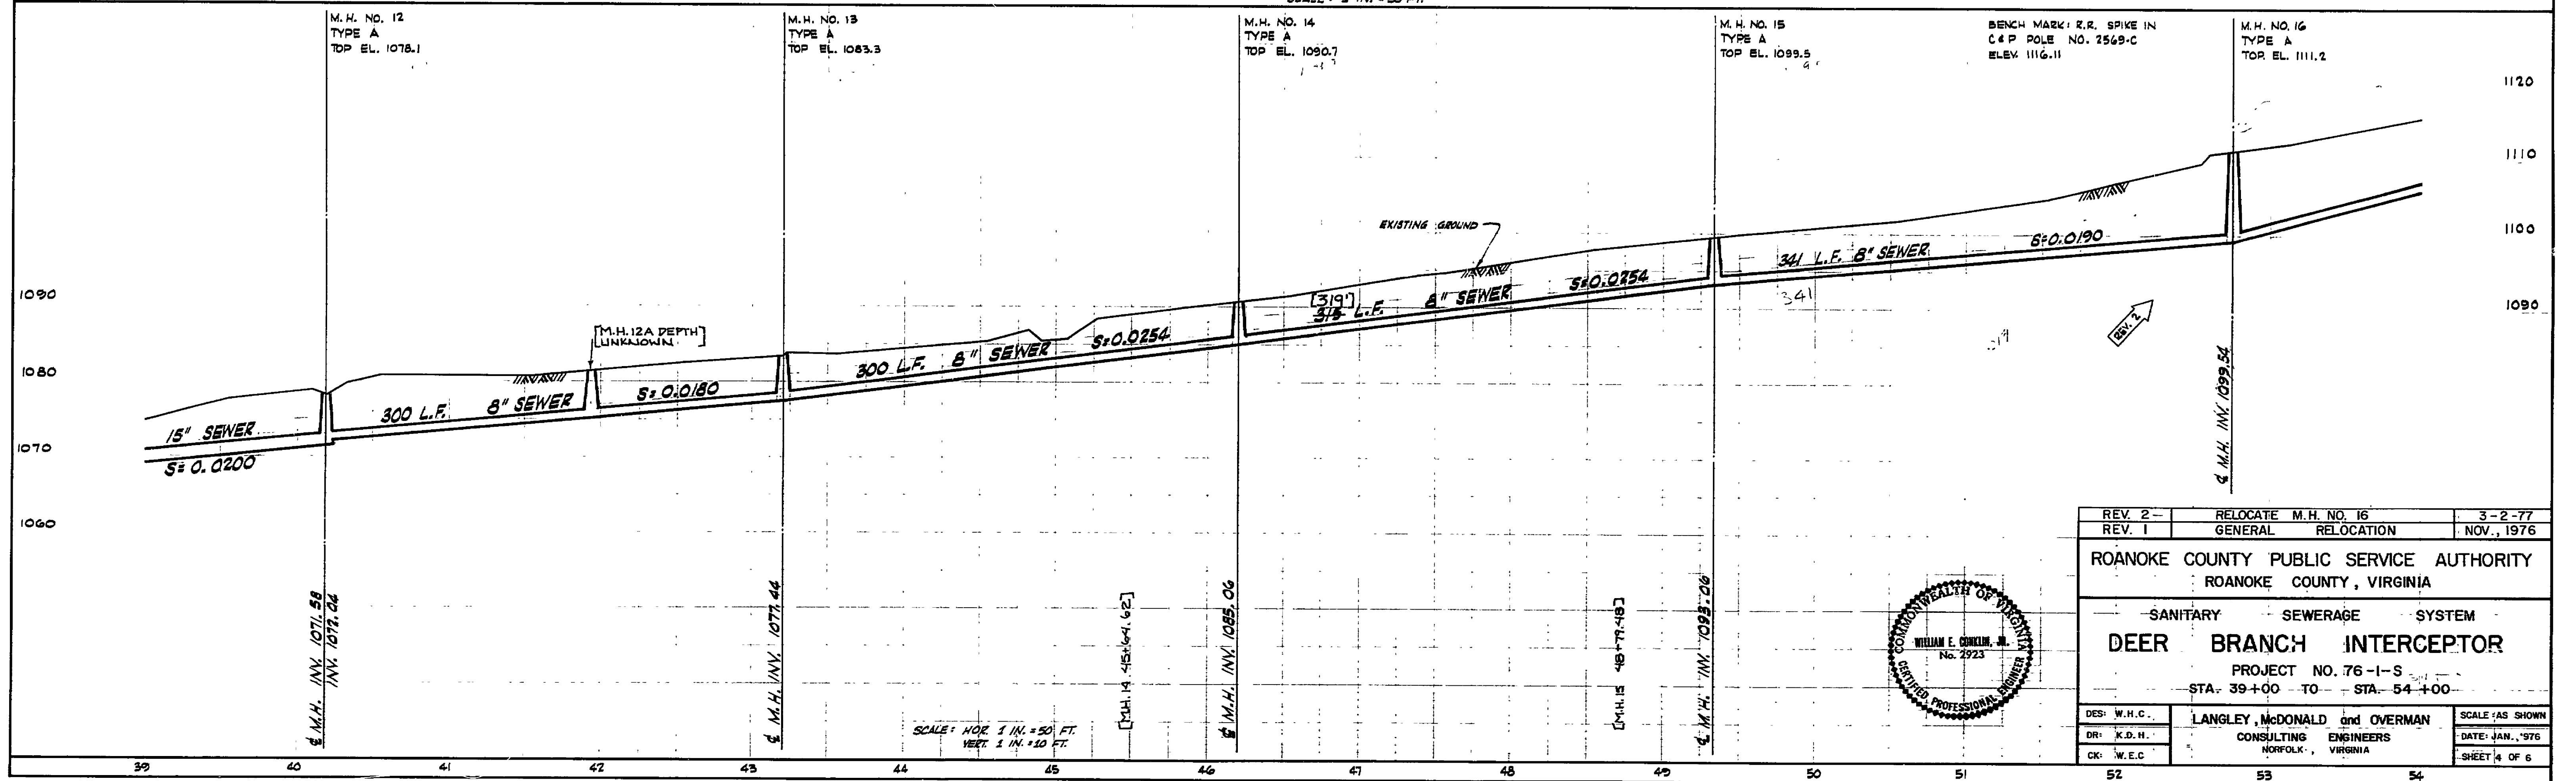


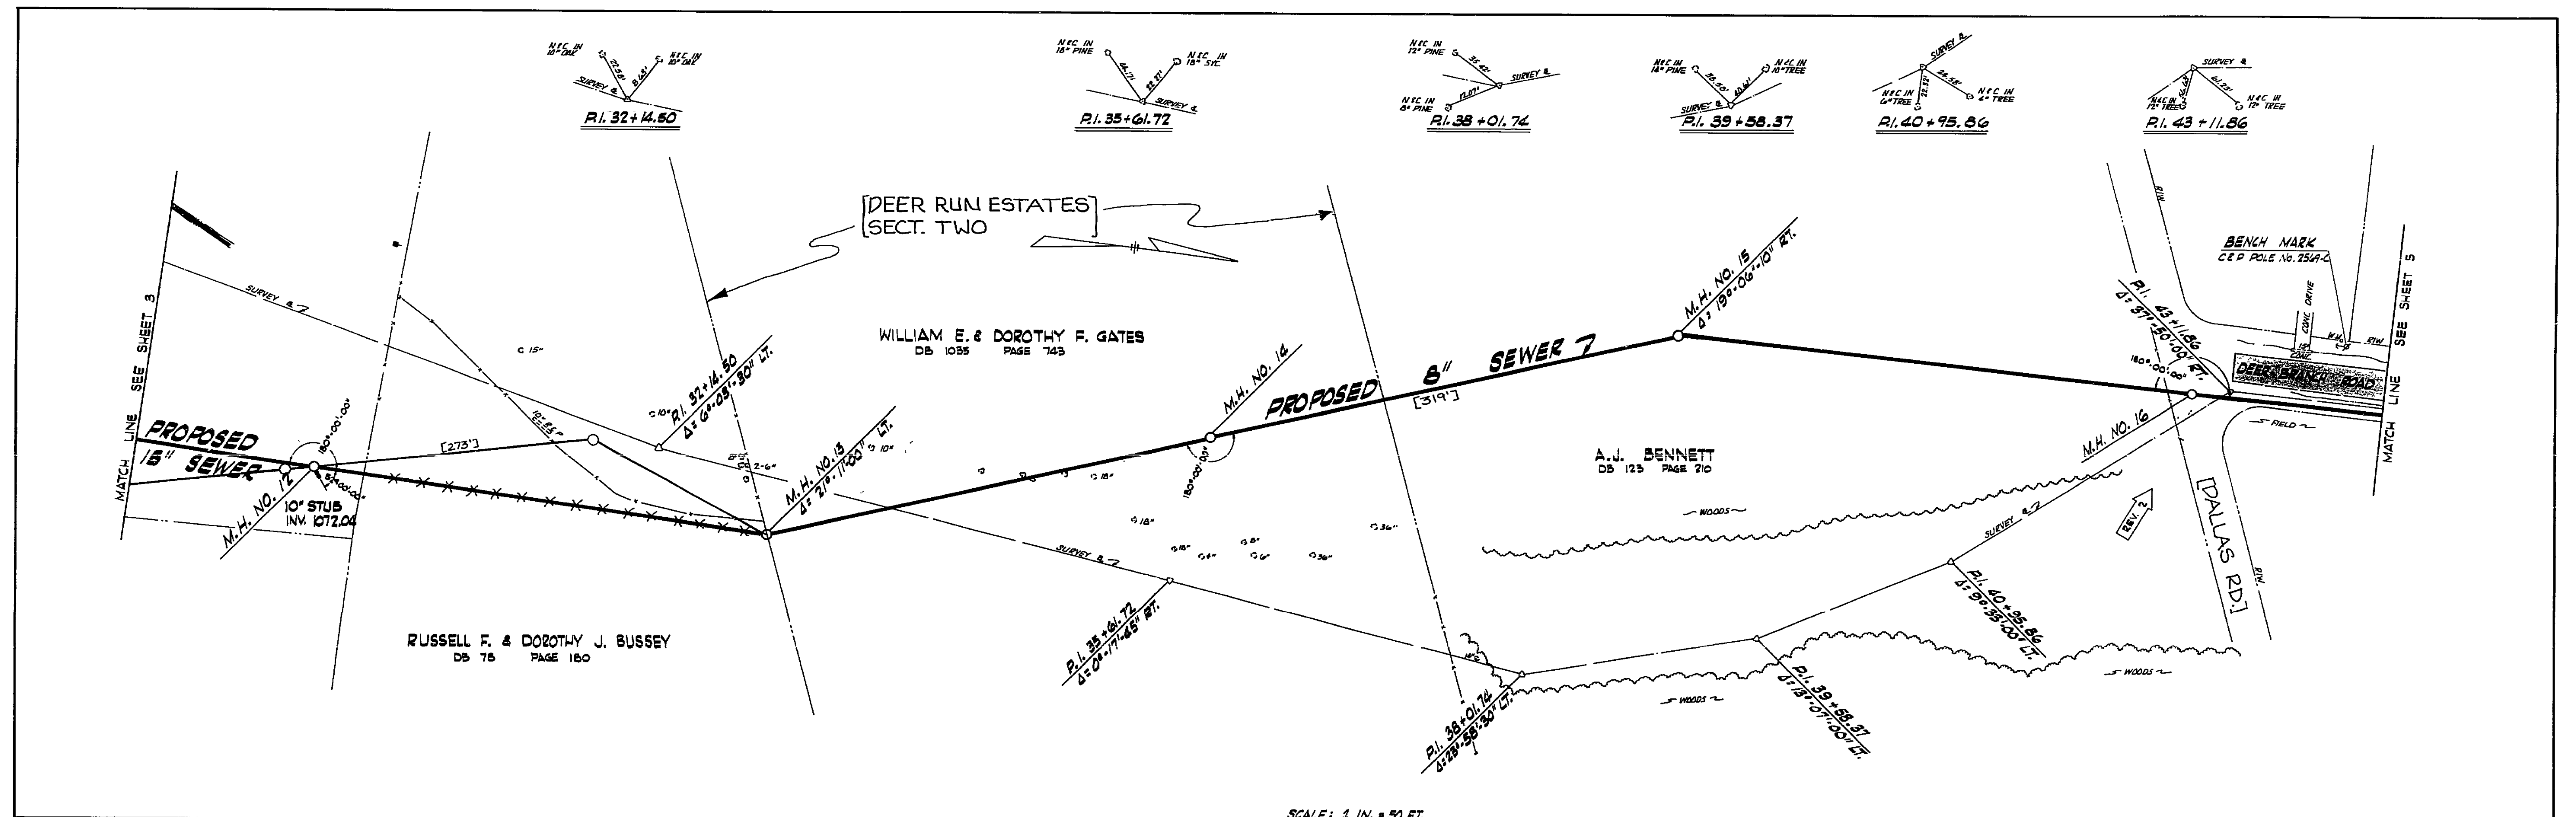

REV. 2 -	RELOCATE M.H. NO. 16	3-2-77
REV. 1	GENERAL RELOCATION	NOV., 1976
ROANOKE COUNTY PUBLIC SERVICE AUTHORITY ROANOKE COUNTY, VIRGINIA		
SANITARY SEWERAGE SYSTEM DEER BRANCH INTERCEPTOR		
PROJECT NO. 76-1-S STA. 39+00 TO STA. 54+00		
DES: W.H.C.	LANGLEY, McDONALD and OVERMAN	SCALE: AS SHOWN
DR: K.D.H.	CONSULTING ENGINEERS	DATE: JAN., '76
CK: W.E.C.	NORFOLK, VIRGINIA	SHEET 4 OF 6

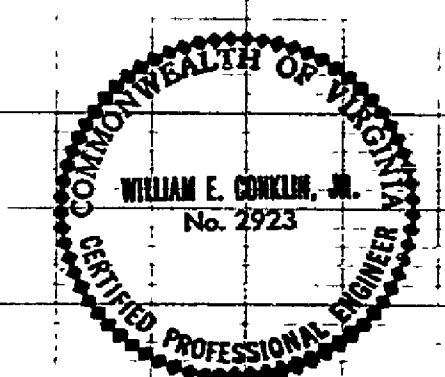


PLATE 15 SINGLE PLAN AND PROFILE FULL LINE
1 IN. = 10 FT. VERT. 1 IN. = 50 FT. HOR.

