

PROFILE	SURVEYED	BY	DATE
	NOTED		
	GRADES CHECKED		
	STRUCTURE NOTATIONS CHECKED		

PLAN	SURVEYED	BY	DATE
	NOTED		
	ALIGNMENT CHECKED		
	PT. OF WAY CHECKED		

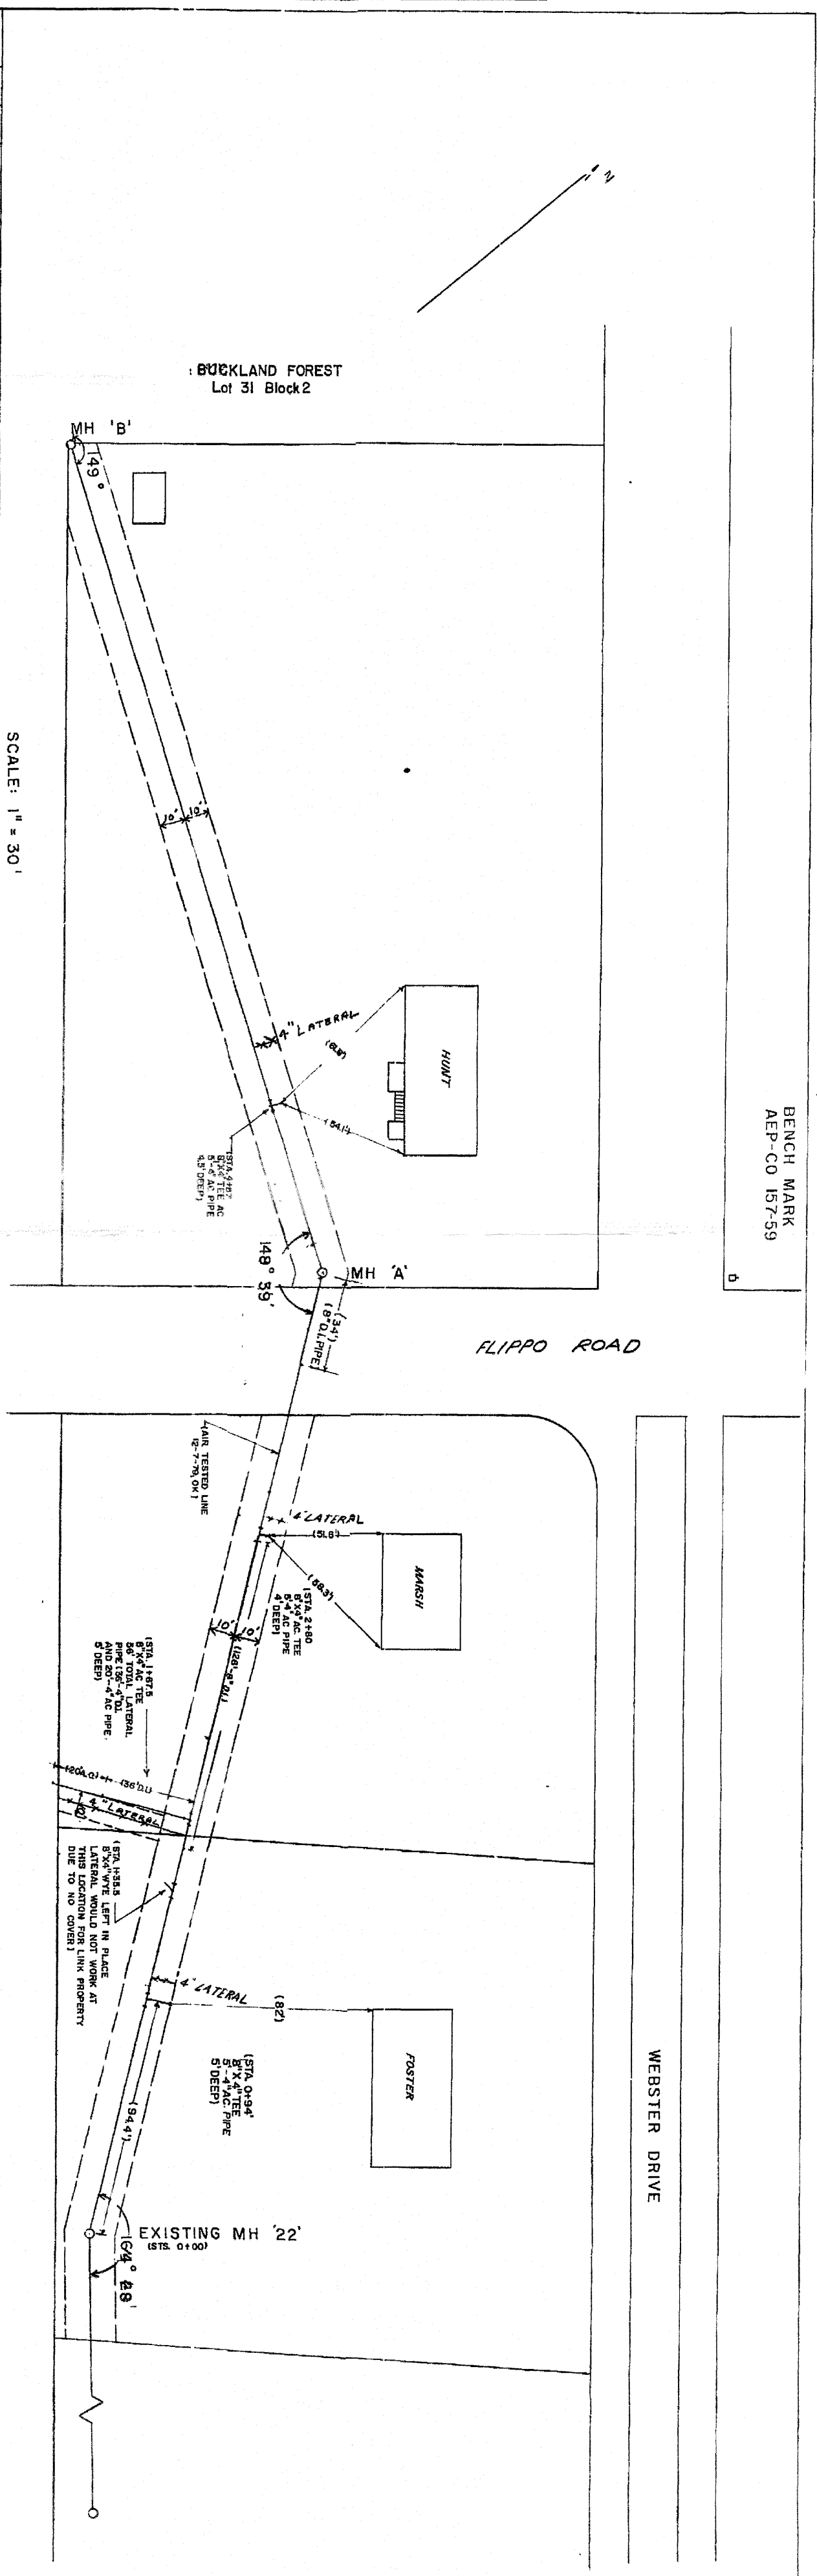
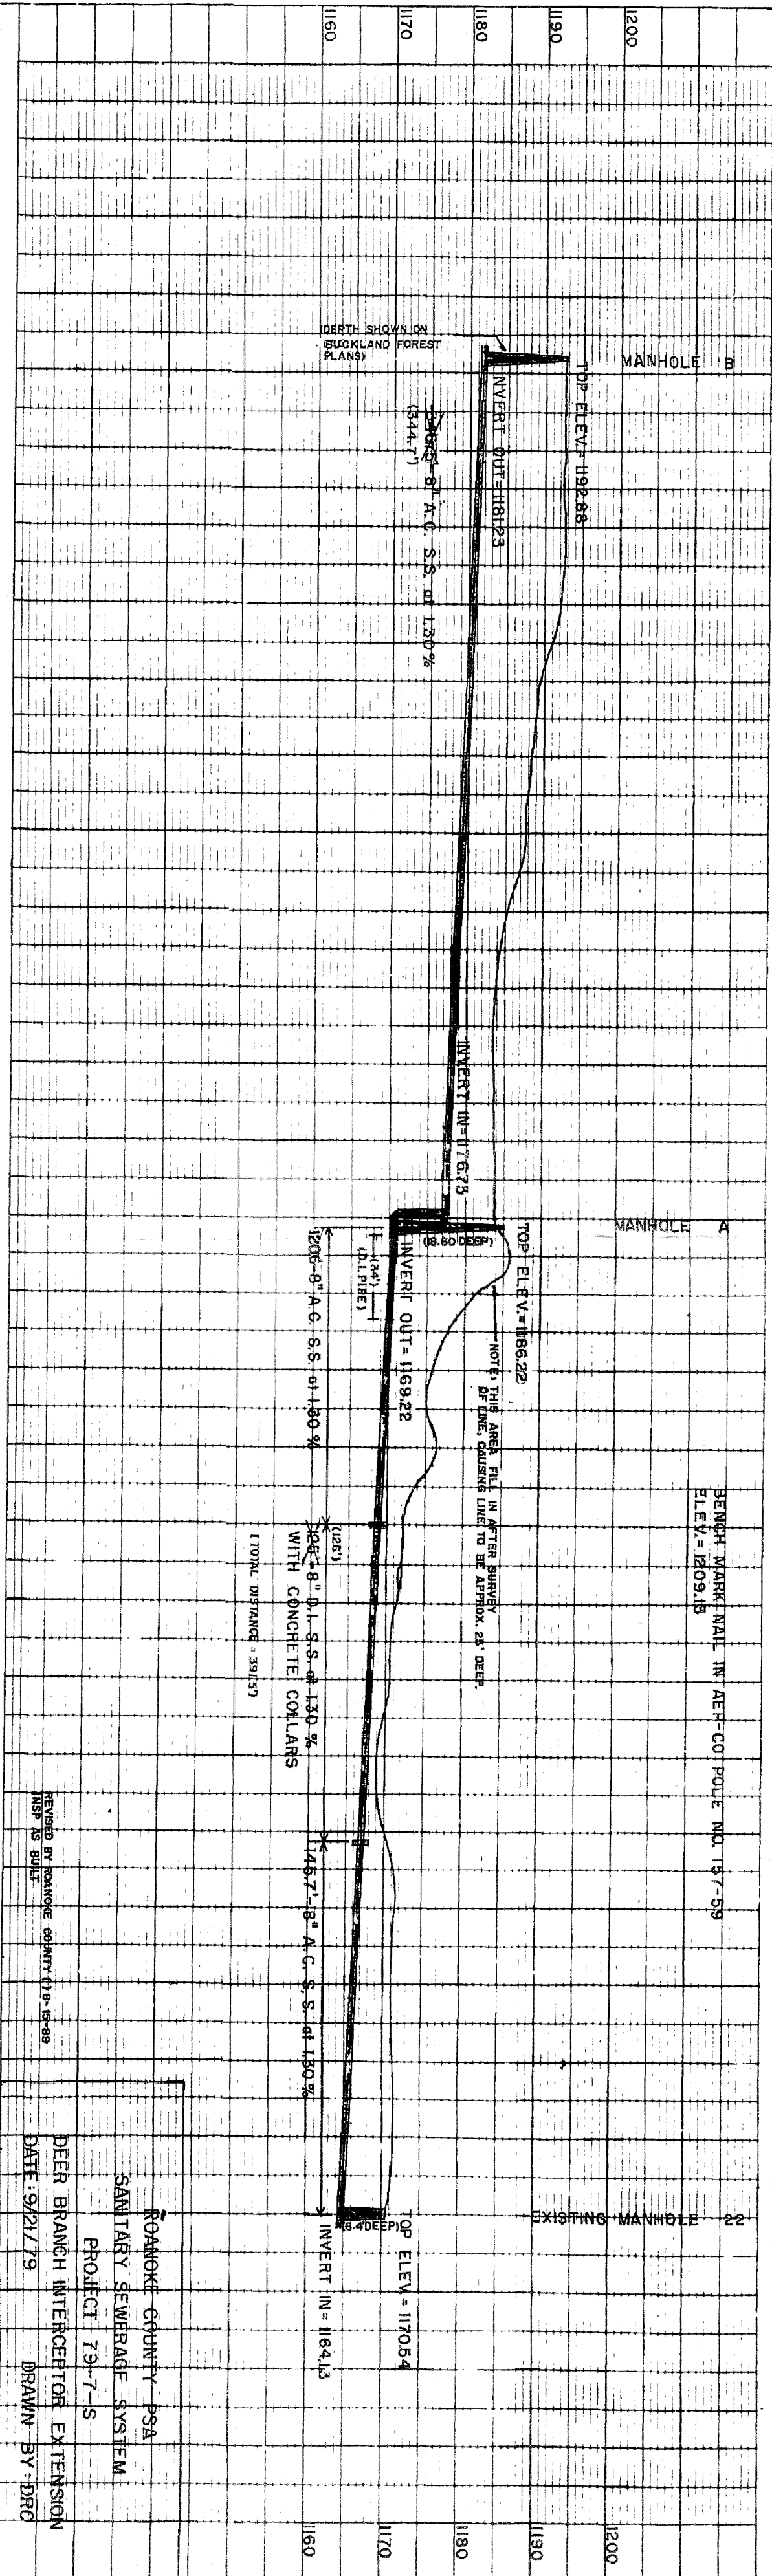


PLATE 1: SINGLE PLAN AND PROFILE-FULL LINE

SI-0117

ROANOKE COUNTY PSA
SANITARY SEWERAGE SYSTEM
PROJECT 79-7-S
DEER BRANCH INTERCEPTOR EXTENSION
DATE: 9/21/79
DRAWN BY: DRC