


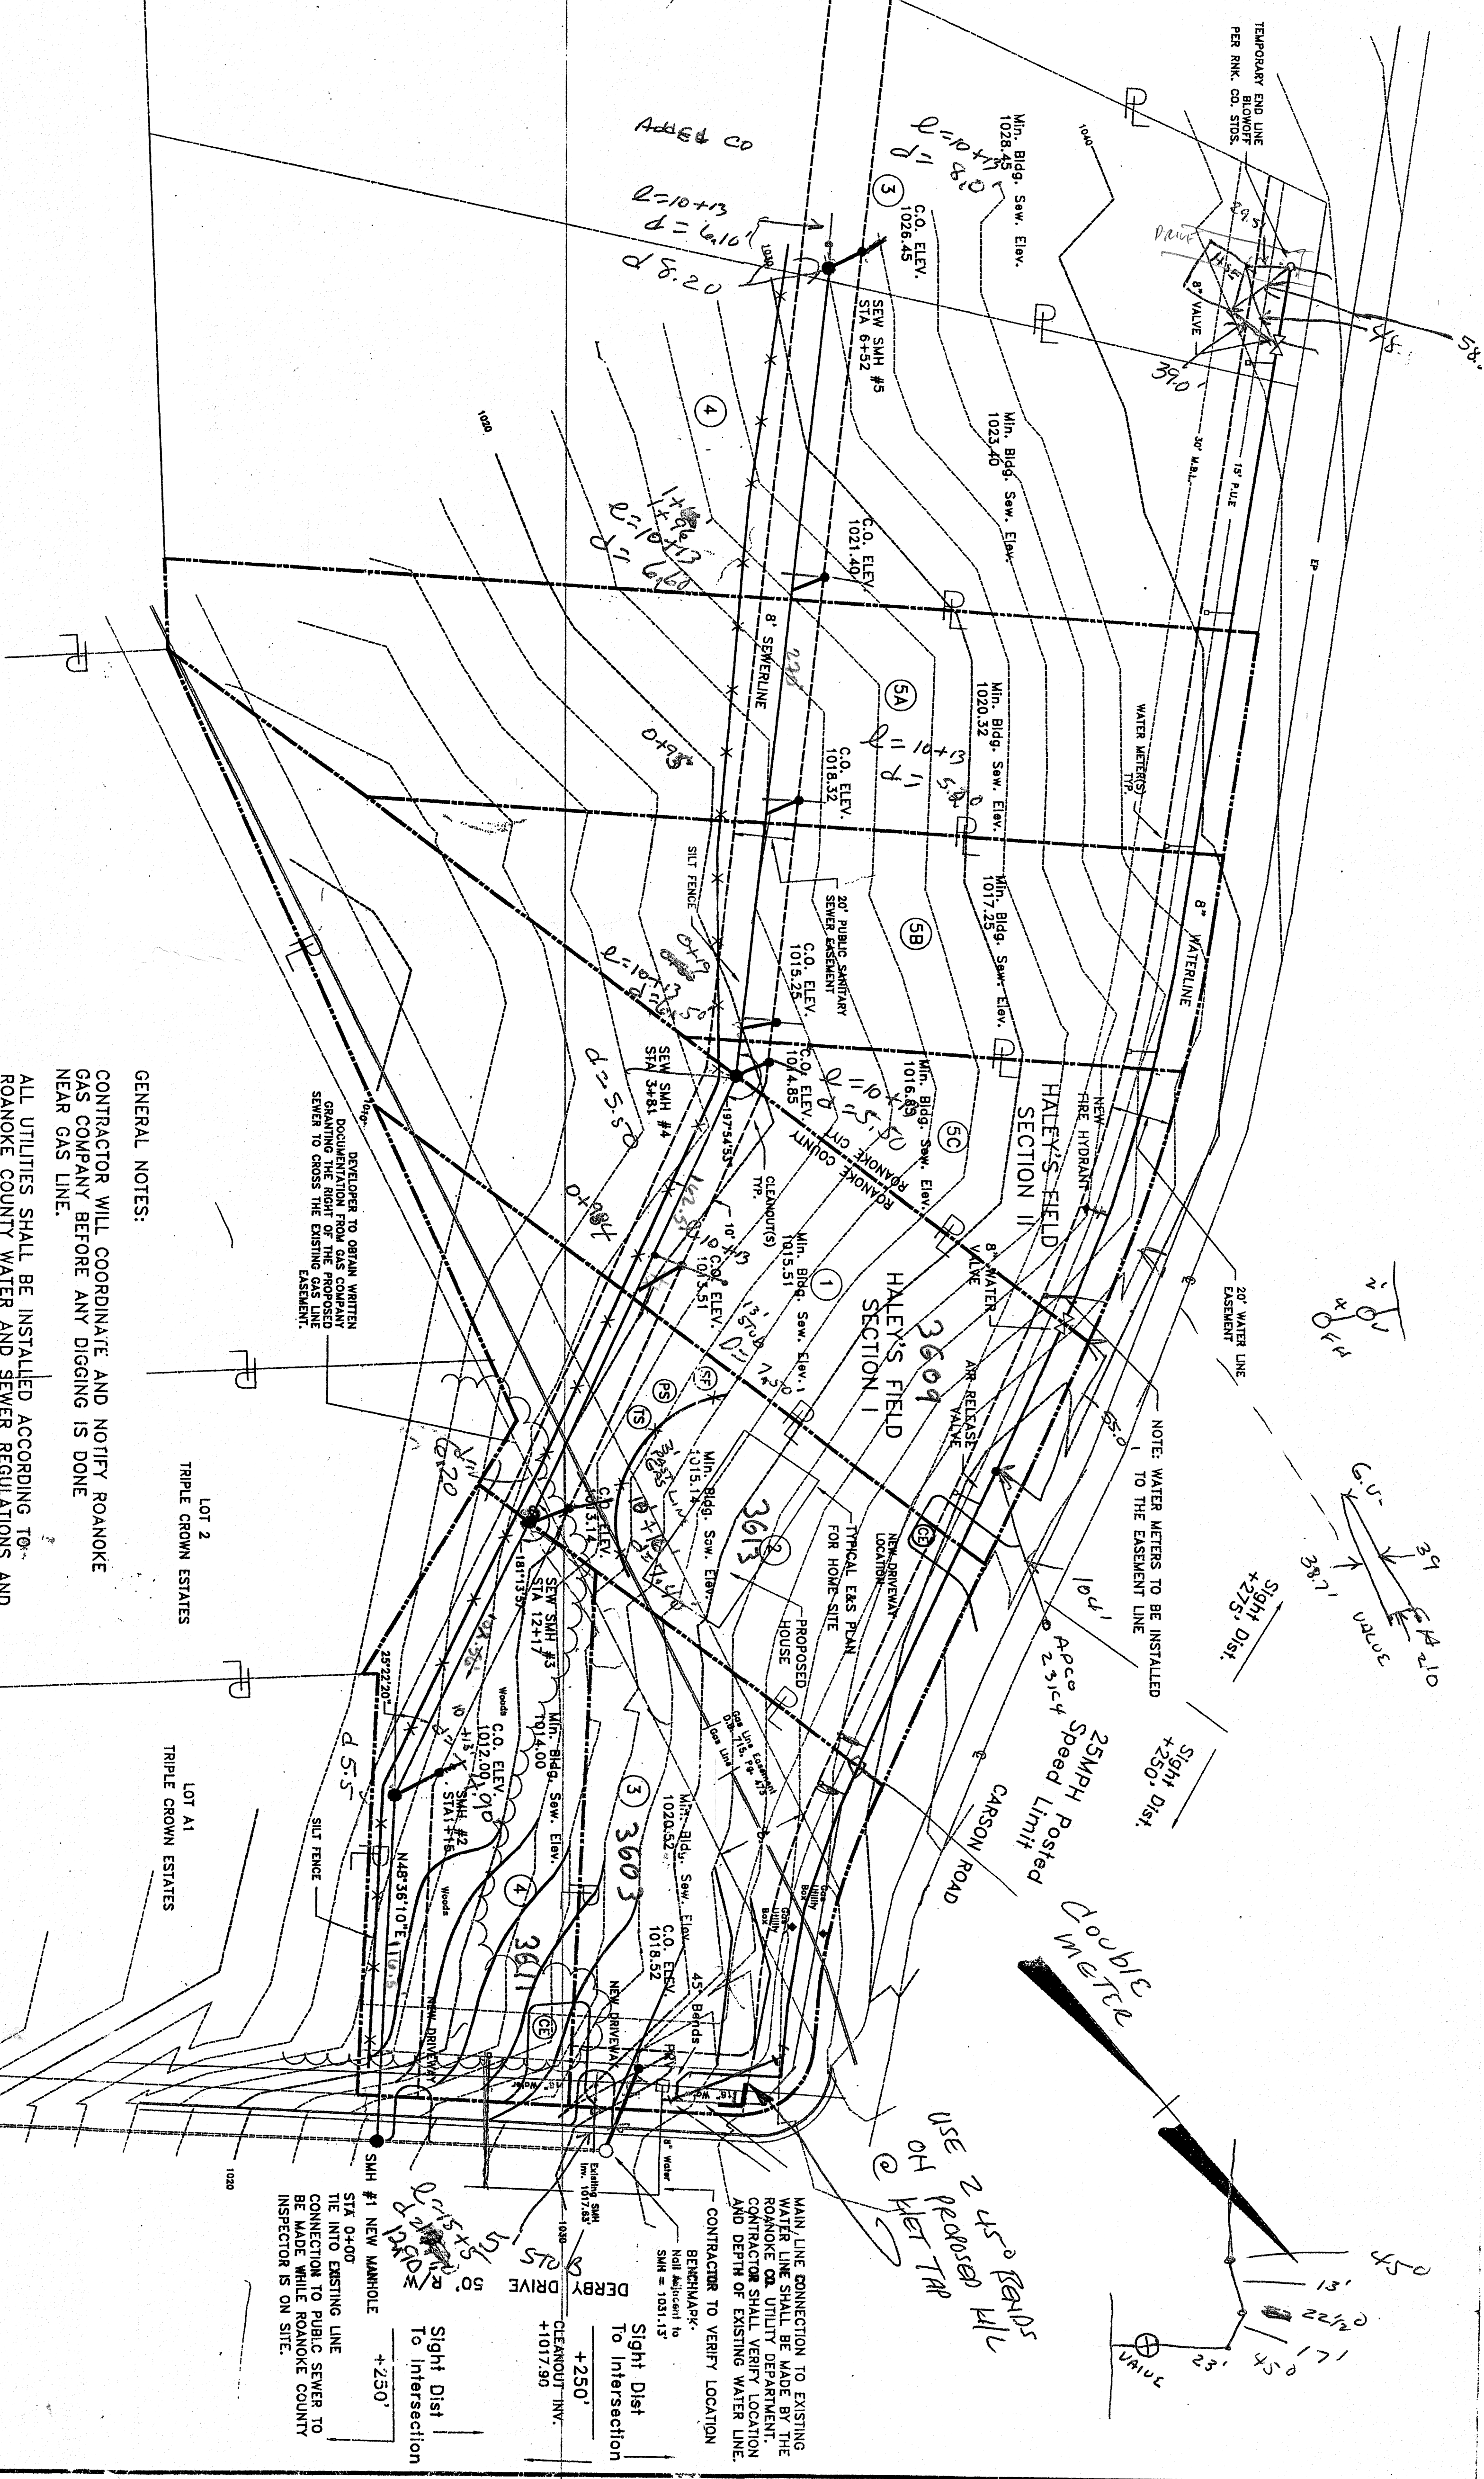

GENERAL NOTES:
CONTRACTOR WILL COORDINATE AND NOTIFY ROANOKE GAS COMPANY BEFORE ANY DIGGING IS DONE NEAR GAS LINE.
ALL UTILITIES SHALL BE INSTALLED ACCORDING TO ROANOKE COUNTY WATER AND SEWER REGULATIONS AND DRAINAGE STANDARDS AND THE VIRGINIA DEPARTMENT OF TRANSPORTATION.

PIERSON ENGINEERING AND SURVEYING
RODERICK F. PIERSON
P.O. BOX 311
710 ROANOKE ROAD
DALEVILLE, VIRGINIA 24083
(540)966-3027

1	4/14/99	PER COUNTY COMMENTS
2	6/01/99	PER COUNTY COMMENTS
3	7/06/99	PER COUNTY COMMENTS

UTILITY PLAN FOR
HALEY'S FIELD SUBDIVISION
ROANOKE COUNTY, VIRGINIA

PC 7805

COMMONWEALTH OF VIRGINIA
RODERICK F. PIERSON
NO. 023842
PROFESSIONAL ENGINEER

SCALE: 1" = 30'
COMM. NO. R9872
DATE: JUNE 6, 1999
SHEET 2 OF 6

R9872REV