


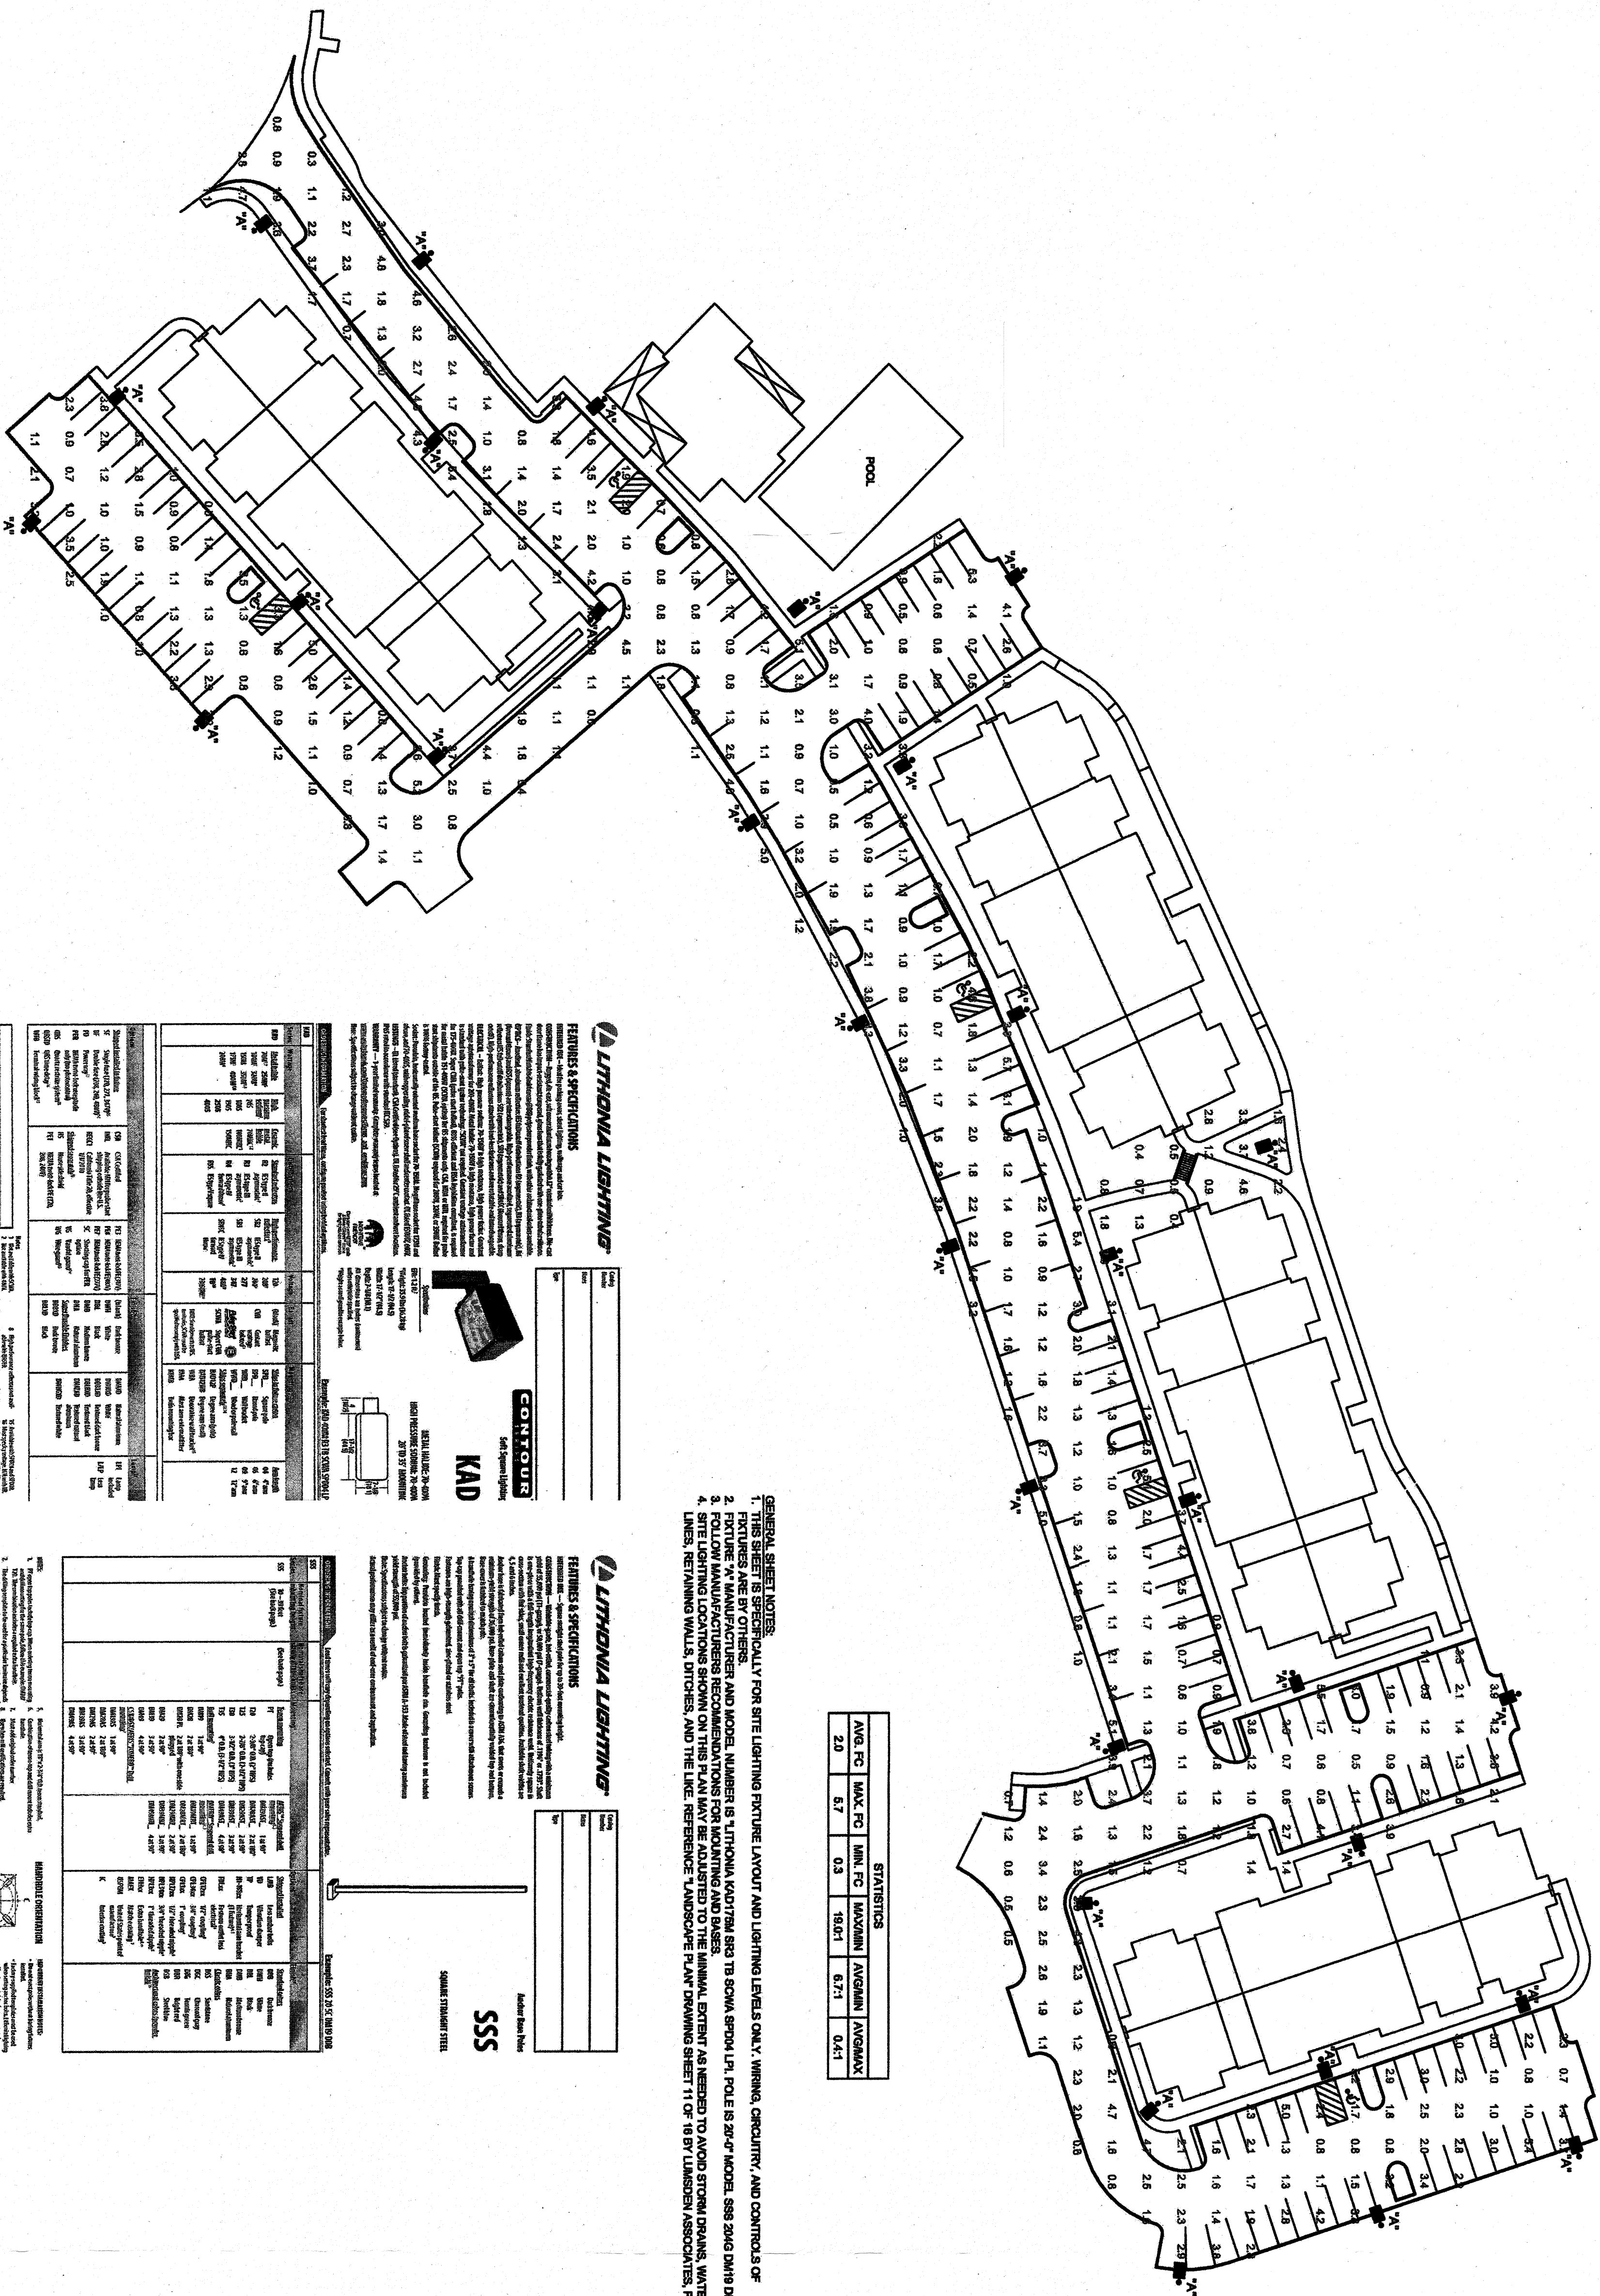

STATISTICS				
AVG FC	MAX FC	MIN FC	MAX/MIN	AVG/MIN
2.0	6.7	0.3	18.6:1	6.7:1

- GENERAL SHEET NOTES:**
- THIS SHEET IS SPECIFICALLY FOR SITE LIGHTING LAYOUT AND LIGHTING LEVELS ONLY. WIRING, CIRCUITRY, AND CONTROLS OF LITONIA LIGHTING SHALL BE SHOWN ON SEPARATE SHEETS.
 - THESE LAYOUTS ARE BASED ON THE ASSUMPTIONS AND NOTES ON THE LITONIA LIGHTING SPECIFICATIONS SHEET.
 - FOLLOW MANUFACTURER'S RECOMMENDATIONS FOR MOUNTING AND SPACING.
 - SITE LIGHTING LOCATIONS SHOWN ON THIS PLAN MAY BE ADJUSTED TO THE MINIMAL EXTENT AS NEEDED TO AVOID STORM DRAIN, WATER LINES, RETAINING WALLS, DITCHES, AND THE LIKE. REFERENCE LANDSCAPE PLAN DRAWING SHEET 11 OF 18 BY LUMSDEN ASSOCIATES, P.C.

LITONIA LIGHTING			
FEATURES & SPECIFICATIONS			
Model	Model	Model	Model
Power	Power	Power	Power
Beam Angle	Beam Angle	Beam Angle	Beam Angle
Mounting	Mounting	Mounting	Mounting
Finish	Finish	Finish	Finish
Notes	Notes	Notes	Notes

LITONIA LIGHTING			
FEATURES & SPECIFICATIONS			
Model	Model	Model	Model
Power	Power	Power	Power
Beam Angle	Beam Angle	Beam Angle	Beam Angle
Mounting	Mounting	Mounting	Mounting
Finish	Finish	Finish	Finish
Notes	Notes	Notes	Notes

SITE LIGHTING PLAN

SCALE 1" = 40'-0"


NOTE:
THIS SHEET HAS BEEN MODIFIED BY LUMSDEN ASSOCIATES, P.C. WITH THE ADDITION OF THE TWO LITONIA SPECIFICATIONS SHEETS.

Project Title
PHEASANT RIDGE APARTMENTS
PHASE ONE
ROANOKE VIRGINIA 24014
Drawing Title
SITE LIGHTING PLAN

Designed by:
Drawn by:
Checked by:
Project Number:
Scale:
Drawing file location:

Date:
Revision number:

Sheet

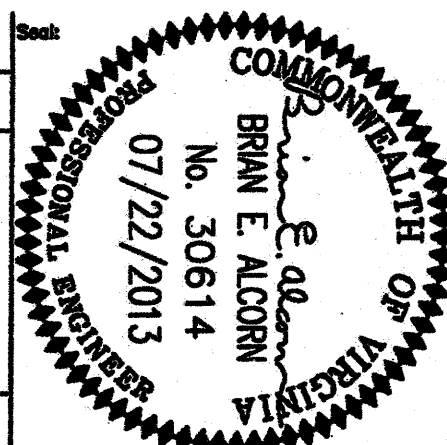

IN FOCUS ENGINEERING
6120 PETERS CREEK RD, SUITE B
ROANOKE VIRGINIA 24019
PH. / FAX 888-689-6874

Rev.	Date	Description	Appr.