

WESTERN VIRGINIA WATER AUTHORITY DEYERLE AREA PHASE 1 WATERLINE REPLACEMENT

CITY OF ROANOKE

SITE SUMMARY

OWNER: WESTERN VIRGINIA WATER AUTHORITY
ADDRESS: 601 S. JEFFERSON ST.
SUITE 300
ROANOKE, VA 24011

CONTACT: EARL SMITH
TELEPHONE NO: 540-853-5792
FAX NO: 540-853-1017

LOCATION: WINDSOR ROAD, ROANOKE CITY

DRAWING LIST

NO.	DESCRIPTION
T-1	COVER SHEET
T-2	LEGEND SHEET
U-1	WATERLINE PLAN AND PROFILE
U-2	WATERLINE PLAN AND PROFILE
U-3	WATERLINE PLAN AND PROFILE
U-4	DETAILS
U-5	DETAILS


DRAPER ADEN ASSOCIATES REVIEW

THESE PLANS HAVE BEEN SUBJECT TO TECHNICAL AND QUALITY REVIEWS BY:

NAME: Randell Hancock PRINTED SIGNATURE [Signature] DATE 7/21/08
PROJECT DESIGNER

NAME: Jim O'Dowd PRINTED SIGNATURE [Signature] DATE 7/21/08
PROJECT MANAGER

NAME: JAY S LESTER PRINTED SIGNATURE [Signature] DATE 7/21/08
QUALITY REVIEWER

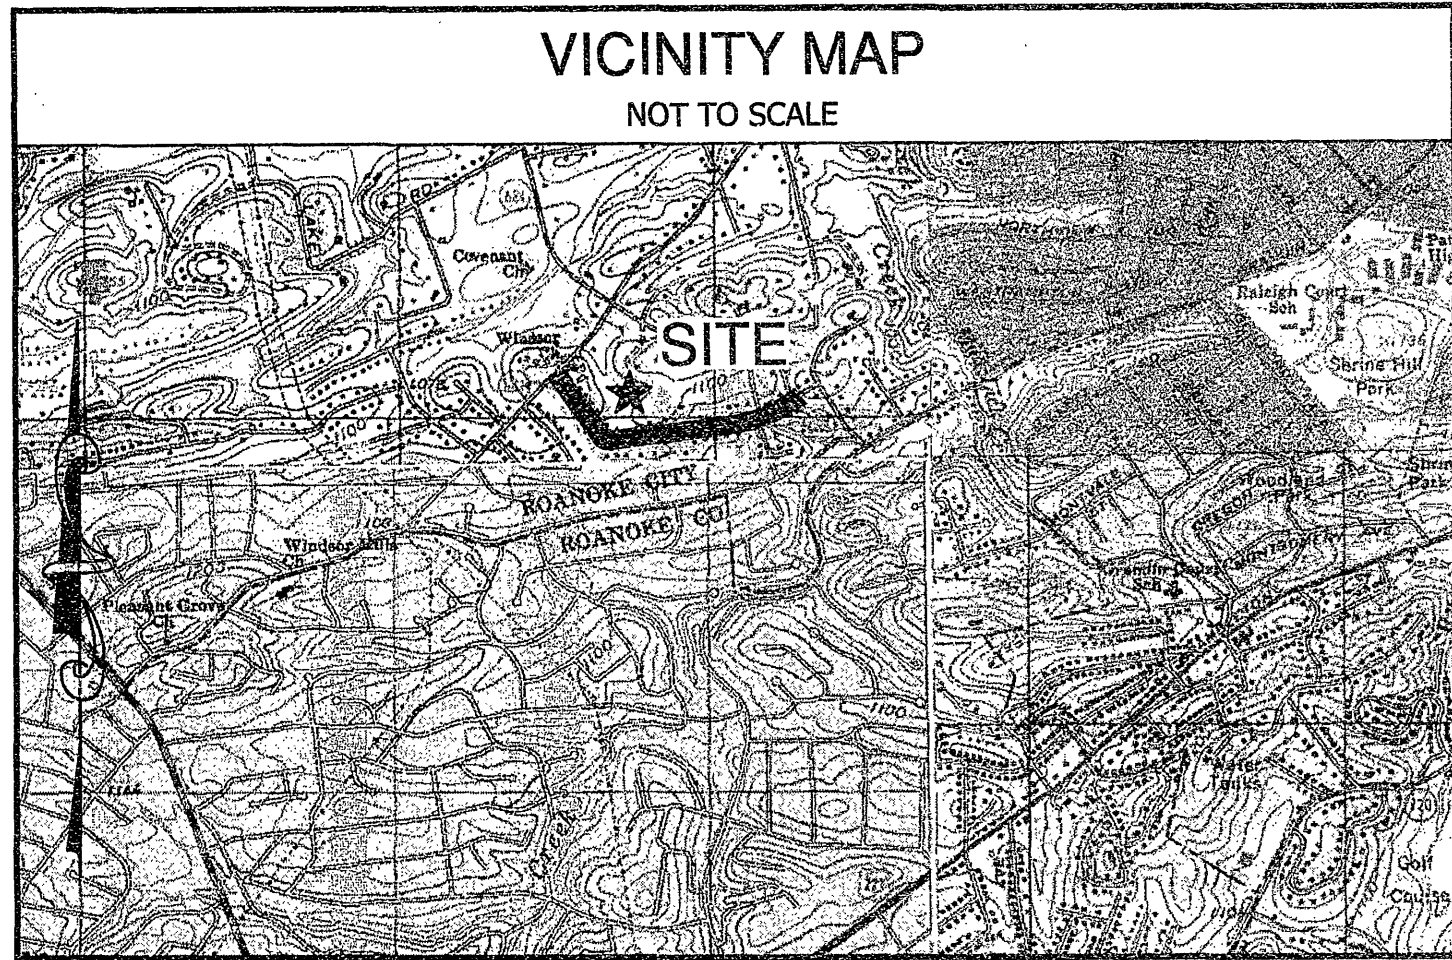

JULY 21, 2008


B04202-08

NOTE: CONTRACTOR TO CONTACT
MISS UTILITY (1-800-552-7001)
AT LEAST 3 WORKING DAYS IN
ADVANCE OF PLANNED WORK.

DESIGN TICKET No.




These documents, including drawings and specifications, were prepared by Draper Aden Associates, Consulting Engineers, pursuant to a contract by and between Draper Aden Associates and Western Virginia Water Authority with respect to the project described in said contract. Any reuse or modification of said documents (whether hard copy or electronic) without written verification or adaptation by Draper Aden Associates for the specific purpose intended will be at the sole risk of the individual or entity utilizing said documents, drawings and specifications and such use is without the authorization of Draper Aden Associates. Draper Aden Associates, Consulting Engineers, shall have no legal liability resulting from any and all claims, damages, losses, and expenses, including attorney's fees arising out of the unauthorized use of these documents, drawings, specifications, reports, and studies prepared as a result of the aforesaid contract.

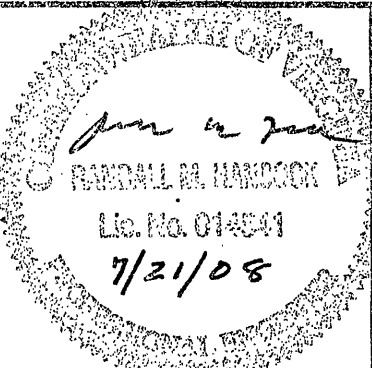


Draper Aden Associates
Engineering • Surveying • Environmental Services
Richmond, VA
Charlottesville, VA
Hampton Roads, VA

Blacksburg, VA
2505 South Main Street
Blacksburg, VA 24060
540-552-0444 Fax: 540-552-0291
www.daa.com

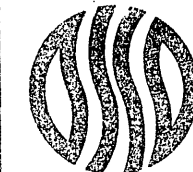

COVER SHEET
DEYERLE AREA PHASE 1 WATERLINE REPLACEMENT
WESTERN VIRGINIA WATER AUTHORITY
CITY OF ROANOKE, VIRGINIA

REVISIONS

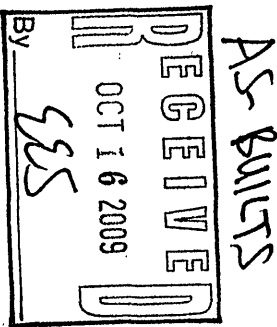

DESIGNED BY: RMH
DRAWN BY: DLD
CHECKED BY: RMH
SCALE: NOT TO SCALE
DATE: JULY 21, 2008
PROJECT NUMBER: B04202-08
T-1

SET
2