
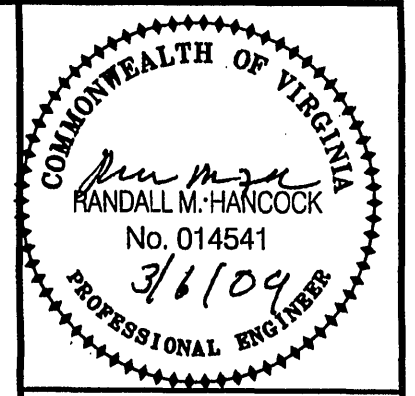
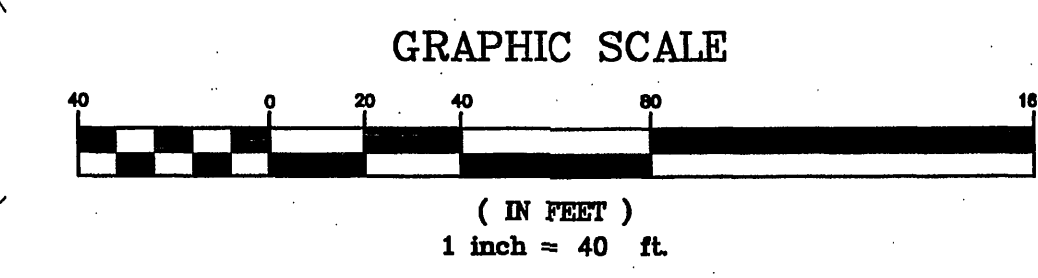
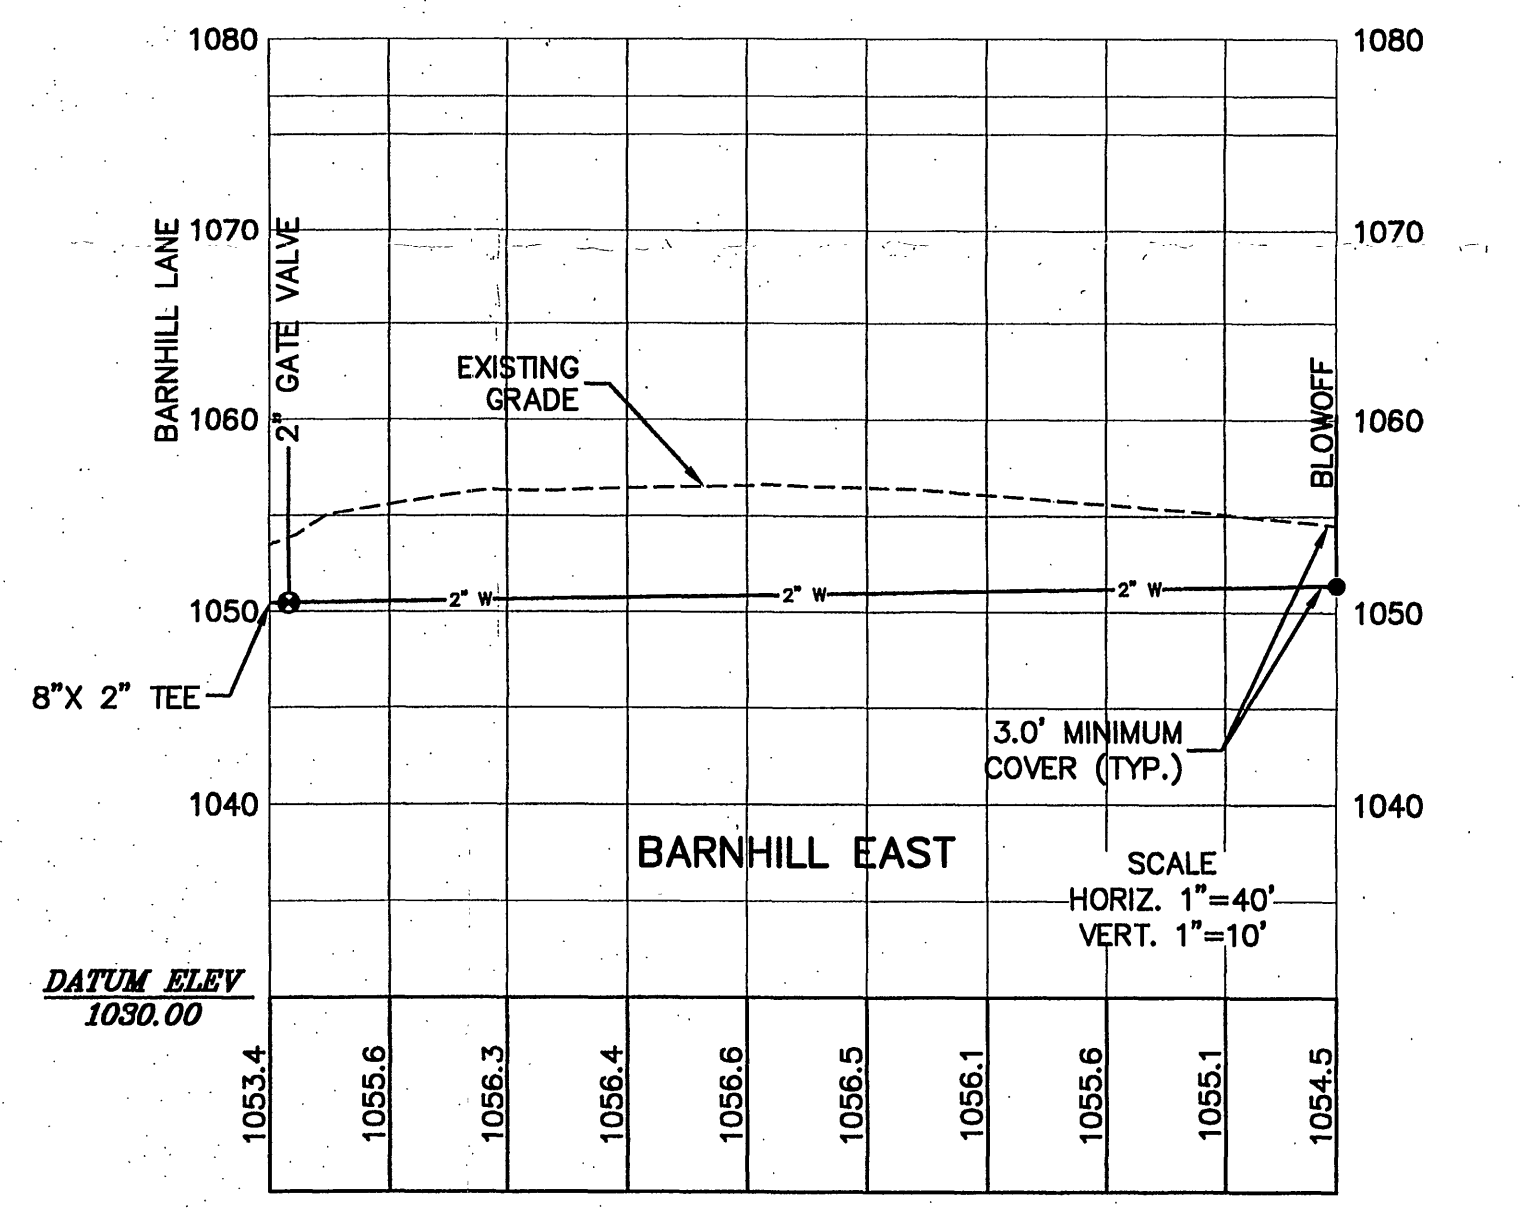
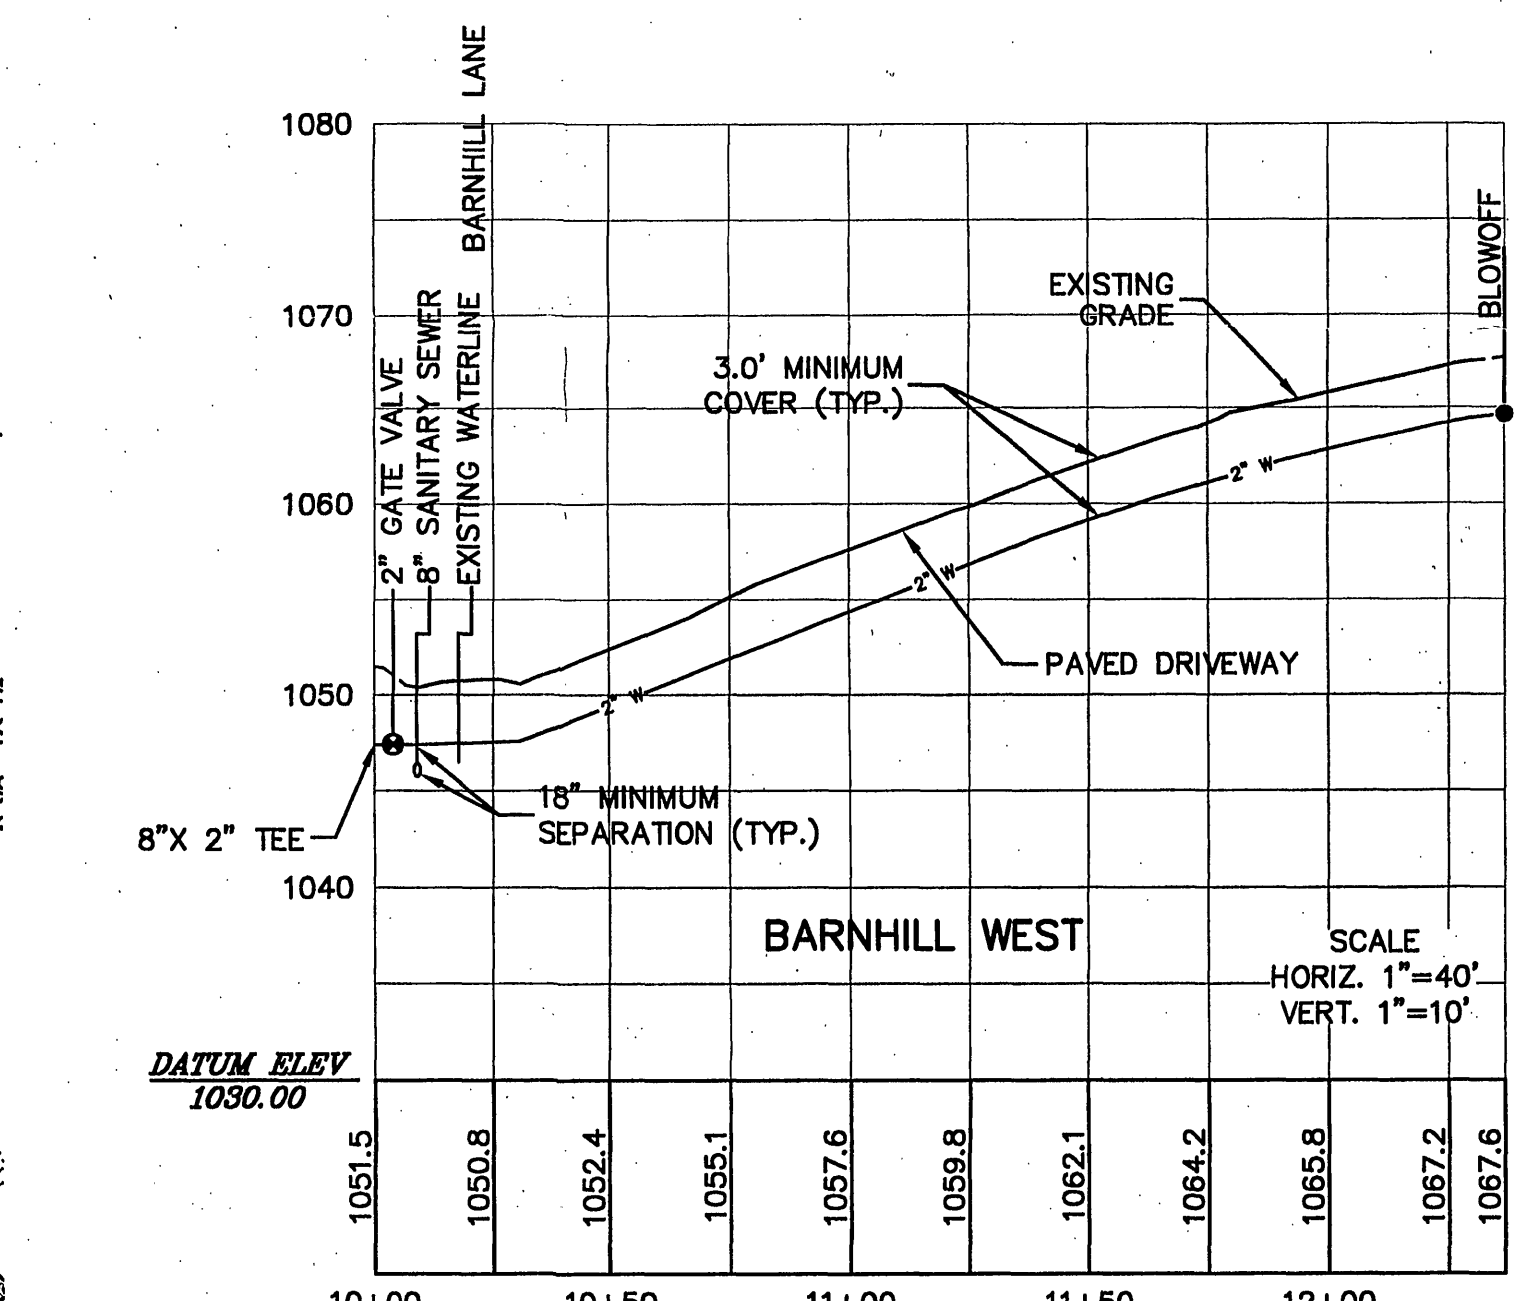
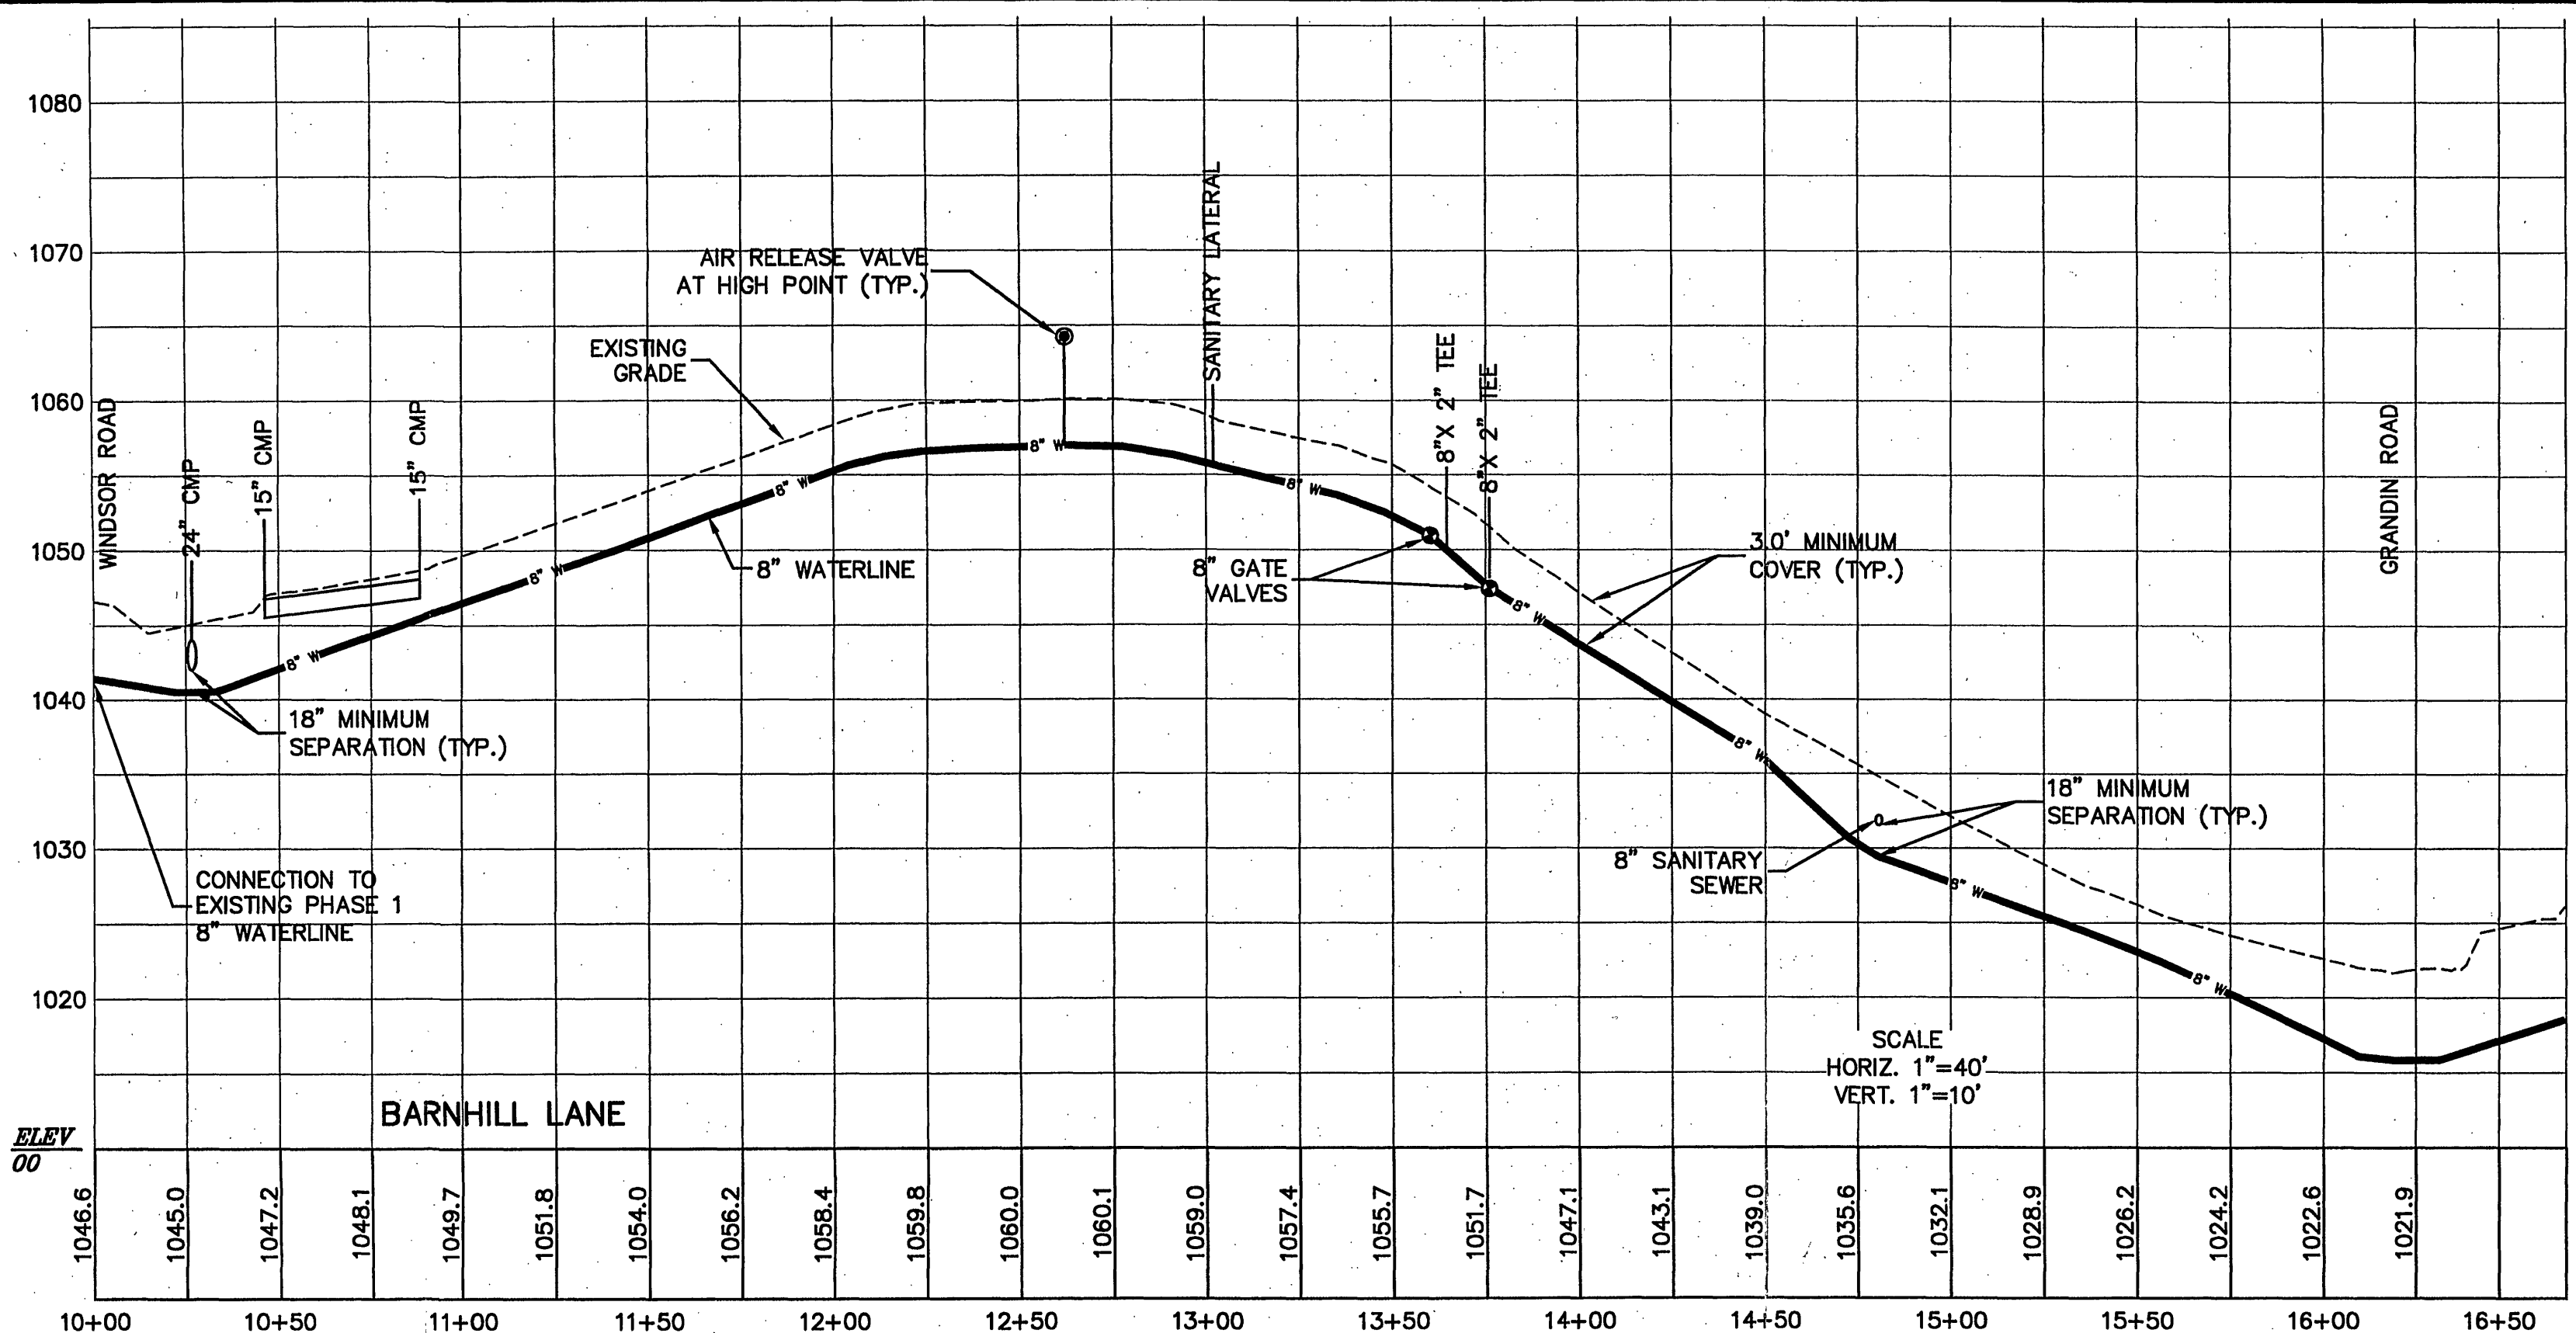


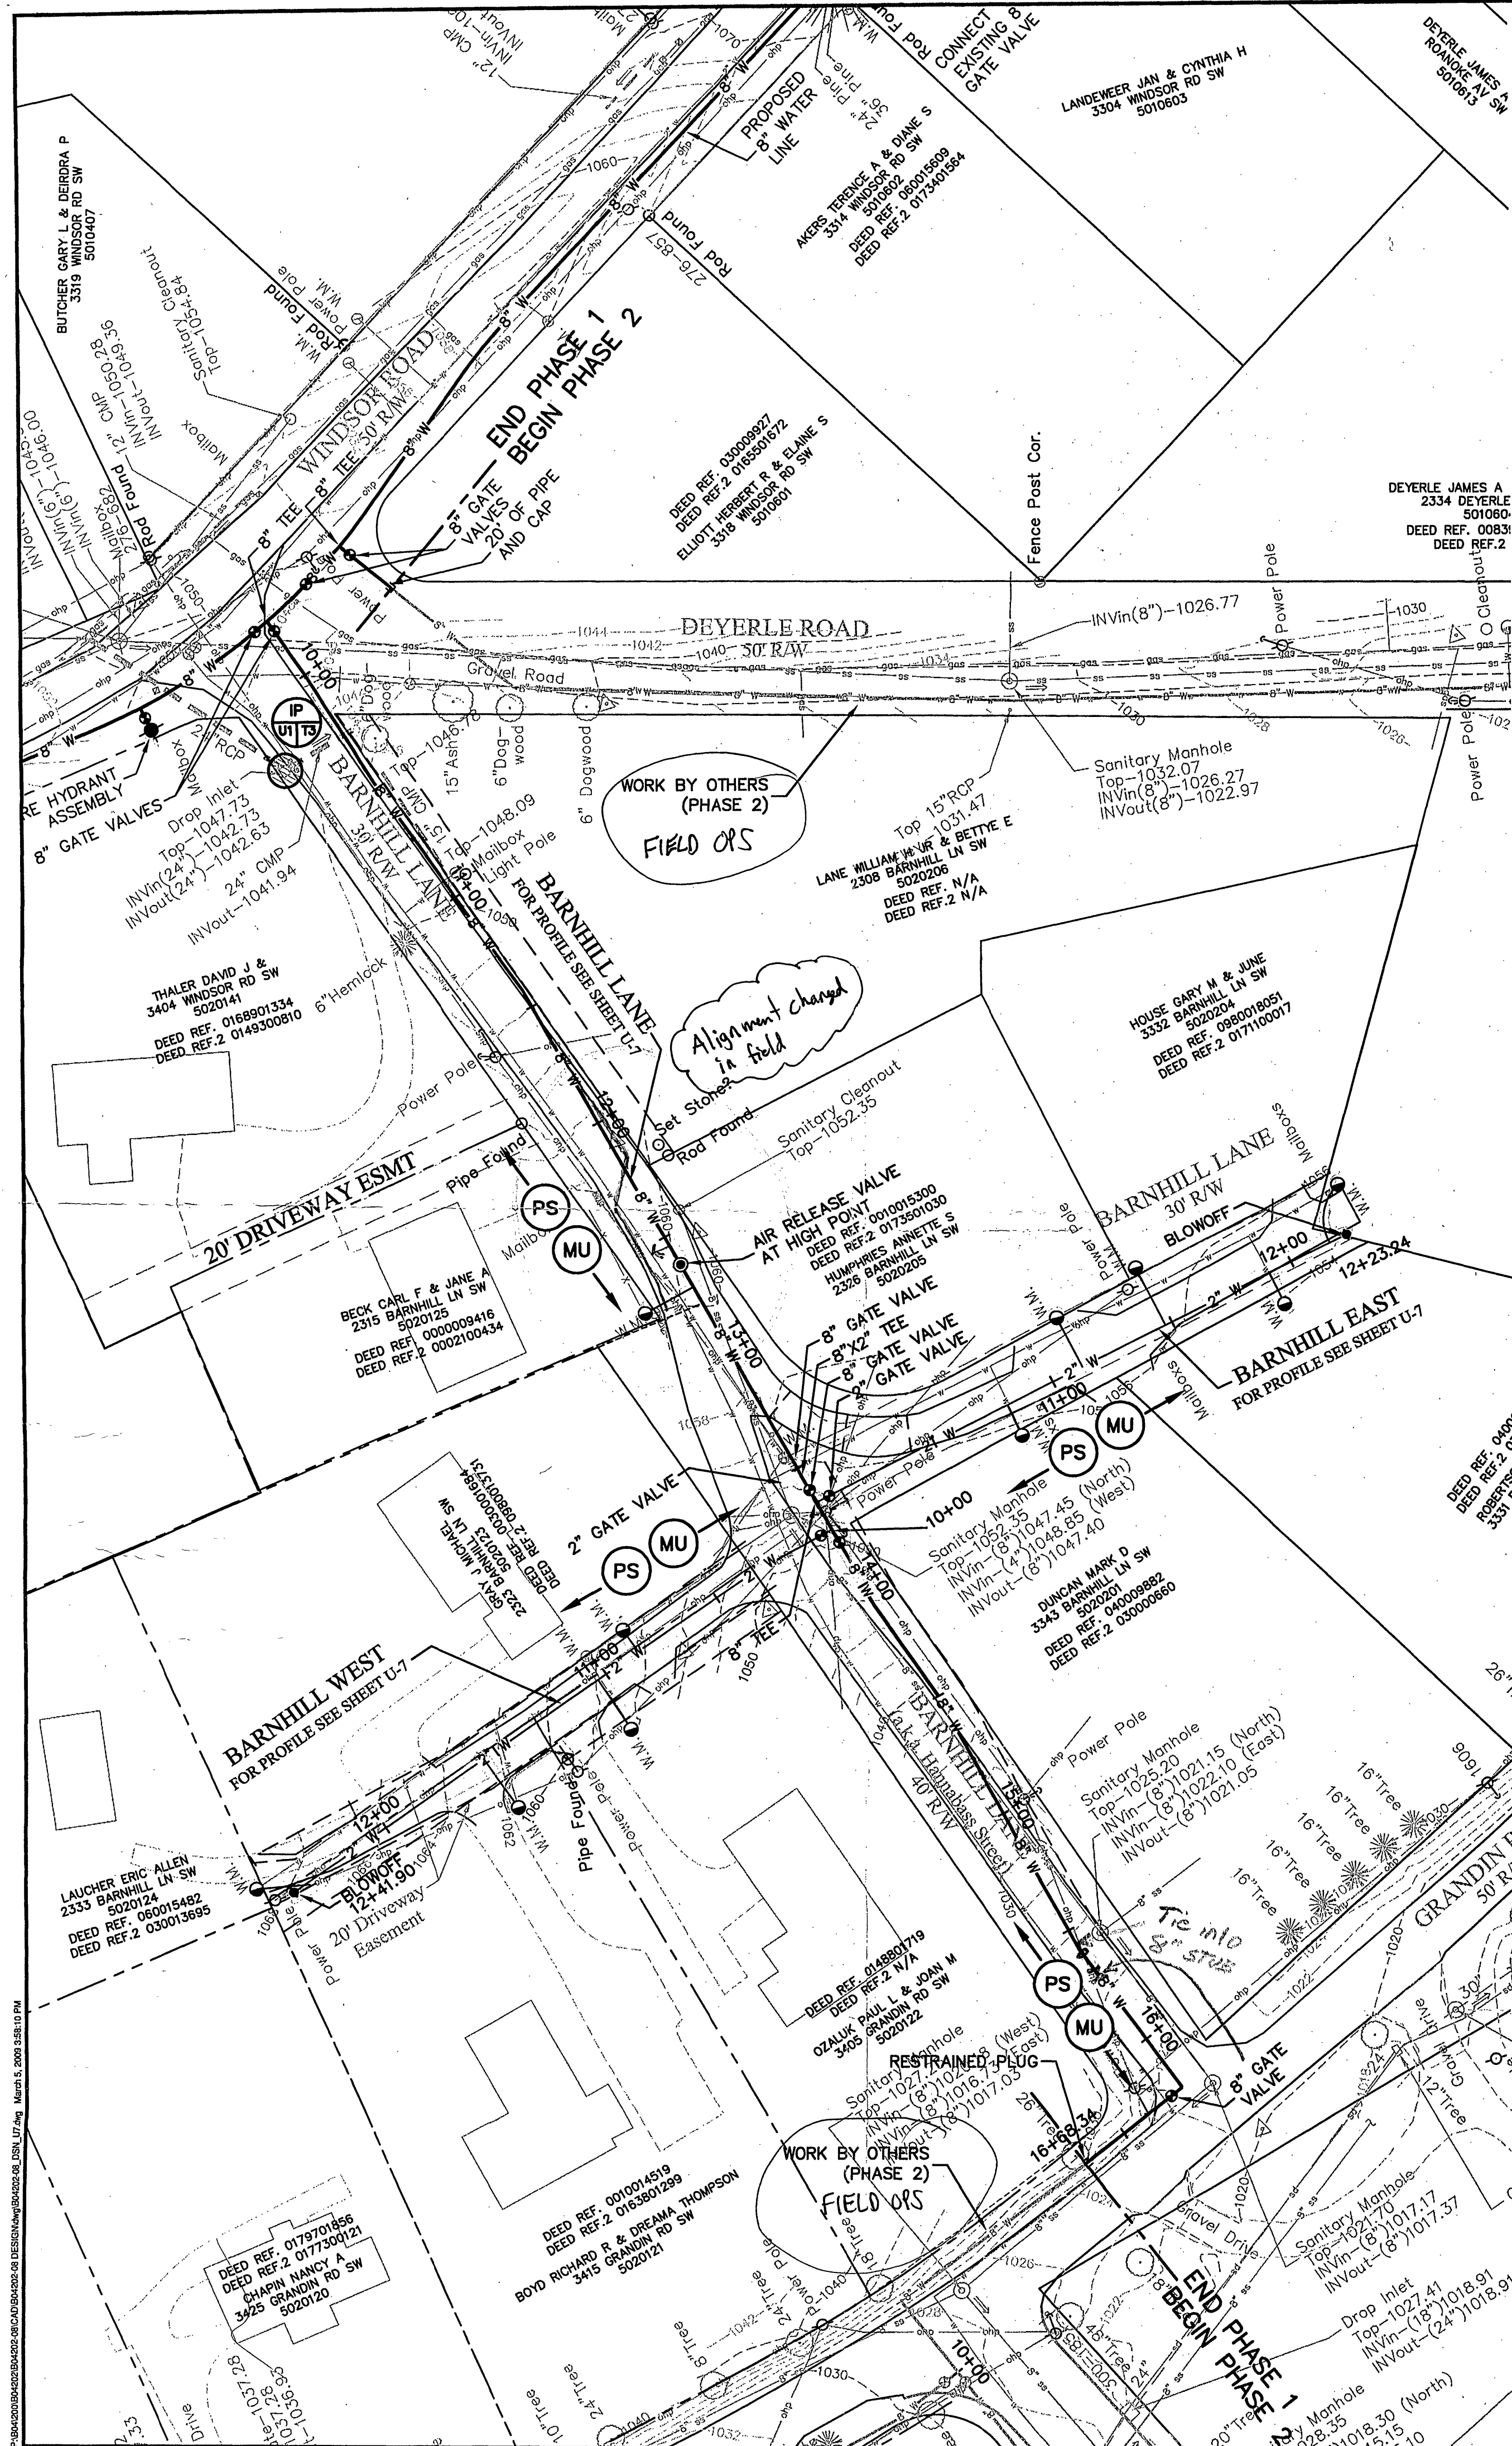

Draper Aden Associates
Engineering • Surveying • Environmental Services
Richmond, VA
Charlottesville, VA
Hampton Roads, VA
Blackburg, VA
2308 South Main Street
Blackburg, VA 24060
540-552-0444 Fax: 540-552-0291
www.daa.com

WATERLINE PLAN AND PROFILE
DEYERLE AREA PHASE 1 WATERLINE REPLACEMENT
WESTERN VIRGINIA WATER AUTHORITY
CITY OF ROANOKE, VIRGINIA

DESIGNED BY:		RMH
DRAWN BY:		SAK
CHECKED BY:		RMH
SCALE:		1" = 40'
DATE:		JULY 21, 2008
PROJECT NUMBER:		B04202-08
U-7		