



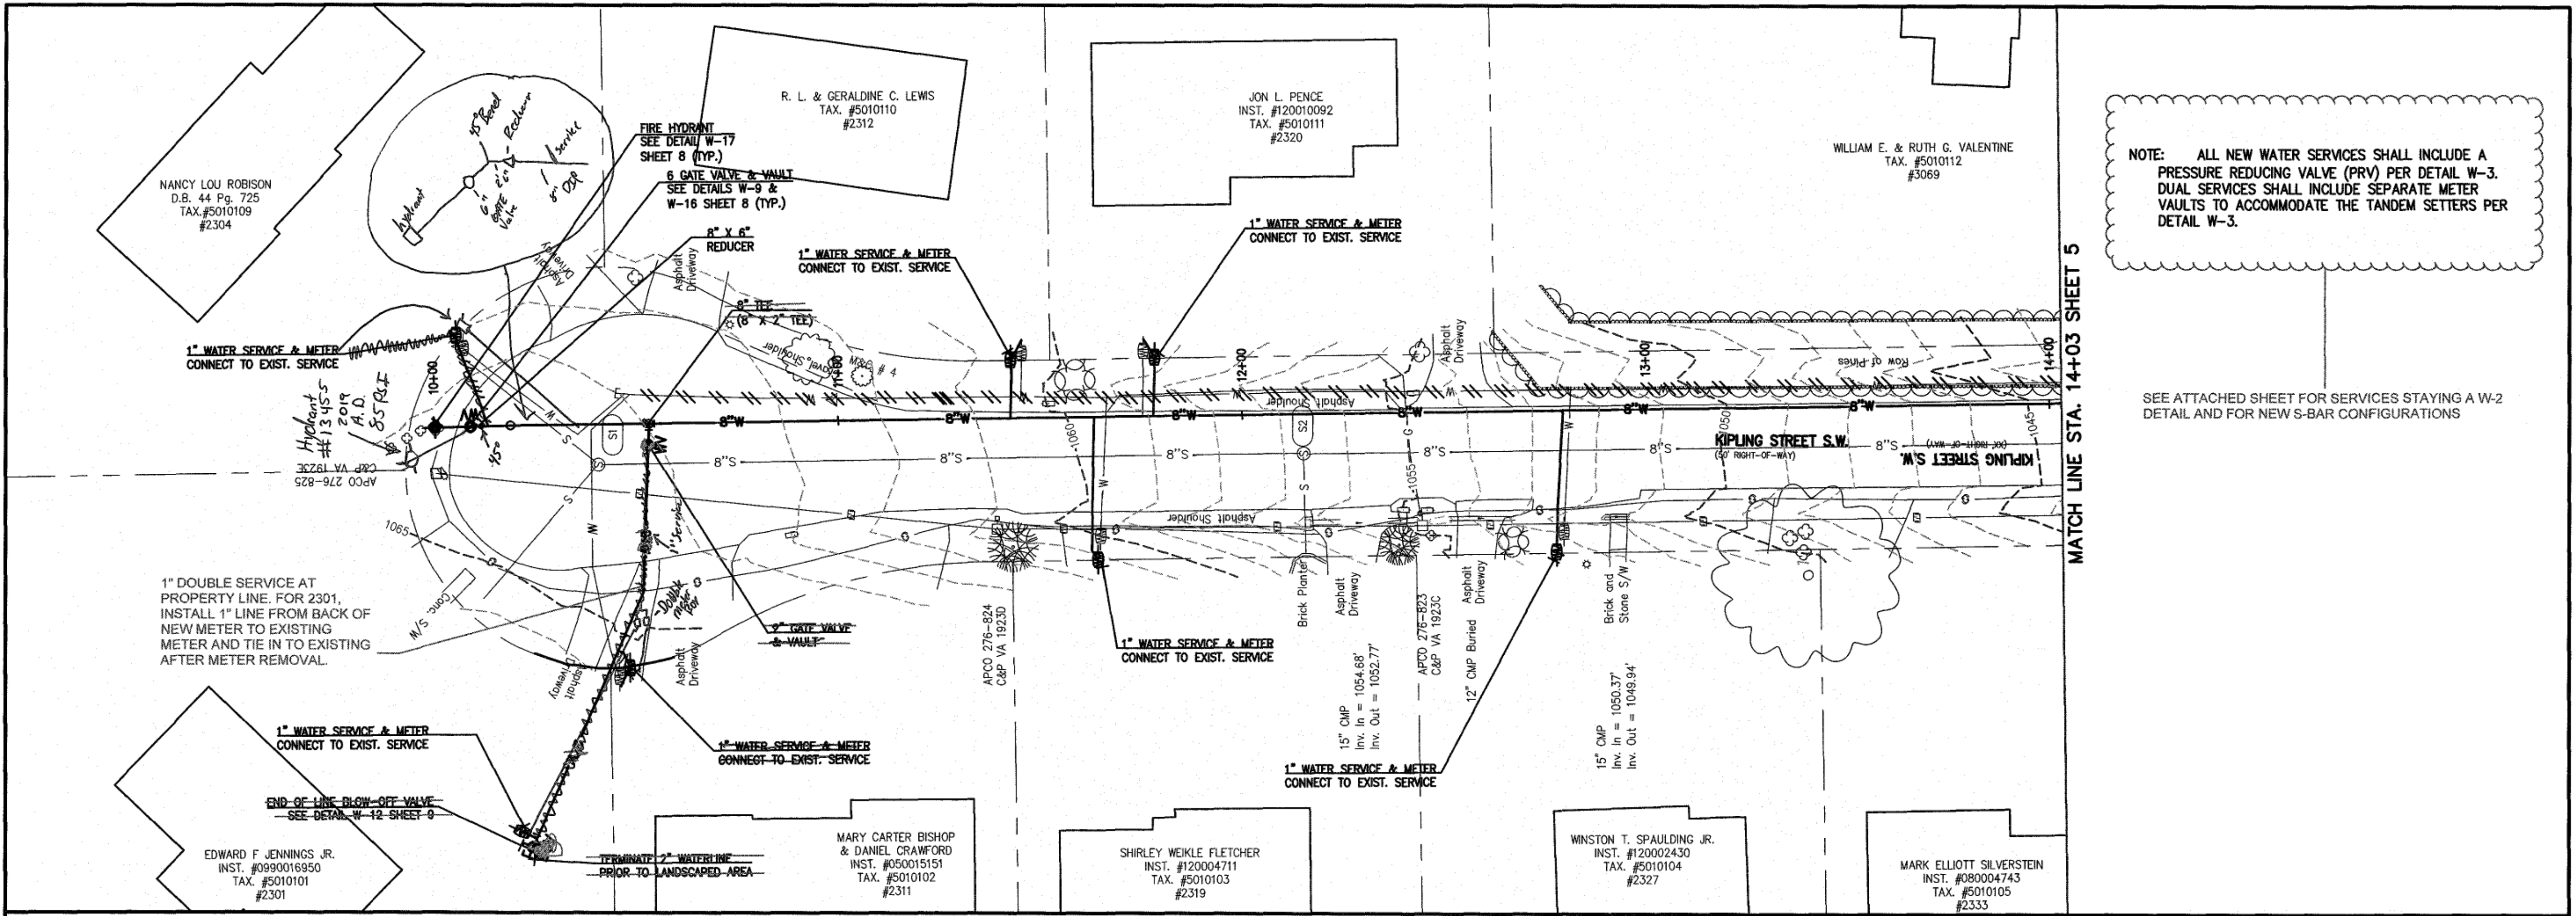

NOTE: ALL NEW WATER SERVICES SHALL INCLUDE A PRESSURE REDUCING VALVE (PRV) PER DETAIL W-3. DUAL SERVICES SHALL INCLUDE SEPARATE METER VAULTS TO ACCOMMODATE THE TANDEM SETTERS PER DETAIL W-3.

SEE ATTACHED SHEET FOR SERVICES STAYING A W-2 DETAIL AND FOR NEW S-BAR CONFIGURATIONS

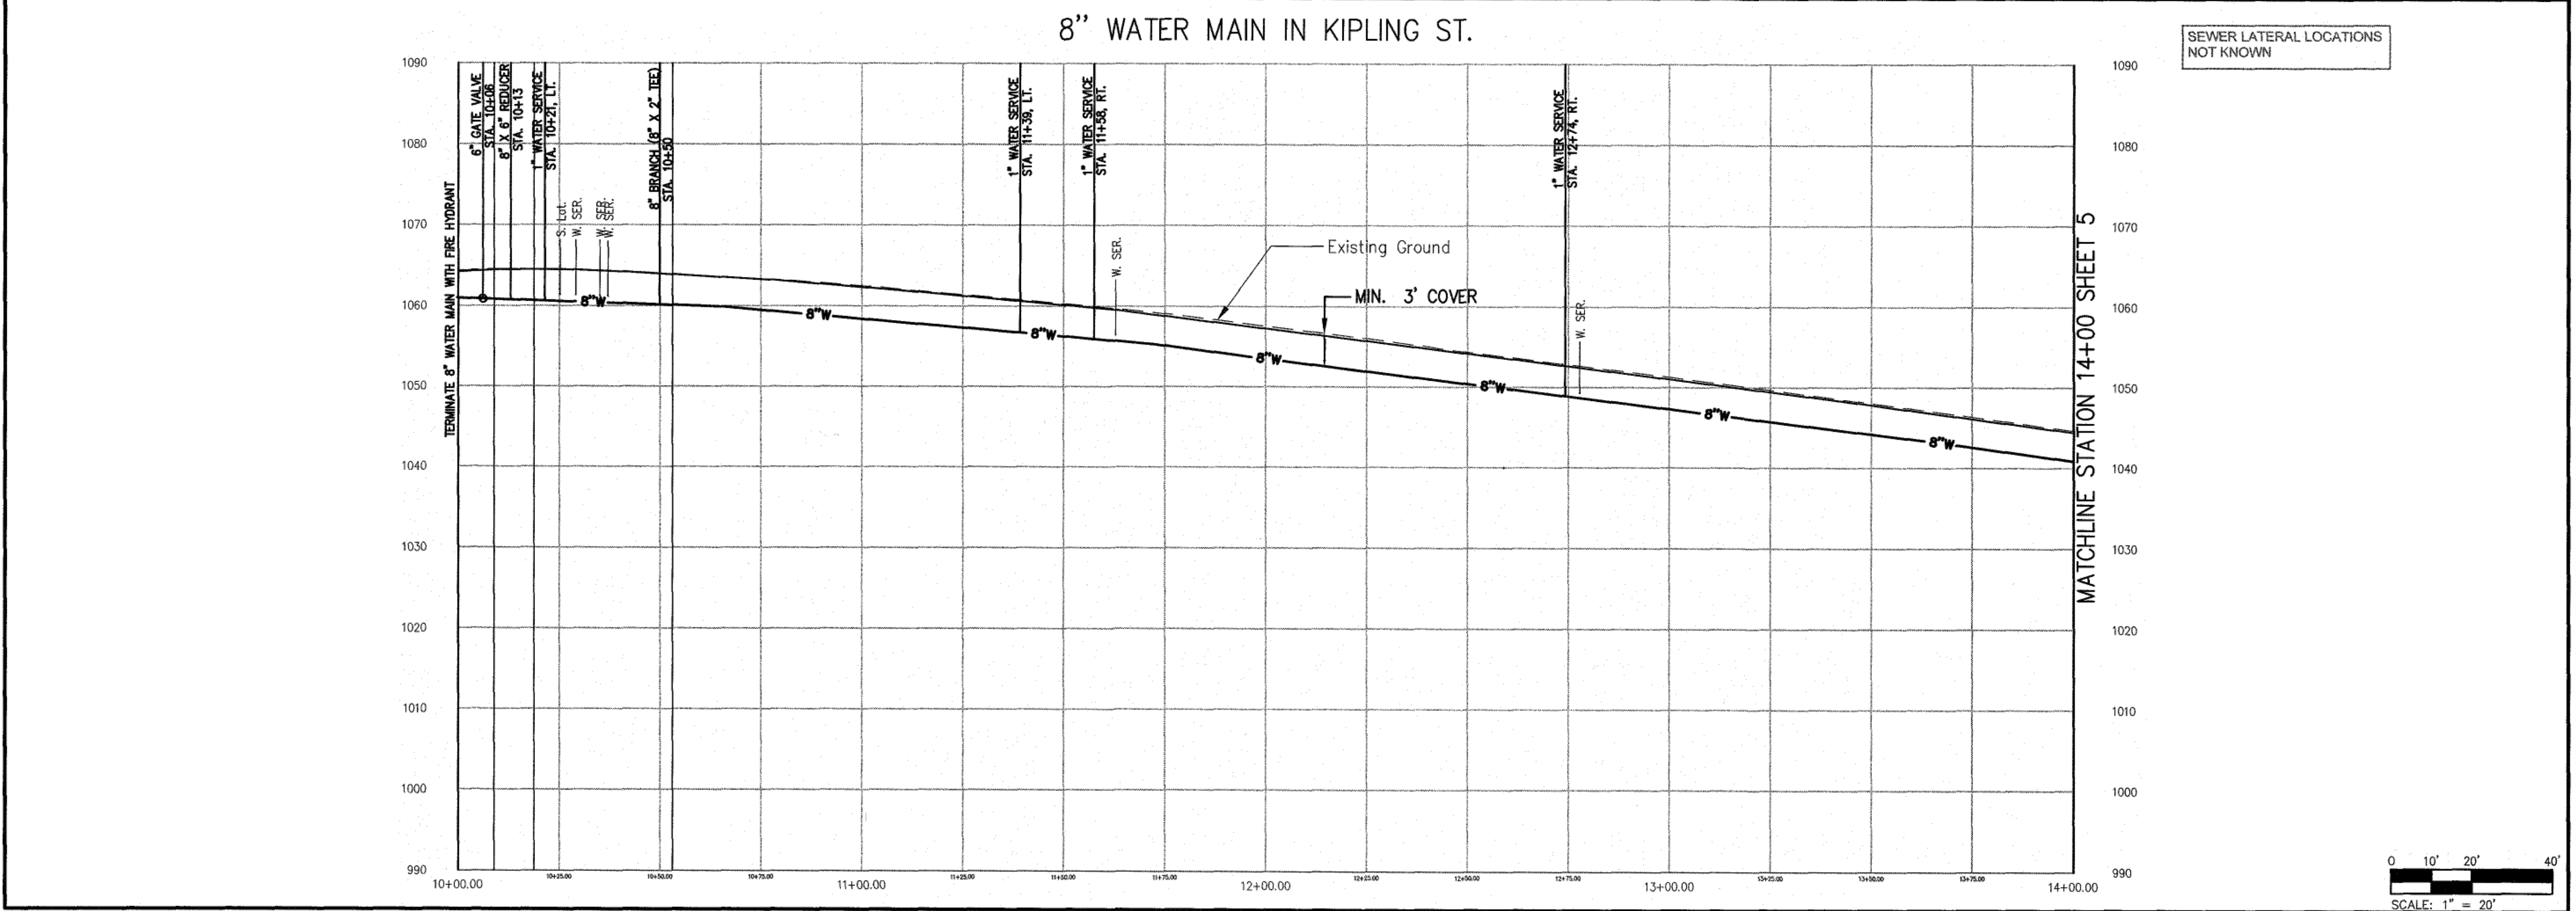

| Revisions | Date |
|-----------|------|
|           |      |
|           |      |
Issue Date: 02/28/19  
Drawn By: DBL  
Designed By: DBL  
Checked By: BCC  
Date: 02/22/19

**Mattern & Craig**  
ENGINEERS-SURVEYORS  
701 FIRST STREET, S.W.  
ROANOKE, VIRGINIA 24016  
(540) 345-9342  
FAX (540) 345-7891

DOVER DR./KIPLING ST. WATERLINE REPLACEMENT  
**PLAN AND PROFILE**  
ROANOKE, VIRGINIA

Vertical Scale: \_\_\_\_\_  
Horizontal Scale: \_\_\_\_\_  
Commission Number: 3770  
Sheet No.: 4