

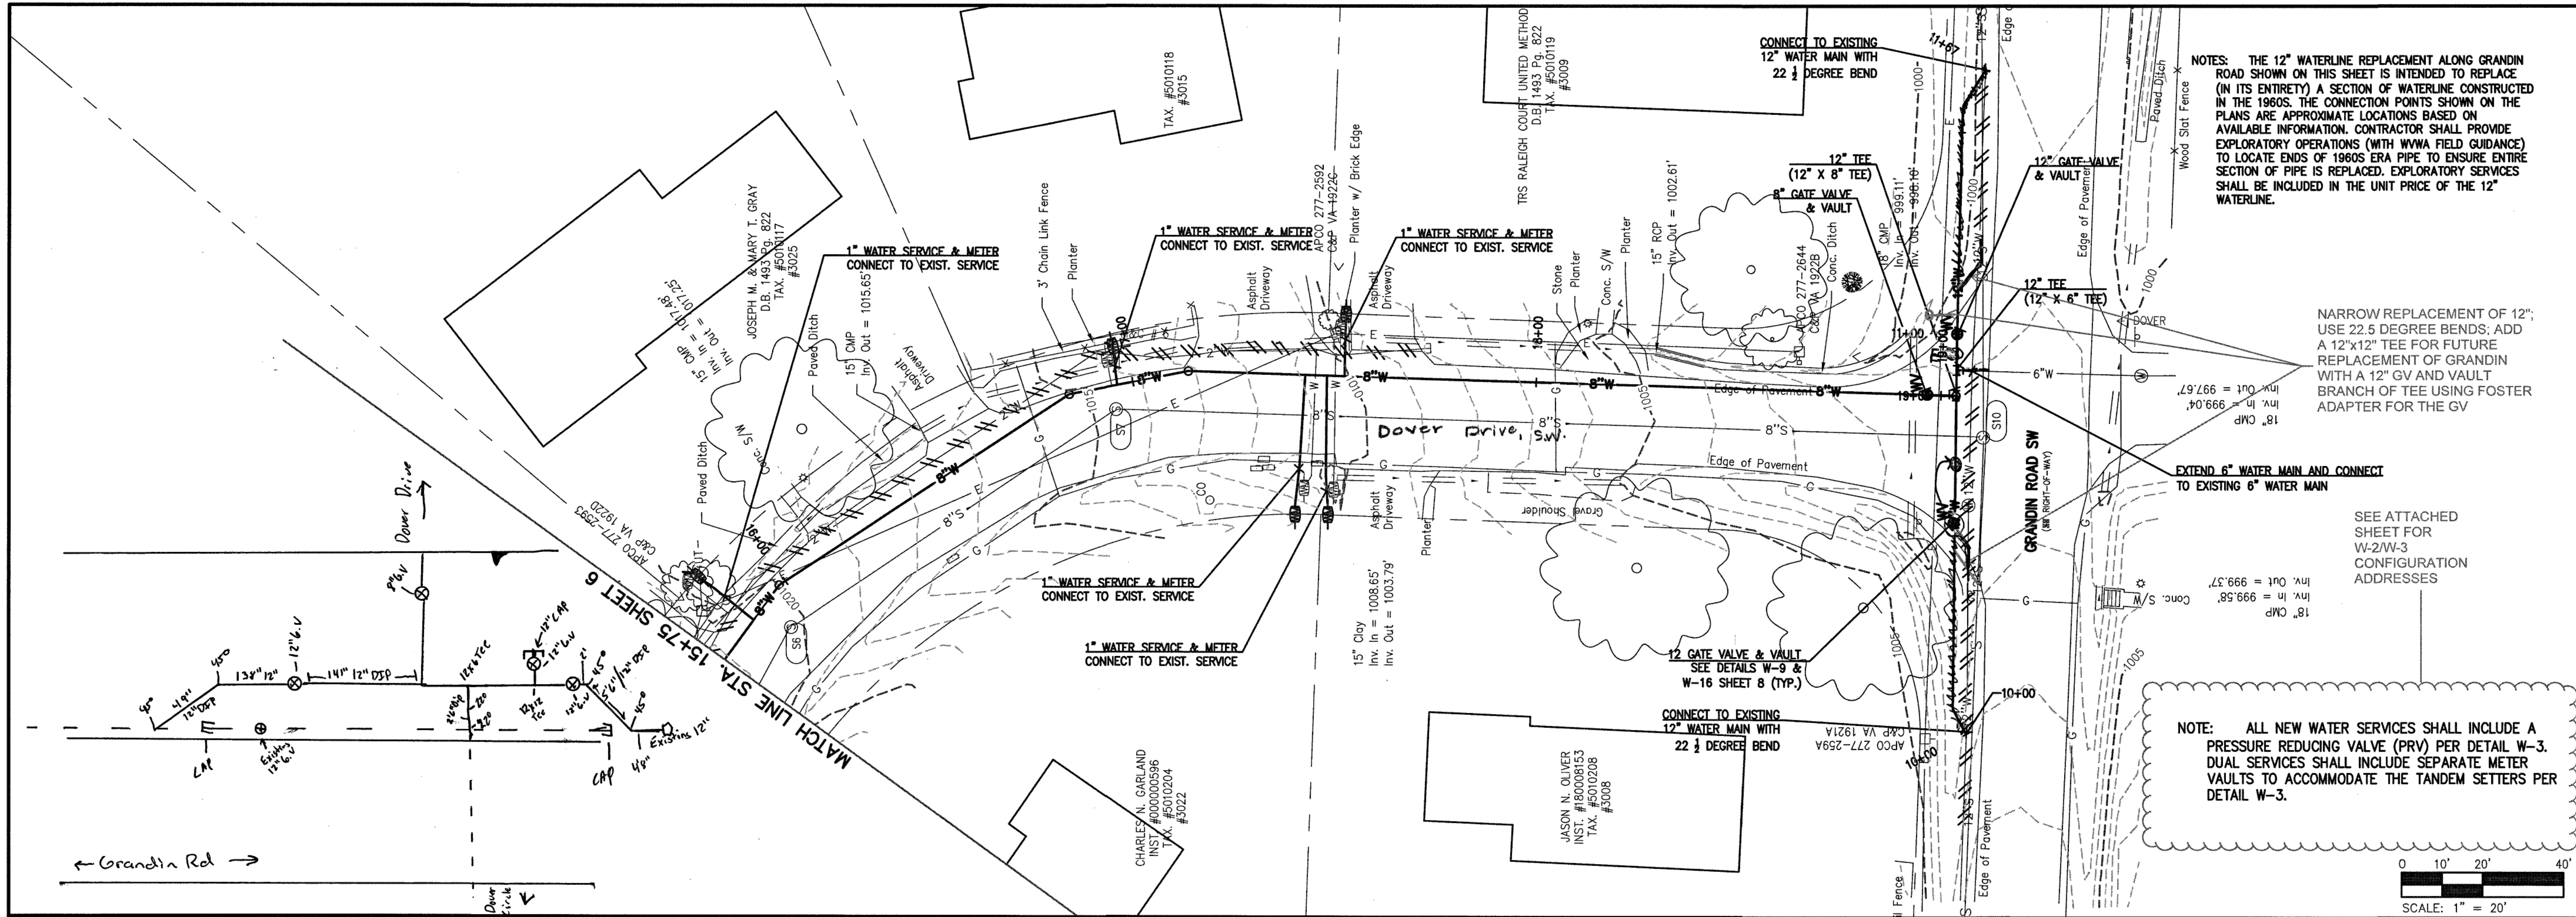


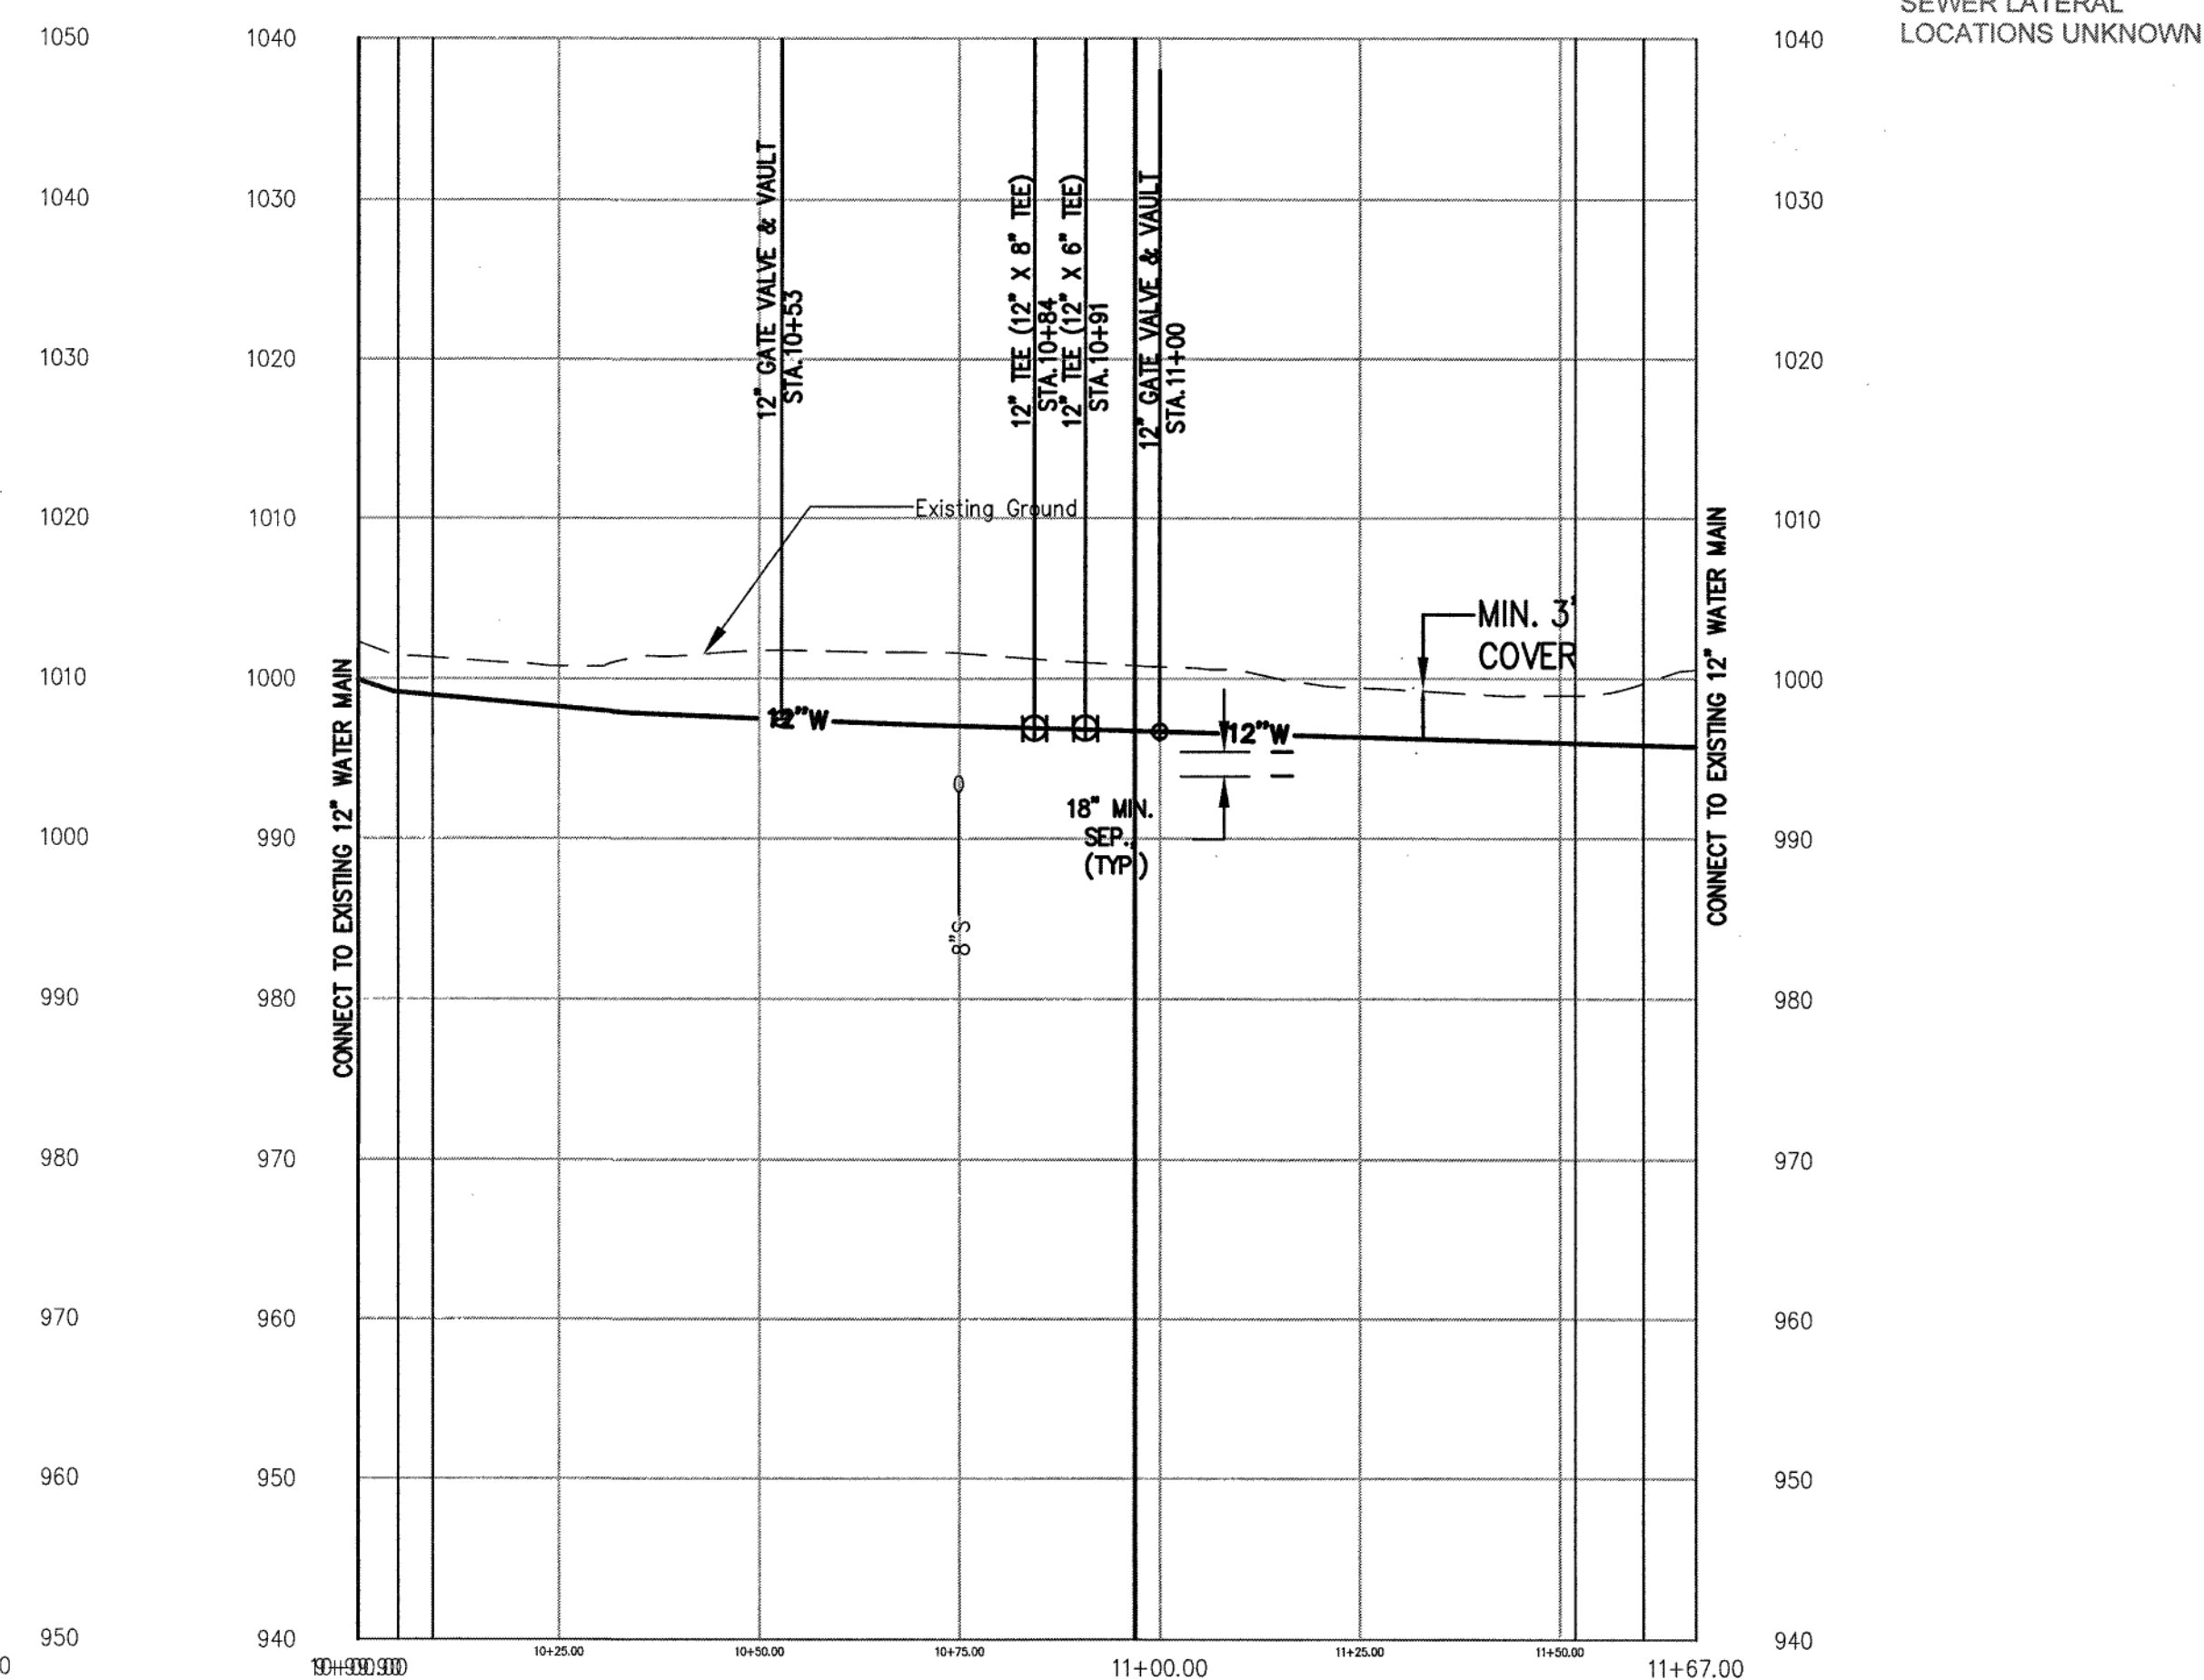

8" WATER MAIN IN DOVER DR.

12" WATER MAIN IN GRANDIN RD.

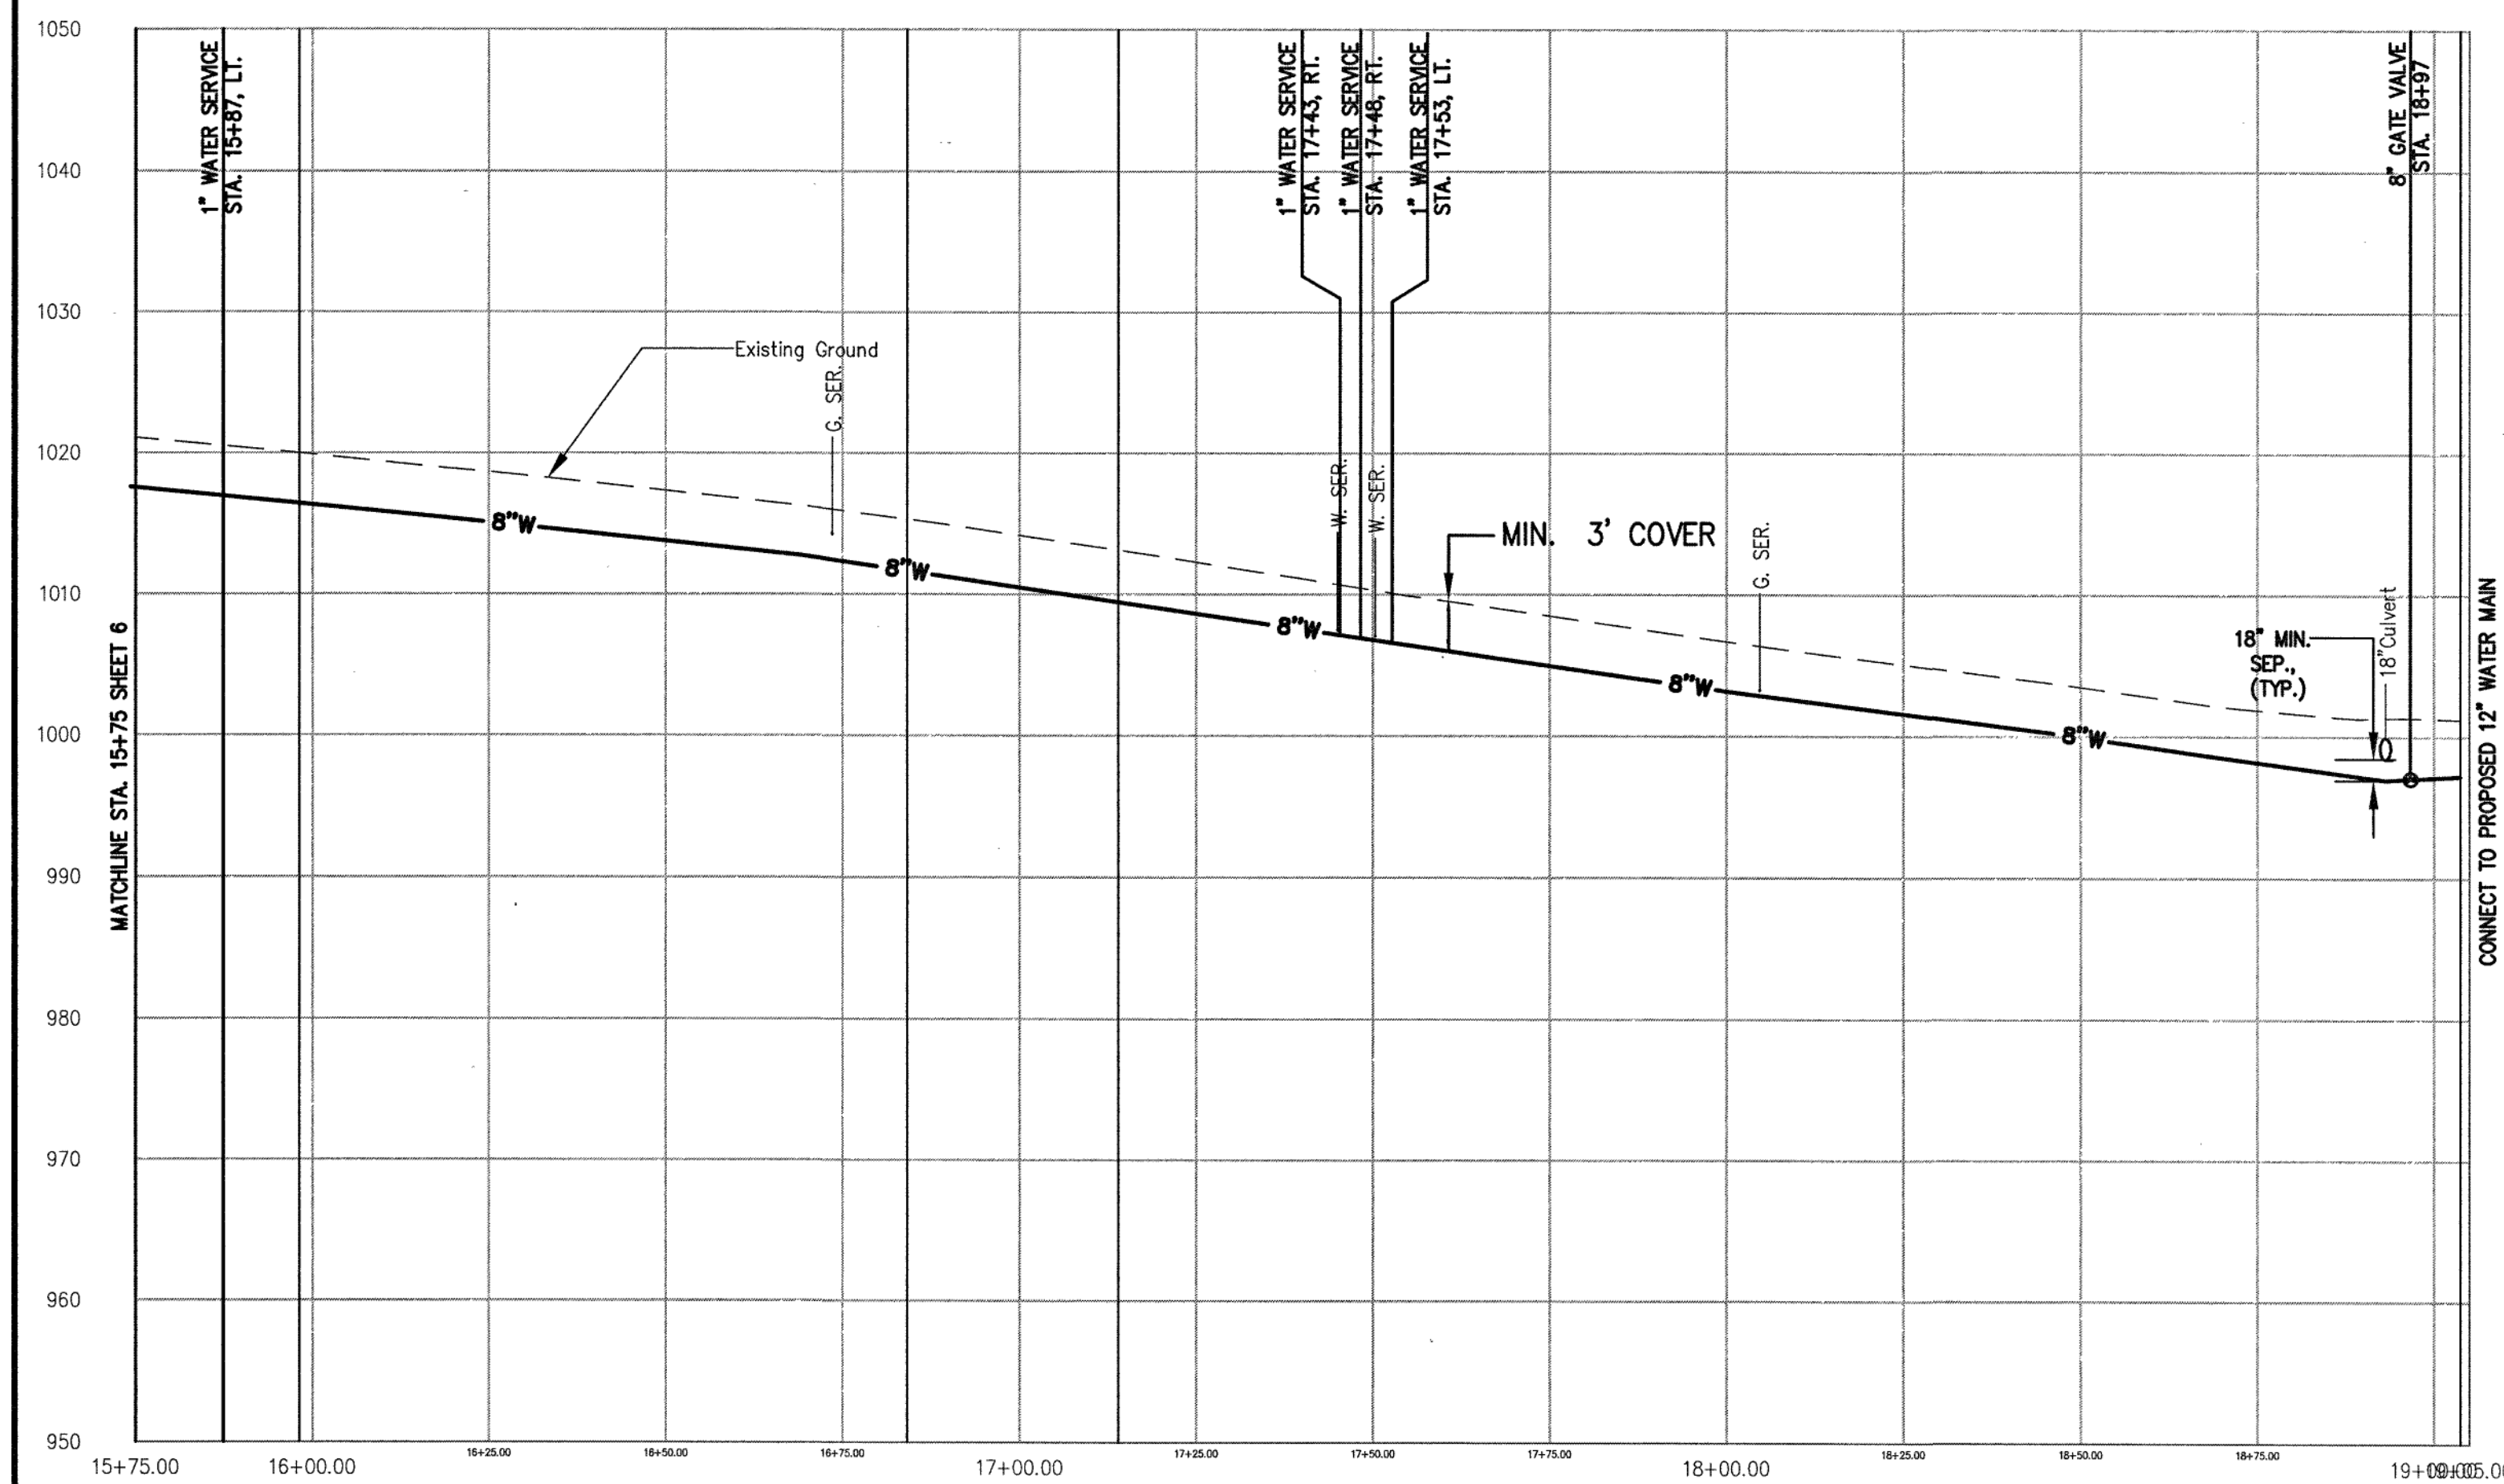

DATE: 02/28/19

DESIGNED BY: DBL

CHECKED BY: BCC

DATE: 02/22/19

Issue Date: 02/28/19

Drawn By: DBL

Designed By: DBL

Checked By: BCC

Date: 02/22/19

Vertical Scale:

Horizontal Scale:

Commission Number: 3770

Sheet No.: 7

DOVER DR./KIPLING ST. WATERLINE REPLACEMENT

PLAN AND PROFILE

ROANOKE, VIRGINIA

701 FIRST STREET, S.W.

ROANOKE, VIRGINIA 24011

(540) 345-3342

FAX (540) 345-7681

DATE: 02/28/19

DESIGNED BY: DBL

CHECKED BY: BCC

DATE: 02/22/19

Issue Date: 02/28/19

Drawn By: DBL

Designed By: DBL

Checked By: BCC

Date: 02/22/19

Vertical Scale:

Horizontal Scale:

Commission Number: 3770

Sheet No.: 7

DOVER DR./KIPLING ST. WATERLINE REPLACEMENT

PLAN AND PROFILE

ROANOKE, VIRGINIA

701 FIRST STREET, S.W.

ROANOKE, VIRGINIA 24011

(540) 345-3342

FAX (540) 345-7681