
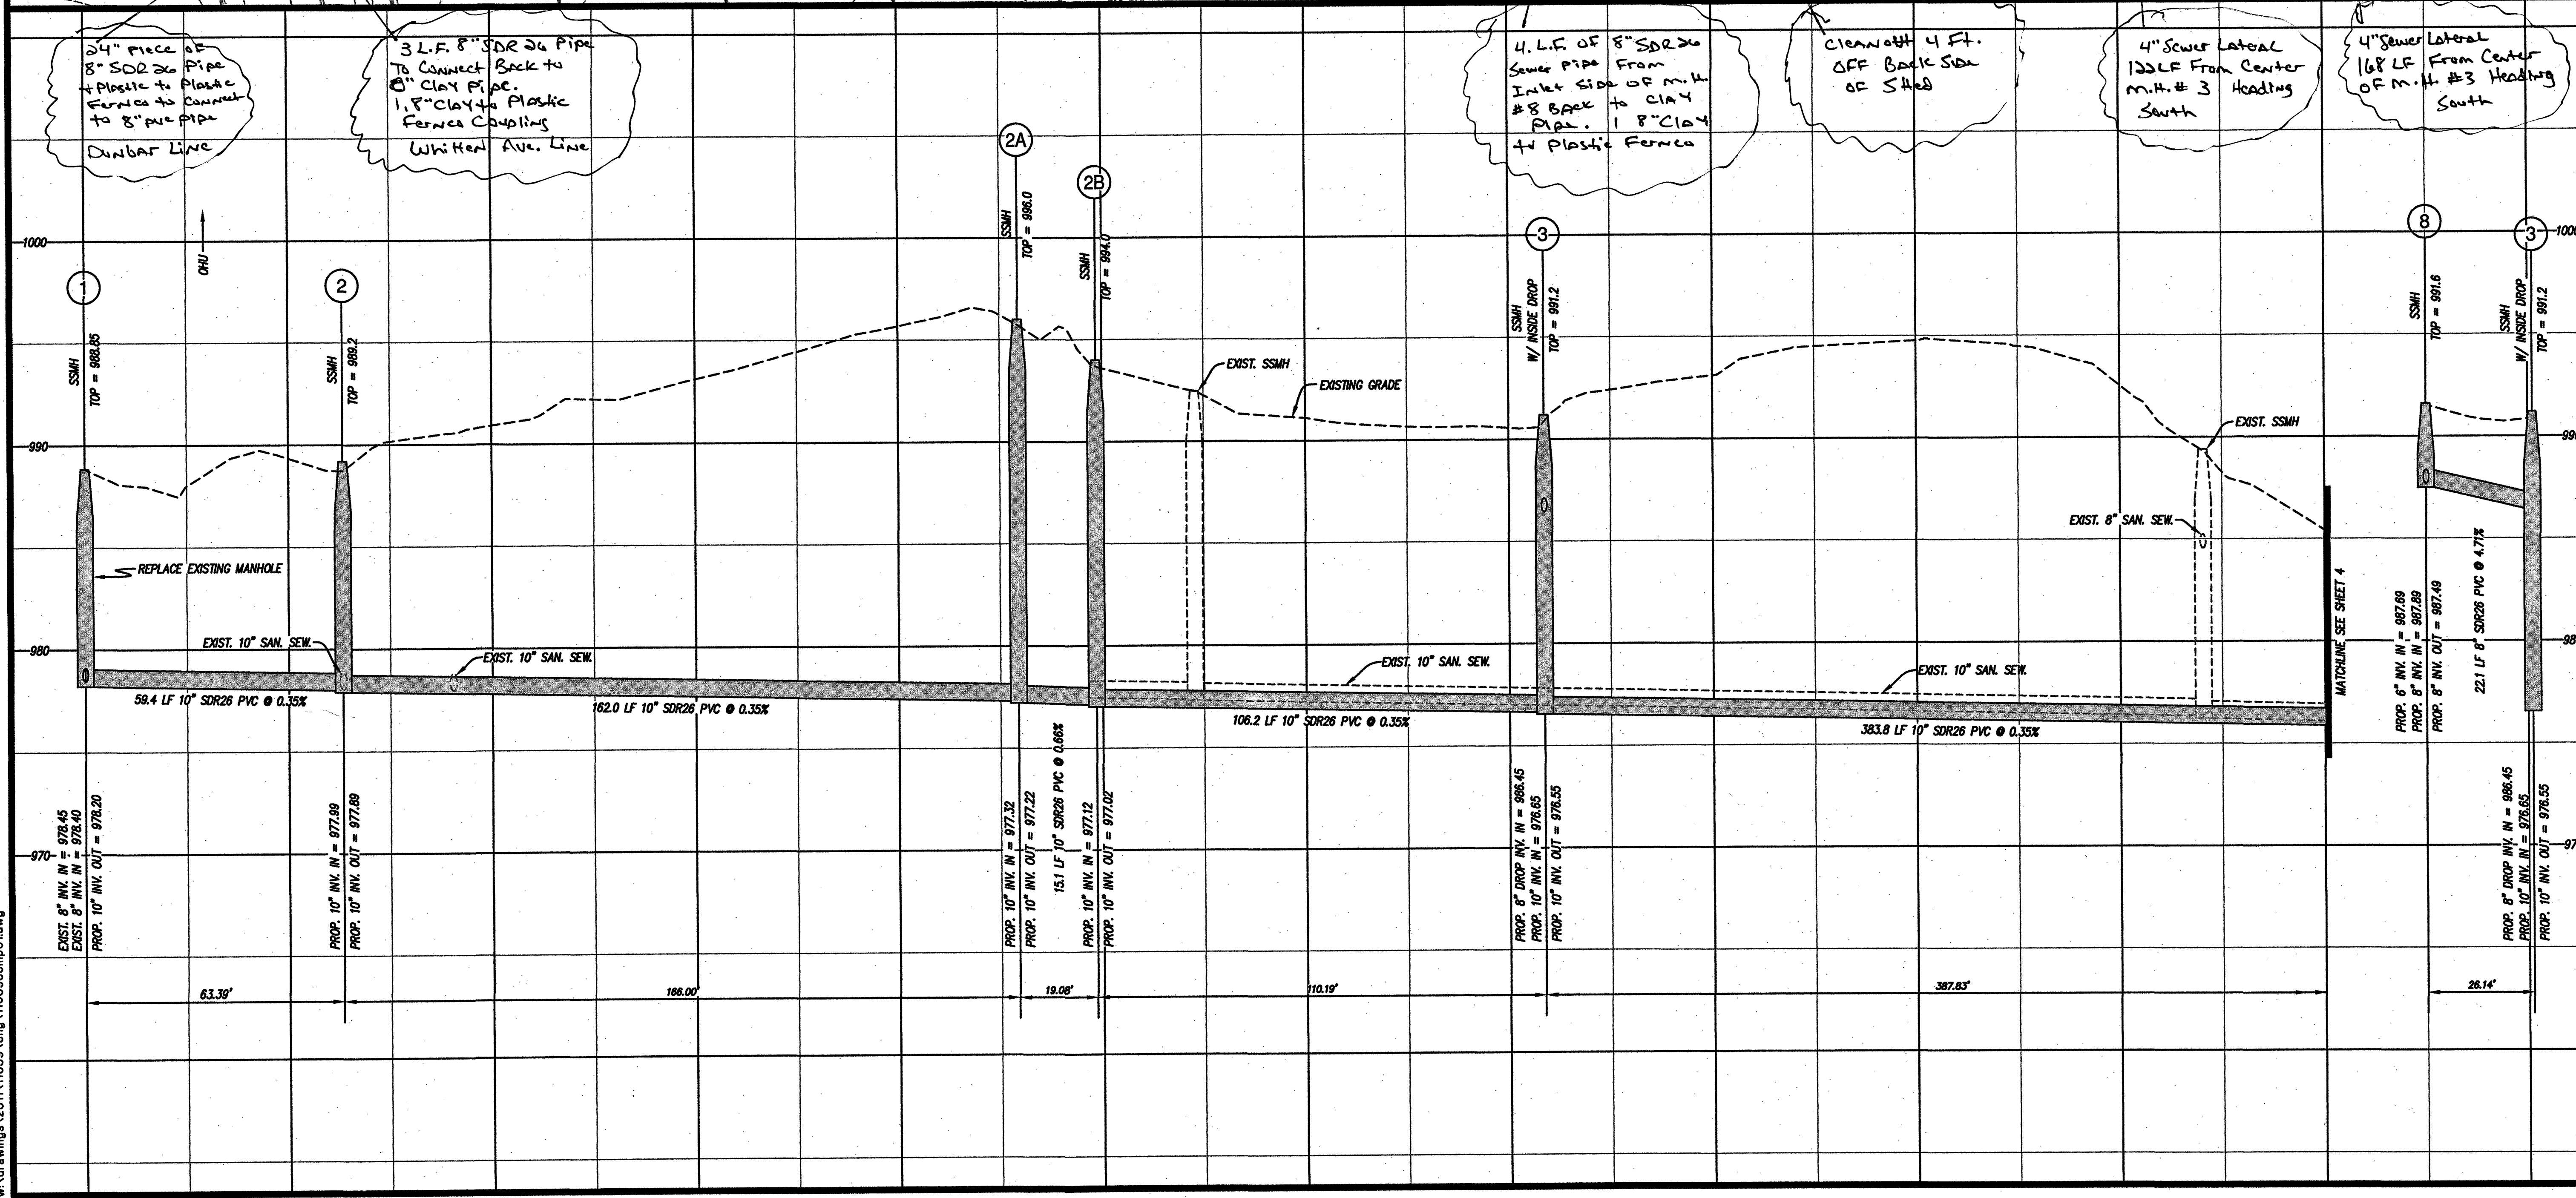


11039comp01-03-pro.dwg

w:\drawings\2011\11039\eng\11039comp01.dwg

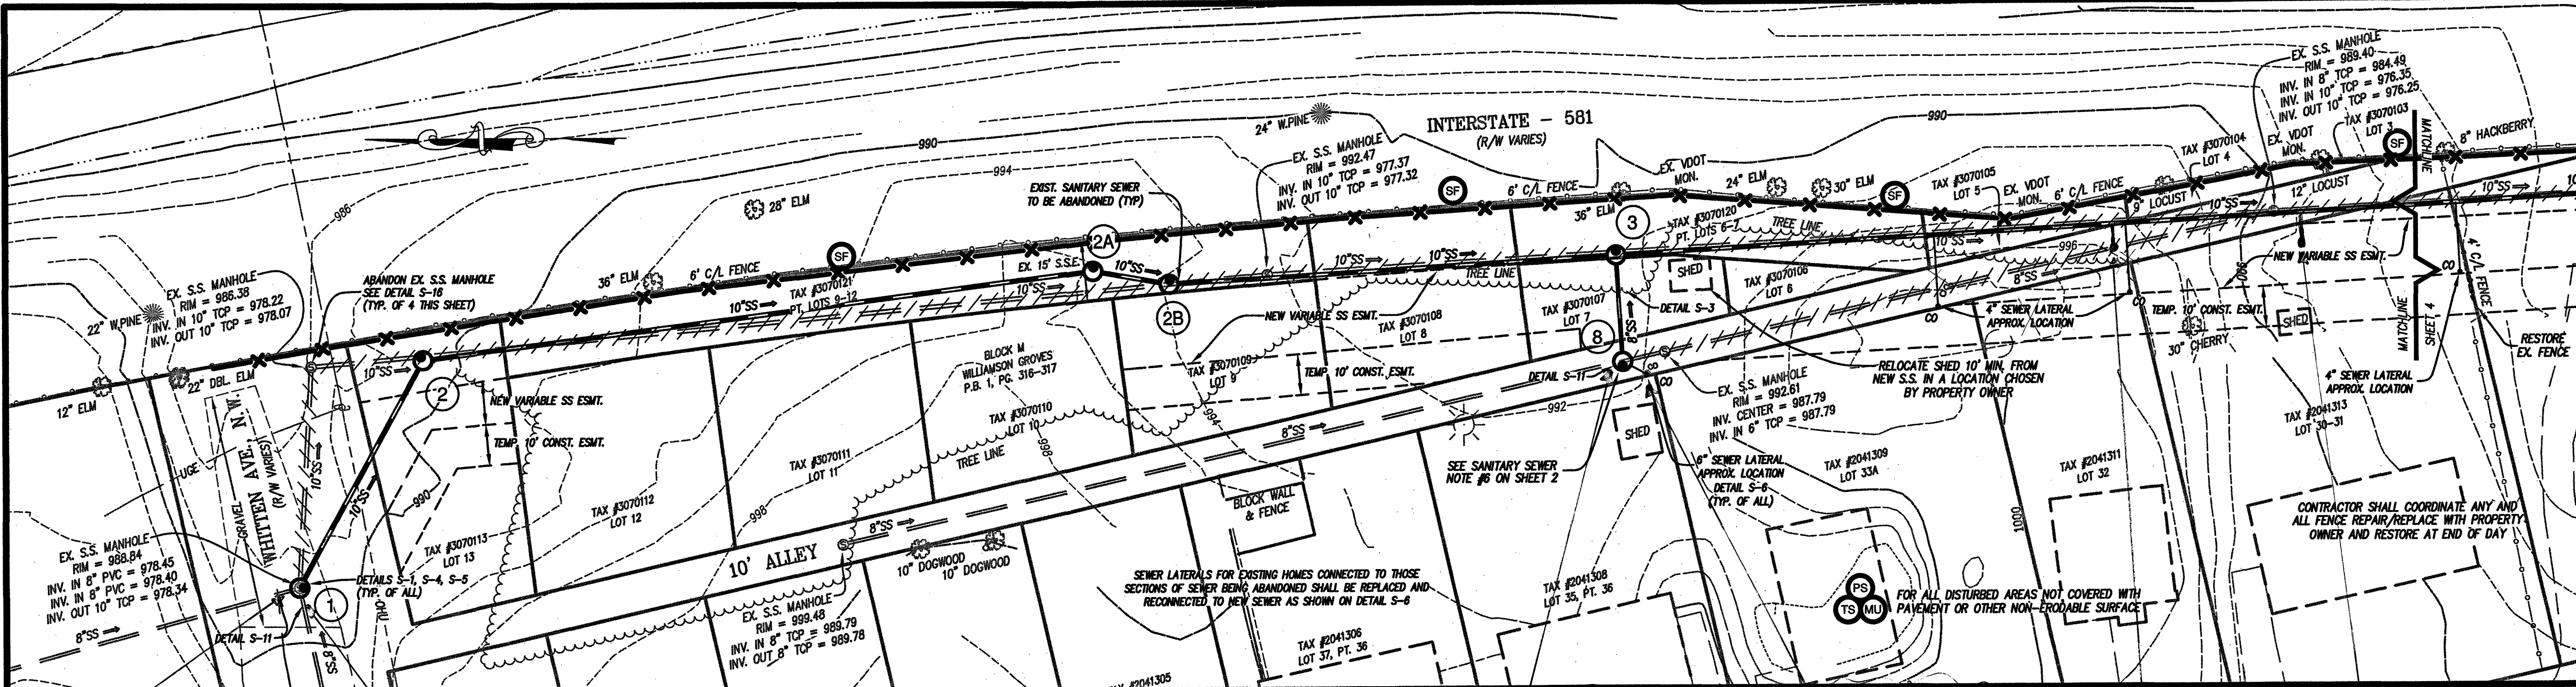

LUMSDEN ASSOCIATES, P.C.
ENGINEERS-SURVEYORS-PLANNERS
ROANOKE, VIRGINIA

4664 BRAMBLETON AVENUE
P.O. BOX 20669
ROANOKE, VIRGINIA 24018

PHONE: (540) 774-4411
FAX: (540) 772-9445
E-MAIL: MAIL@LUMSDENPC.COM

COMMONWEALTH OF VIRGINIA
12-1-14
B. LEE
HENDERSON, JR.
Lic. No. 017591
PROFESSIONAL ENGINEER

**PLAN AND PROFILE
DUNBAR STREET**

**DUNBAR STREET & CARVER AVENUE
SANITARY SEWER REPLACEMENTS**
PREPARED FOR
WESTERN VIRGINIA WATER AUTHORITY
CITY OF ROANOKE, VIRGINIA

NO.	DATE	DESCRIPTION
1	12/01/2014	REVISED (CONTRACTOR'S MANHOLES 2A, 2B, 3, 4 AND 5 EXISTING MANHOLE 4A)
2		
3		
4		
5		

DATE: SEPTEMBER 25, 2014
SCALE:
(H) 1" = 20', (V) 1" = 4'
COMMISSION NO.: 11-039

SHEET 3 OF 8