


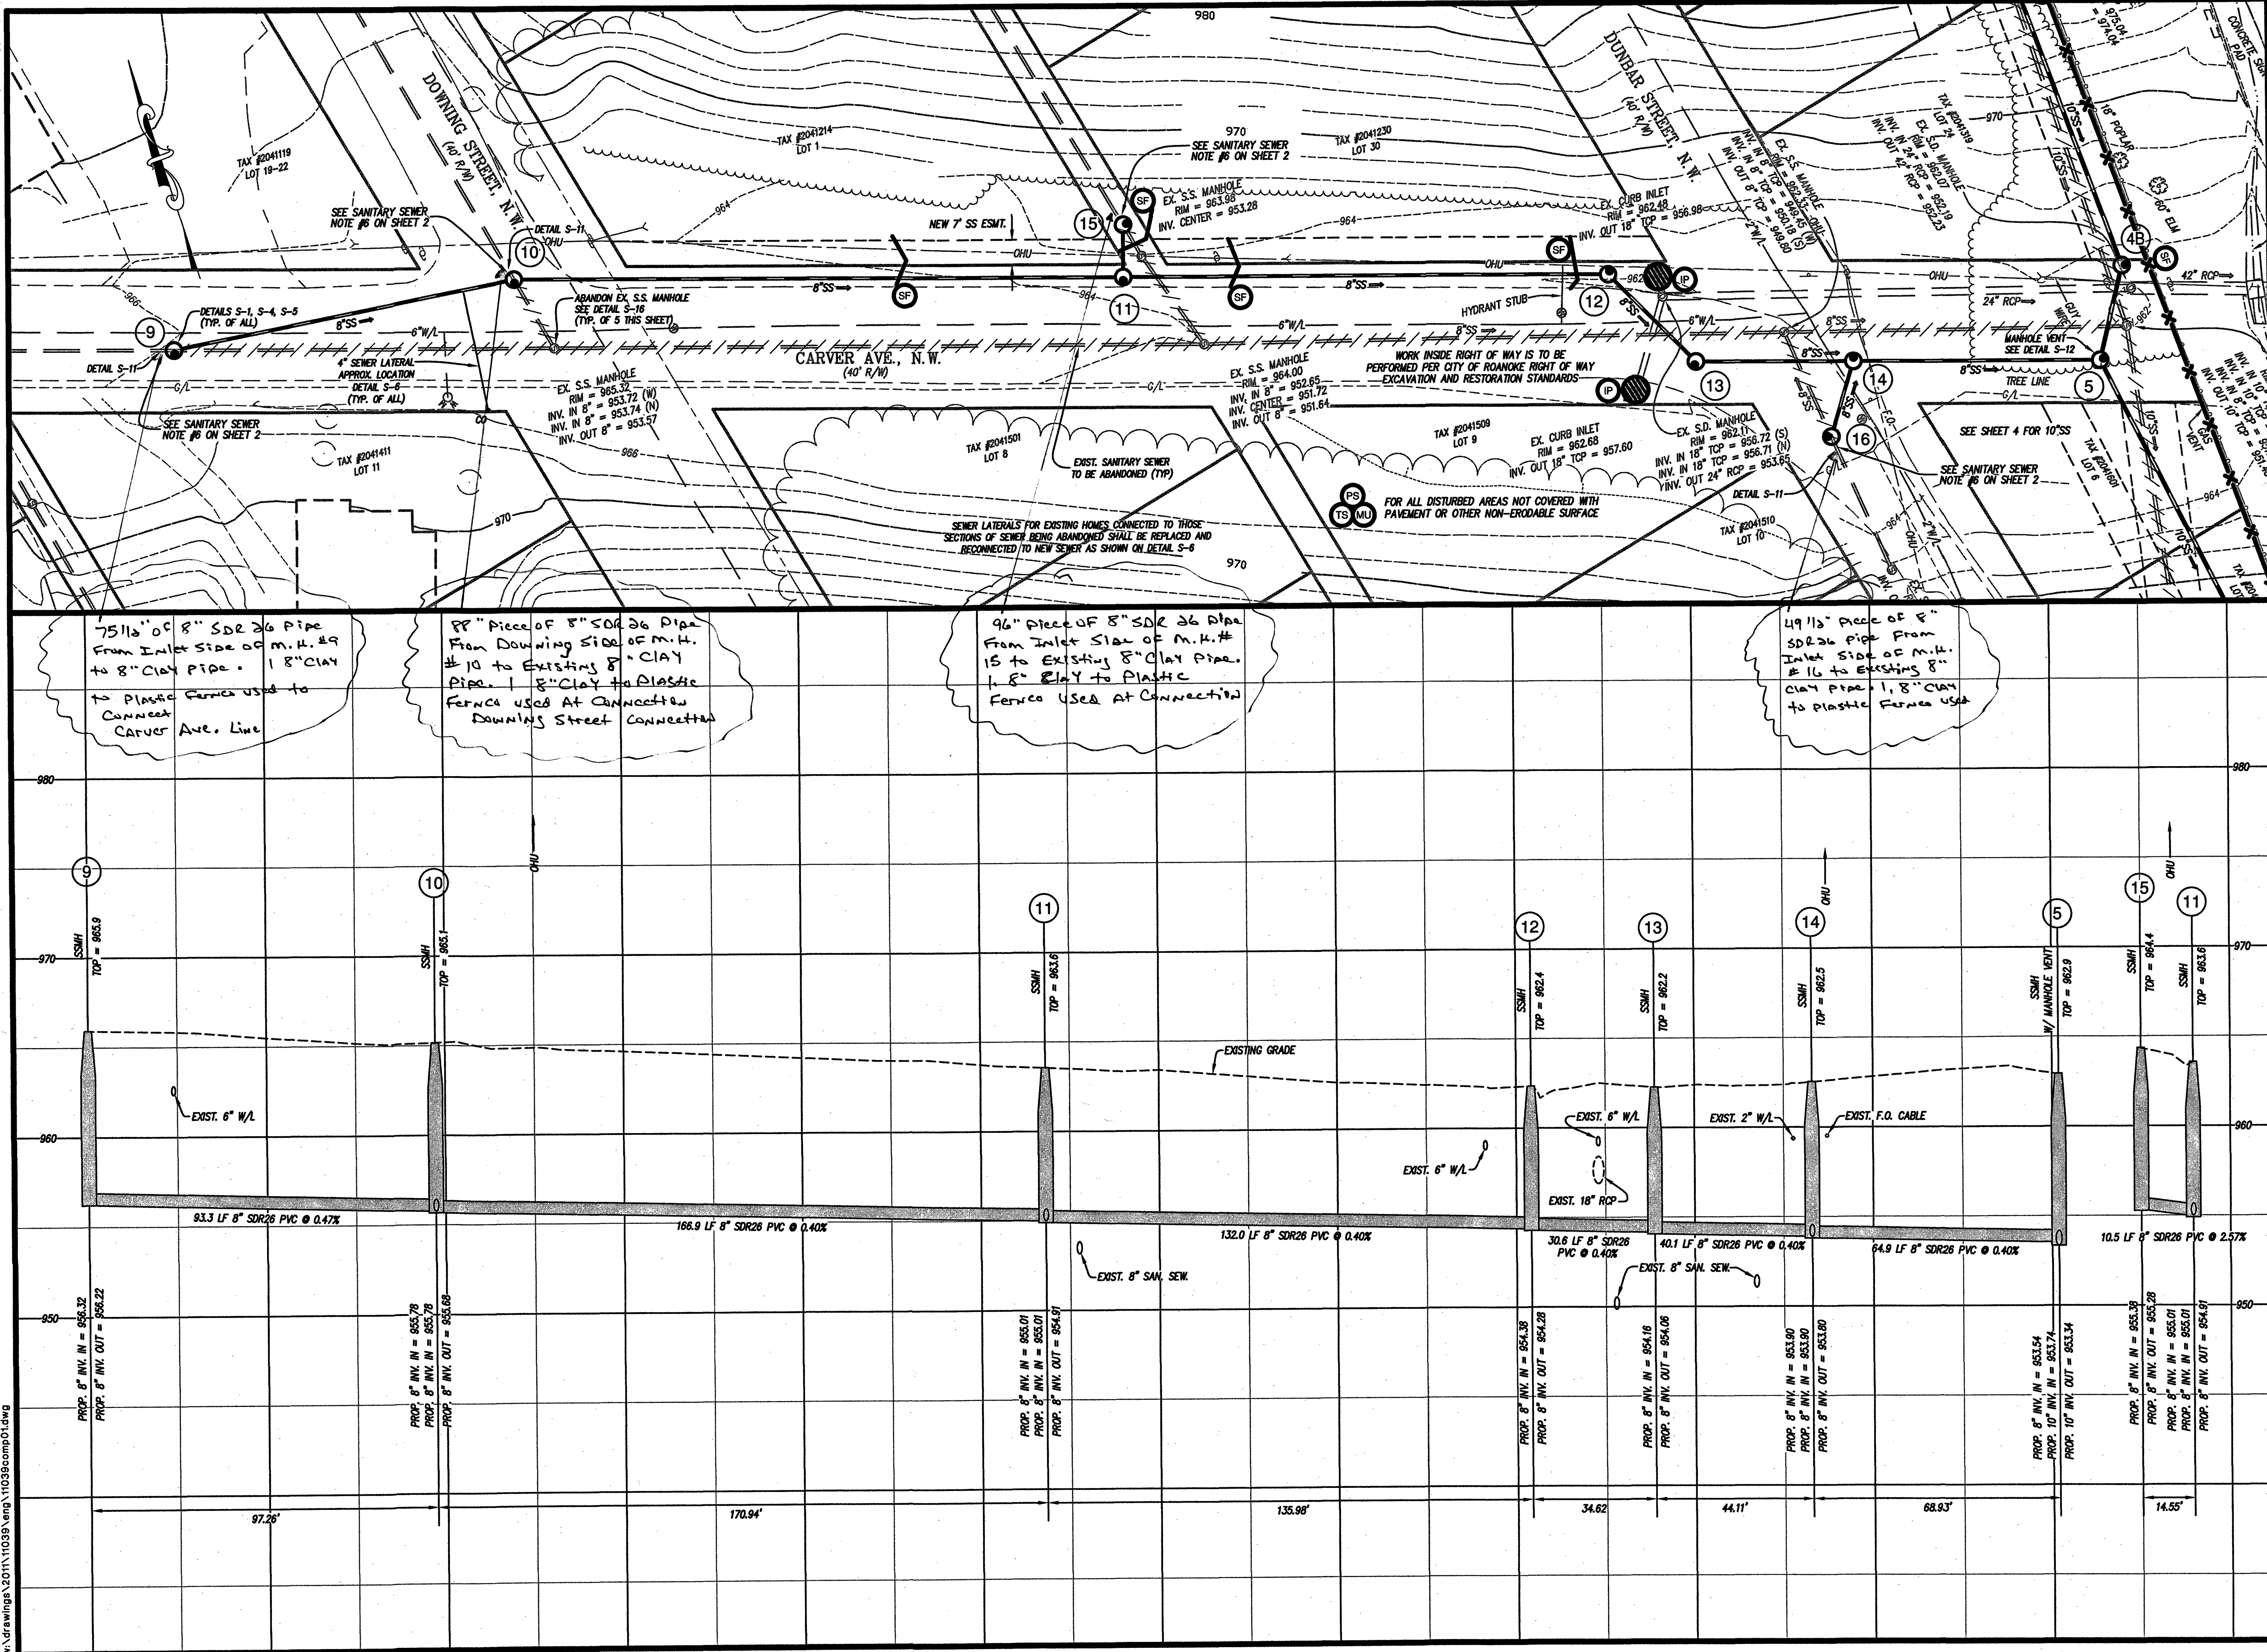

LUMSDEN ASSOCIATES, P.C.
ENGINEERS-SURVEYORS-PLANNERS
ROANOKE, VIRGINIA

464 BRAMBLETON AVENUE
P.O. BOX 2085
ROANOKE, VIRGINIA 24018

PHONE: (540) 774-4411
FAX: (540) 772-9445
E-MAIL: MAIL@LUMSDENPC.COM

PLAN AND PROFILE
CARVER AVENUE

DUNBAR STREET & CARVER AVENUE
SANITARY SEWER REPLACEMENTS
PREPARED FOR
WESTERN VIRGINIA WATER AUTHORITY
CITY OF ROANOKE, VIRGINIA

REVISIONS

NO.	DATE	DESCRIPTION
1		
2		
3		
4		
5		

DATE: SEPTEMBER 25, 2014
SCALE: (H) 1" = 20', (V) 1" = 4'
COMMISSION NO. 11-039
SHEET 5 OF 8