
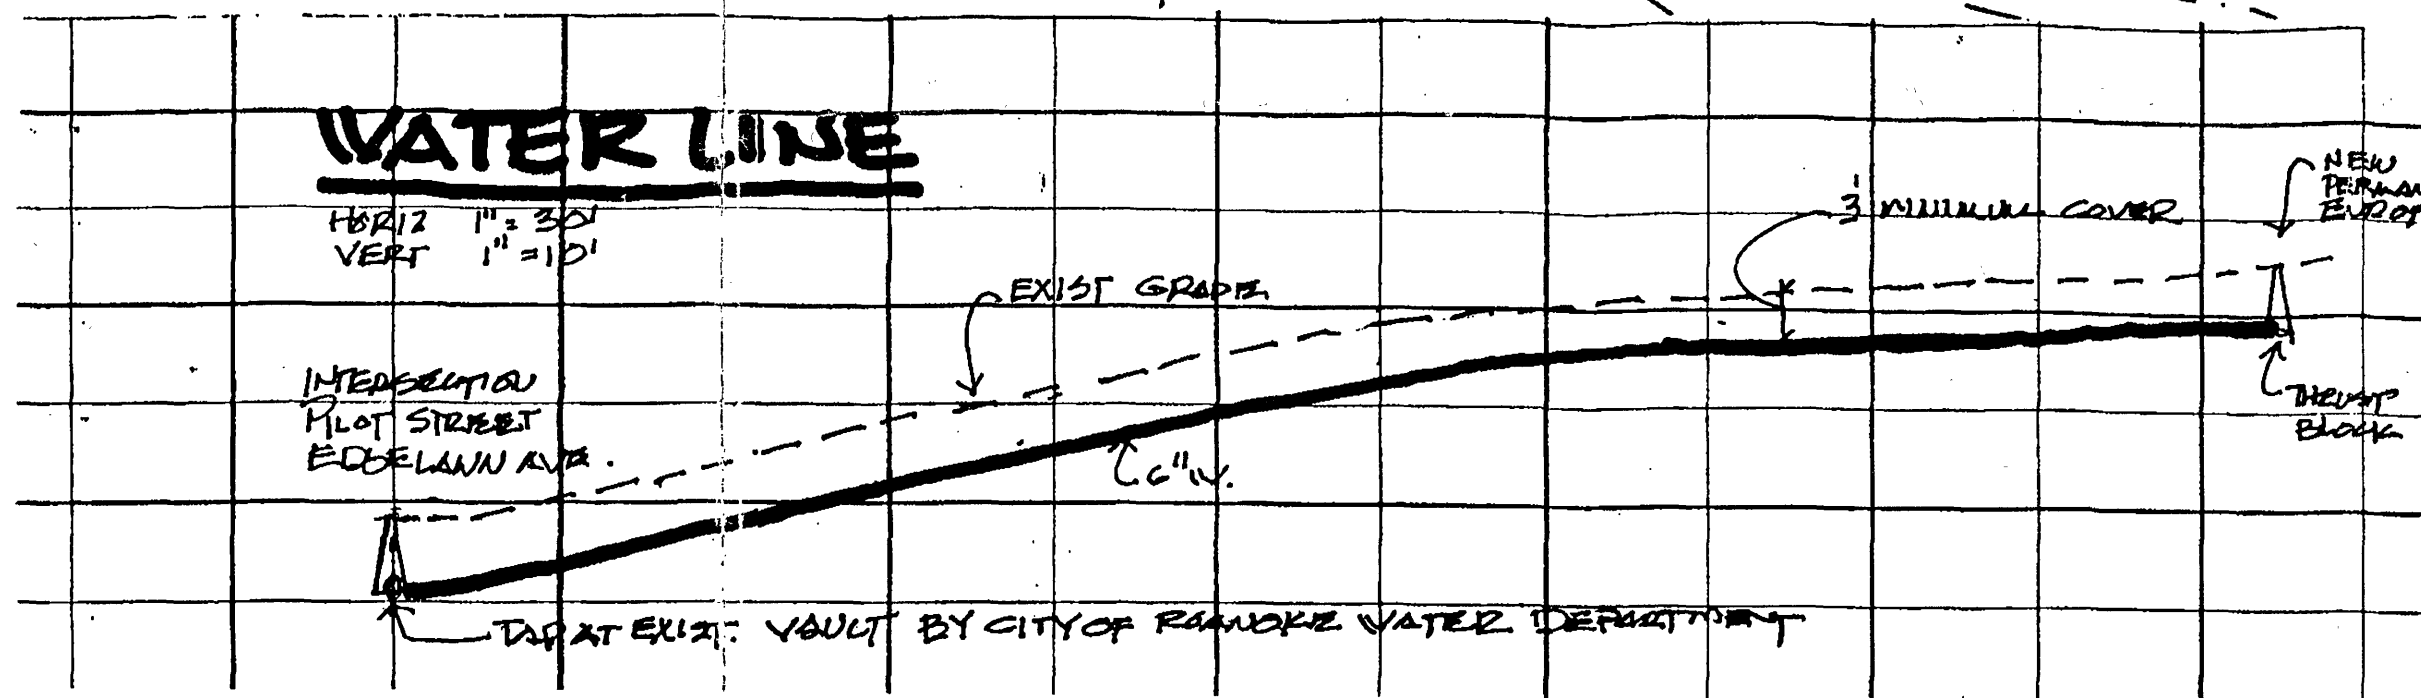


NOTE: THE DESIGN AND CONCEPT INDICATED BY THIS PRINT AND ACCOMPANYING DOCUMENTS ARE THE SOLE PROPERTY OF CRAIGHEAD & ASSOCIATES. ARCHITECTS. THEY MAY NOT BE USED, COPIED, ALTERED OR REPRODUCED IN ANY FORM OR MANNER, FOR ANY PURPOSE, WITHOUT THE WRITTEN PERMISSION OF THE ARCHITECTS. PRINTS NOT BEARING THE SIGNED ARCHITECTS SEAL SHALL BE SCHEMATIC OR DESIGN DEVELOPMENT DRAWING ONLY, NOT FOR CONSTRUCTION.


PROPOSED WATER LINE EXT.
SITE PLAN
1" = 20'-0"

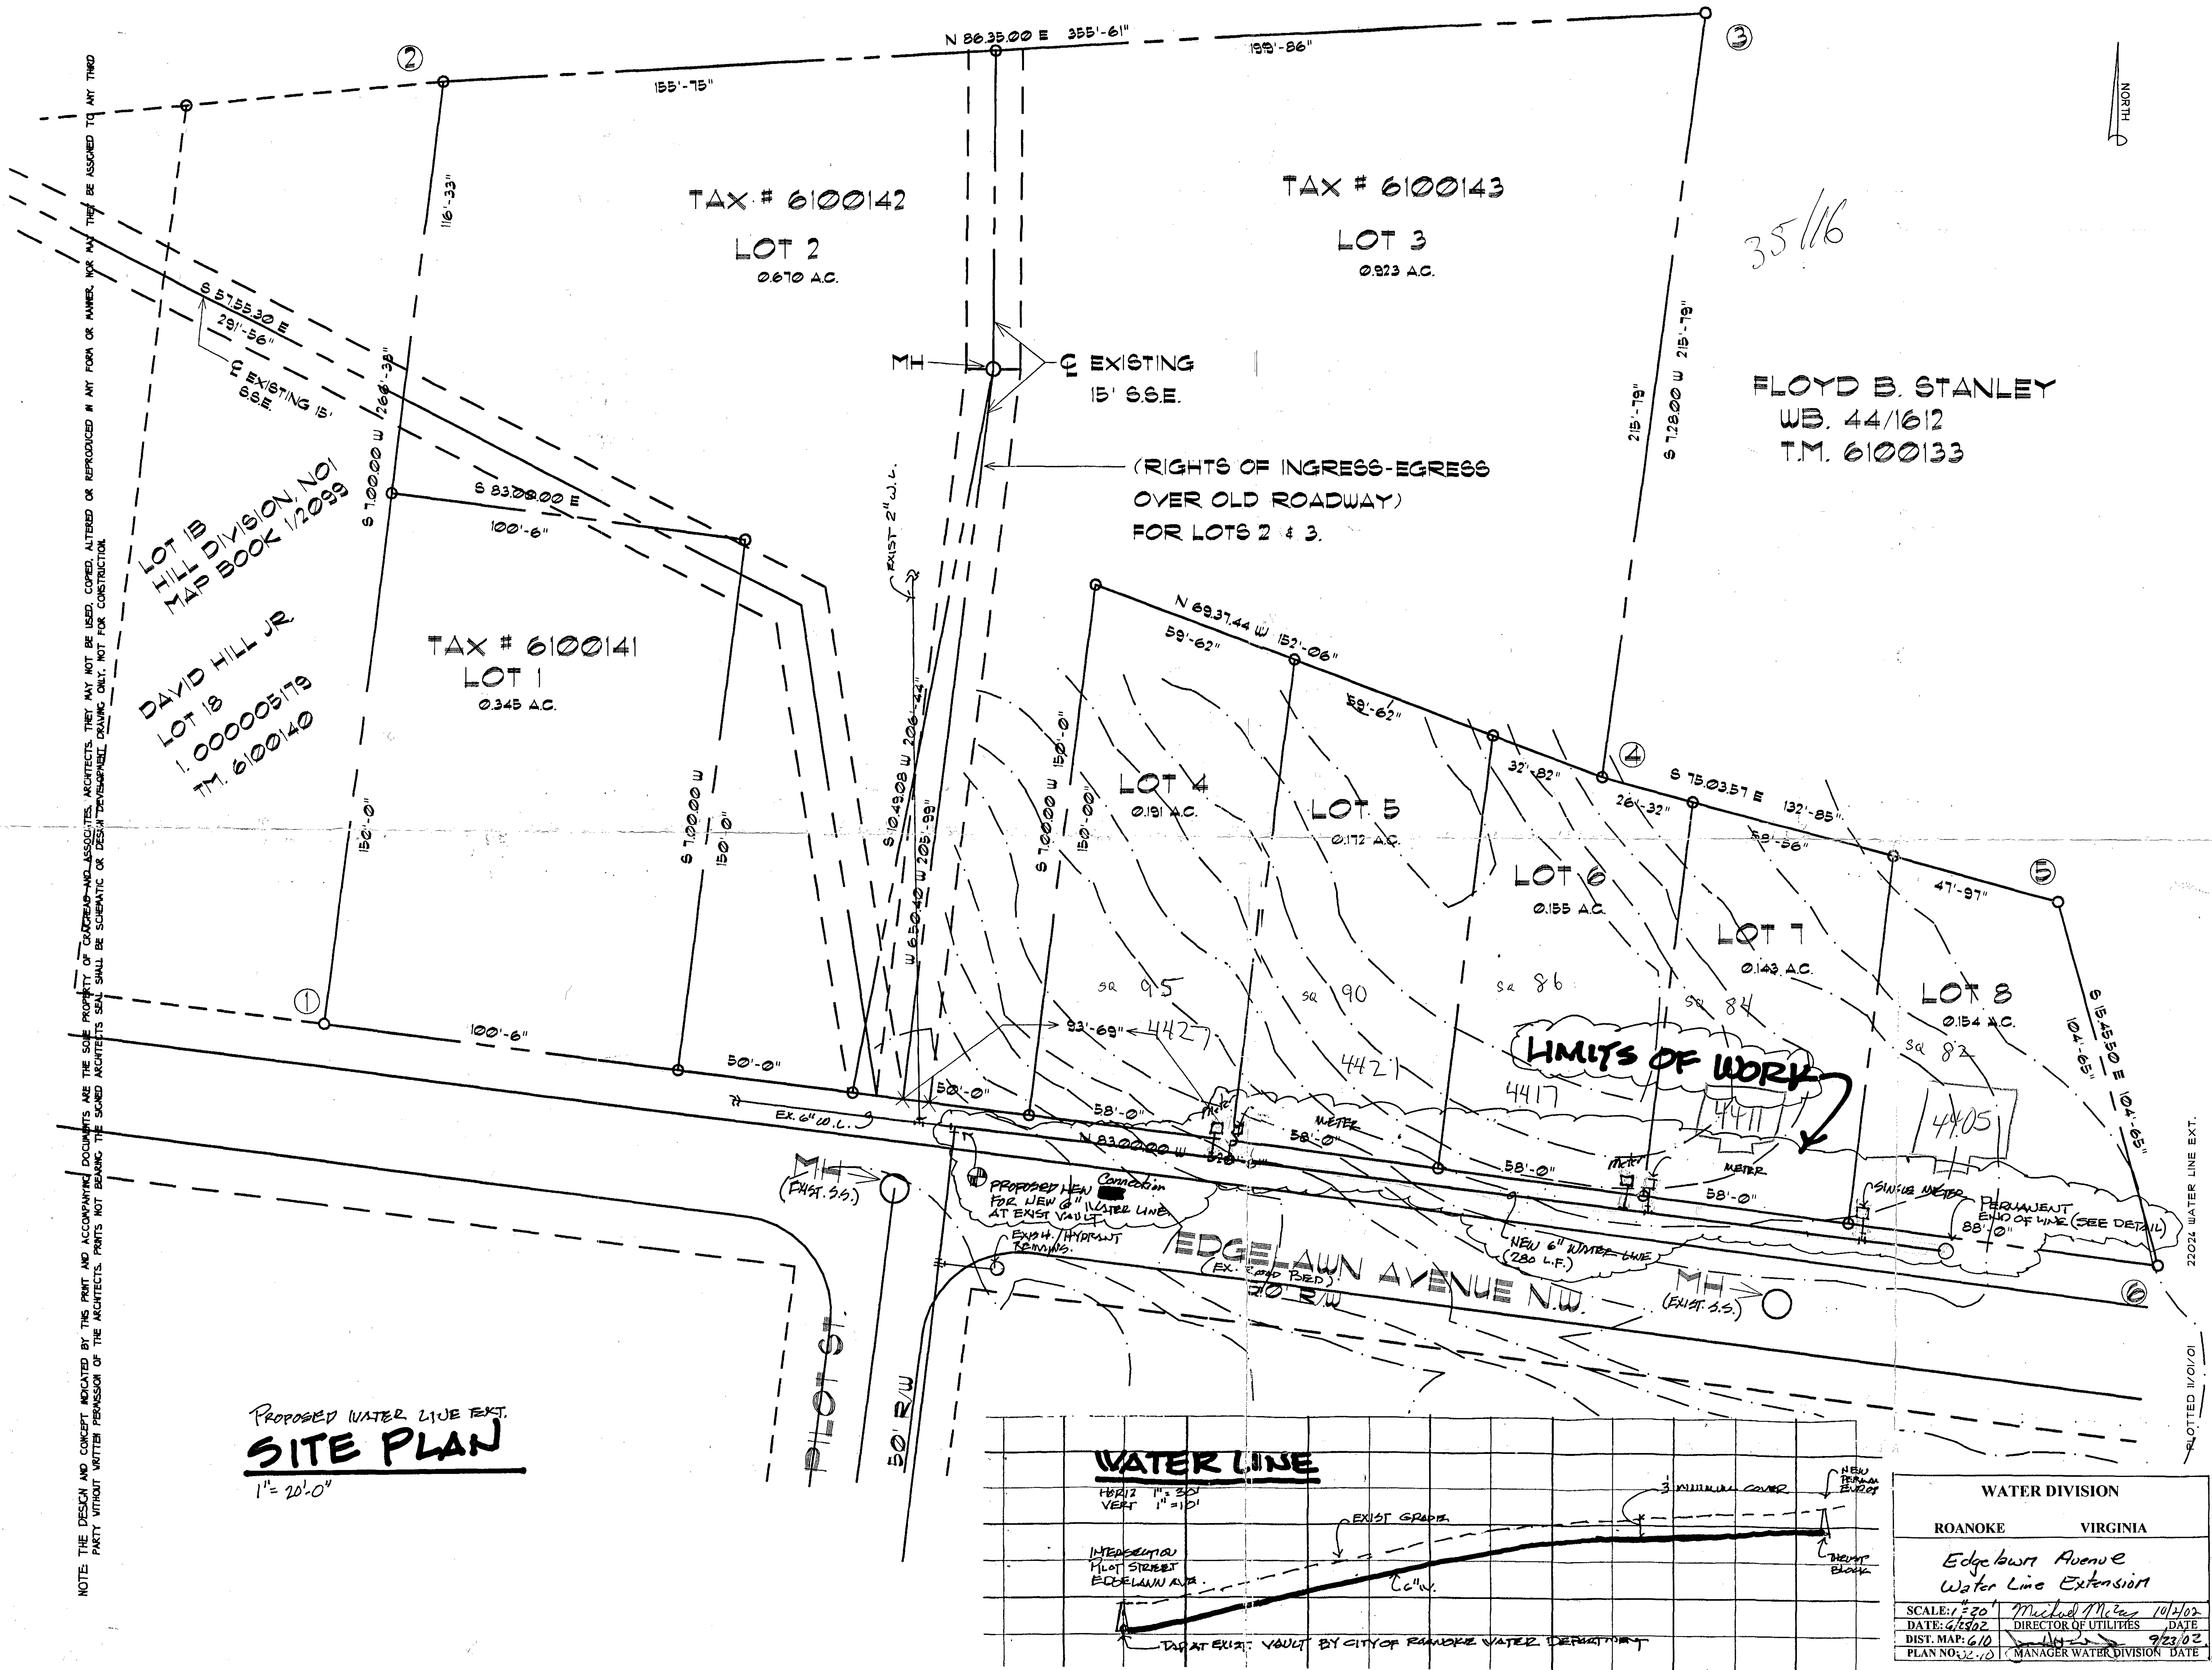

WATER DIVISION	
ROANOKE	VIRGINIA
Edgeclawn Avenue Water Line Extension	
SCALE: 1" = 20'	DATE: 6/25/02
DIST. MAP: 6/10	MANAGER WATER DIVISION DATE: 9/23/02

CRAIGHEAD & ASSOCIATES
Architects, Designers, Construction Managers
2721 BRAMBLETON AVENUE
SUITE 2
ROANOKE, VIRGINIA 24015
(703) 771-5324
FAX (703) 901-0132

△	---	---
△	---	---
△	---	---
△	---	---
△	---	---
△	---	---
REVISIONS	DATE	

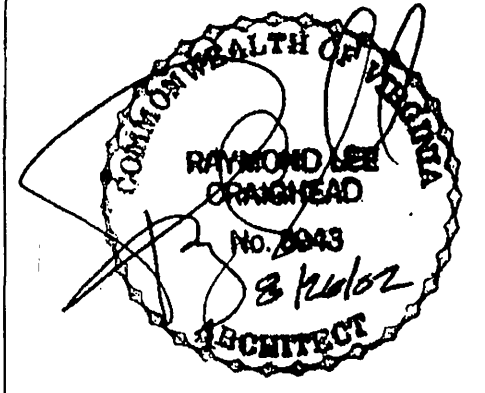

PROPOSED SITE
LAYOUT FOR
WATER LINE EXT.
EDGECLAWN ST.

ROANOKE COUNTY VA
PROJECT NO: 22026
DATE: 6/25/02
DRAWN BY: GWK
CHECKED BY: RLC

APPROVED FOR THE OWNER DATE: 8-27-02

S-2
WATER LINE EXT.

SCALE: AS NOTED
GRAPHIC: