

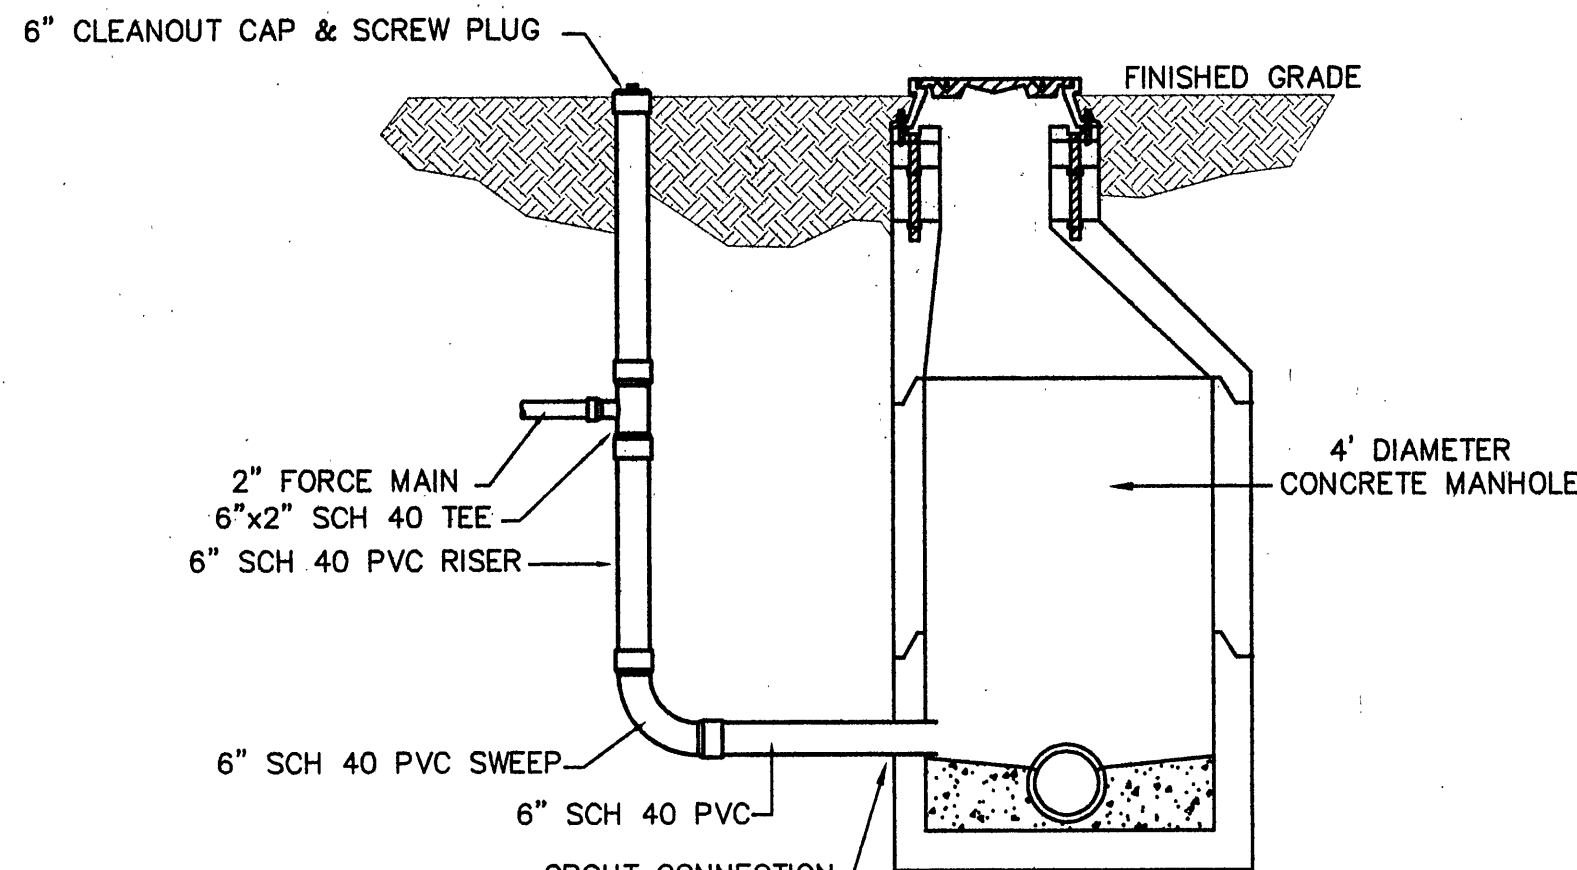


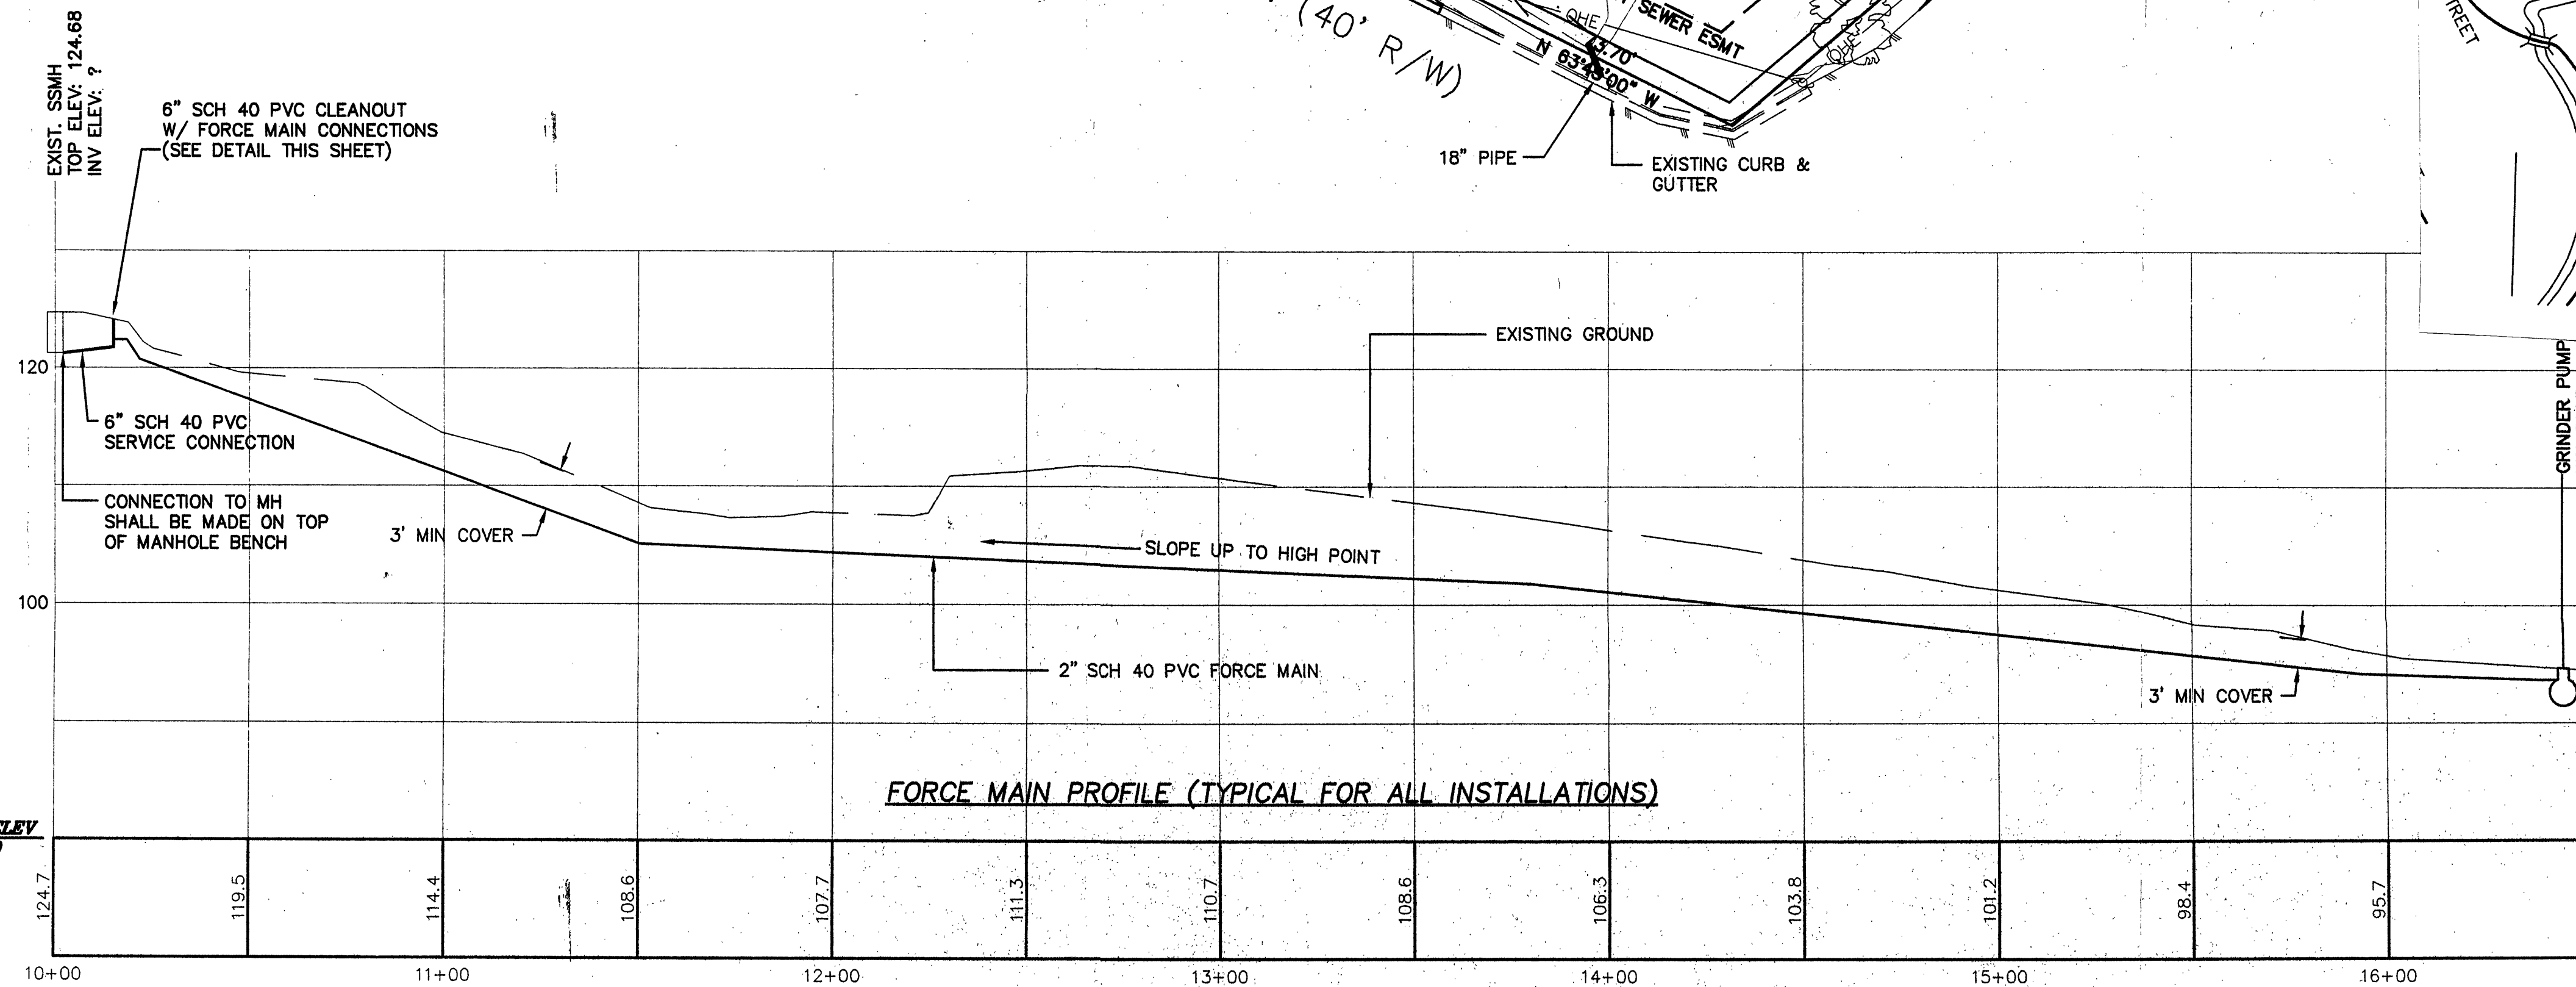

FORCE MAIN SERVICE CONNECTION

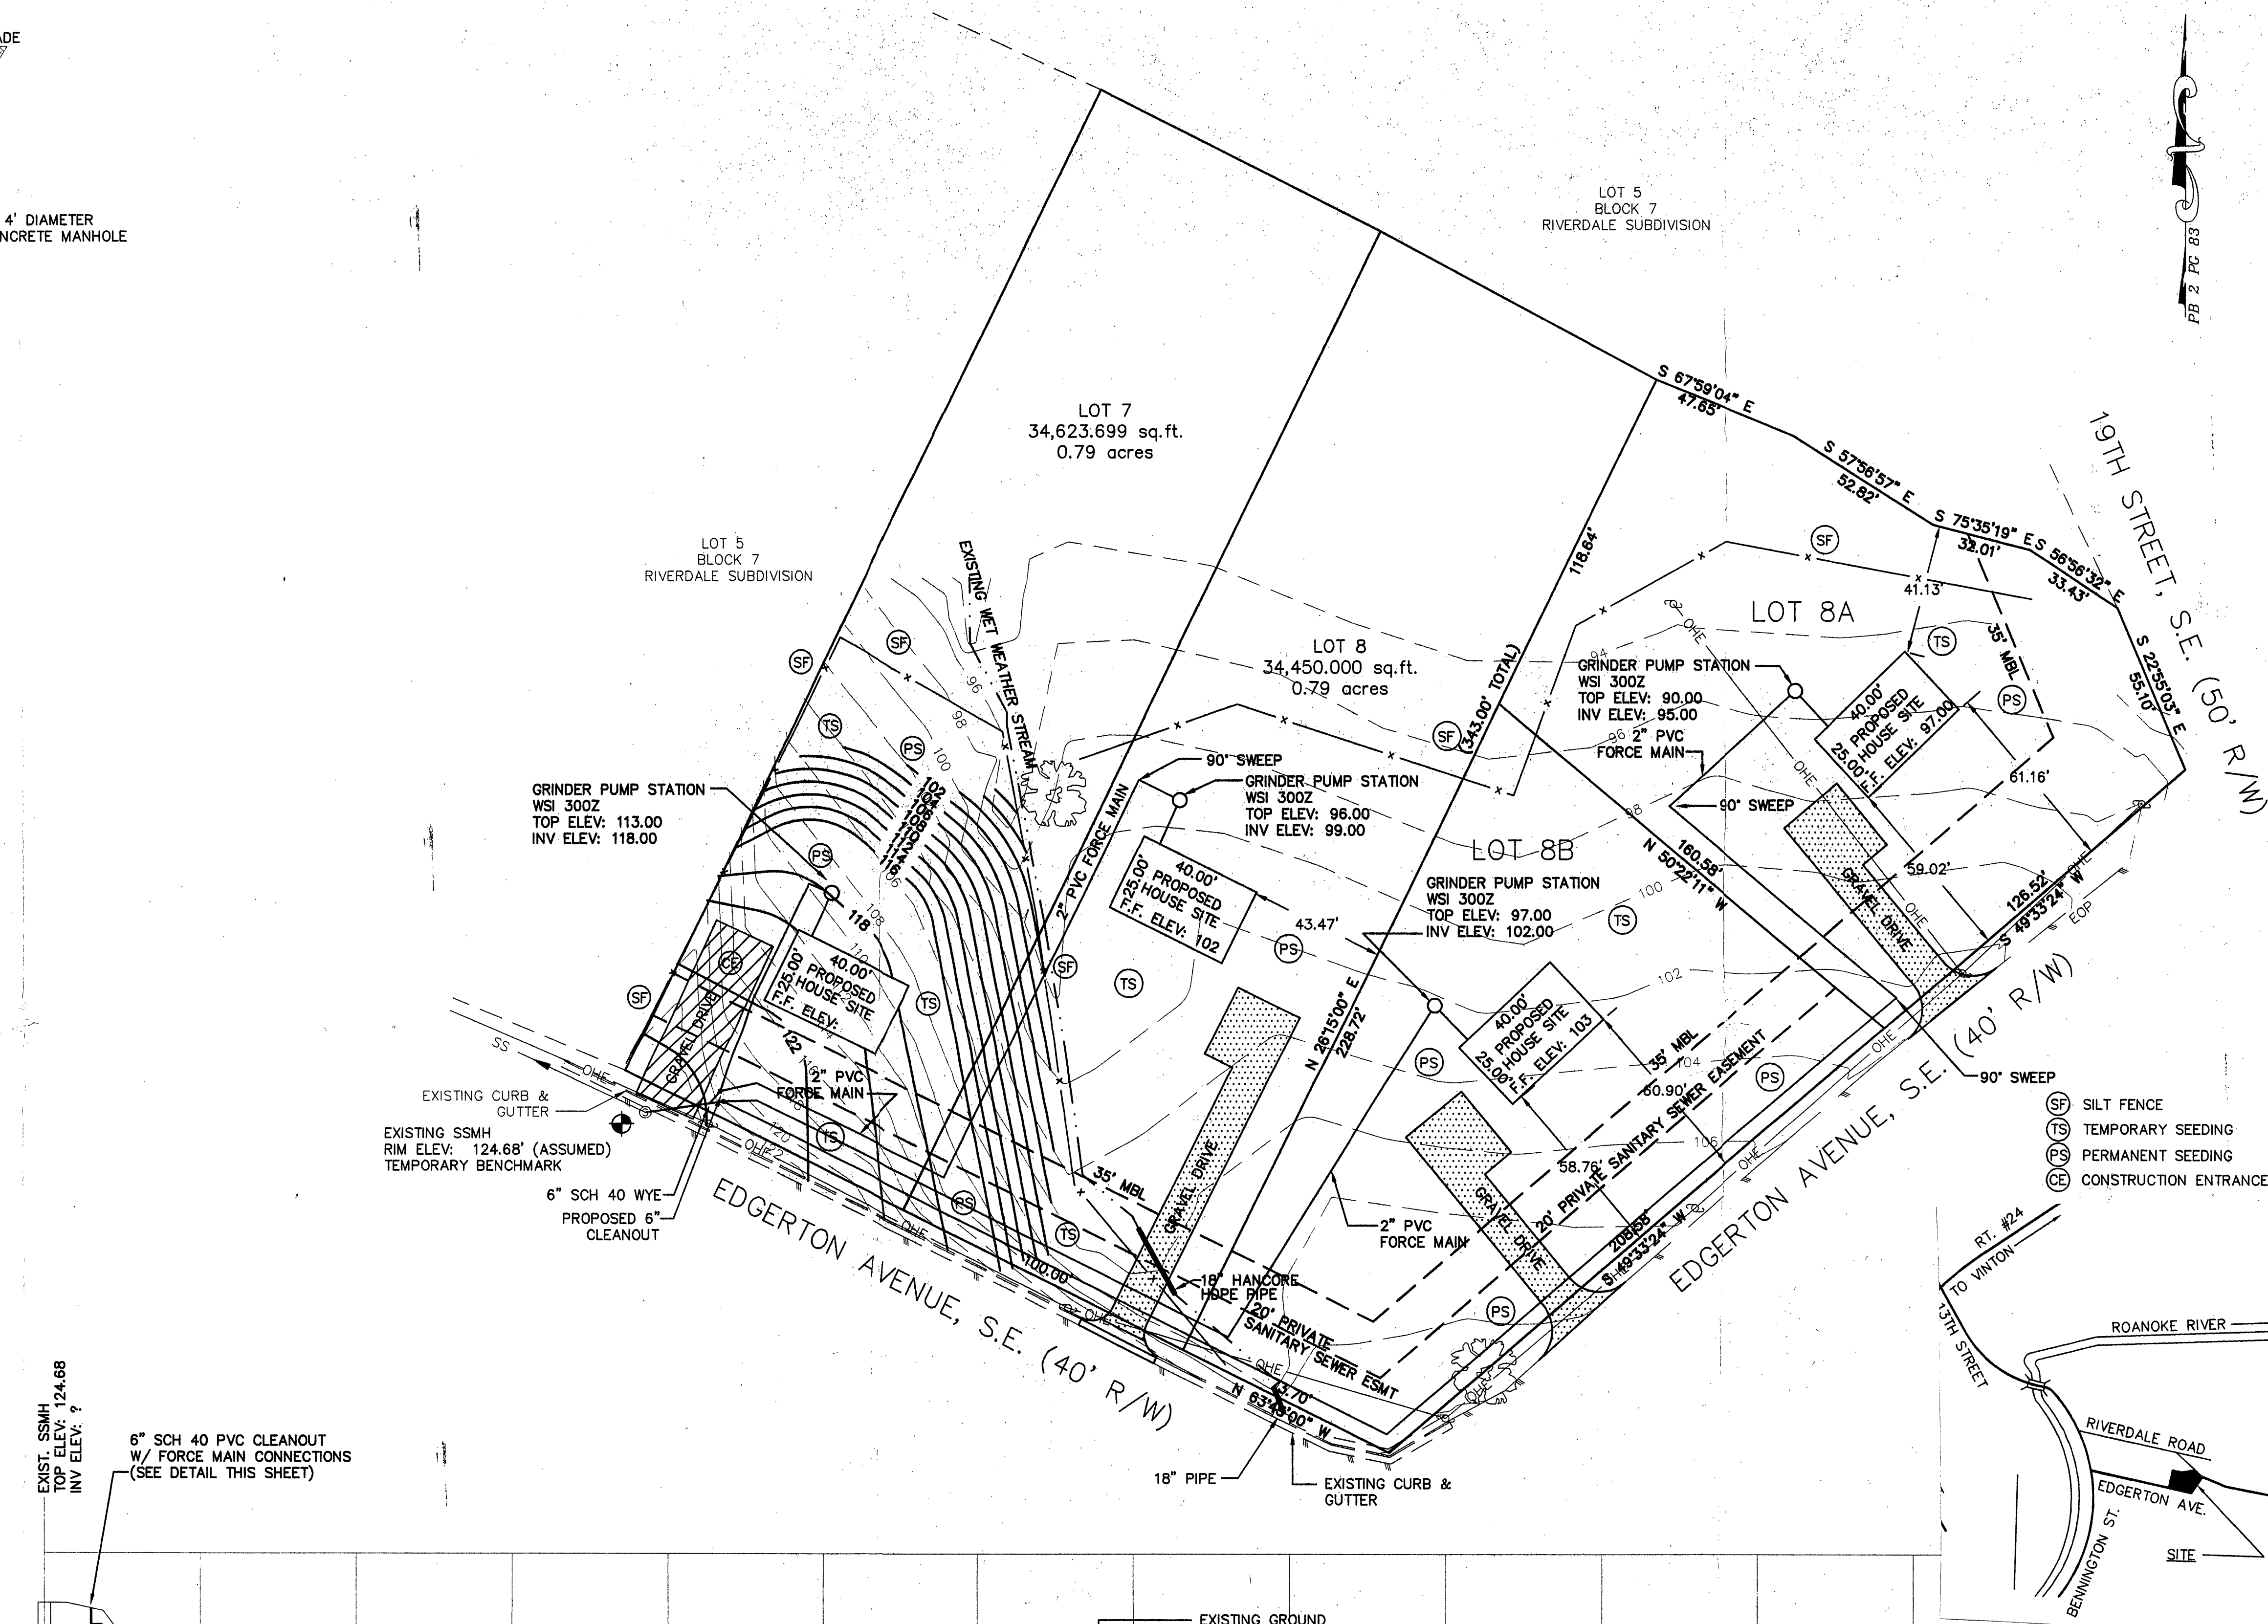

FORCE MAIN PROFILE (TYPICAL FOR ALL INSTALLATIONS)

GENERAL NOTES


- ALL FILLS SHALL BE COMPACTED TO 95% STANDARD PROCTOR
- ALL EROSION & SEDIMENT CONTROL MEASURES SHOWN ON THIS PLAN SHALL BE THE MINIMUM CONSIDERED NECESSARY TO MAINTAIN SEDIMENT CONTROL. SITE CONDITIONS MAY WARRANT ADDITIONAL MEASURES DURING CONSTRUCTION.
- THE SANITARY SEWER FORCE MAINS SHALL BE CONSTRUCTED OF 2" DIA. SCHEDULE 40 PVC PIPE. PRESSURE FITTING GLUE JOINTS SHALL BE USED AT ALL JOINT CONNECTIONS. THERE SHALL BE NO LOCAL HIGH OR LOW JOINTS LOCATED ON THE FORCE MAINS.
- ALL FORCE MAINS SHALL BE INSTALLED WITH A MINIMUM OF 3' COVER.
- ALL PUMP STATIONS SHALL BE WSI 300Z BRAND. SEE SHEET #4 FOR DETAILS.
- CONNECTION OF THE 6" SANITARY SEWER SERVICE CONNECTION SHALL BE MADE BY THE CITY OF ROANOKE UTILITY DEPARTMENT.

DATUM ELEV
80.00

- SF SILT FENCE
- TS TEMPORARY SEEDING
- PS PERMANENT SEEDING
- CE CONSTRUCTION ENTRANCE

DON SHORES
SITE PLAN
EROSION CONTROL PLAN

NO	DATE	DESCRIPTION	BY

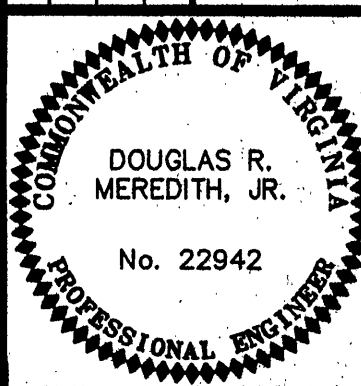

Designed By	DME
Drawn By	DME
Checked By	RCW
Approved By	DRM
Submitted By	DRM

Drawing	666SITE.DWG
Date	06/15/98
Scale	H: 1" = 30'
Commission No.	666C

LMW P.C.

ENGINEERING - ARCHITECTURE - SURVEYING
102 ALBEMARLE AVE., S.E.
ROANOKE, VIRGINIA 24013
TEL (840) 345-0675
FAX (840) 342-4466