


NOTE:
CUT IN NEW CONNECTIONS AS
REQUIRED. CONTRACTOR IS
RESPONSIBLE FOR COORDINATING
WITH WWA AT TIME OF CONNECTION.

- UTILITY LEGEND
REFERENCE PLAN AND PROFILE FOR SIZE
- GV GATE VALVE
 - WL PVC PIPE
 - FH NEW FIRE HYDRANT ASSEMBLY
 - RF REDUCER FITTING

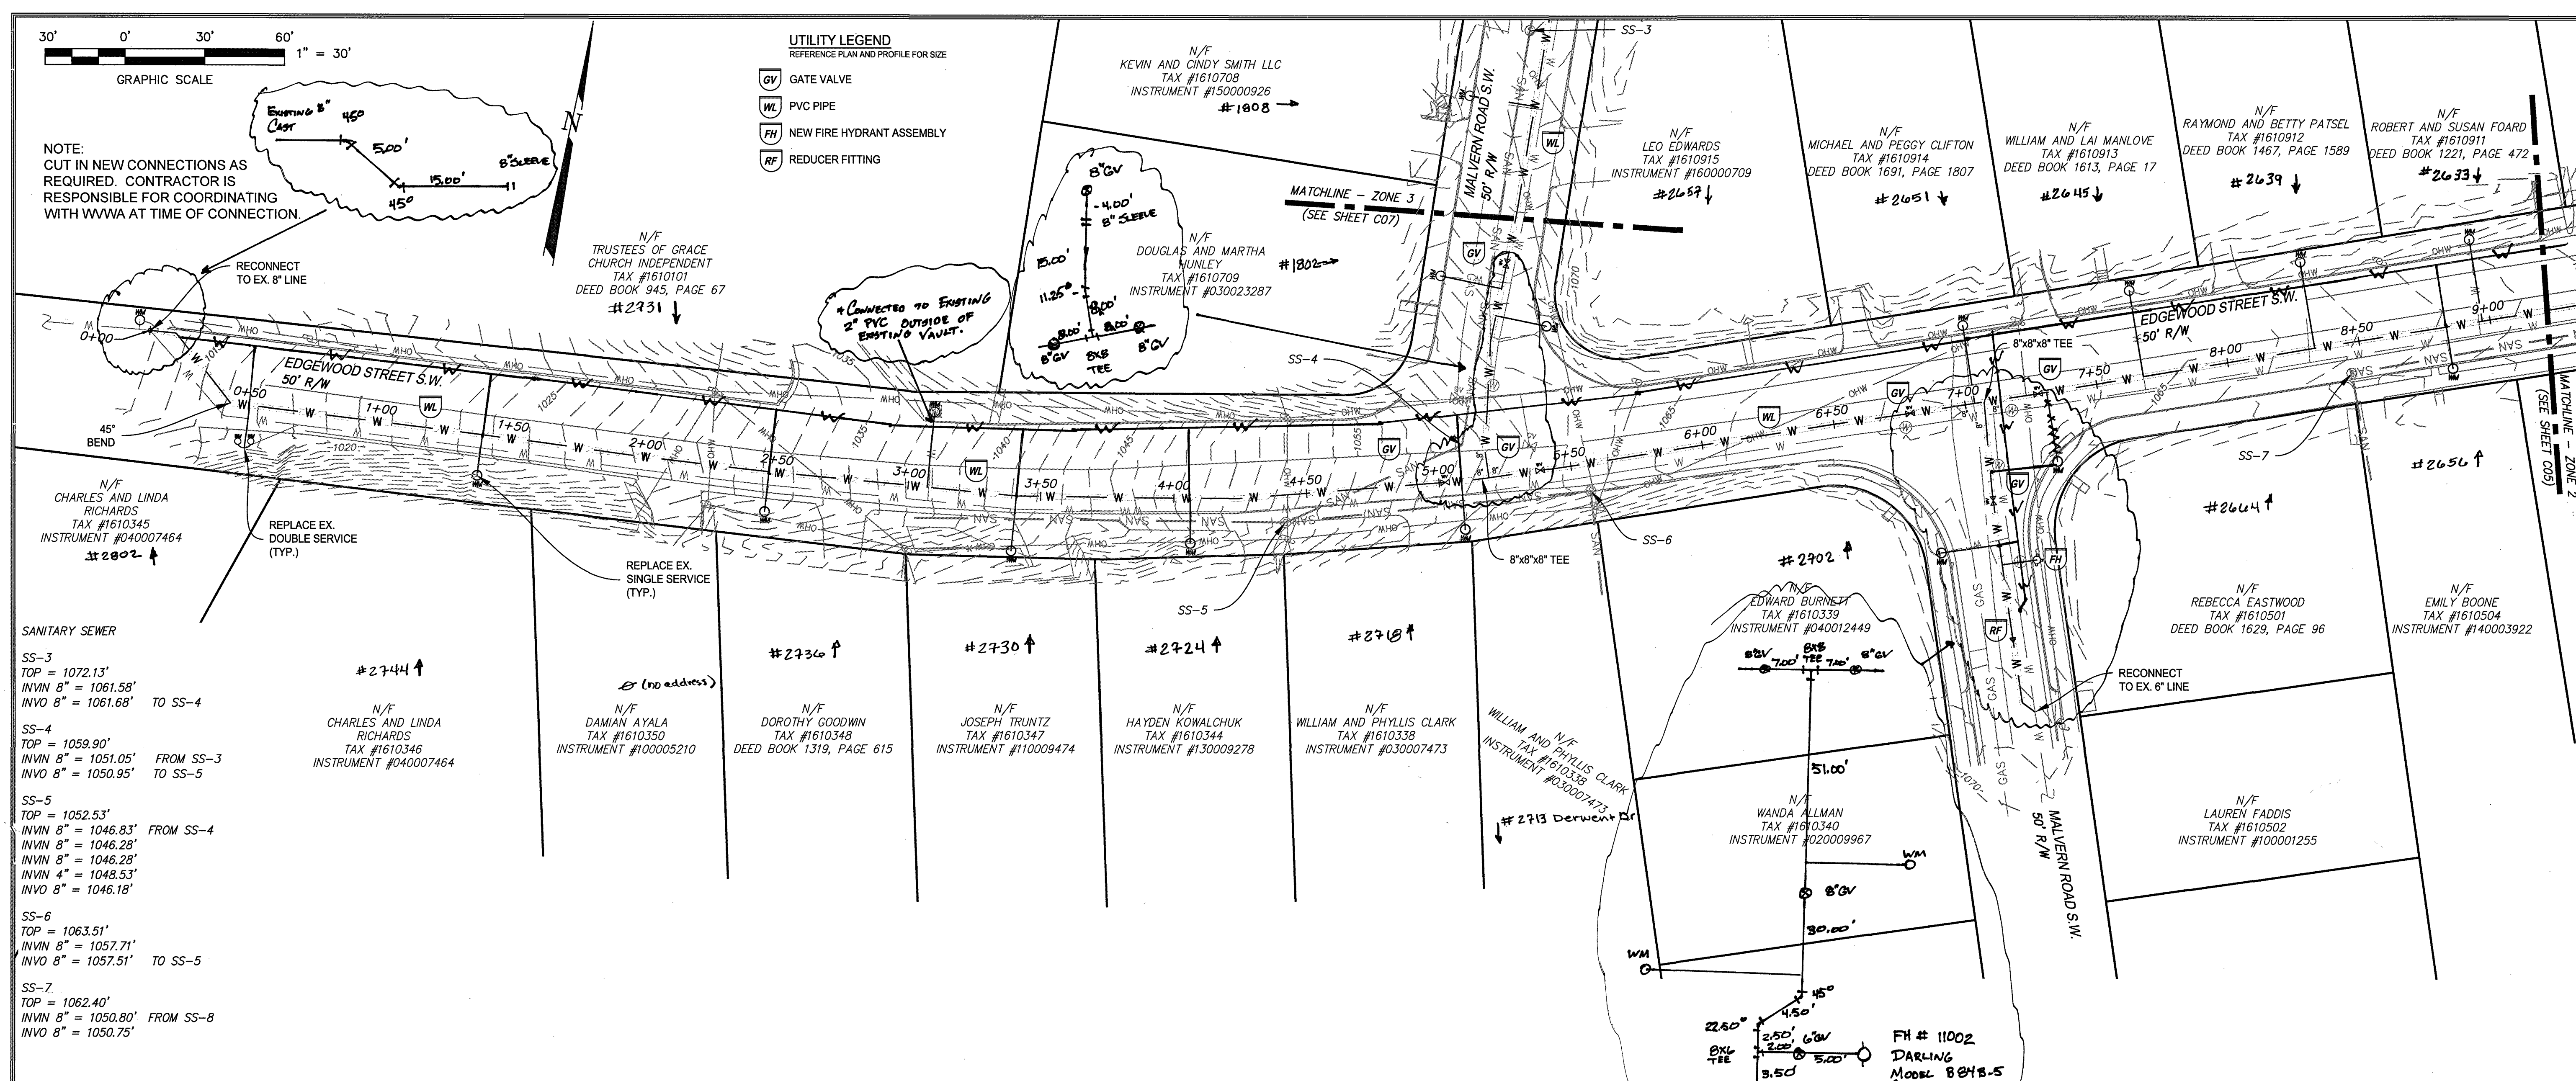

SANITARY SEWER

SS-3
TOP = 1072.13'
INVIN 8" = 1061.58'
INVO 8" = 1061.68' TO SS-4

SS-4
TOP = 1059.90'
INVIN 8" = 1051.05' FROM SS-3
INVO 8" = 1050.95' TO SS-5


SS-5
TOP = 1052.53'
INVIN 8" = 1046.83' FROM SS-4
INVIN 8" = 1046.28'
INVIN 4" = 1043.53'
INVO 8" = 1046.18'

SS-6
TOP = 1063.51'
INVIN 8" = 1057.71'
INVO 8" = 1057.51' TO SS-5

SS-7
TOP = 1062.40'
INVIN 8" = 1050.80' FROM SS-8
INVO 8" = 1050.75'


NOTE:
EXISTING UTILITIES ARE ASSUMED TO BE 3' IN DEPTH
UNLESS OTHERWISE NOTED. CONTRACTOR IS
RESPONSIBLE TO POTHOLE AND VERIFY DEPTHS. A
MINIMUM OF 3' OF COVER IS REQUIRED FOR ALL NEW
WATERLINE PER G-11 FROM WWA.

NOTE:
CONTRACTOR SHALL REPLACE ALL
SERVICE CONNECTIONS ENCOUNTERED.

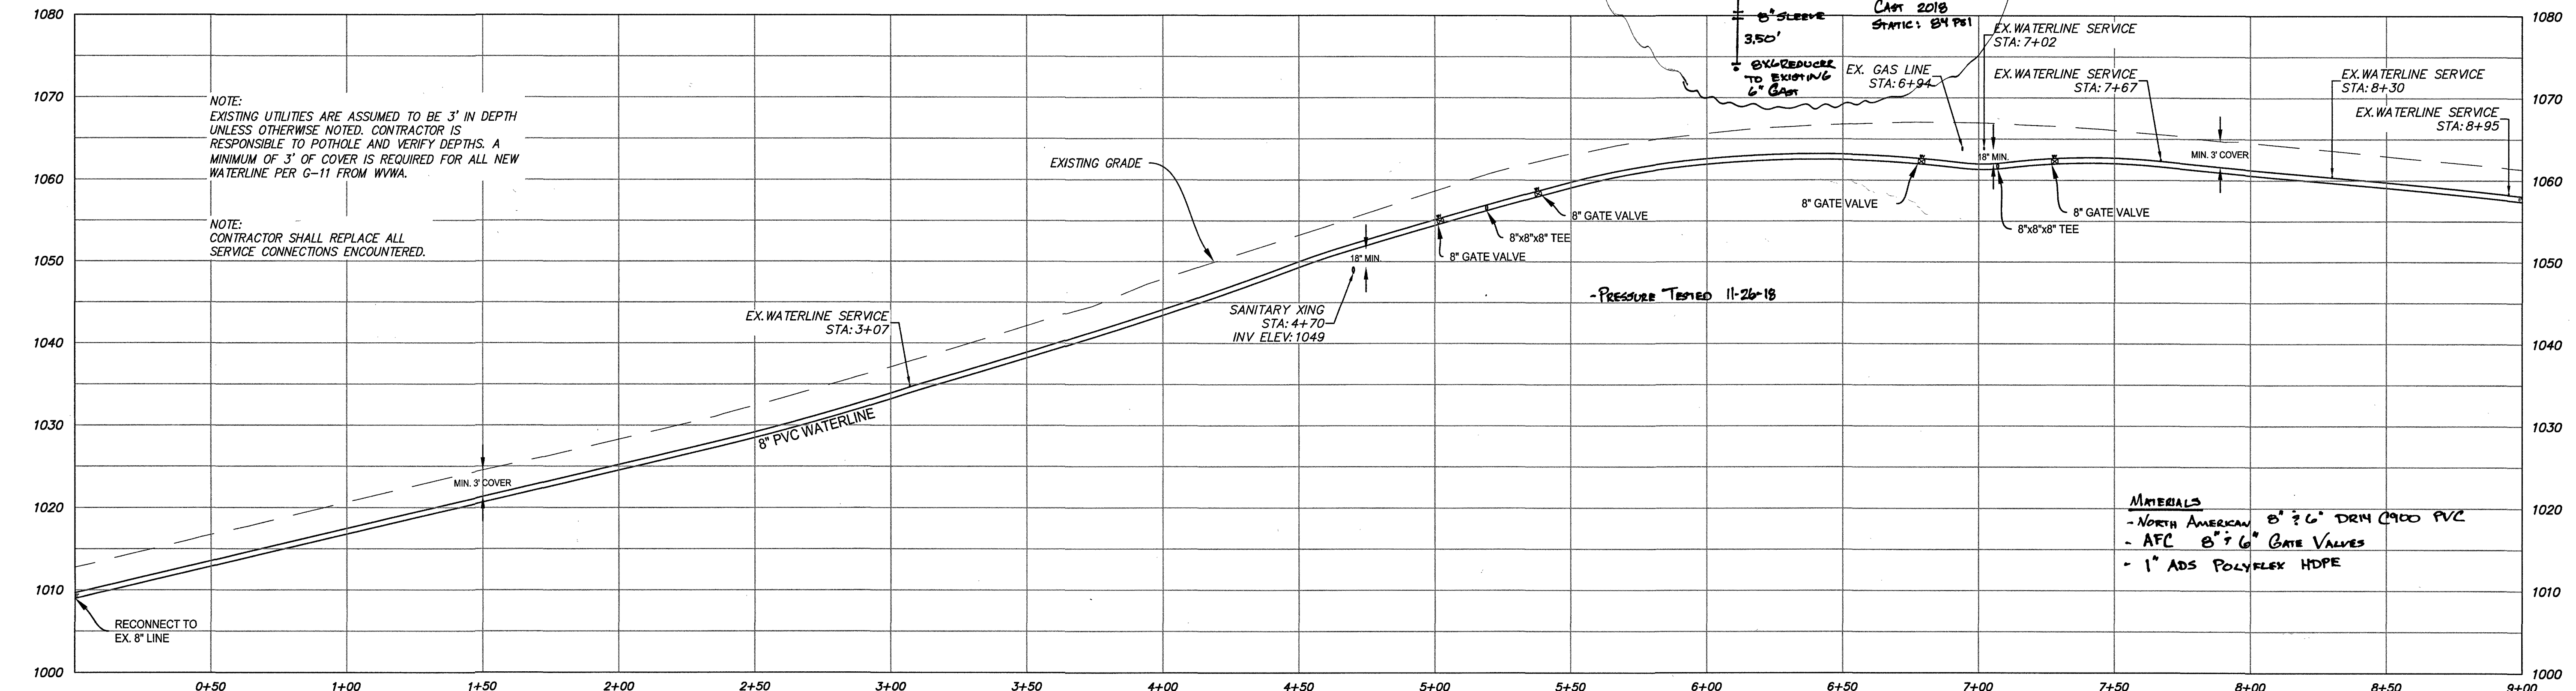


EDGEWOOD STREET S.W. 0+00 - 9+00 PROFILE
1" = 30' Horizontal
1" = 10' Vertical

MATERIALS
- NORTH AMERICAN 8" x 6" DR11 C900 PVC
- AFC 8" x 6" GATE VALVES
- 1" ADS POLYFLEX HDPE

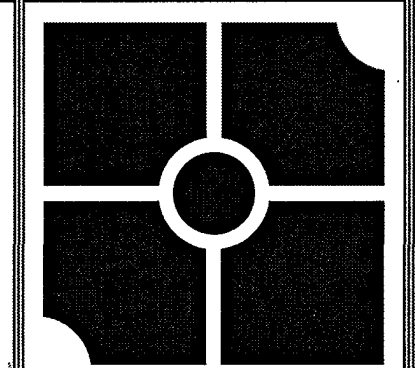

parker
DESIGN GROUP
2122 Carolina Ave. SW
Roanoke, VA 24014
Ph: 540-387-1153
Fax: 540-389-5767
1915-B W. Cary Street
Richmond, VA 23220
Phone: 804-358-2947
Fax: 804-359-9645
180 AMT Tech Dr.
Suite 101-B
Rocky Mount, VA 24151
Phone: 804-358-2947
Fax: 804-359-9645
www.parkergd.com

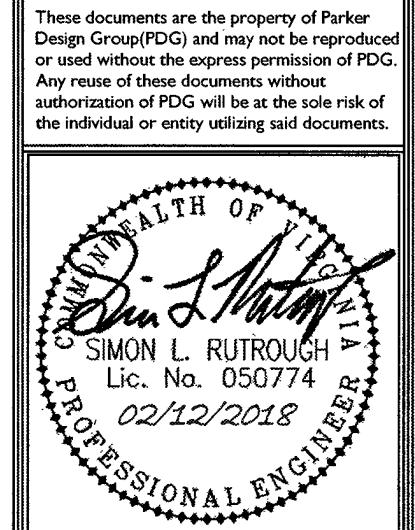

EDGEWOOD / WINDSOR WATERLINE UTILITY REPLACEMENT PLAN

WESTERN VIRGINIA WATER AUTHORITY
ROANOKE CITY, VIRGINIA

DESIGNED BY:	DATE:
DRAWN BY:	12 FEBRUARY, 2018
CHECKED BY:	SHEET TITLE:
	EDGEWOOD ST SW
	WATERLINE STA
	0+00 - 9+00
	SCALE:
	1" = 30'
	SHEET NO.

C04