




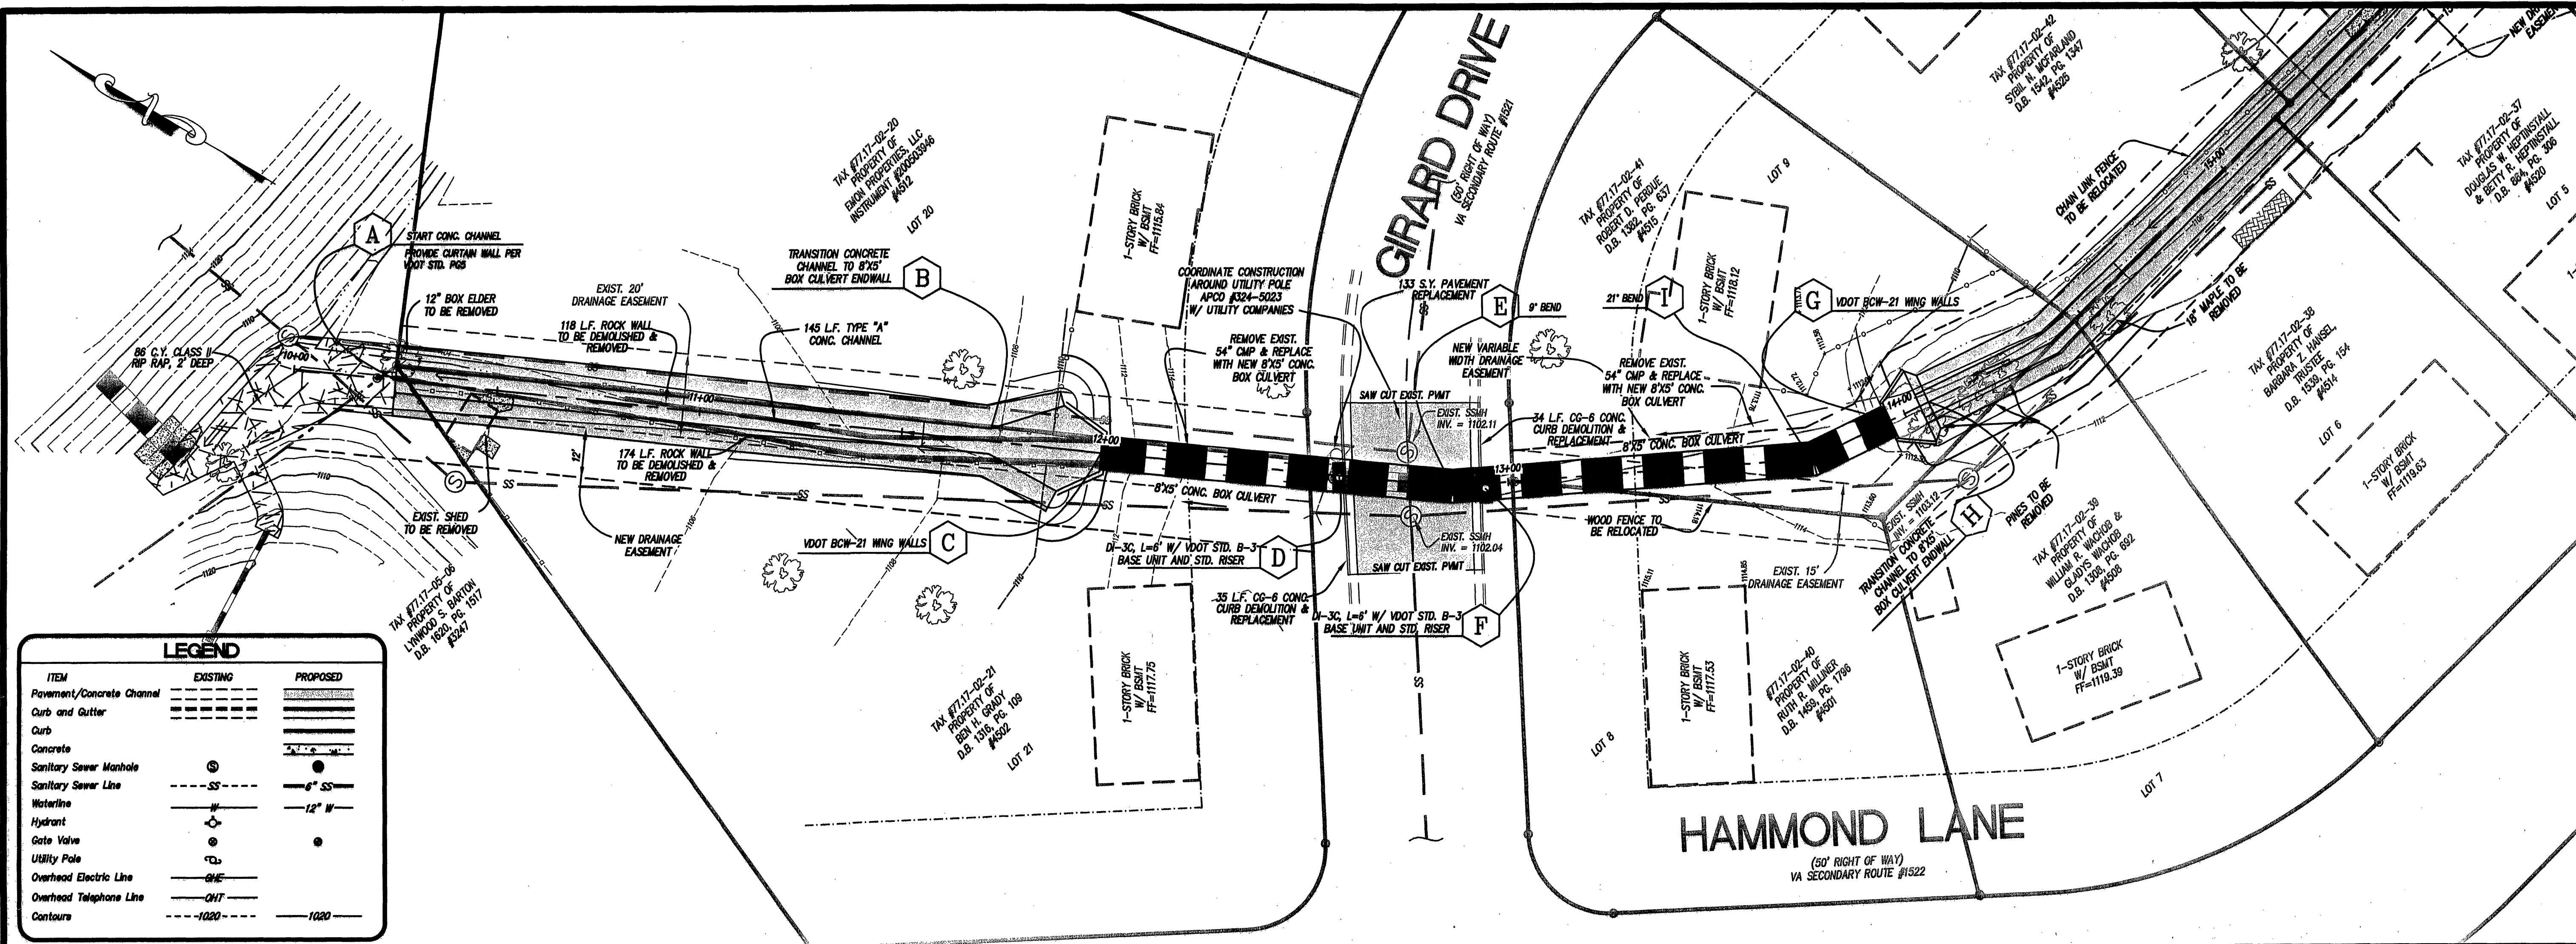

ITEM	EXISTING	PROPOSED
Pavement/Concrete Channel	---	---
Curb and Gutter	---	---
Curb	---	---
Concrete	---	---
Sanitary Sewer Manhole	⊙	⊙
Sanitary Sewer Line	SS	SS
Waterline	W	W
Hydrant	⊙	⊙
Gate Valve	⊙	⊙
Utility Pole	⊙	⊙
Overhead Electric Line	OHE	OHE
Overhead Telephone Line	OHT	OHT
Contours	1020	1020

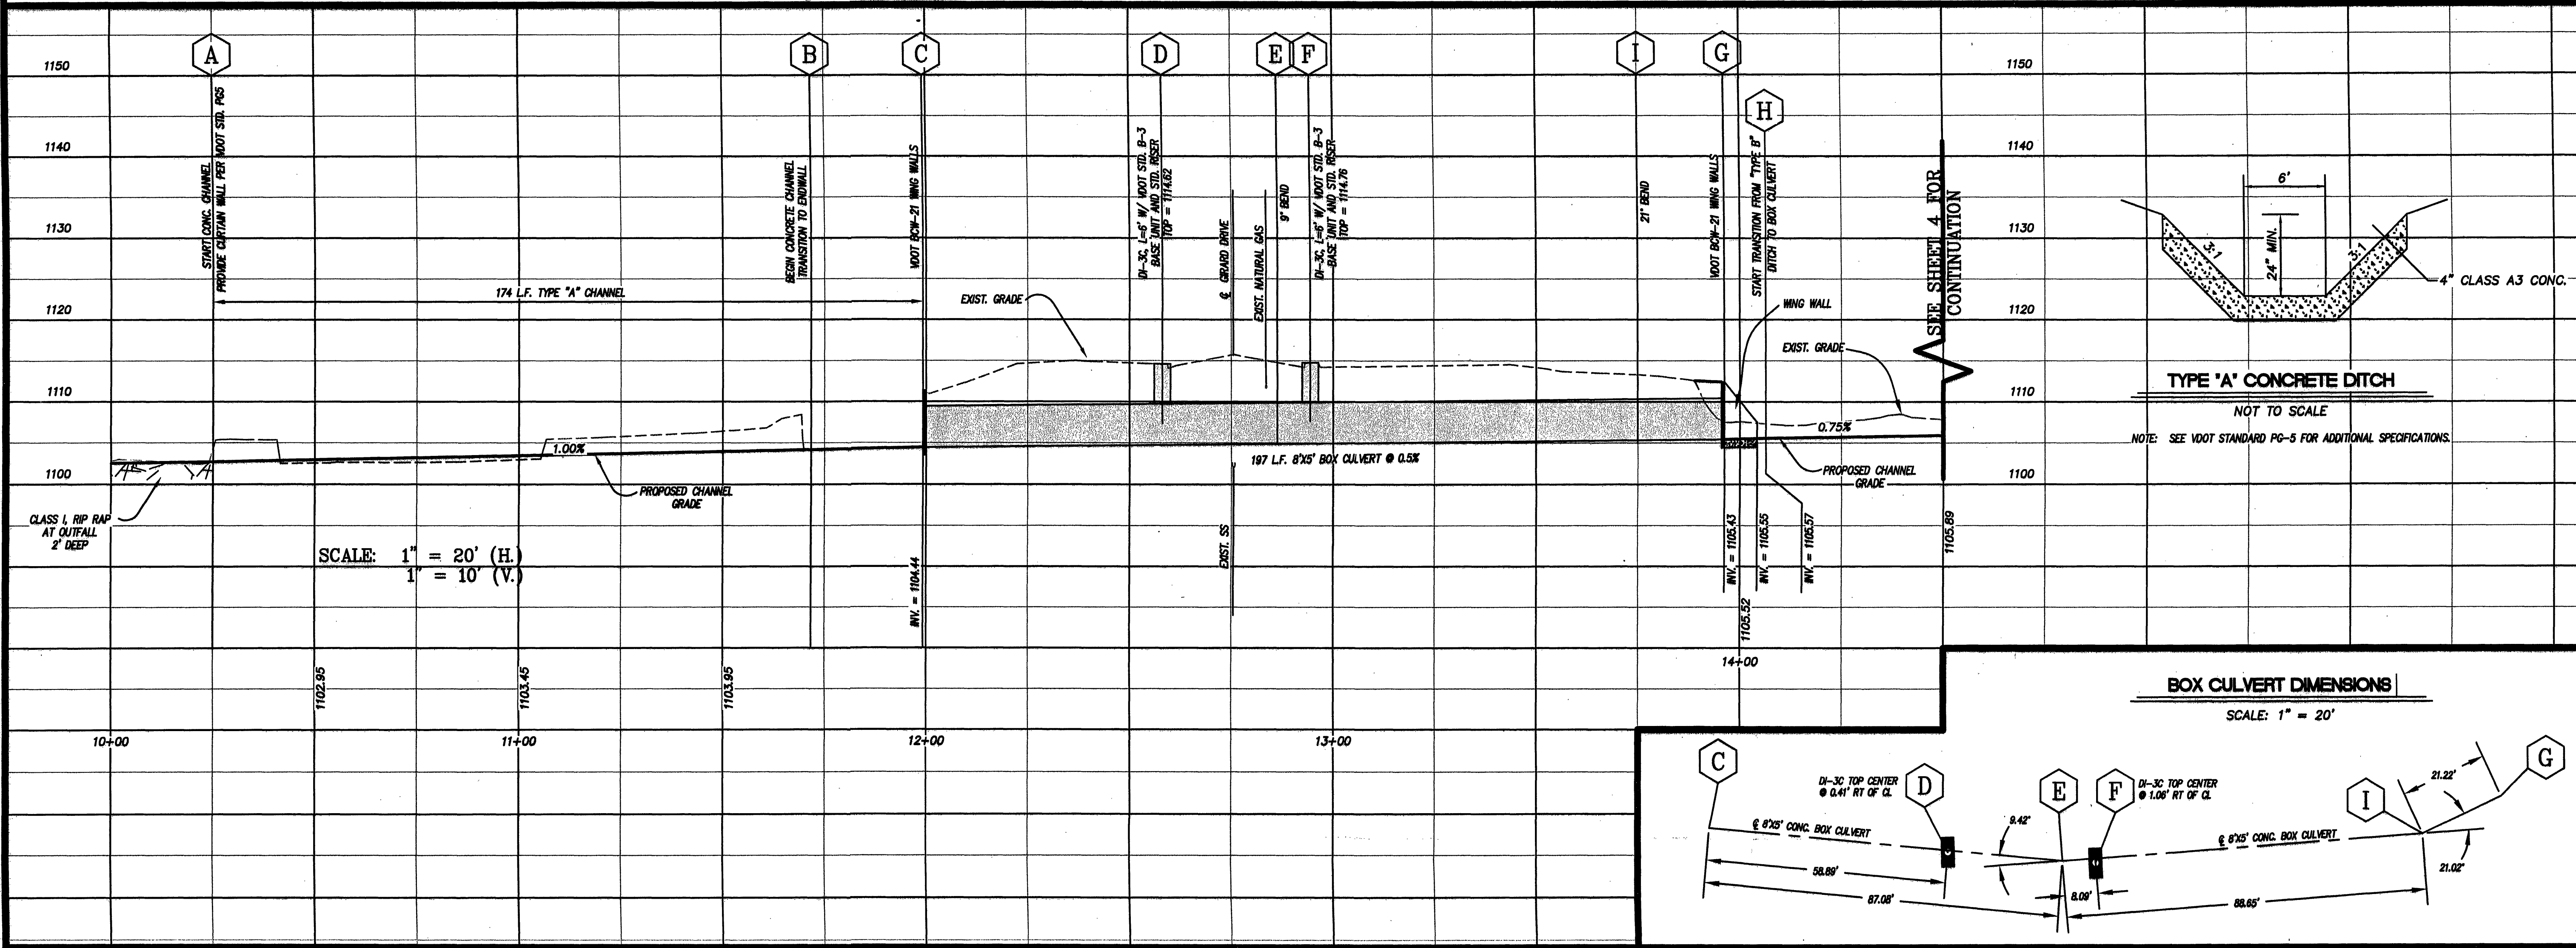

BOX CULVERT DIMENSIONS
SCALE: 1" = 20'

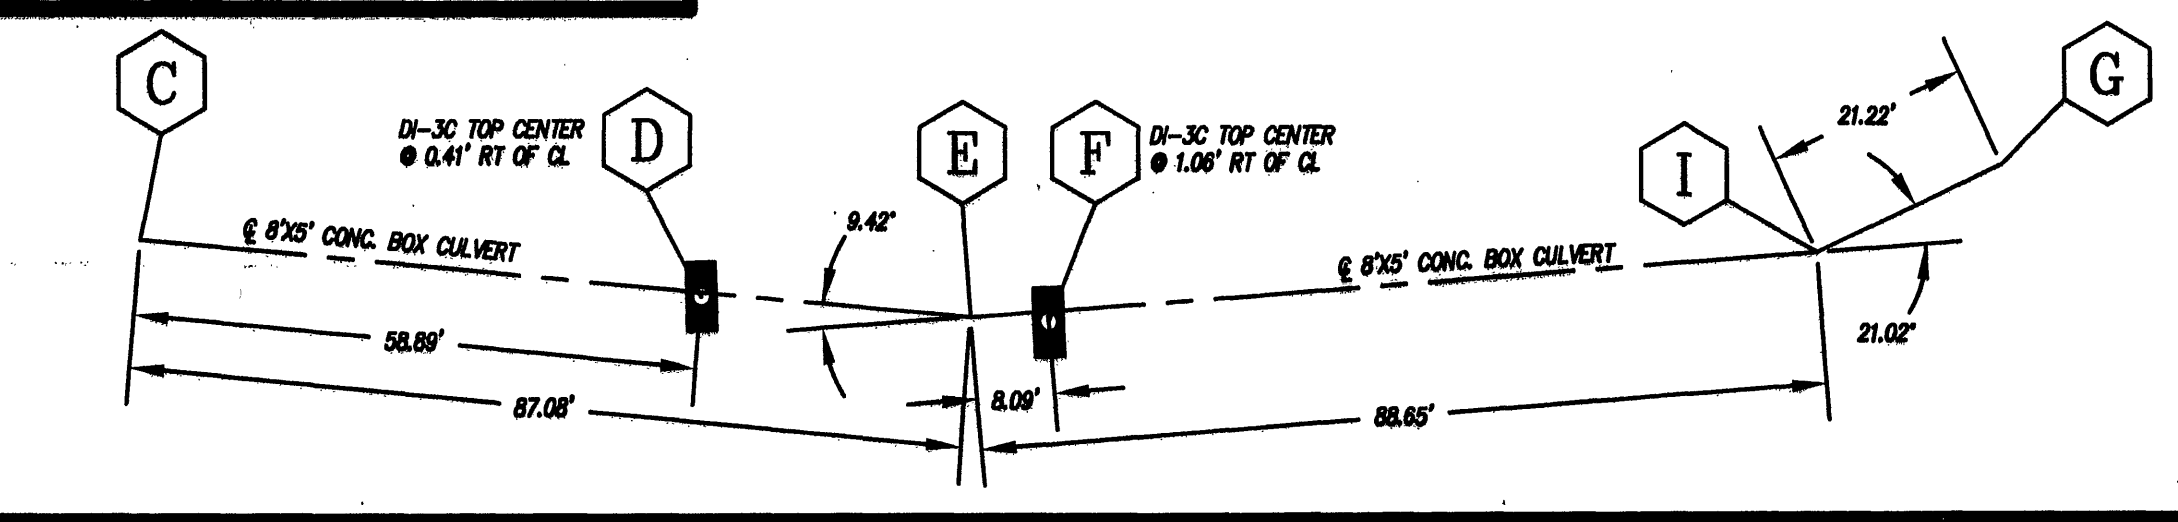

ETON HILL STORM DRAINAGE IMPROVEMENTS
PREPARED FOR
ROANOKE COUNTY ENGINEERING DEPARTMENT
CAVE SPRING MAGISTERIAL DISTRICT
ROANOKE COUNTY, VIRGINIA

STORM DRAINAGE PLAN

REVISIONS

NO.	DATE	DESCRIPTION
1	7/19/06	VARIOUS REVISIONS AS DIRECTED BY BUTCH WORKMAN
2		
3		
4		
5		

DATE: APRIL 03, 2006
SCALE: 1" = 20'
COMMISSION NO: 05-088
SHEET 3 OF 6

LUMSDEN ASSOCIATES, P.C.
ENGINEERS-SURVEYORS-PLANNERS
ROANOKE, VIRGINIA

COMMONWEALTH OF VIRGINIA
B. LEE HENDERSON JR.
Professional Engineer
Lic. No. 017591

4664 BRAMBLETON AVENUE
P.O. BOX 20669
ROANOKE, VIRGINIA 24018
PHONE (540) 774-4411
FAX (540) 772-9445
E-MAIL: MAIL@LUMSDENPC.COM