
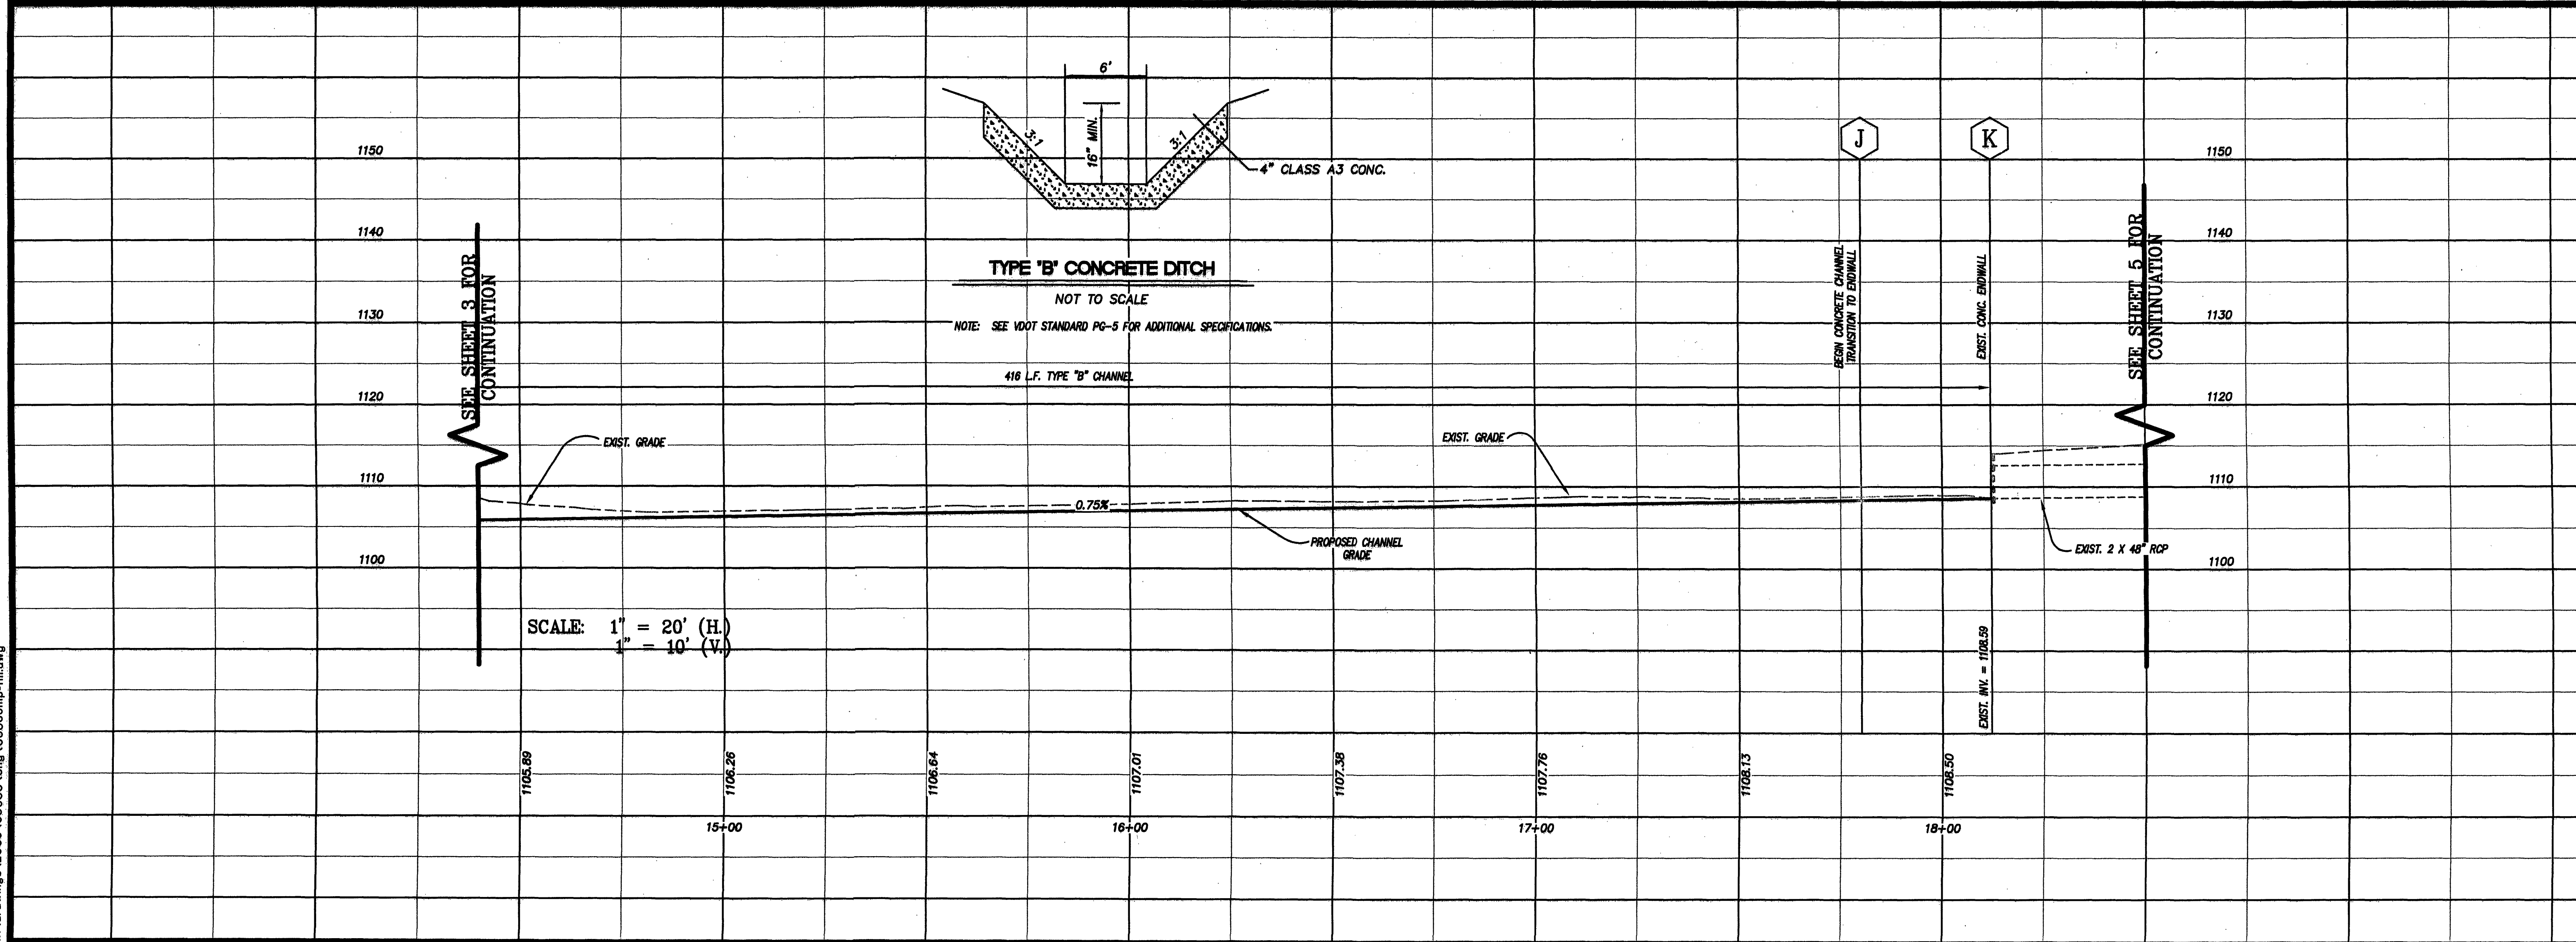


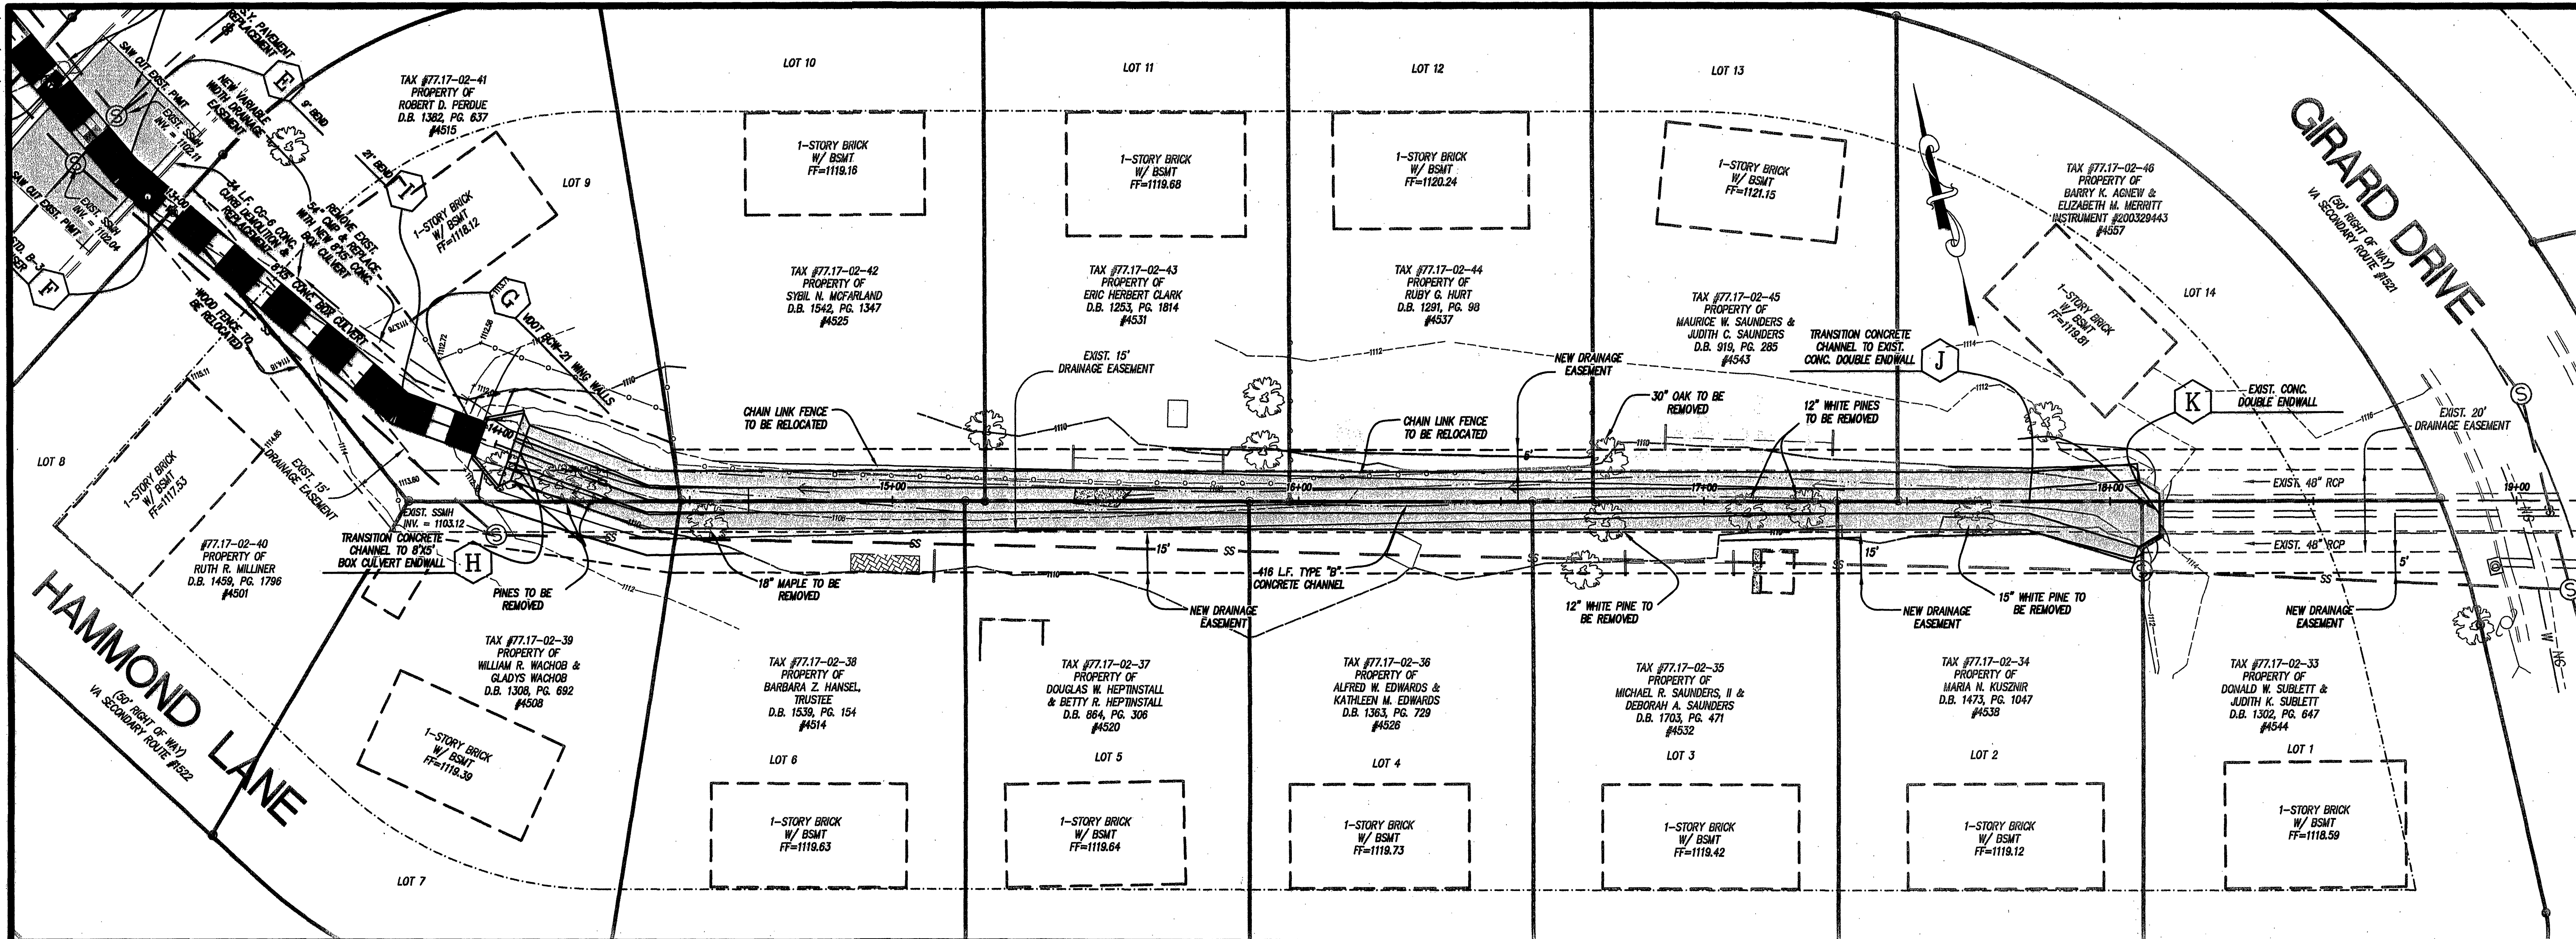

SCALE: 1" = 20' (H.)
1" = 10' (V.)

TYPE 'B' CONCRETE DITCH

NOT TO SCALE


NOTE: SEE VDOT STANDARD PG-5 FOR ADDITIONAL SPECIFICATIONS.

416 L.F. TYPE 'B' CHANNEL

LUMSDEN ASSOCIATES, P.C.
ENGINEERS-SURVEYORS-PLANNERS
ROANOKE, VIRGINIA

4664 BRAMBLETON AVENUE
P.O. BOX 20669
ROANOKE, VIRGINIA 24018

PHONE: (540) 774-4411
FAX: (540) 772-9445
E-MAIL: MAIL@LUMSDENPC.COM

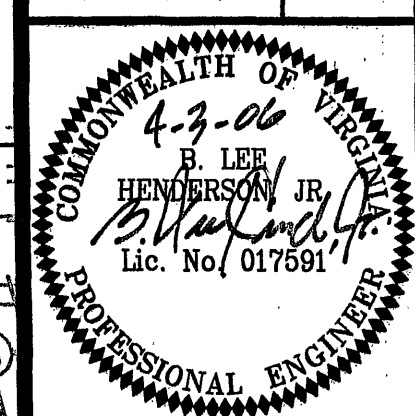

STORM DRAINAGE PLAN

ETON HILL STORM DRAINAGE IMPROVEMENTS
PREPARED FOR
ROANOKE COUNTY ENGINEERING DEPARTMENT
CAVE SPRING MAGISTERIAL DISTRICT
ROANOKE COUNTY, VIRGINIA

NO.	DATE	REVISIONS DESCRIPTION
1		
2		
3		
4		
5		

DATE: APRIL 03, 2006
SCALE: 1" = 20'
COMMISSION NO.: 05-088
SHEET 4 OF 6