


088comp-fm-pn03.plt
w:\drawings\2005\05088\eng\088comp-fm.dwg

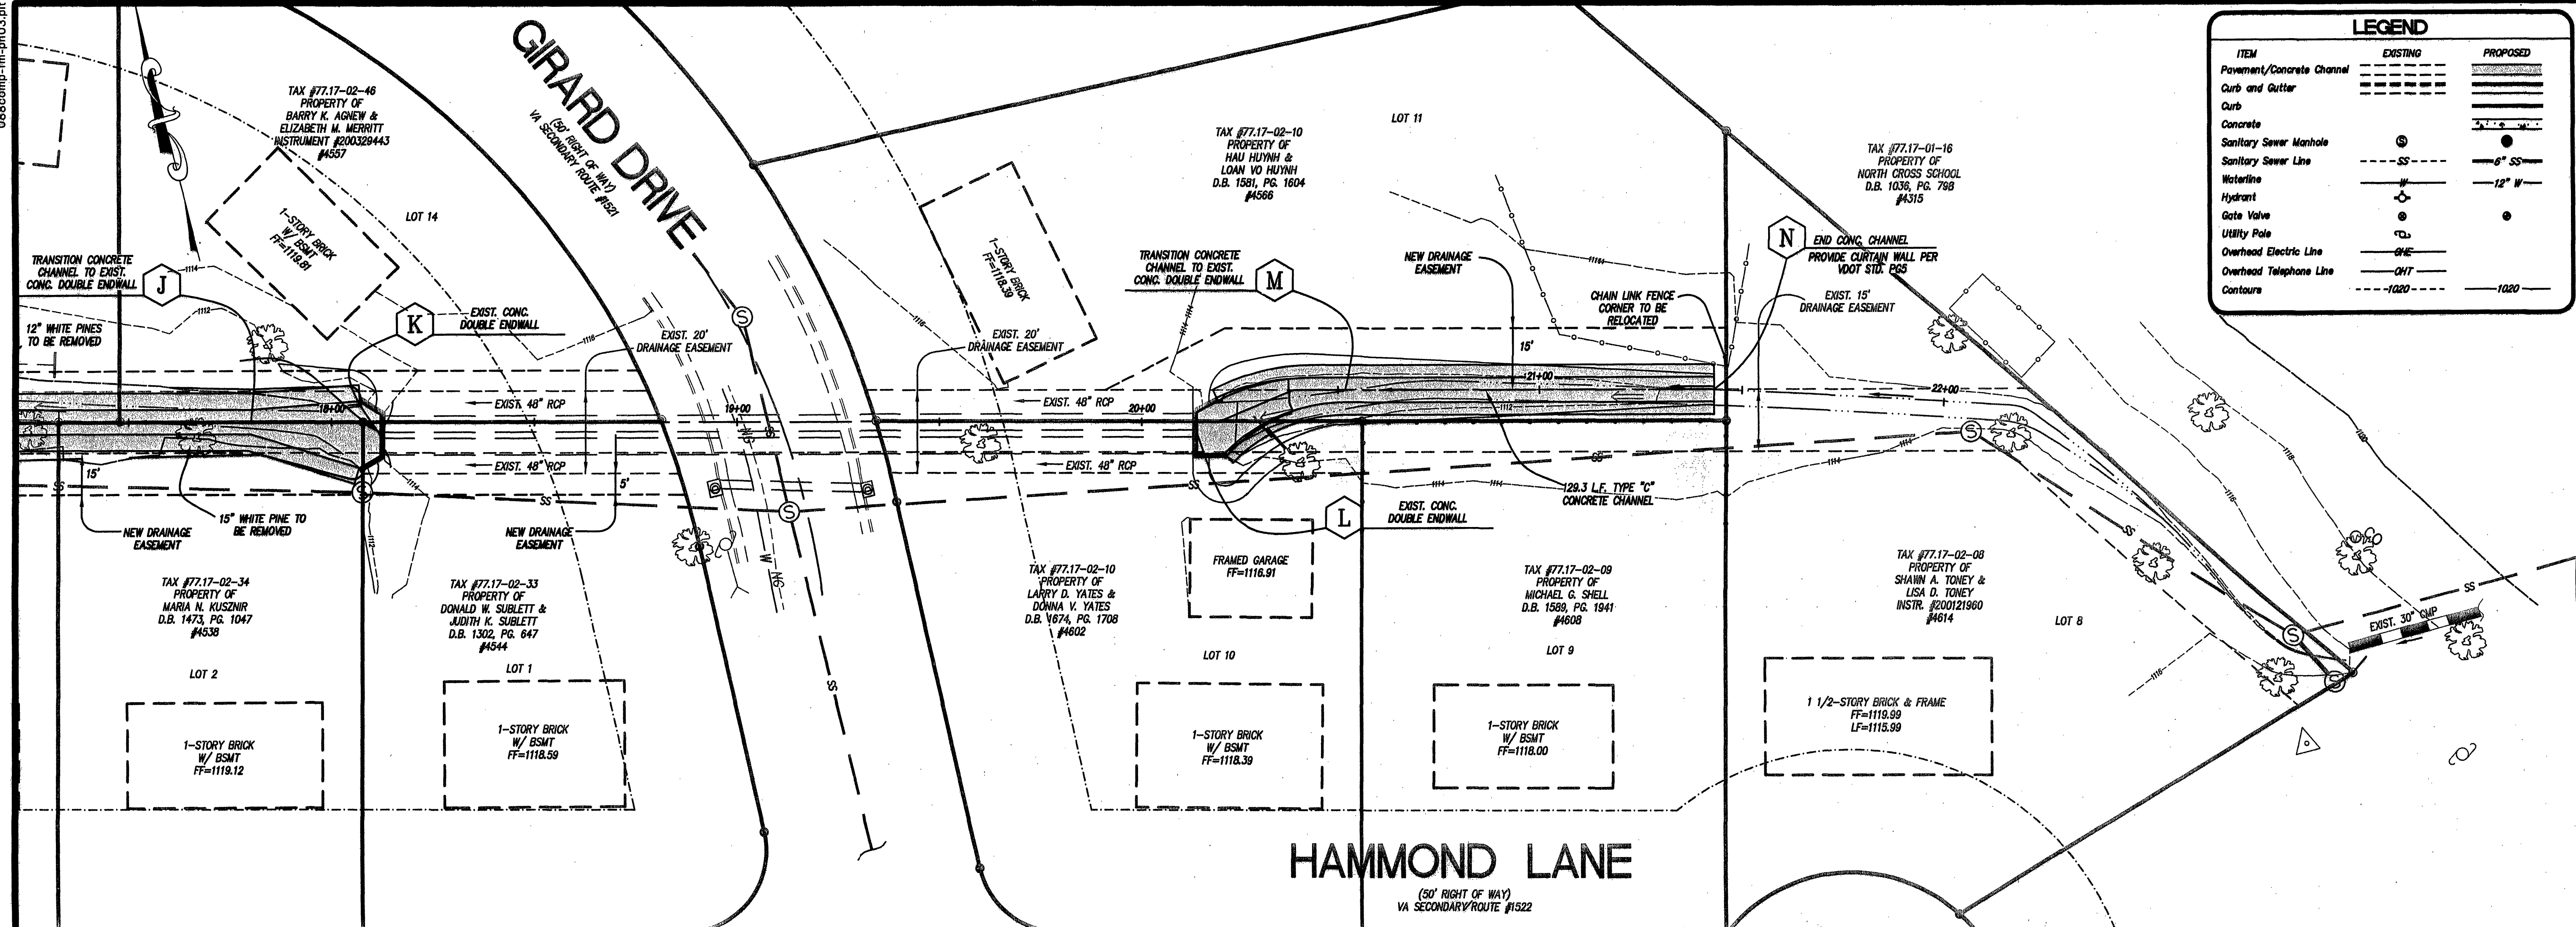


LEGEND		
ITEM	EXISTING	PROPOSED
Pavement/Concrete Channel		
Curb and Gutter		
Concrete		
Sanitary Sewer Manhole		
Sanitary Sewer Line		
Waterline		
Hydrant		
Gate Valve		
Utility Pole		
Overhead Electric Line		
Overhead Telephone Line		
Contours		


LUMSDEN ASSOCIATES, P.C.
ENGINEERS-SURVEYORS-PLANNERS
ROANOKE, VIRGINIA

4664 BRAMBLETON AVENUE
P.O. BOX 20669
ROANOKE, VIRGINIA 24018

PHONE: (540) 774-4411
FAX: (540) 772-9445
E-MAIL: MAIL@LUMSDENPC.COM

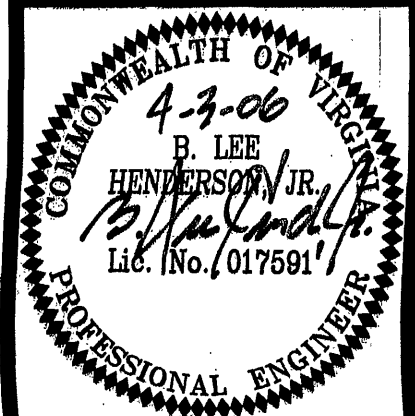

STORM DRAINAGE PLAN

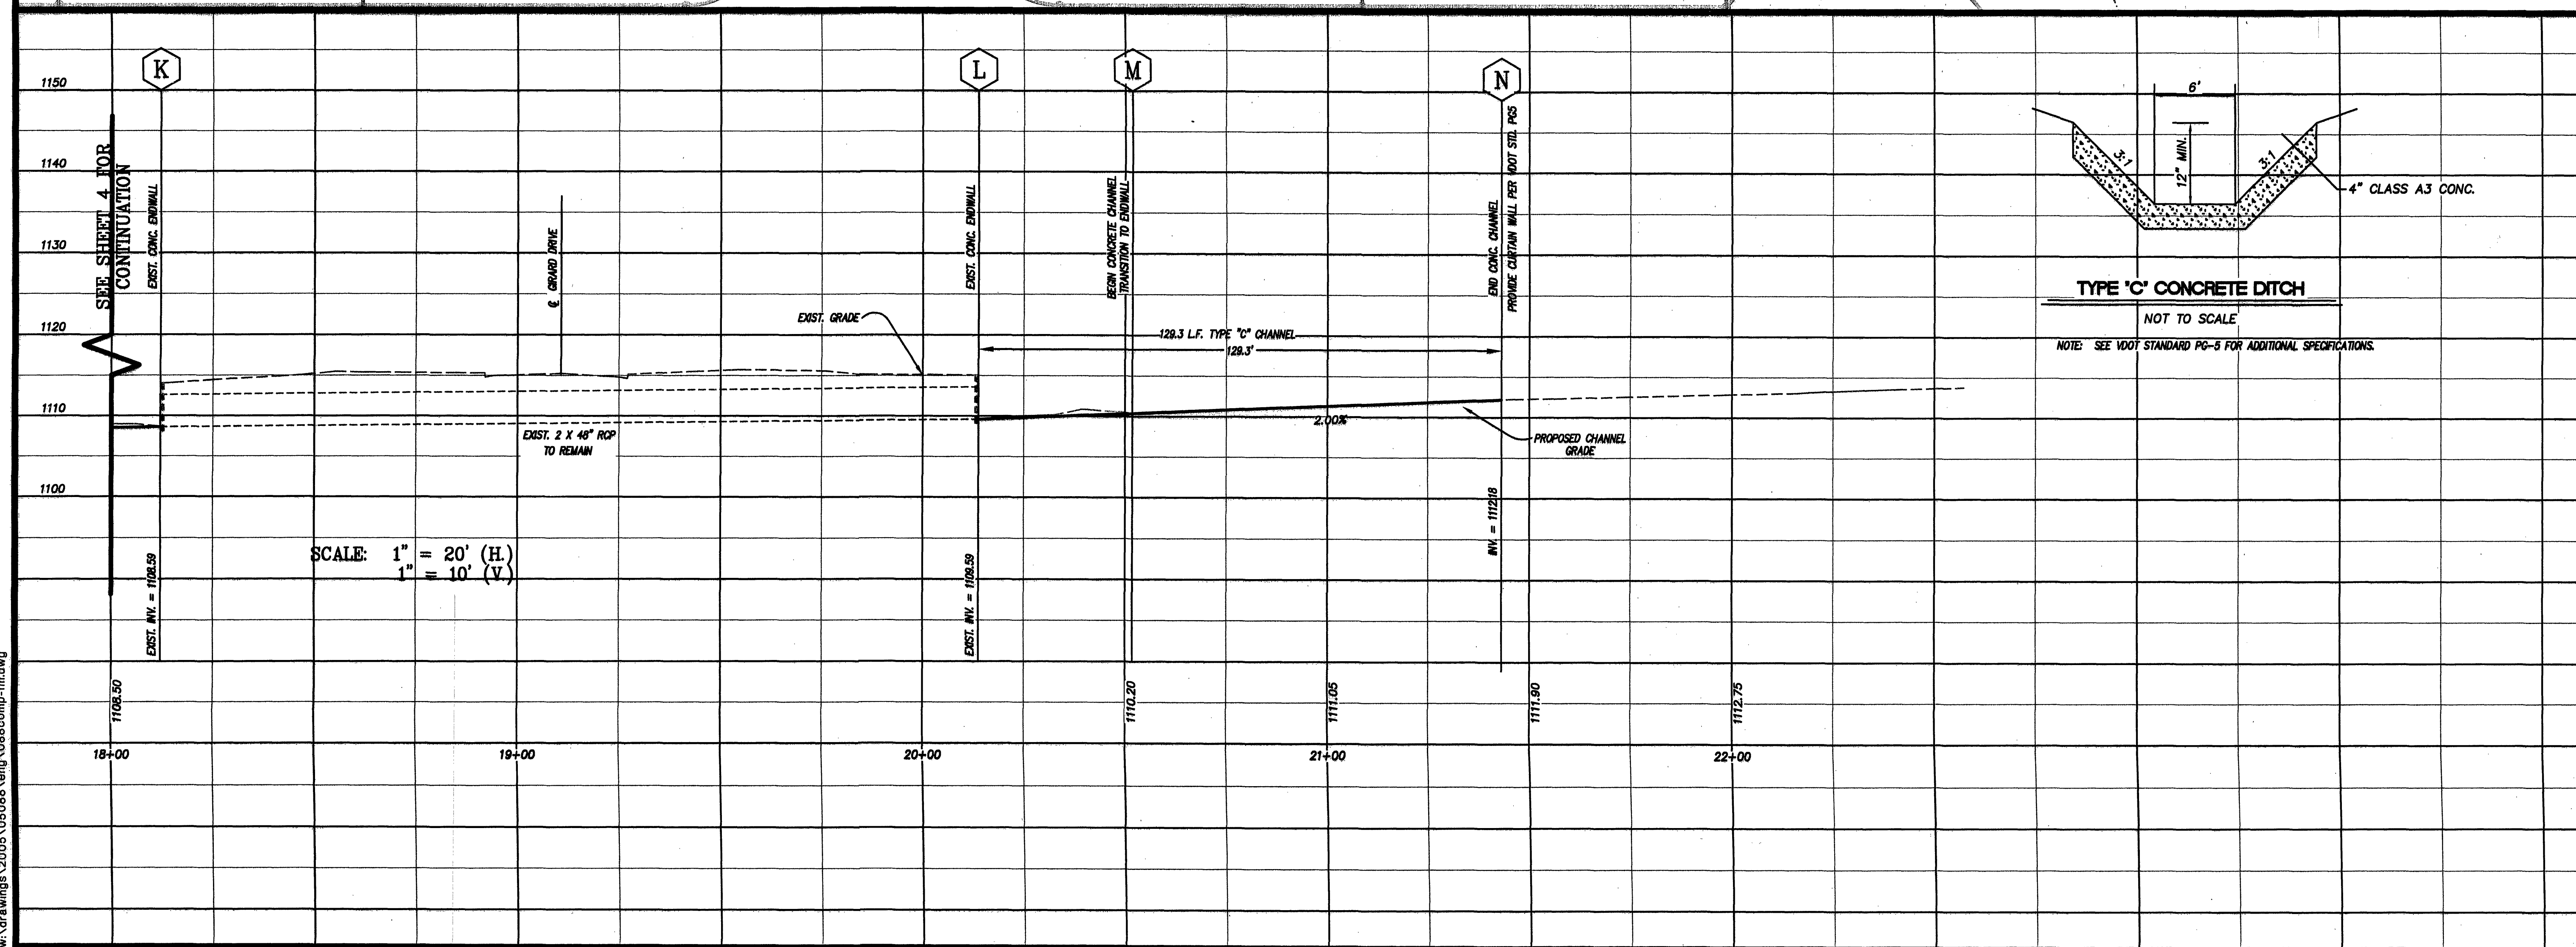

ETON HILL STORM DRAINAGE IMPROVEMENTS
PREPARED FOR
ROANOKE COUNTY
ENGINEERING DEPARTMENT
CAVE SPRING MAGISTERIAL DISTRICT
ROANOKE COUNTY, VIRGINIA

NO.	DATE	DESCRIPTION
1		
2		
3		
4		
5		

DATE: APRIL 03, 2006
SCALE: 1" = 20'
COMMISSION NO: 05-088
SHEET 5 OF 6