


BENCHMARK:
ARROWHEAD ON TOP OF FIRE HYDRANT,
LOCATED IN GRASS, NEAR NORTHWEST
CORNER OF BRUGH TAVERN PARKING LOT.
ELEVATION=1032.77

AVAILABLE RECORDS INDICATE THE PRESENCE OF AN ORIGINAL 4" WELL
SUPPLY WATERLINE CROSSING THE ACCESS ROAD IN THIS AREA, AND
THE 8" SUPPLY LINE FROM THE STORAGE TANK CONTINUING ON THE
SOUTH SIDE OF THE ACCESS ROAD. THE WATERLINE LOCATIONS SHOWN
ON THESE PLANS ARE APPROXIMATE, AND SHALL BE VERIFIED BY THE
CONTRACTOR PRIOR TO ANY CONSTRUCTION.

THE CONTRACTOR IS REQUIRED TO PERFORM EXPLORATORY EXCAVATION
TO DETERMINE THE LOCATIONS OF THE EXISTING WATERLINES, AND TO DETERMINE
ANY CONFLICTS THAT WILL ARISE FROM INSTALLATION OF NEW ITEMS
REQUIRED BY THESE PLANS, AND IS REQUIRED TO NOTIFY THE ENGINEER
OF ANY POTENTIAL CONFLICTS PRIOR TO INSTALLATION OF ANY NEW ITEMS.

MATCH LINE - SEE SHEET C-8 FOR CONTINUATION

PROVIDE "ENKAMAT" TYPE 7010 EROSION CONTROL
FABRIC IN DITCH LINES. FABRIC SHALL BE INSTALLED
IN ACCORDANCE WITH VDOT STD EC-3, AND TO A FLOW
DEPTH OF 12" MINIMUM.

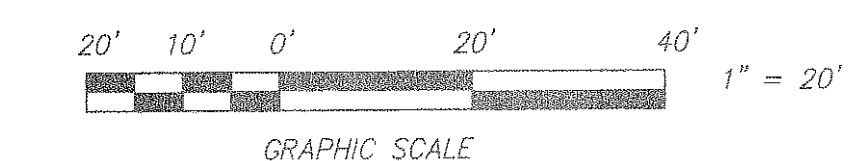

	GRADING, STORM DRAIN, AND SITE UTILITIES PLAN FOR BLUE RIDGE PARKWAY INTERPRETIVE CENTER
	FOR VIRGINIA'S EXPLORE PARK SITUATE OFF OF RUTROUGH ROAD AND THE BLUE RIDGE PARKWAY VINTON MAGISTERIAL DISTRICT COUNTY OF ROANOKE, VIRGINIA
Designed: C.L. White Drawn: C.L. White Checked: Date: October 12, 1999 Scale: 1" = 20' Tax Parcel: 80.00-05-24 Field Book: WES-1 W.D. No.: 99-0040	 CALDWELL WHITE ASSOCIATES ENGINEERS / SURVEYORS / PLANNERS 1054 OLD COUNTRY CLUB ROAD P.O. BOX 6940 ROANOKE, VIRGINIA 24017 (540) 342-7094 FAX: (540) 981-0888

* STREE NAMES ADDED TO MAP 11/27/2018