

WESTERN VIRGINIA WATER AUTHORITY
FY2011 VCWRLF COLLECTION SYSTEM PROJECTS
CONTRACT 3: LARGE REPLACEMENT PROJECTS
LOWER MURRAY RUN SEWER REPLACEMENT

"As-built Drawings", 7/29/14
Submitted by: Prillaman & Pace, Inc.

LOAN IDENTIFICATION NO. C-515471
* * *
ROANOKE, VIRGINIA


CONTACT SUMMARY

OWNER: WESTERN VIRGINIA WATER AUTHORITY
ADDRESS: 601 S. JEFFERSON ST.
SUITE 300
ROANOKE, VA 24011

CONTACT: EARL SMITH P.E.
TELEPHONE NO: 540-853-5700
FAX NO: 540-853-1017

ENGINEER: DRAPER ADEN ASSOCIATES
2206 SOUTH MAIN STREET
BLACKSBURG, VIRGINIA 24060

CHA CONSULTING
1901 INNOVATION DRIVE, SUITE 2100
BLACKSBURG, VA 24060

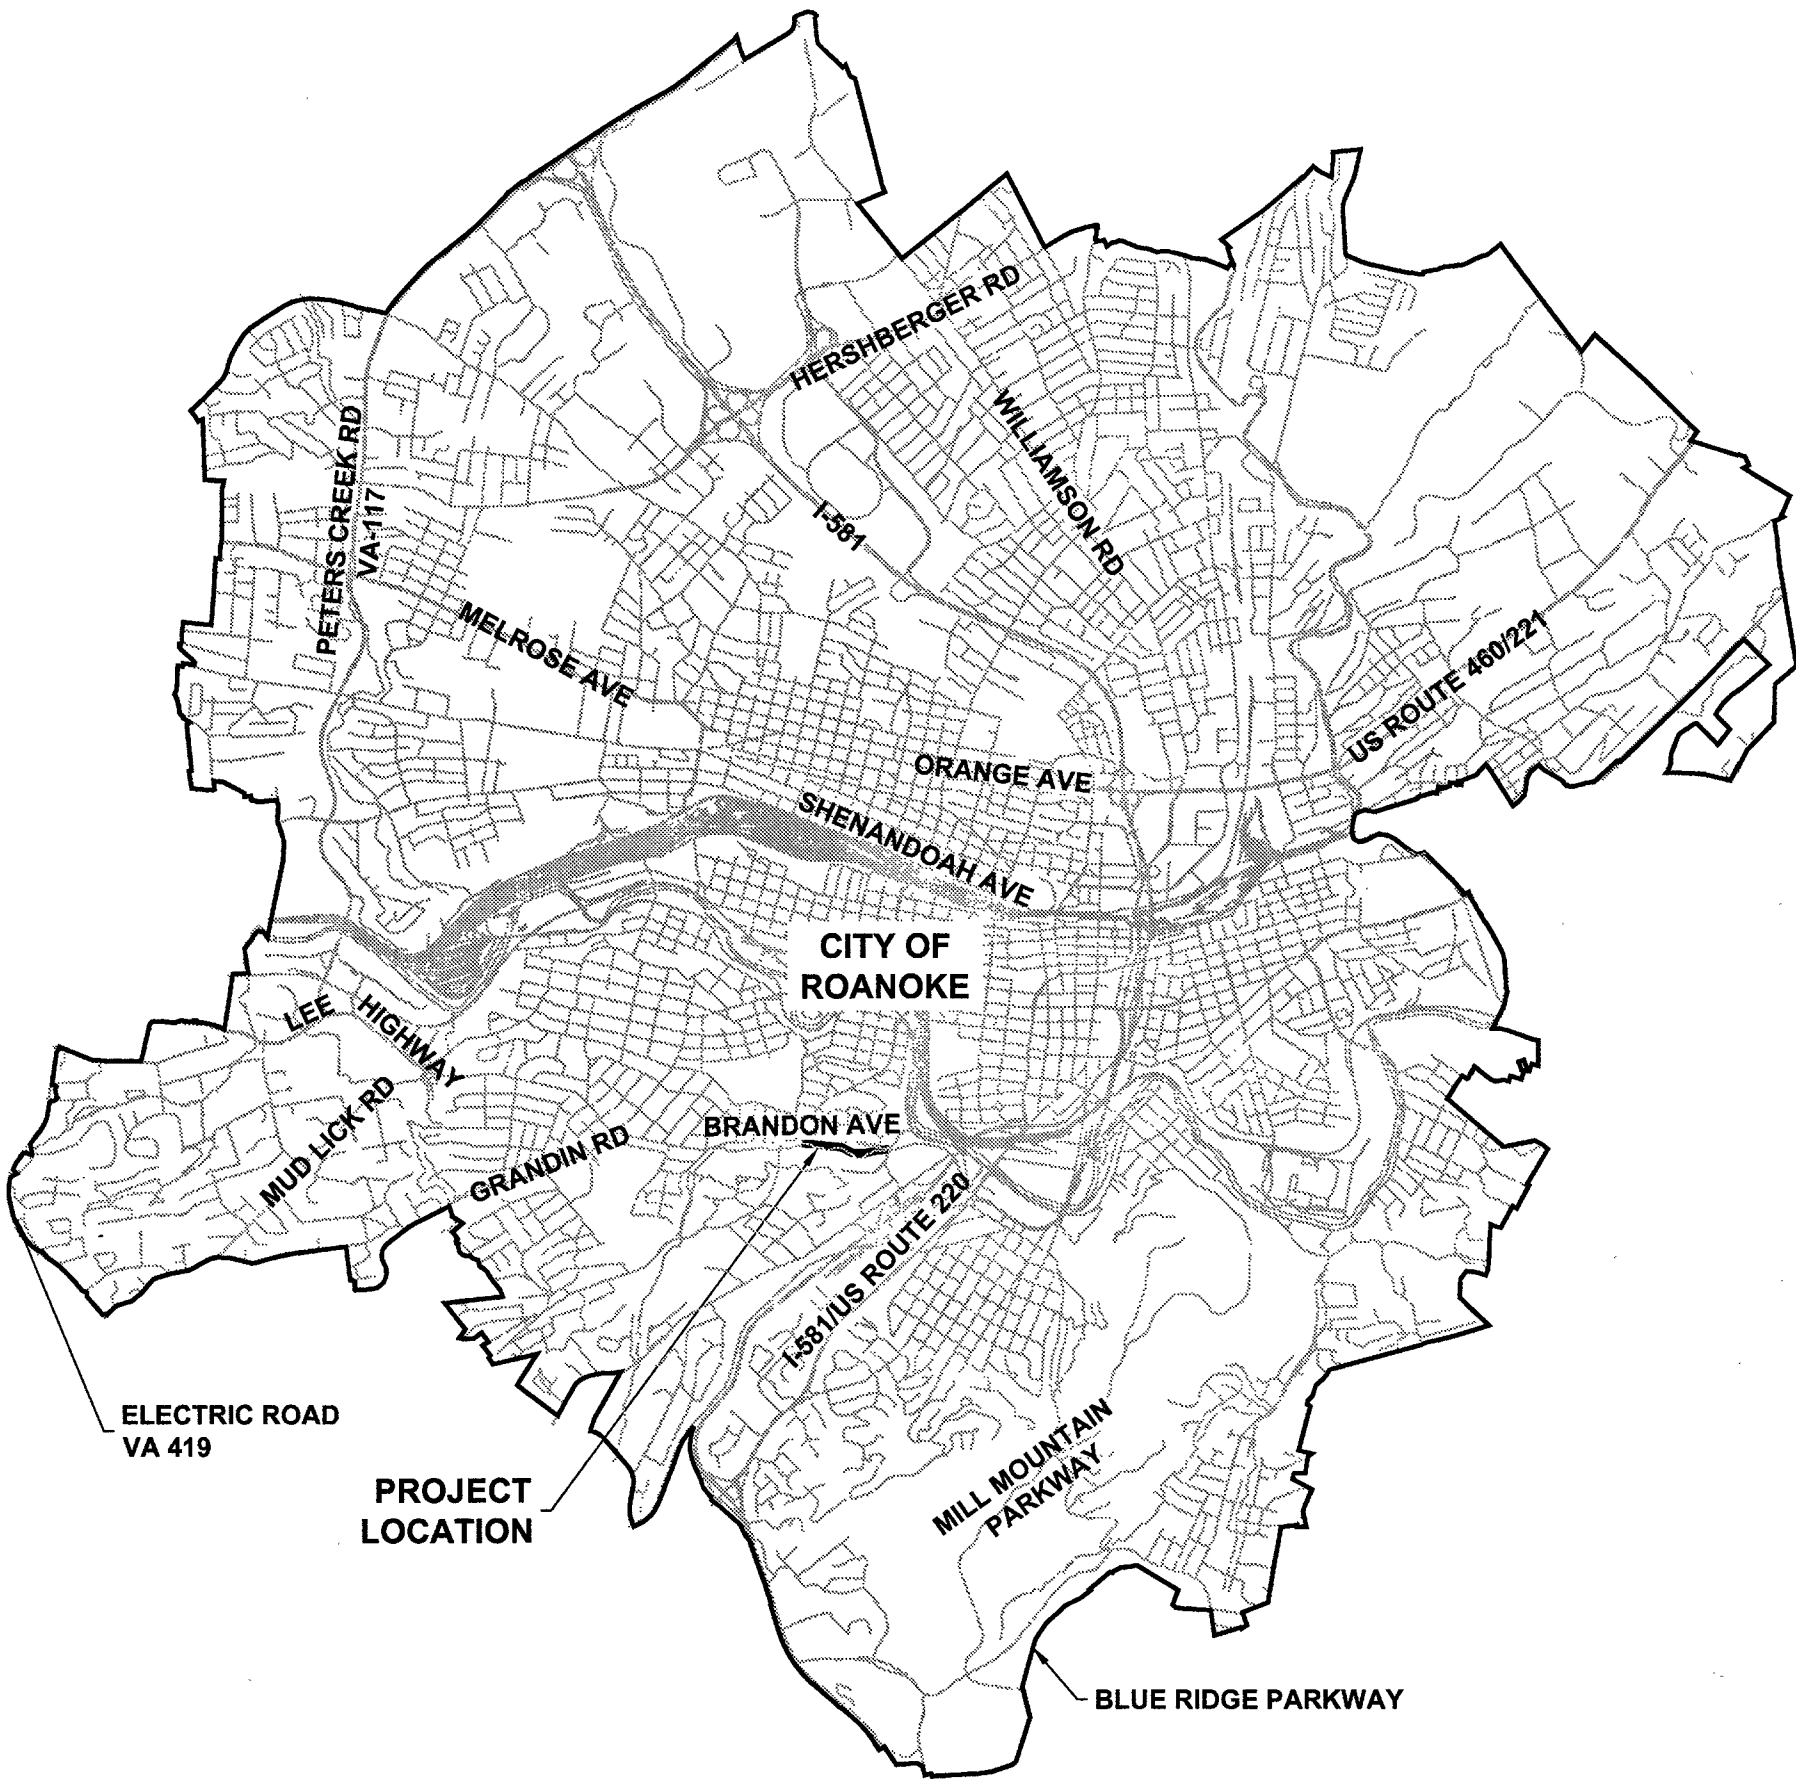

Drawing List

No.	Description
T-301	COVER SHEET
T-302	SEWER SHEET INDEX
C-301	SEWER PLAN AND PROFILE
C-302	SEWER PLAN AND PROFILE
C-303	LATERAL COLLECTOR PROFILES
ES-301	EROSION AND SEDIMENT CONTROL NARRATIVE AND DETAILS
(SEE SPECIFICATIONS FOR TRAFFIC CONTROL PLANS.)	

PROJECT DESCRIPTION


THIS PROJECT CONSISTS OF REPLACING APPROXIMATELY 1,350 LF OF 12", 15" & 18" SEWER WITH NEW 24" PVC AND 7 MANHOLES, ABANDONING APPROXIMATELY 715' OF 18" SEWER AND 4 MANHOLES, THE CONSTRUCTION OF A NEW SERVICE LATERAL COLLECTOR LINE CONSISTING OF 470 LF OF 8" PVC AND 3 NEW MANHOLES AND THE RECONNECTION OF 15 SEWER SERVICE LATERALS.

April 14, 2013
* * * * *
B11132B-04A



NOTE: CONTRACTOR TO CONTACT MISS UTILITY (811) IN ADVANCE OF PLANNED WORK. ADVANCE TIME PERIOD SHALL BE IN ACCORDANCE WITH CURRENT MISS UTILITY GUIDELINES (www.missutilityofvirginia.com).

These documents, including drawings and specifications, were prepared by Draper Aden Associates and CHA Consulting, Consulting Engineers, pursuant to a contract by and between Draper Aden Associates and CHA Consulting and Western Virginia Water Authority with respect to the project described in said contract. Any reuse or modification of said documents (whether hard copy or electronic) without written verification or adaptation by Draper Aden Associates and CHA Consulting for the specific purpose intended will be at the sole risk of the individual or entity utilizing said documents, drawings and specifications and such use is without the authorization of Draper Aden Associates and CHA Consulting. Draper Aden Associates and CHA Consulting, Consulting Engineers, shall have no legal liability resulting from any and all claims, damages, losses, and expenses, including attorney's fees arising out of the unauthorized use of these documents, drawings, specifications, reports, and studies prepared as a result of the aforesaid contract.

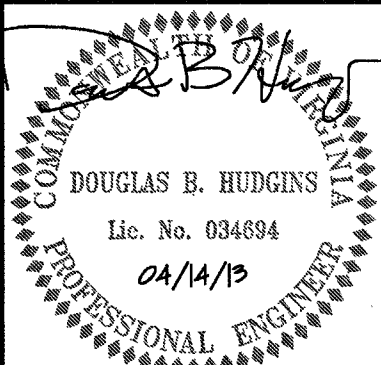

Draper Aden Associates
Engineering • Surveying • Environmental Services
2206 South Main Street
Blacksburg, VA 24060
540-552-0444 Fax: 540-552-0291



COVER SHEET
WESTERN VIRGINIA WATER AUTHORITY FY2011
VCWRLF COLLECTION SYSTEM PROJECTS
LOWER MURRAY RUN SEWER REPLACEMENT
ROANOKE, VIRGINIA

REVISIONS

DESIGNED BY: BSR
DRAWN BY: BSR
CHECKED BY: DBH
SCALE: AS NOTED
DATE: 04/14/13
PROJECT NUMBER: 24495-1003 (CHA)
B11132B-04X (DAA)

T-301

AS-BUILT
Inspector: Mark Sink