




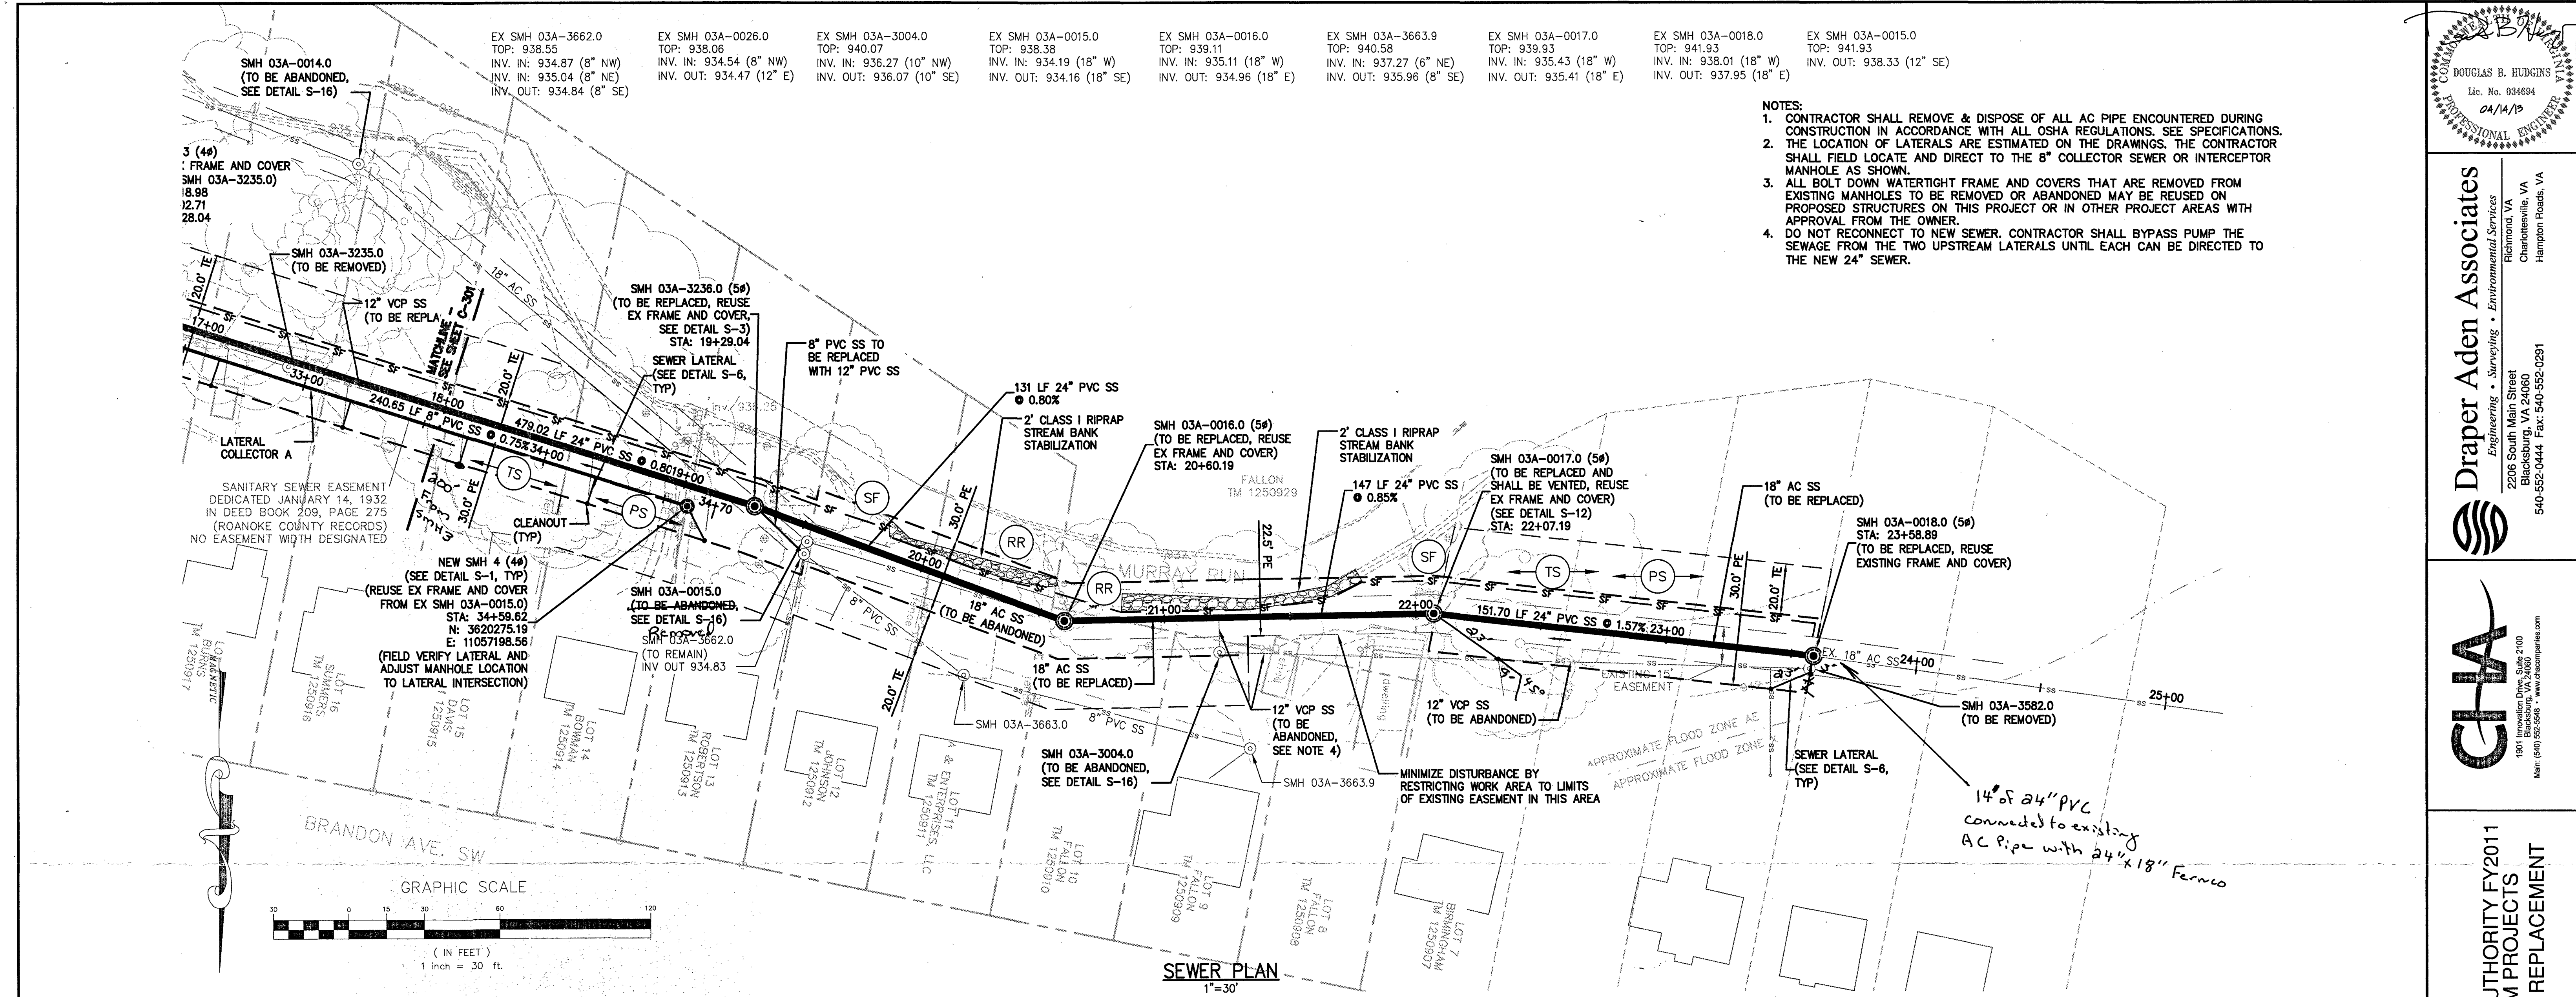

- NOTES:
1. CONTRACTOR SHALL REMOVE & DISPOSE OF ALL AC PIPE ENCOUNTERED DURING CONSTRUCTION IN ACCORDANCE WITH ALL OSHA REGULATIONS. SEE SPECIFICATIONS.
 2. THE LOCATION OF LATERALS ARE ESTIMATED ON THE DRAWINGS. THE CONTRACTOR SHALL FIELD LOCATE AND DIRECT TO THE 8" COLLECTOR SEWER OR INTERCEPTOR MANHOLE AS SHOWN.
 3. ALL BOLT DOWN WATERTIGHT FRAME AND COVERS THAT ARE REMOVED FROM EXISTING MANHOLES TO BE REMOVED OR ABANDONED MAY BE REUSED ON PROPOSED STRUCTURES ON THIS PROJECT OR IN OTHER PROJECT AREAS WITH APPROVAL FROM THE OWNER.
 4. DO NOT RECONNECT TO NEW SEWER. CONTRACTOR SHALL BYPASS PUMP THE SEWAGE FROM THE TWO UPSTREAM LATERALS UNTIL EACH CAN BE DIRECTED TO THE NEW 24" SEWER.

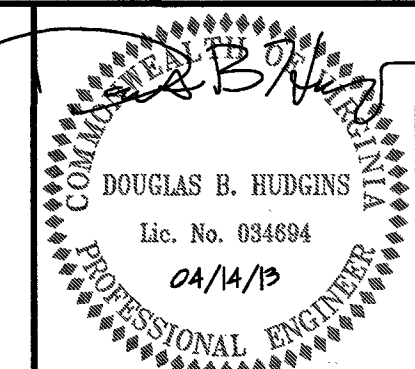


Draper Aden Associates
Engineering • Surveying • Environmental Services
2206 South Main Street
Blacksburg, VA 24060
540-552-0444 Fax: 540-552-0291

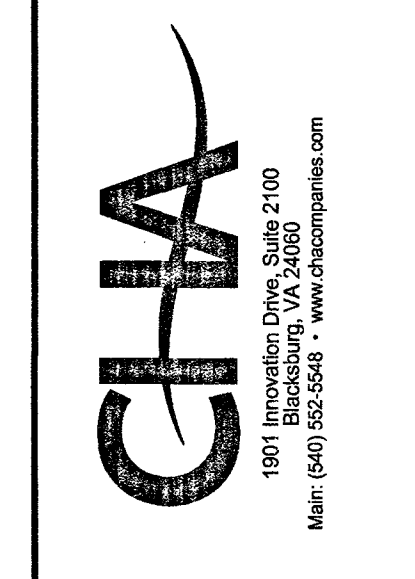

SEWER PLAN AND PROFILE
WESTERN VIRGINIA WATER AUTHORITY FY2011
VCWRLF COLLECTION SYSTEM PROJECTS
LOWER MURRAY RUN SEWER REPLACEMENT
ROANOKE, VIRGINIA

REVISIONS	
DESIGNED BY:	BSR
DRAWN BY:	BSR
CHECKED BY:	DBH
SCALE:	AS NOTED
DATE:	04/14/13
PROJECT NUMBER:	24495.1003 (CHA) B11132B-04X (DAA)
C-302	

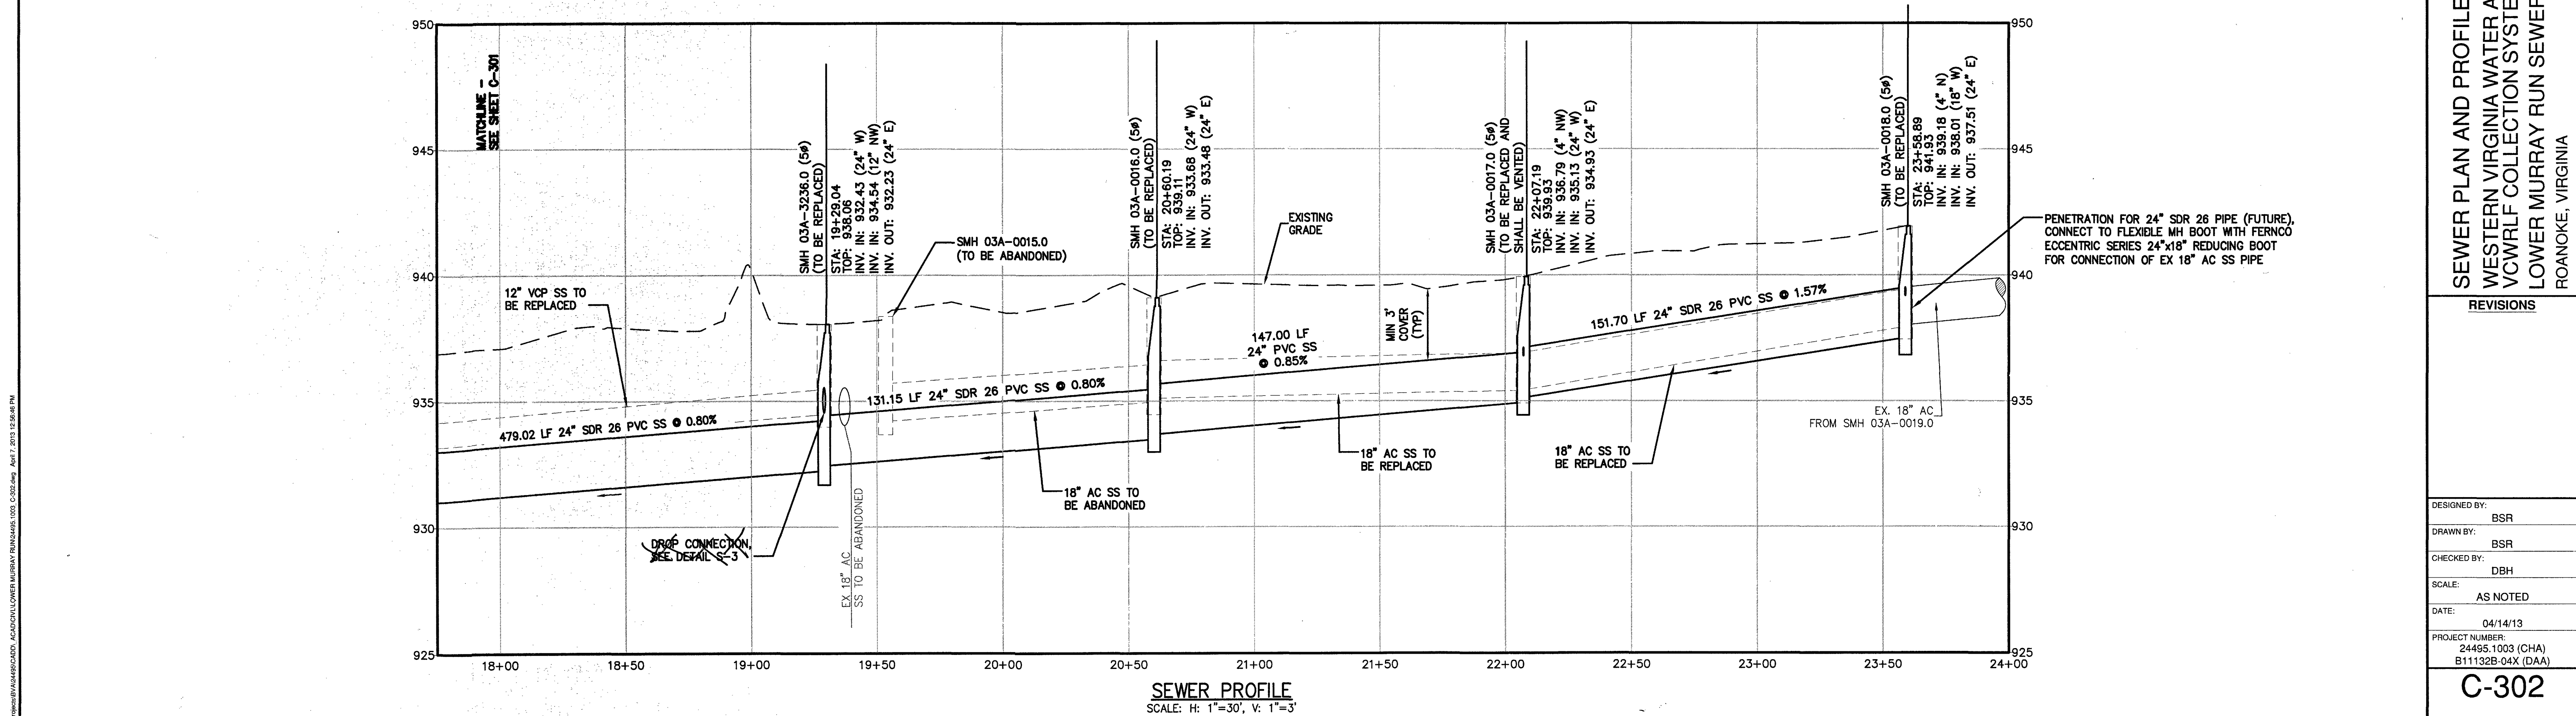

V:\Projects\2011\VCWRLF\Lower Murray Run\Drawings\002 C-302.dwg April 17, 2013 12:58:40 PM