


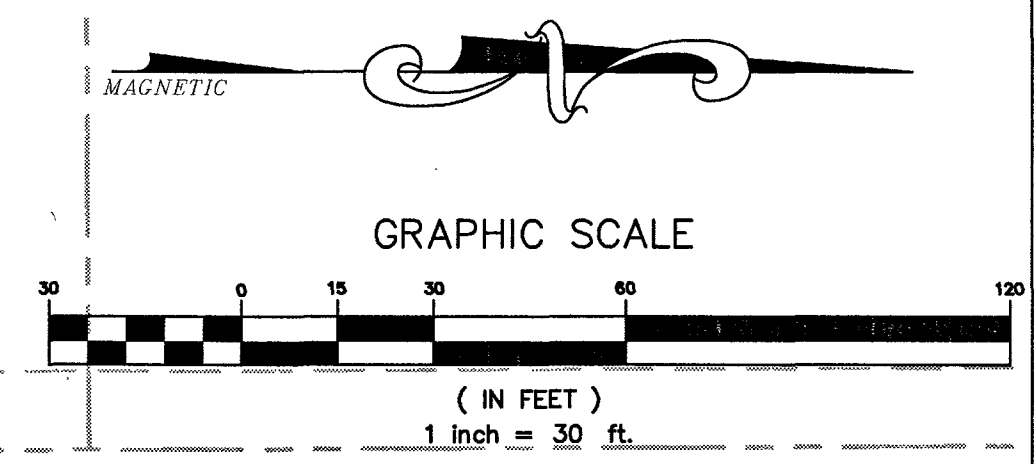


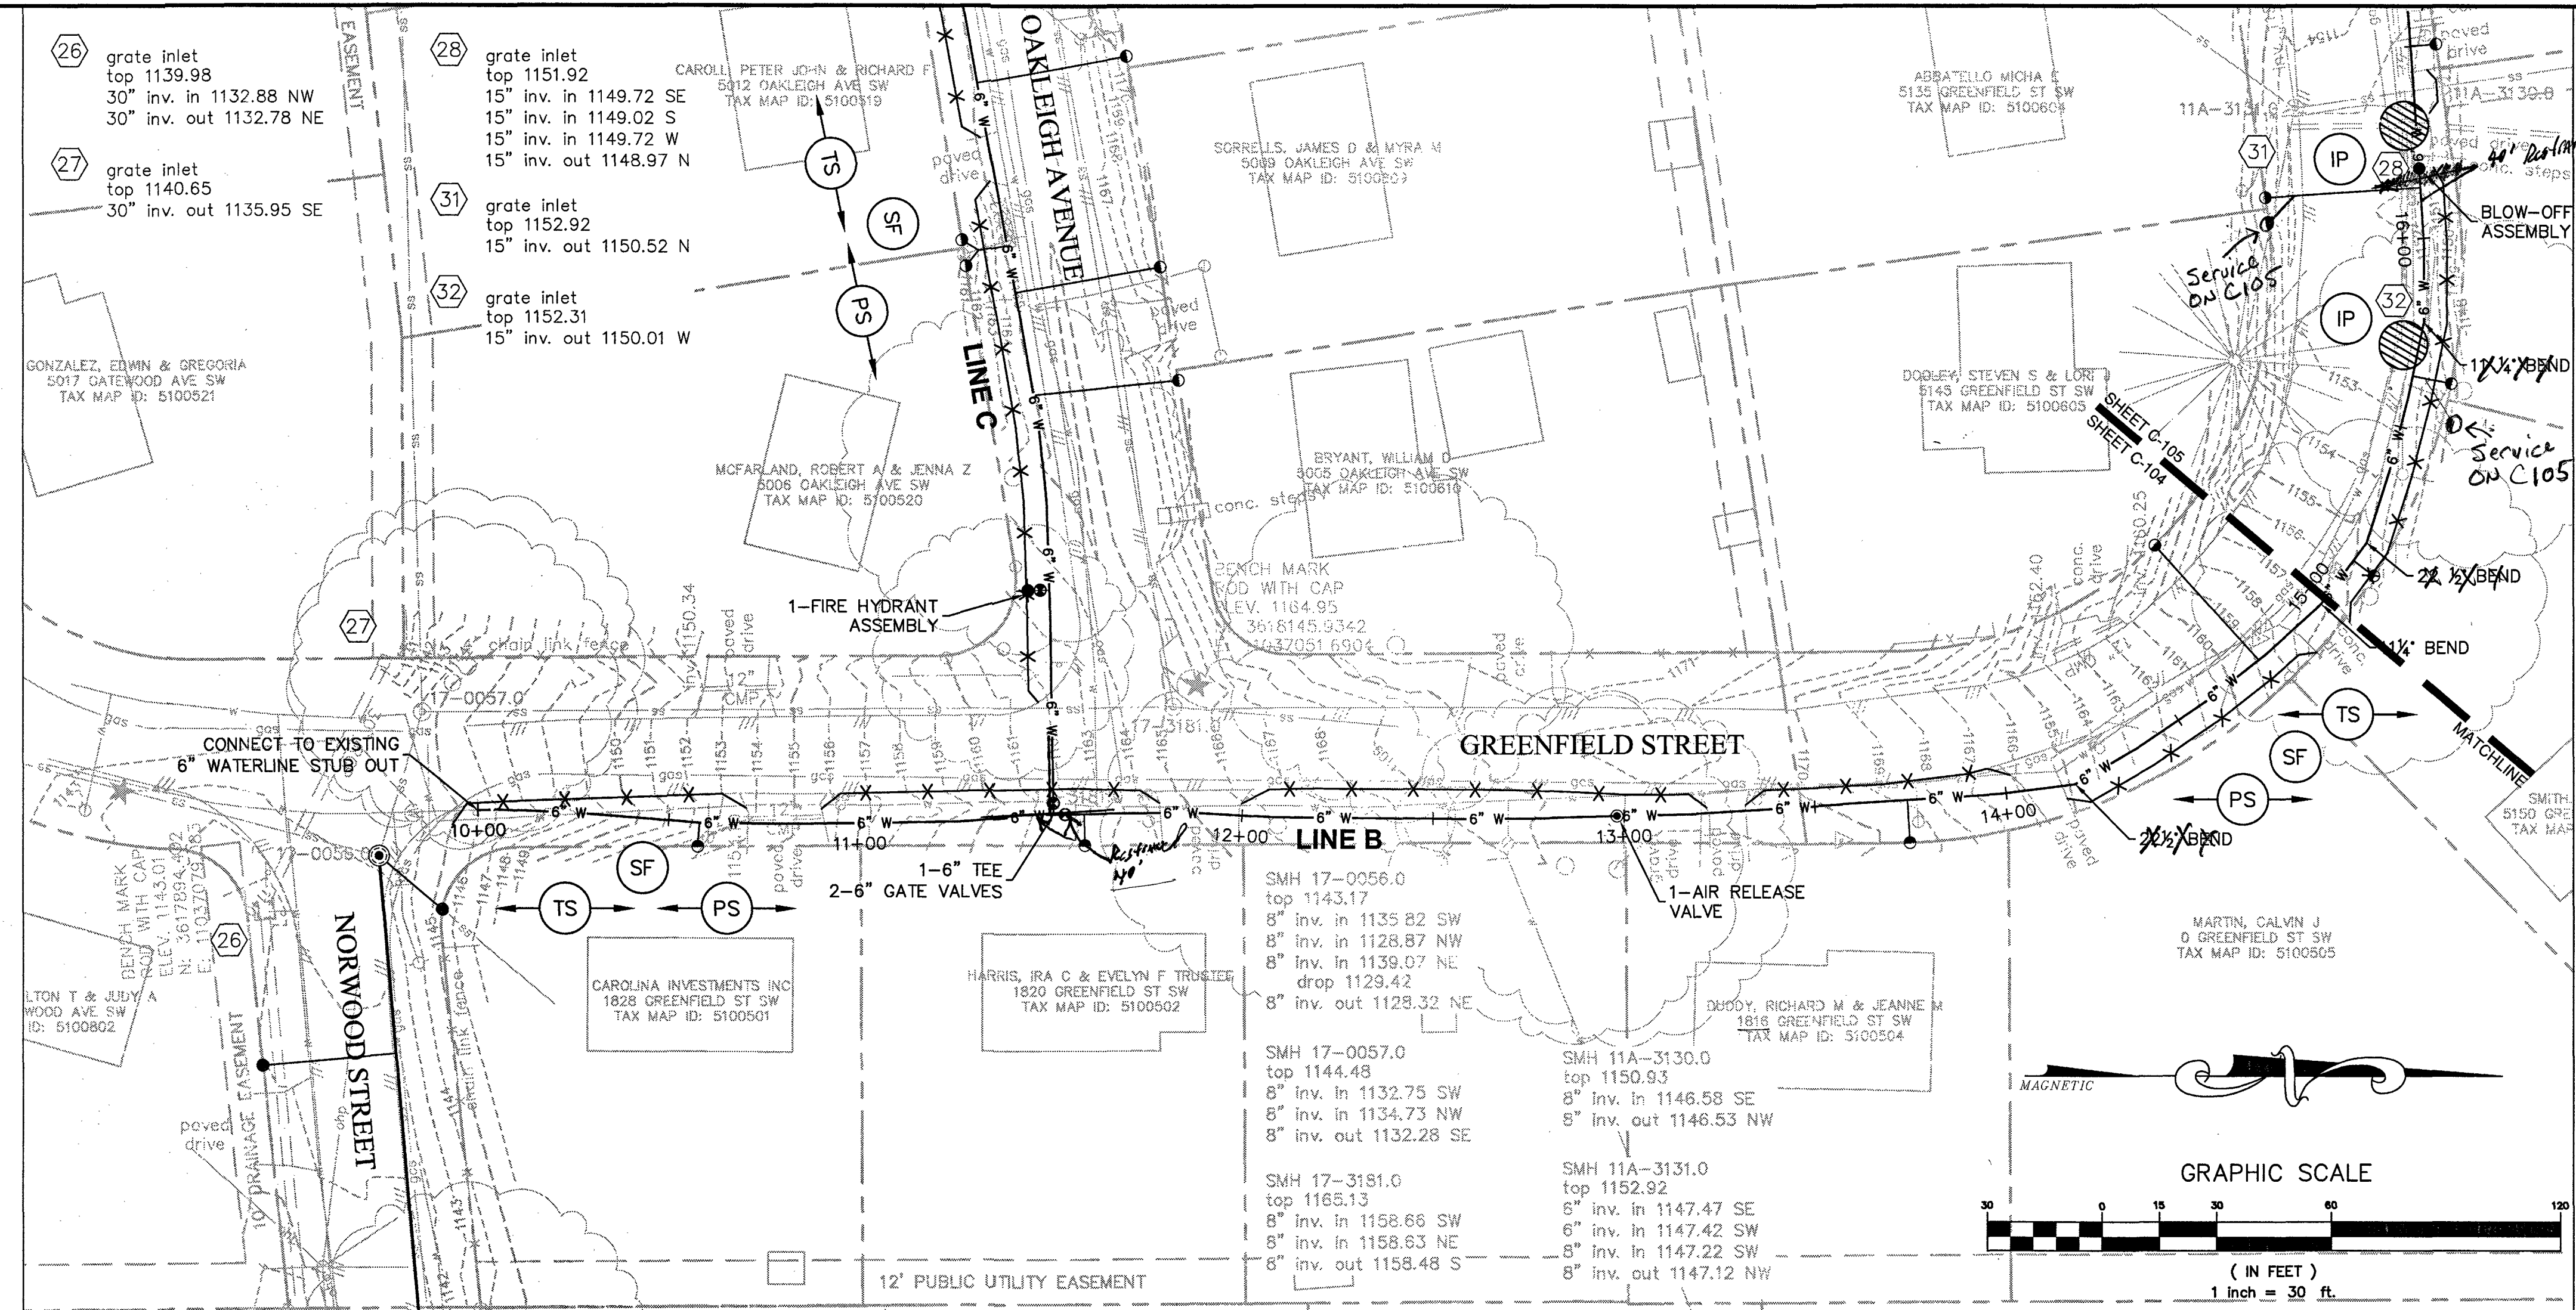


NOTE: CONTRACTOR SHALL LOCATE AND VERIFY EXISTING METER LOCATION PRIOR TO INSTALLING NEW METER BOX. SOME NEW METER LOCATIONS SHOWN ON THE PLANS ARE APPROXIMATE.

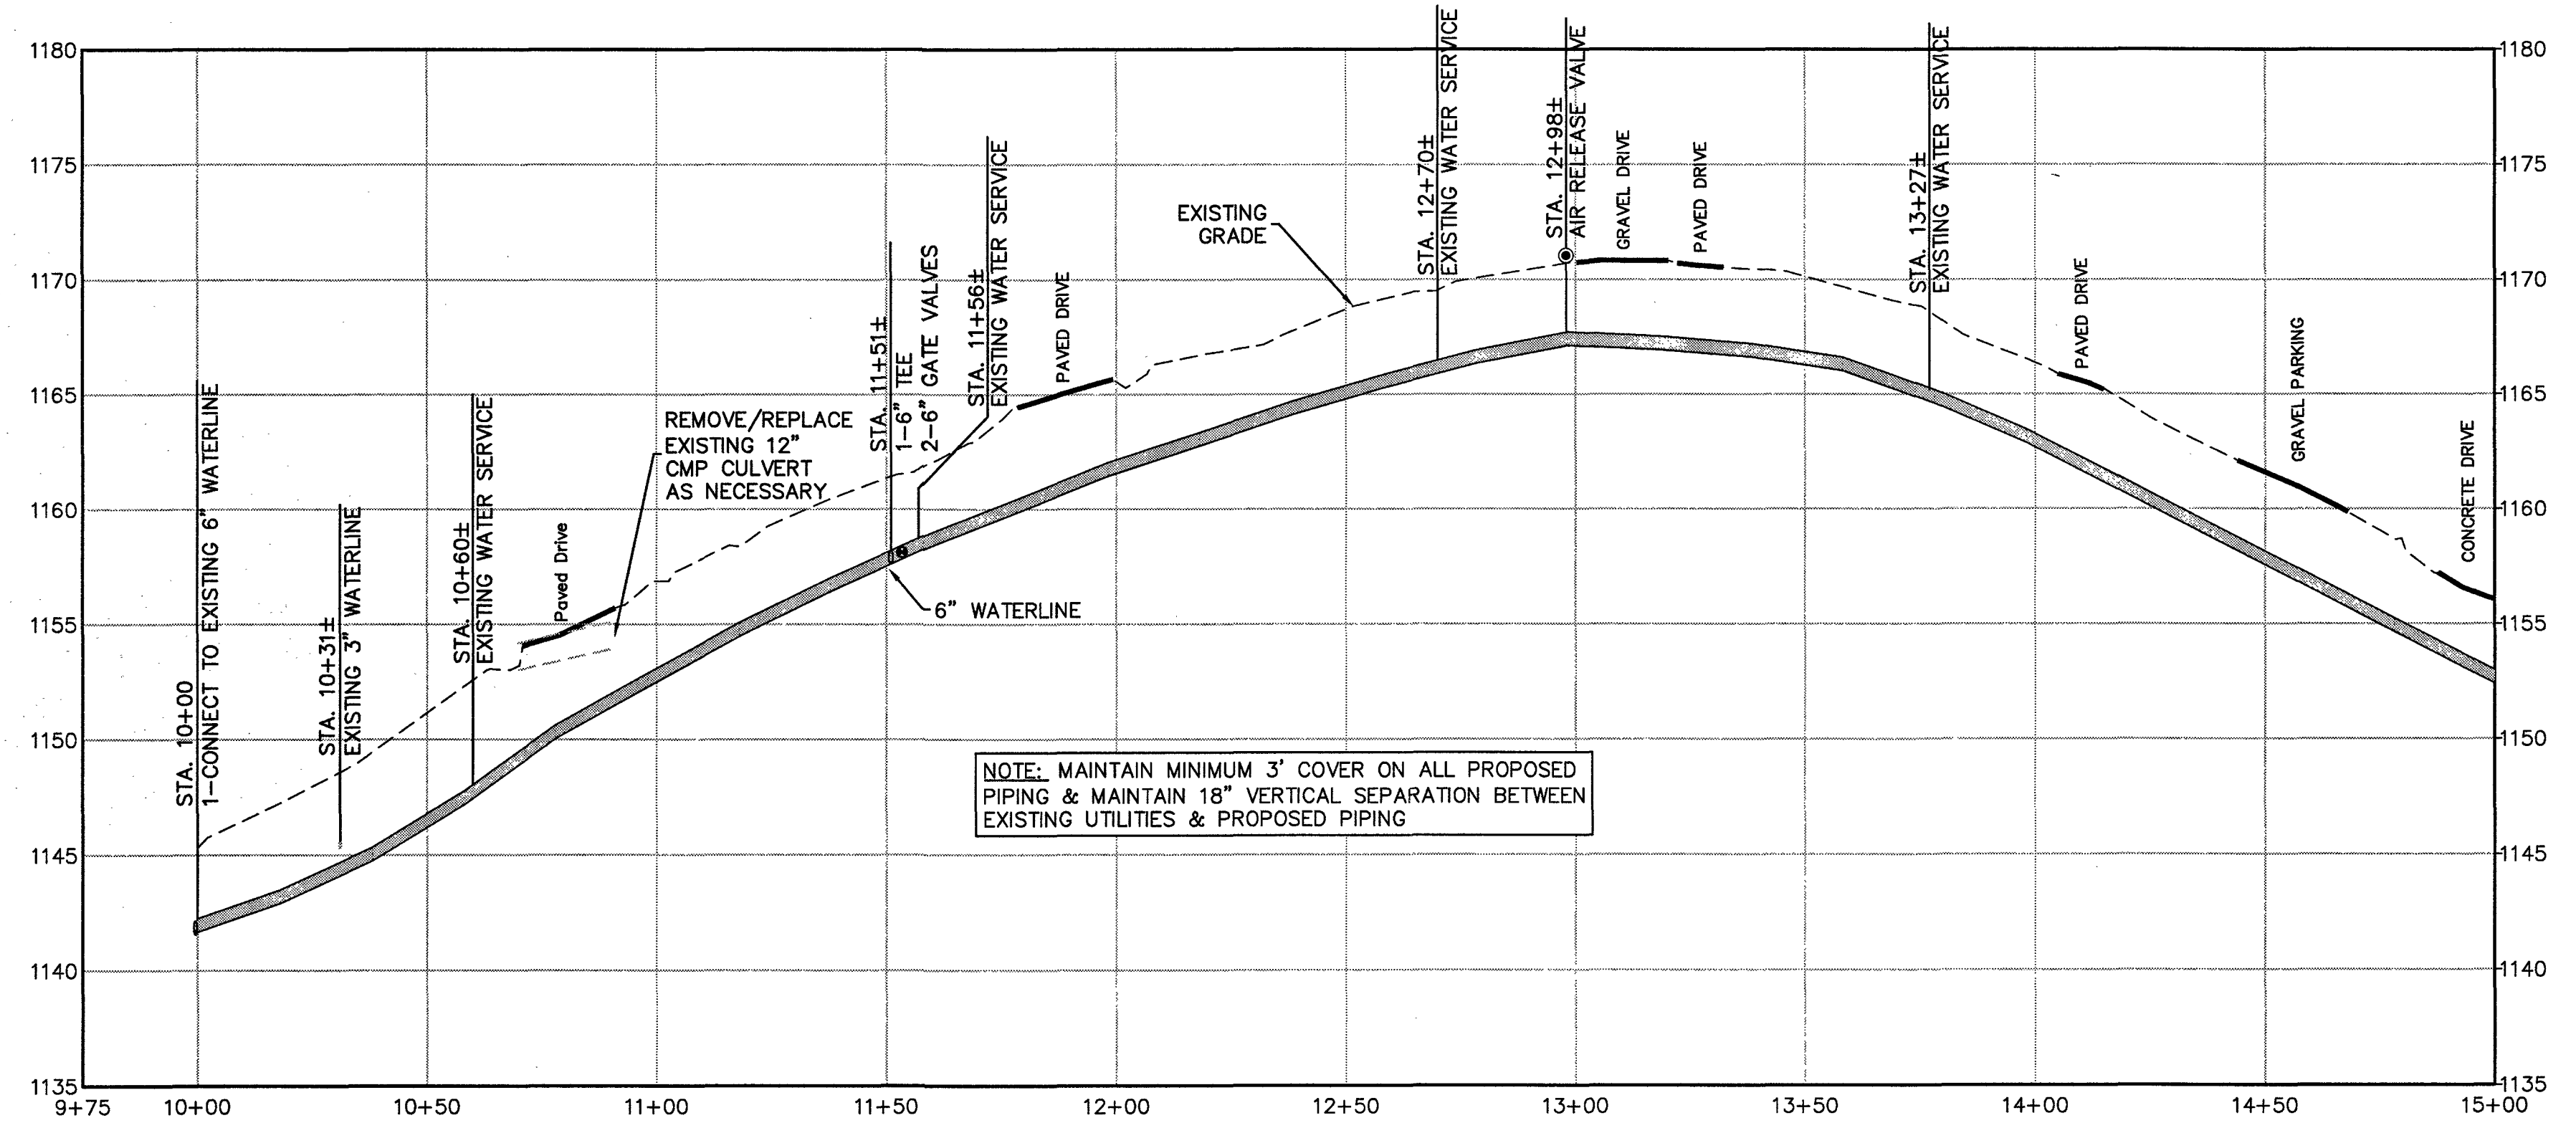

LINE B PROFILE
SCALE: H: 1"=30' V: 1"=6'

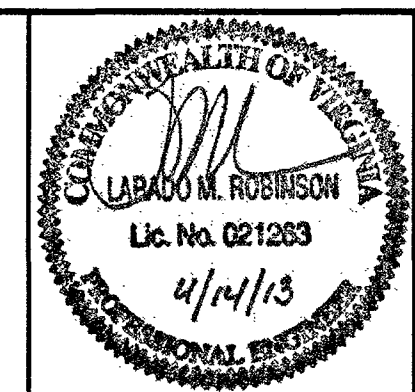

Draper Aden Associates
 Engineering • Surveying • Environmental Services
 2206 South Main Street
 Blacksburg, VA 24060
 540-552-0444 Fax: 540-552-0291

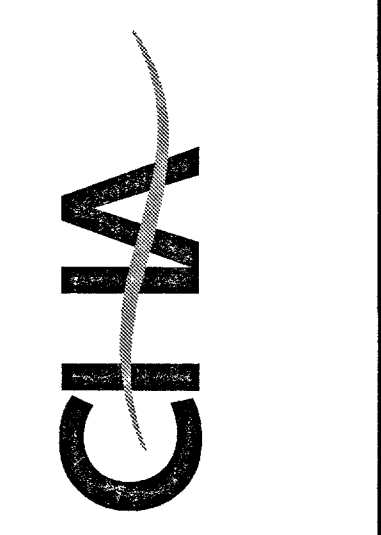

WATER PLAN AND PROFILE - LINE B
 WESTERN VIRGINIA WATER AUTHORITY FY2011
 VCVWRLF COLLECTION SYSTEM PROJECTS
 MURDOCK CREEK WATER AND SEWER REPLACEMENT
 ROANOKE, VIRGINIA

REVISIONS	
DESIGNED BY:	JSL
DRAWN BY:	BMC
CHECKED BY:	LMR
SCALE:	H: 1"=30' V: 1"=6'
DATE:	04/14/13
PROJECT NUMBER:	B11132B-04B/05
C-104	

P:\B11132B\B11132B-04B\B11132B-05_VCVWRLF_COLLECTION_SYSTEM_PROJECTS\DWG\B11132B-05_VCVWRLF_COLLECTION_SYSTEM_PROJECTS_C-104.dwg April 13, 2013 10:40:39 AM