

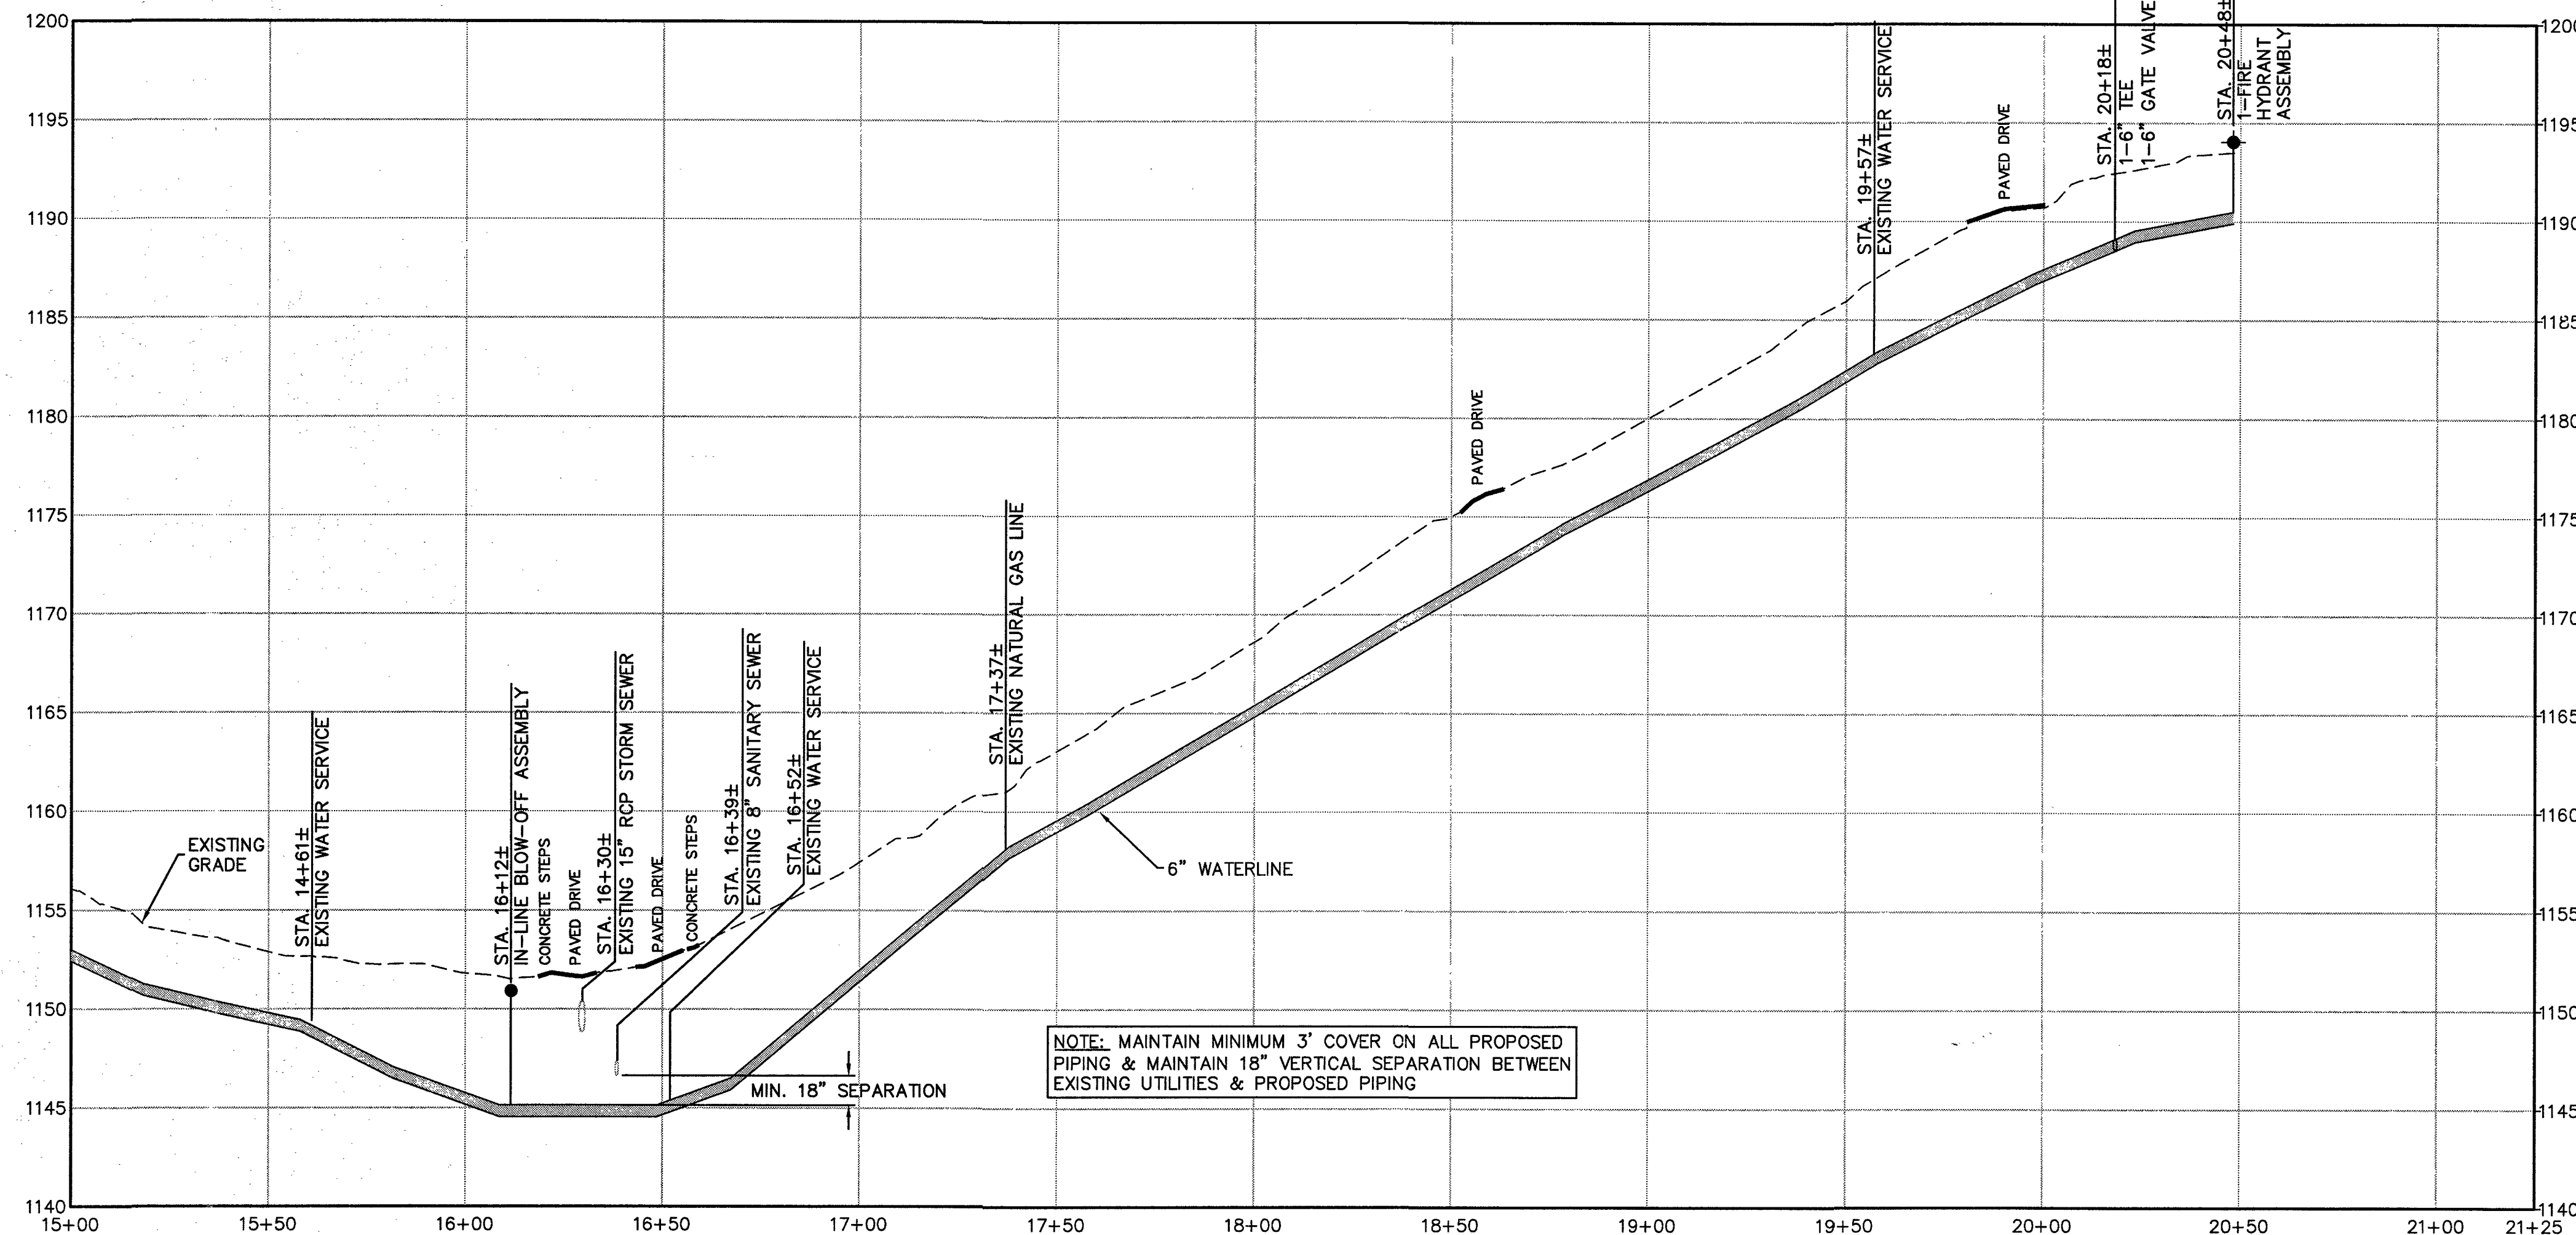


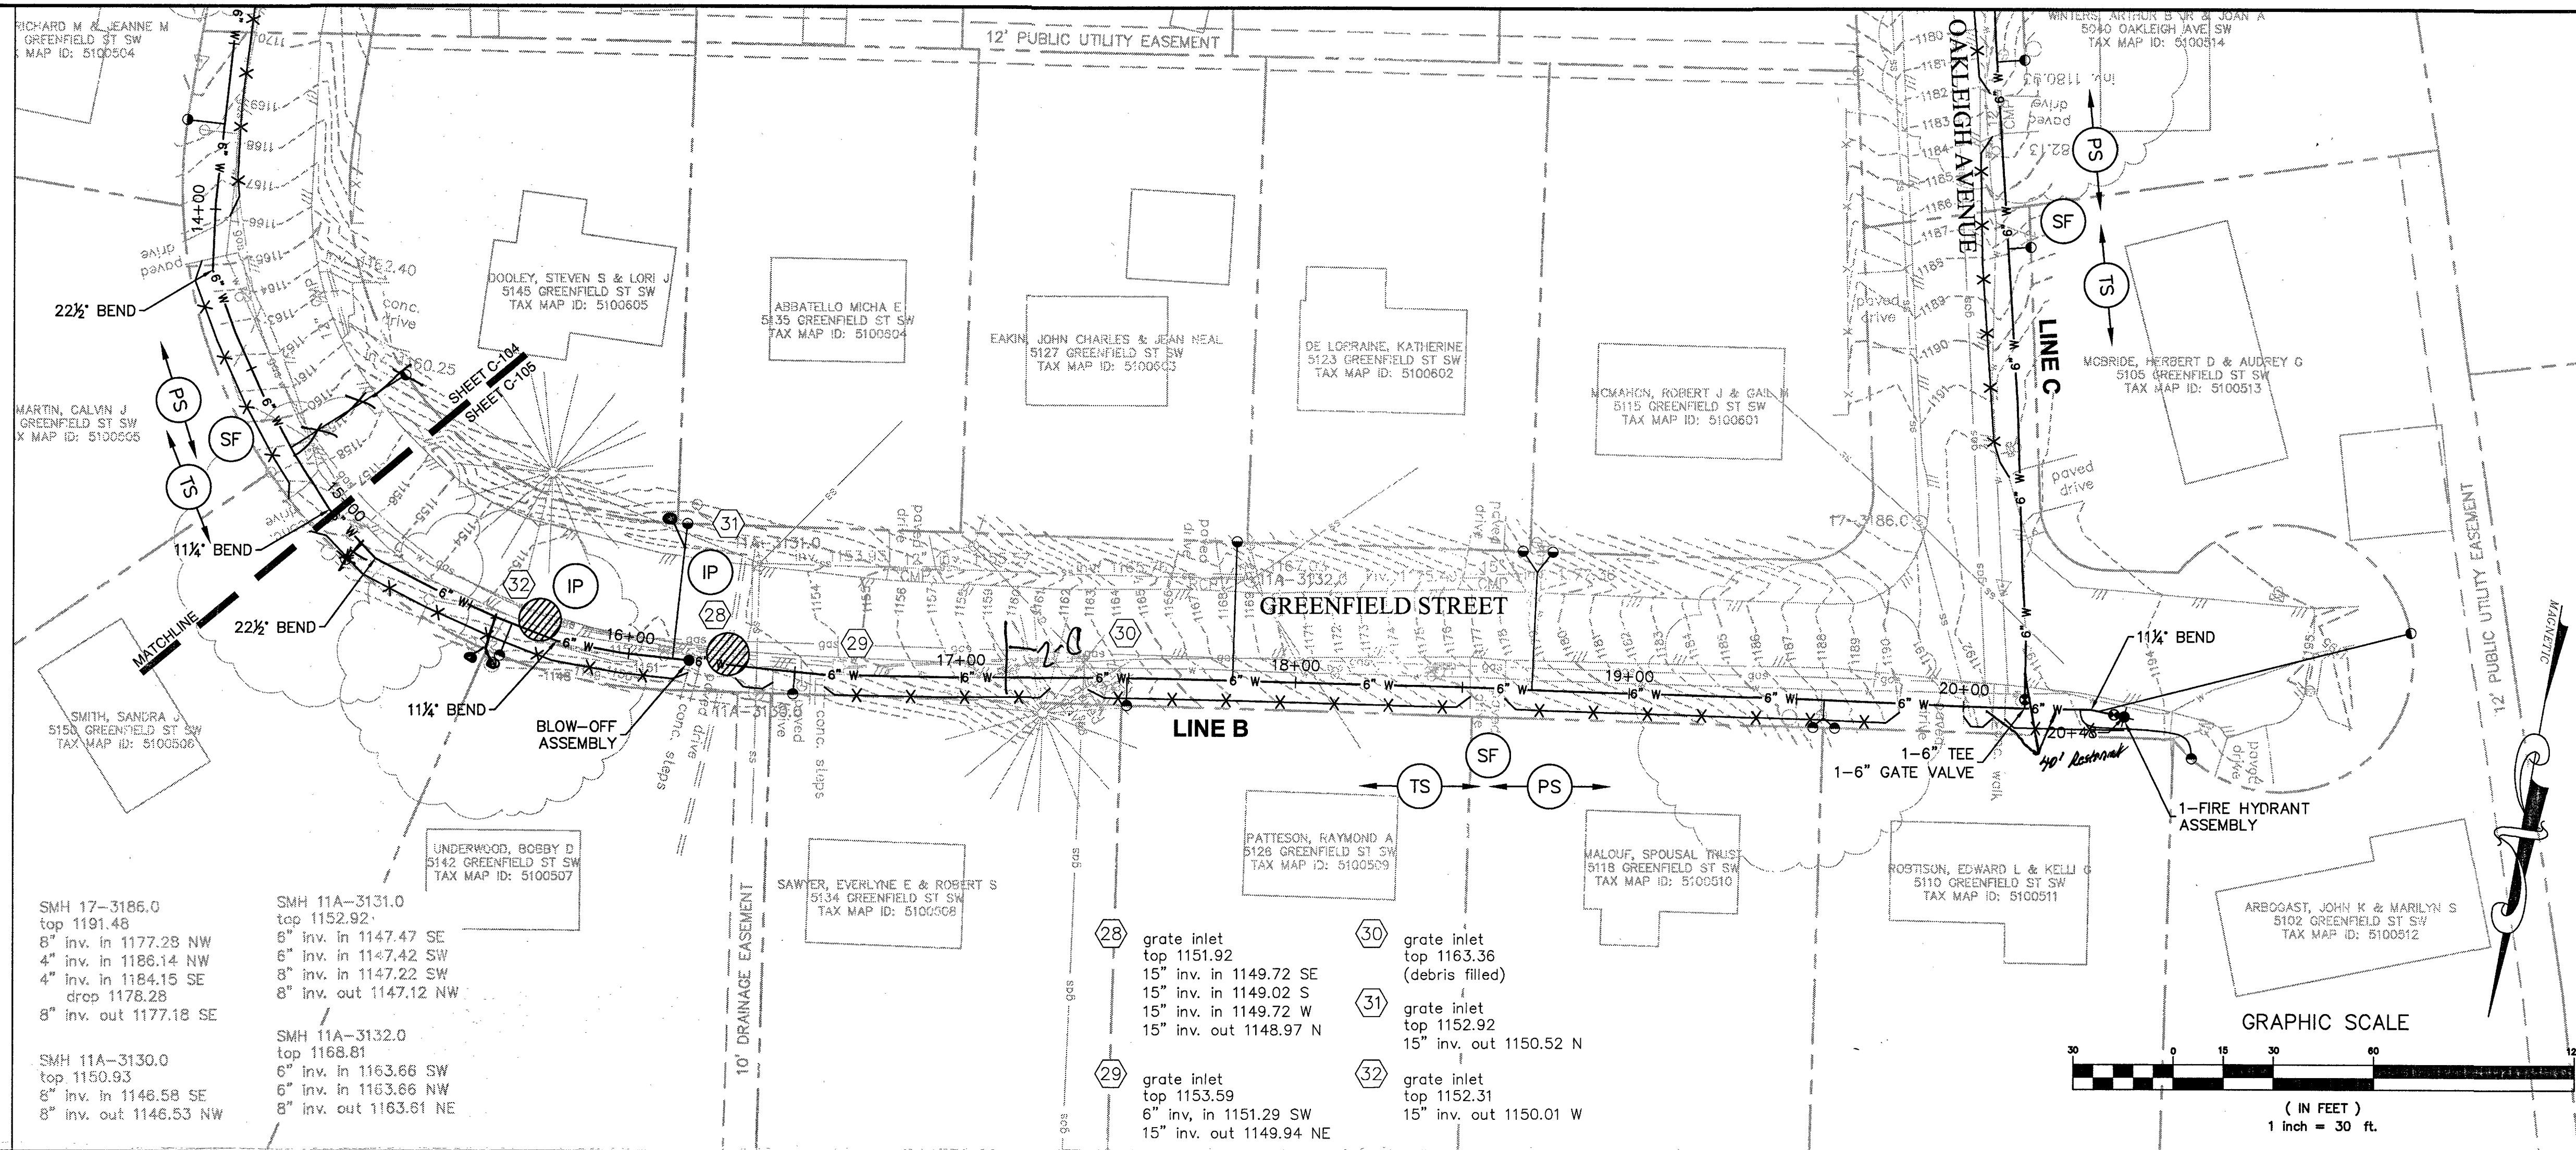

LINE B PROFILE
SCALE: H: 1"=30' V: 1"=6'

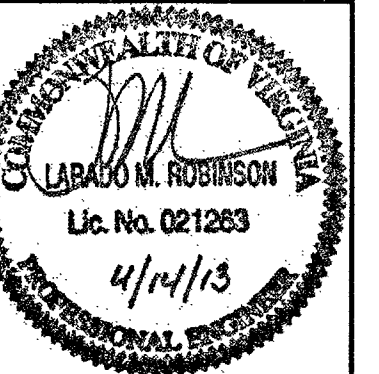

Draper Aden Associates
Engineering • Surveying • Environmental Services
2206 South Main Street
Blacksburg, VA 24060
540-552-0444 Fax: 540-552-0291

WATER PLAN AND PROFILE - LINE B
WESTERN VIRGINIA WATER AUTHORITY FY2011
VCWRLF COLLECTION SYSTEM PROJECTS
MURDOCK CREEK WATER AND SEWER REPLACEMENT
ROANOKE, VIRGINIA

REVISIONS

DESIGNED BY: JSL
DRAWN BY: BMC
CHECKED BY: LMR
SCALE: H: 1"=30' V: 1"=6'
DATE: 04/14/13
PROJECT NUMBER: B11132B-04B/05

C-105