

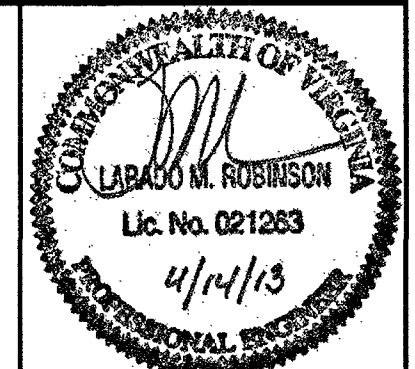


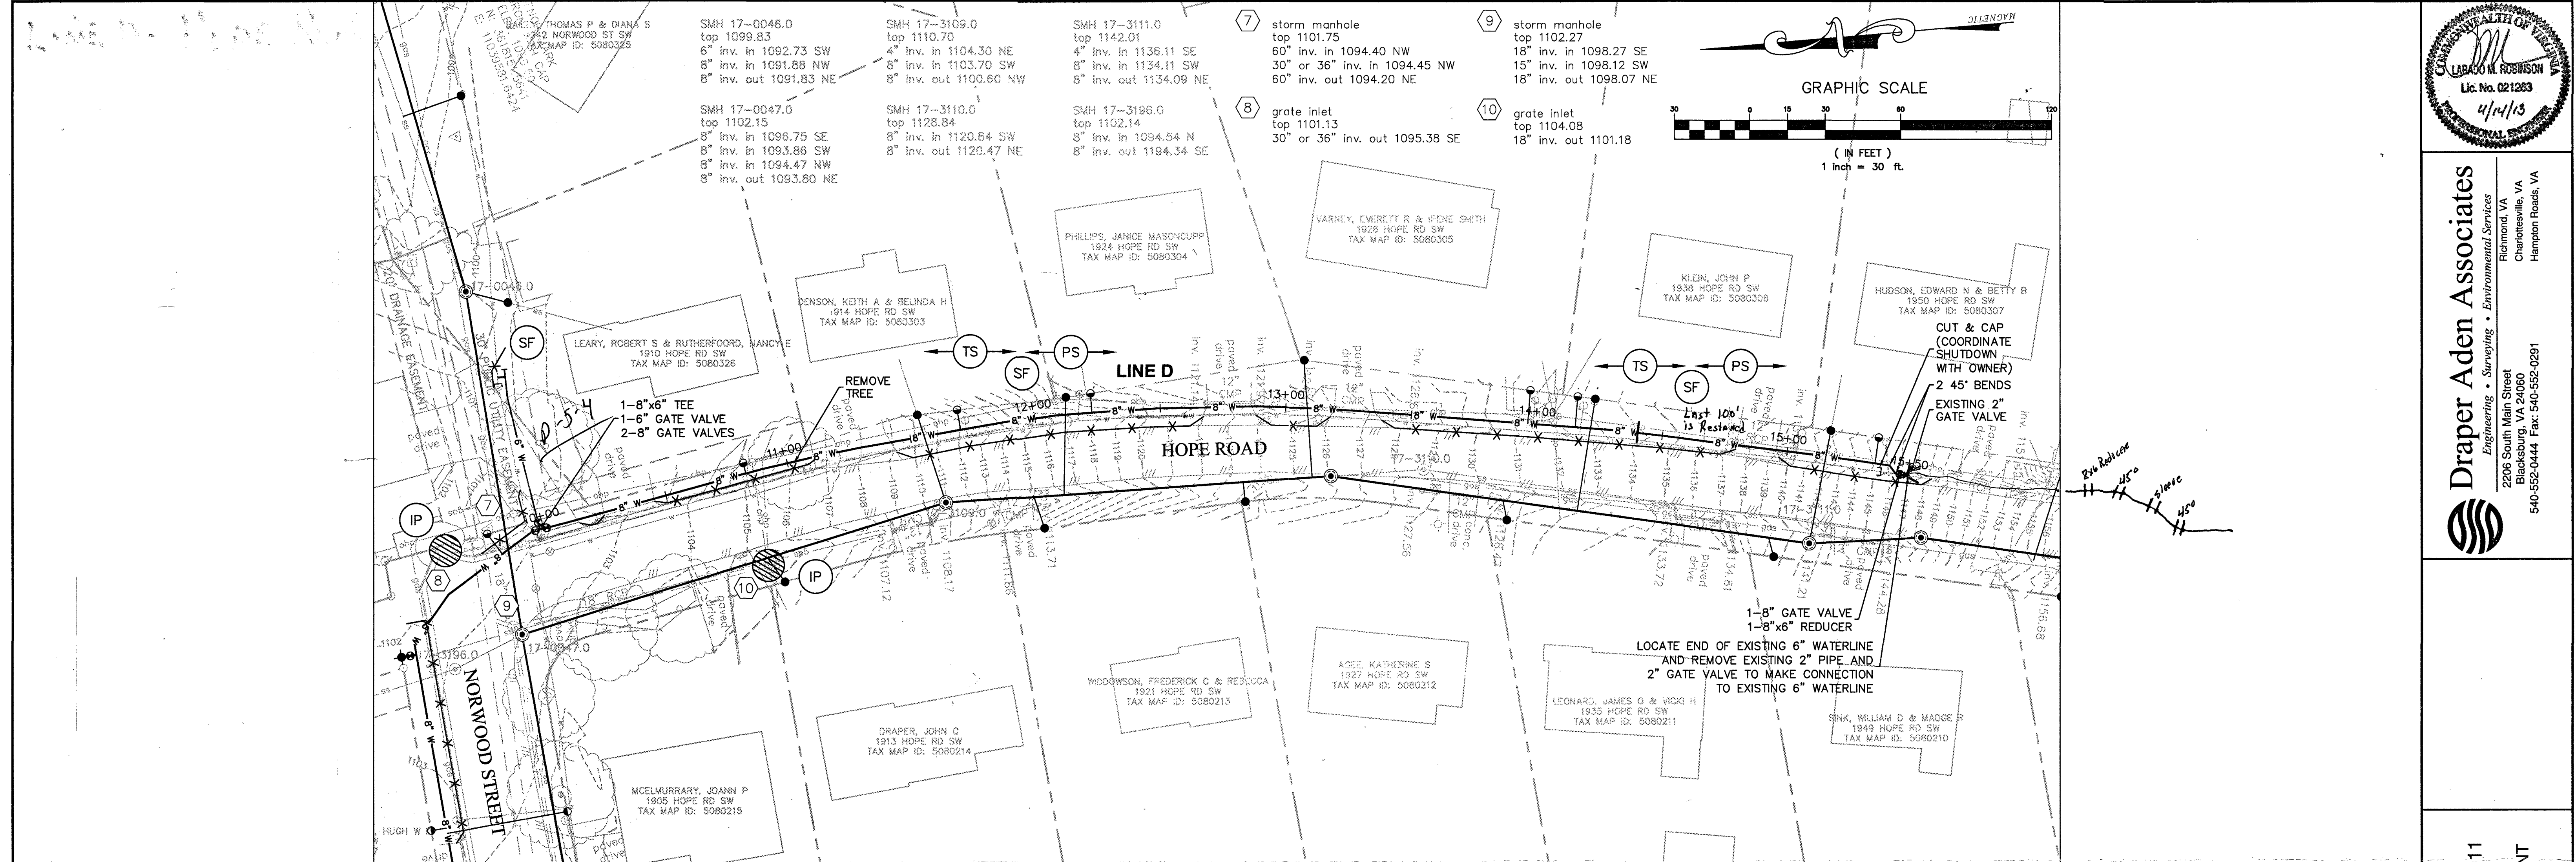

Draper Aden Associates
Engineering • Surveying • Environmental Services
2206 South Main Street
Blacksburg, VA 24060
540-552-0444 Fax: 540-552-0291

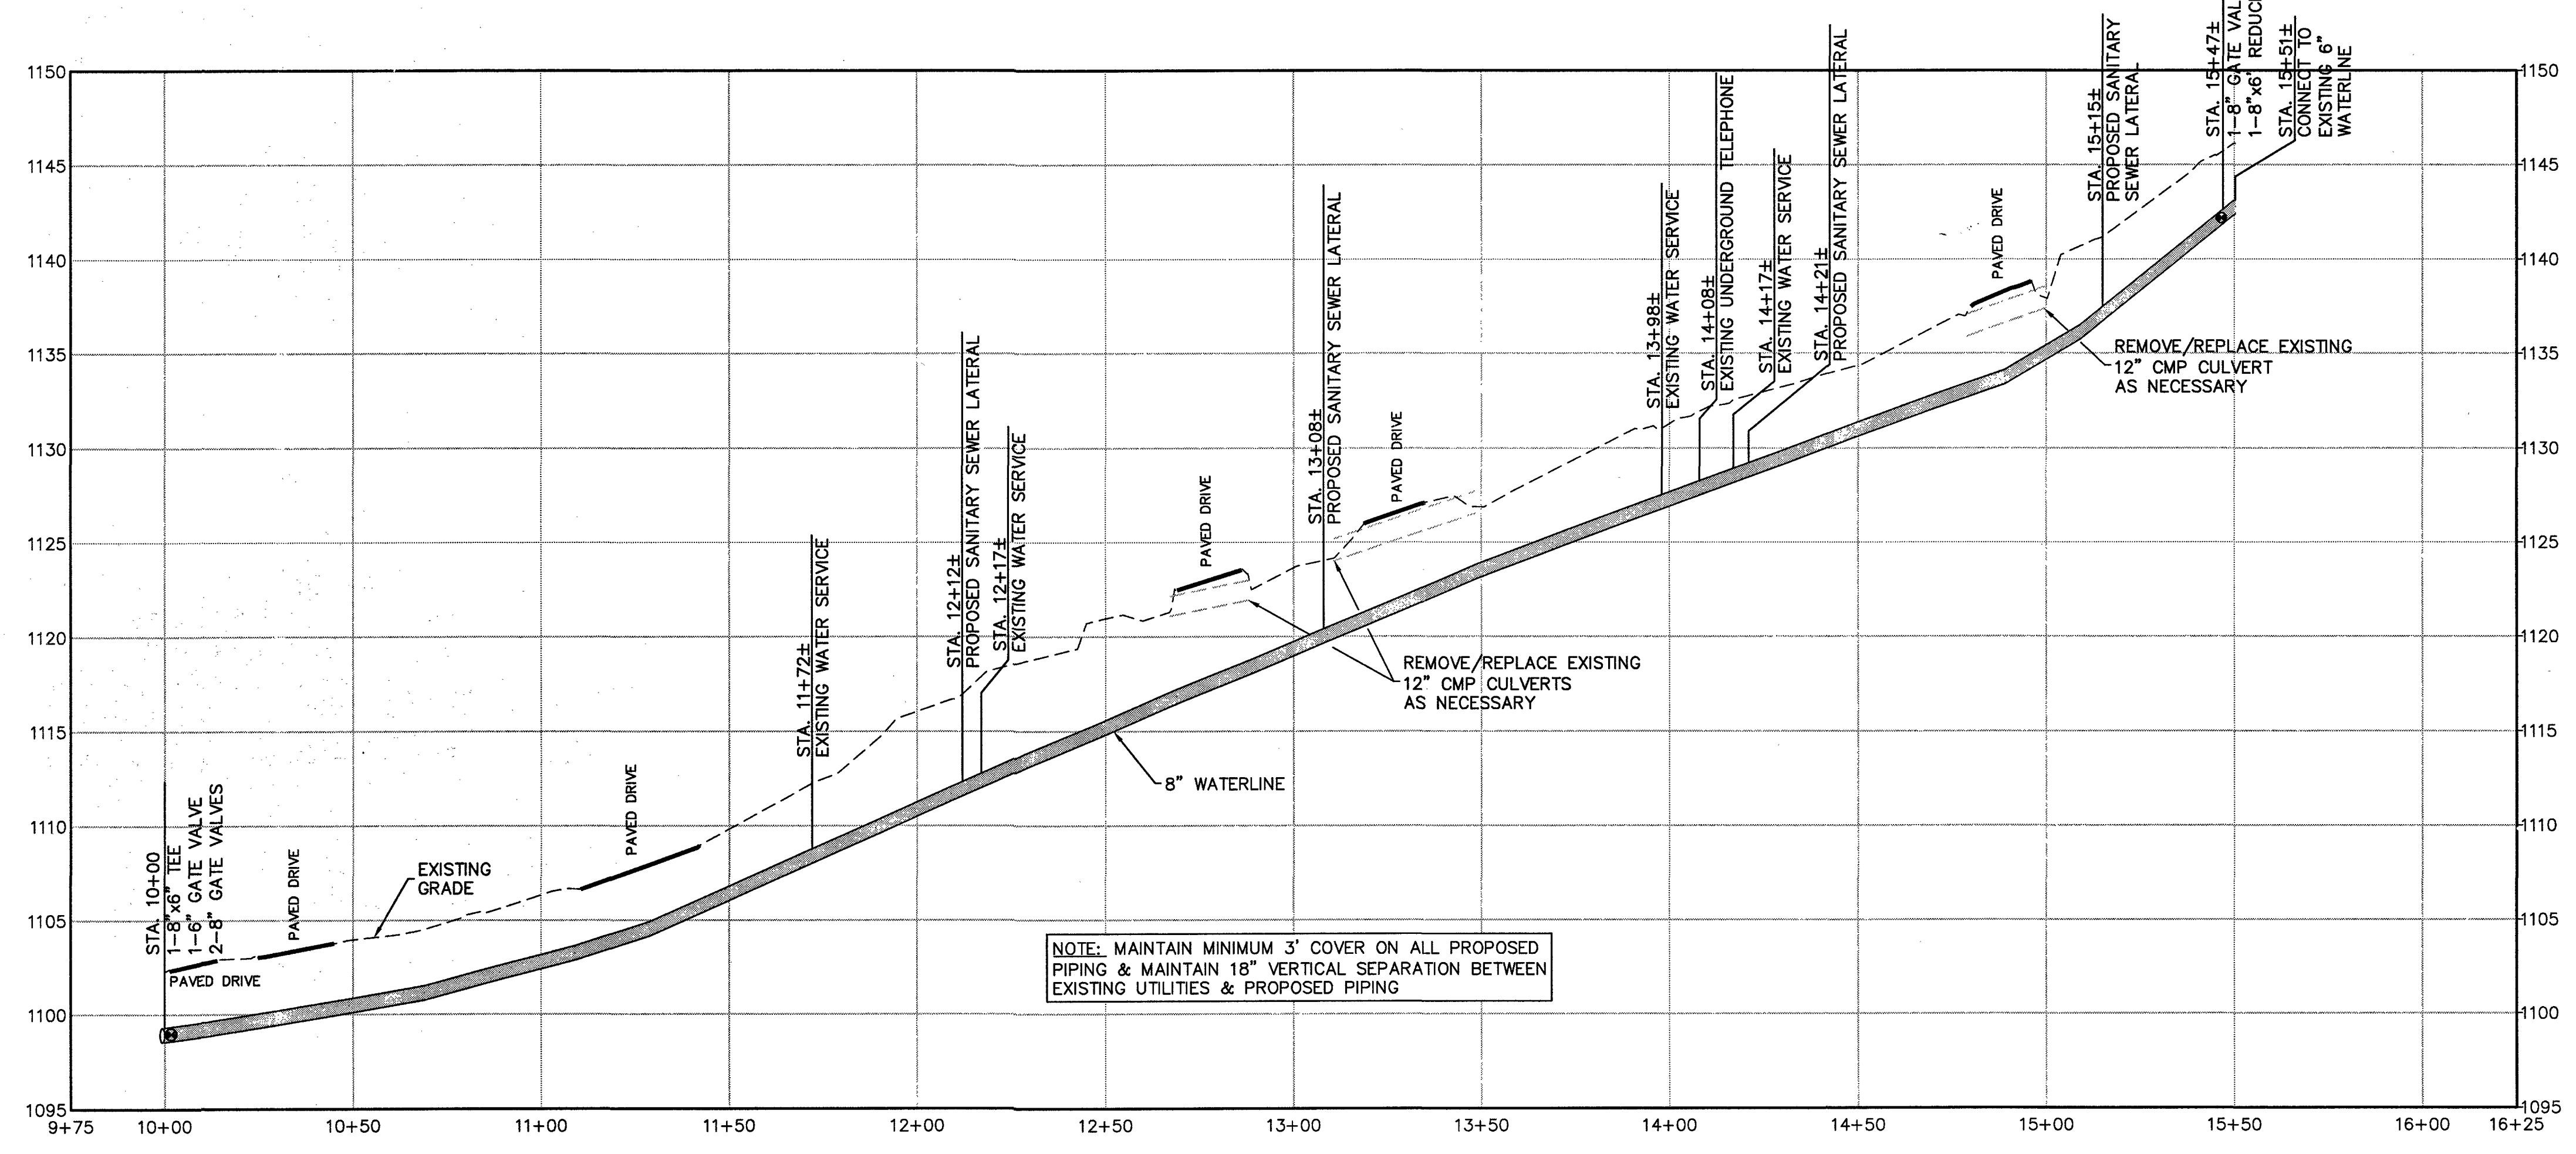

NOTE: CONTRACTOR SHALL LOCATE AND VERIFY EXISTING METER LOCATION PRIOR TO INSTALLING NEW METER BOX. SOME NEW METER LOCATIONS SHOWN ON THE PLANS ARE APPROXIMATE.

LINE D PROFILE
SCALE: H: 1"=30' V: 1"=6'

WATER PLAN AND PROFILE - LINE D
WESTERN VIRGINIA WATER AUTHORITY FY2011
VCWRLF COLLECTION SYSTEM PROJECTS
MURDOCK CREEK WATER AND SEWER REPLACEMENT
ROANOKE, VIRGINIA

REVISIONS	
DESIGNED BY:	JSL
DRAWN BY:	BMC
CHECKED BY:	LMR
SCALE:	H: 1"=30' V: 1"=6'
DATE:	04/14/13
PROJECT NUMBER:	B11132B-04B/05
C-107	