
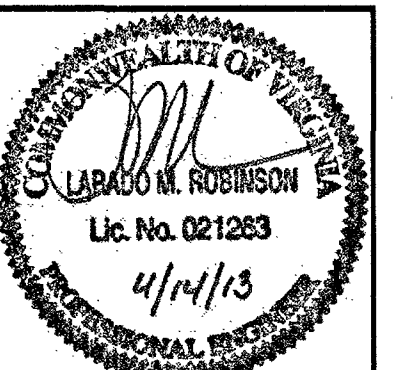
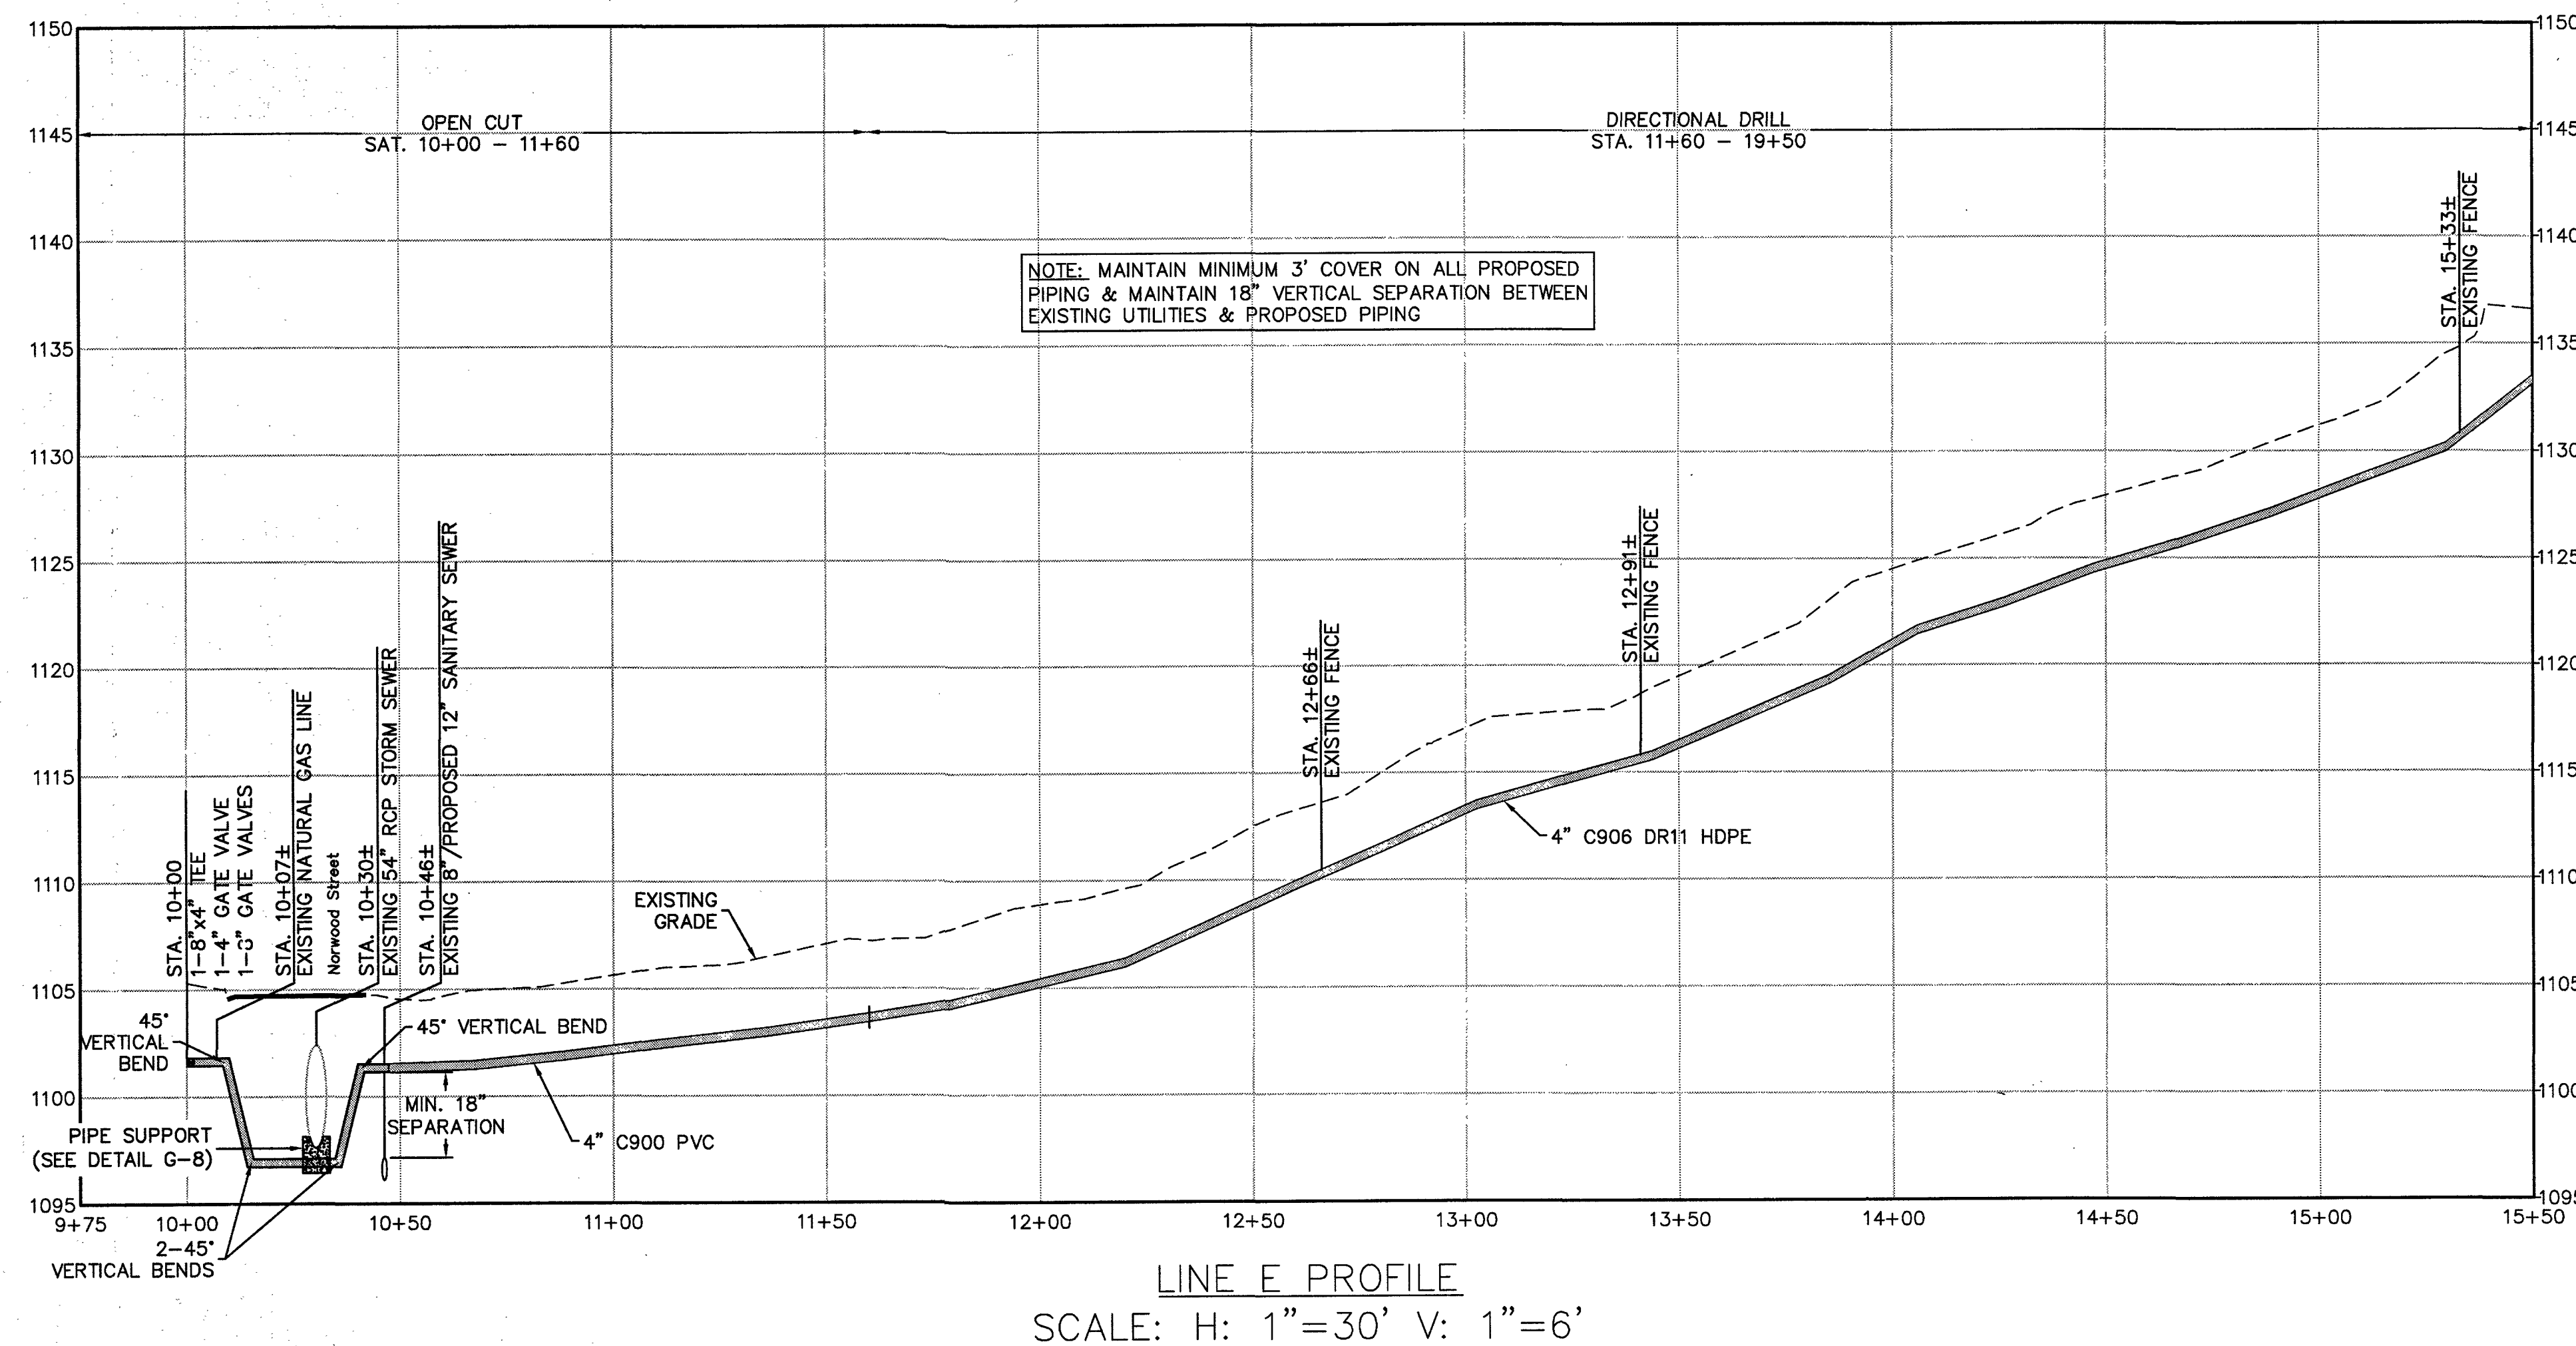


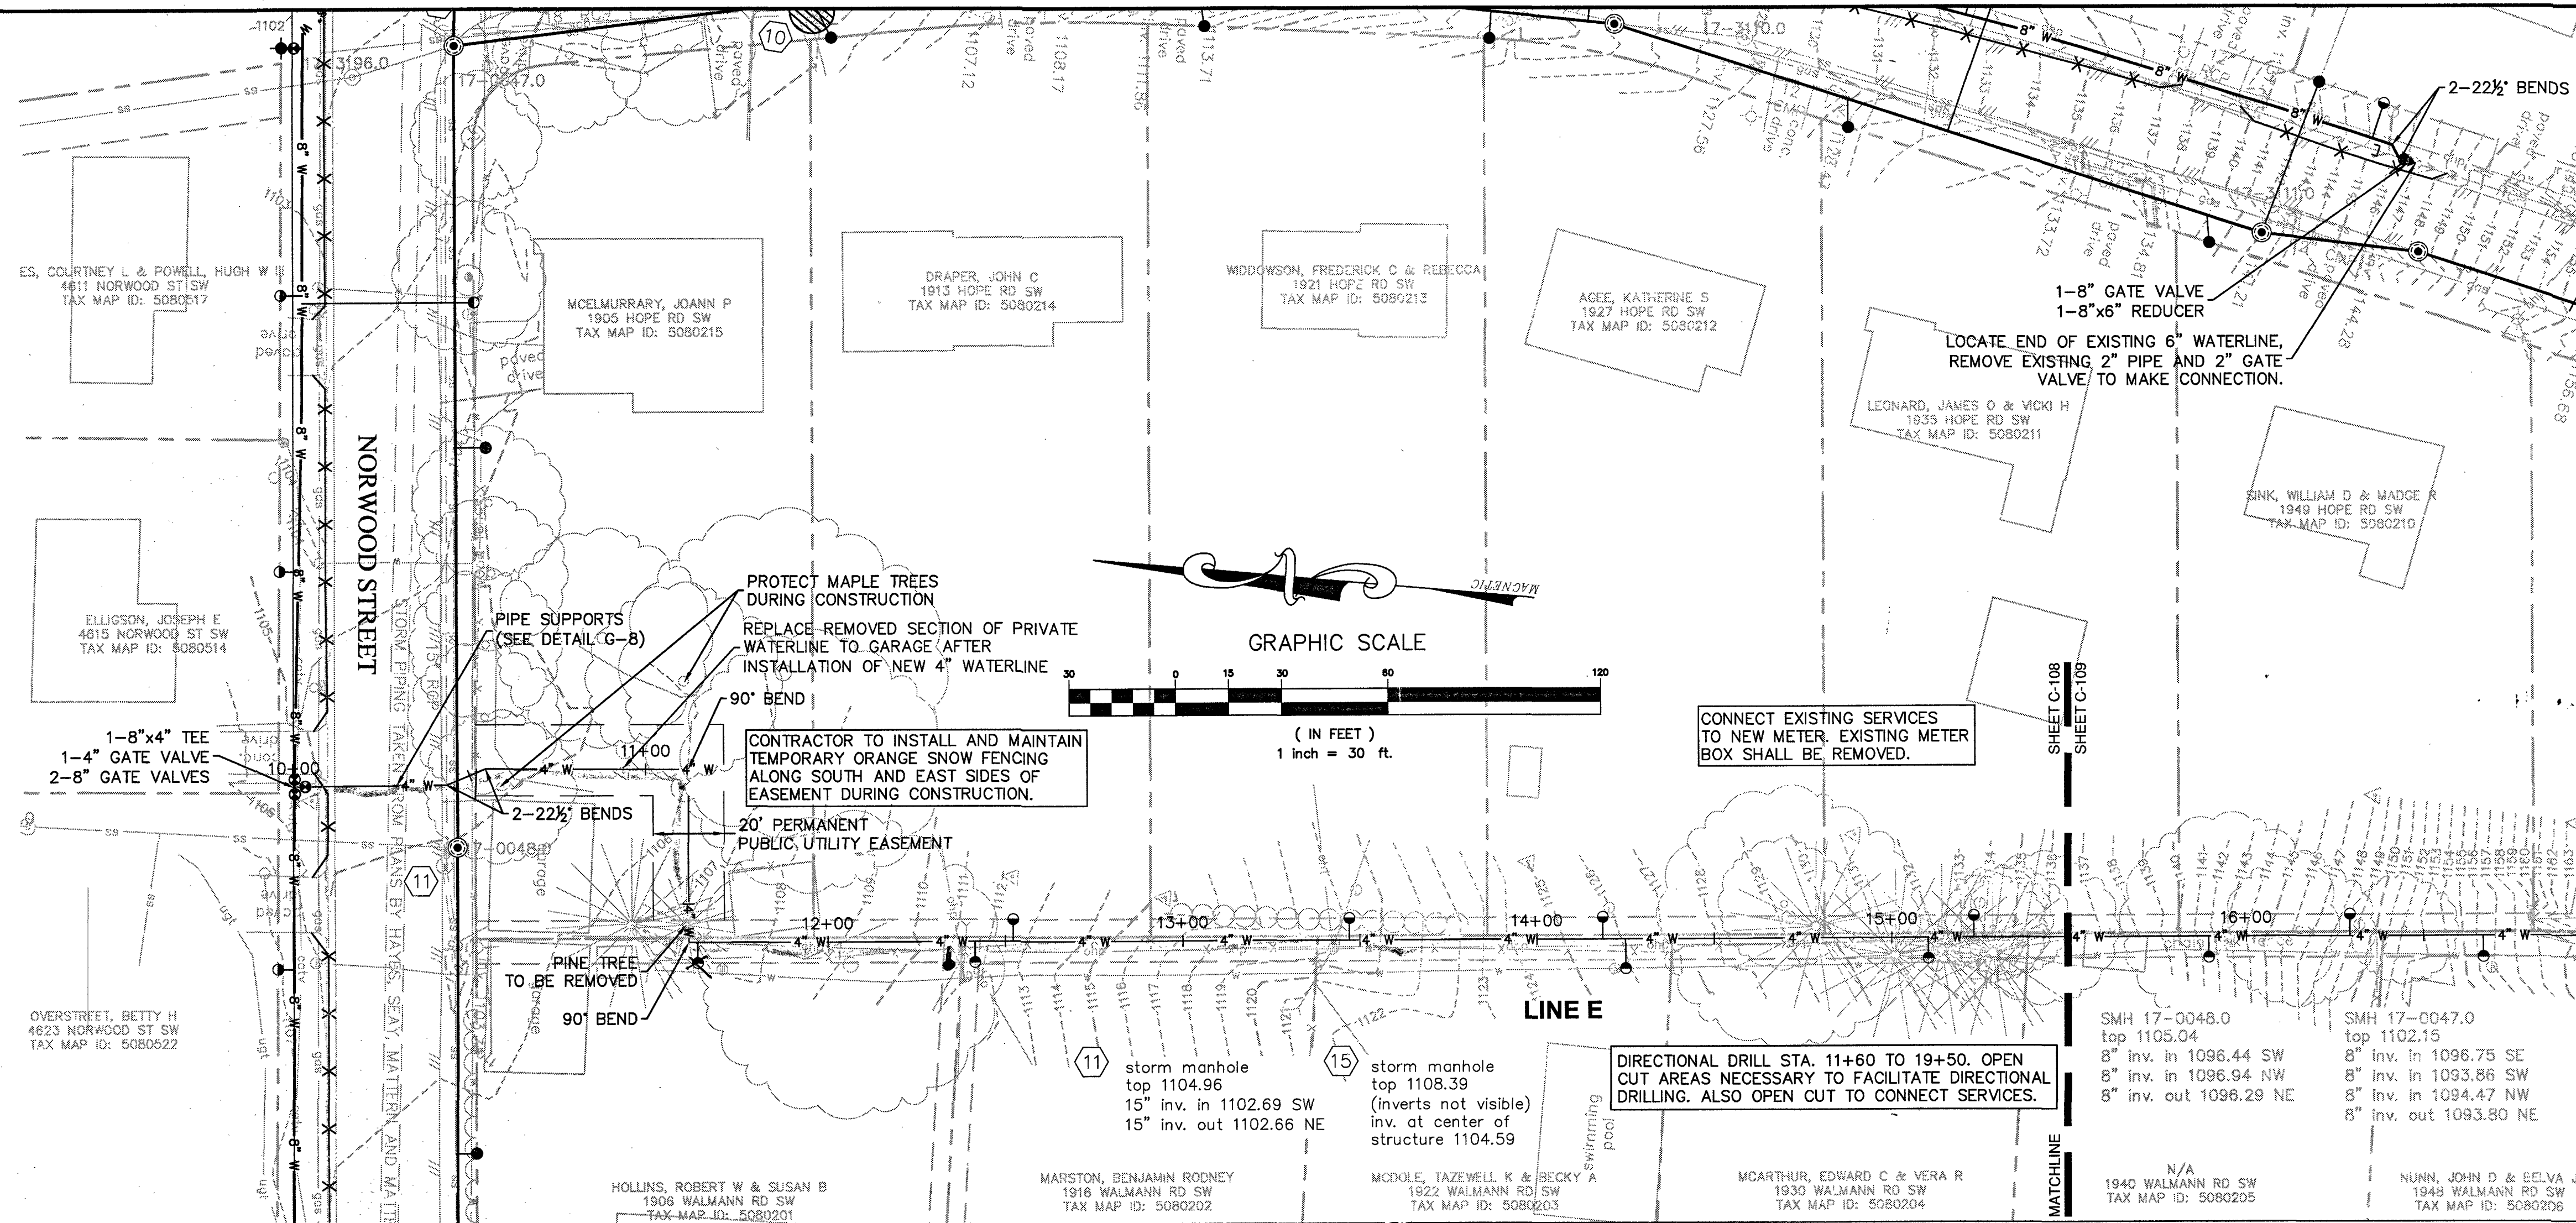

Draper Aden Associates
 Engineering • Surveying • Environmental Services
 2206 South Main Street
 Blacksburg, VA 24060
 540-552-0444 Fax: 540-552-0291
 Richmond, VA
 Charlottesville, VA
 Hampton Roads, VA

WATER PLAN AND PROFILE - LINE E
WESTERN VIRGINIA WATER AUTHORITY FY2011
VCWRLF COLLECTION SYSTEM PROJECTS
MURDOCK CREEK WATER AND SEWER REPLACEMENT
ROANOKE, VIRGINIA

REVISIONS	
DESIGNED BY:	JSL
DRAWN BY:	BMC
CHECKED BY:	LMR
SCALE:	H: 1"=30' V: 1"=6'
DATE:	04/14/13
PROJECT NUMBER:	B11132B-04B/05
C-108	